


**2 upper floor - lighting**  
 SCALE: 1/8" = 1' - 0"

LIGHT FIXTURE SCHEDULE						
TYPE	MANUFACTURER	LAMP TYPE	WATTS	VOLTS	MOUNTING	DESCRIPTION
A	LOUIS POULSEN NYP-471-WHITE/TR-NYP-12-2-WHT	100MH	130	277	POLE	SITE LIGHTING
B	HYDRELL 9100-MHT75/SPOT-XLT	175MH	175	277	GROUND	TREE UPLIGHT CAST IN CONCRETE, COLLAR - WHITE
C	LOUIS POULSEN NYHWAL, NYB-247-WHITE	100MH	100	277	BOLLARD	BOLLARD
D	BELFER 3435-WH-SBRL-13	131T/35	130	277	RECESSED	STEP LIGHT WITH BATTERY BACK-UP
E	HP-TR-7 B2P-12-11-CP-SE	100W	100	277	RECESSED	AQUADUCT LIGHT
F	EDISON PRICE TRP-42/B-120-COL-WF	42T/35	50	277	RECESSED	DOWNLIGHT
G	LOUIS POULSEN TRP-42/B-120-COL-WF-EM	42T/35	50	277	RECESSED	SAME WITH EMERGENCY BATTERY
H	KIRLIN RR80929-58	32T/35	80	277	RECESSED	CONCRETE POUR DOWNLIGHT
I	LUMINAIRE LVP-524-232-OCT-LA-277	F32T8/35	70	277	SURFACE	VANDAL RESISTANT WALL
J	LUMINAIRE LVP-524-232-OCT-LA-EMB-277	F32T8/35	70	277	SURFACE	SAME WITH EMERGENCY BATTERY

K	FINELITE SS-XX-278-SC-91W-277-ACXAFE	F32T8/35	70	277	PENDANT	INDIRECT/DIRECT FLUORESCENT
L	FINELITE SS-XX-278-SC-91W-277-ACXAFE		70	277	PENDANT	SAME WITH BATTERY BACK-UP
M	HE WILLIAM 76-4-232-E277	F32T8/35	70	277	SURFACE	FLUORESCENT STRIP
N	LOUIS POULSEN NYP-MAX-459-100MMHL	100MH	130	277	PENDANT	PAVILLION (ALT #4)
P	STERNER ARS-RT-19-250MH-3-MT-BK-HS STERNER POLE SSS-20-4-11-10-BK	250HPS	310	277	POLE	SITE LIGHTING POLE FIXTURE (ALT #3)
Q	KIRLIN RR80929-45-FT	32T/35	80	277	RECESSED	SHOWER (N CONCRETE)
R	HUBBELL EVR-3-100MH-MT-GR-A/EVR4181GR	1000MH	130	277	POLE	TENNIS COURT POLES/FIXTURES (ALT #5)
S	HYDRELL 818-362-9465	PAR 56	500	120	RECESSED	UNDER WATER
X	HUBBELL X3B SERIES (RED)					EXIT SIGN (POWERLESS)

NOTE: CROSS HATCHED FIXTURES DENOTE EMERGENCY LIGHTS. PROVIDE FIXTURE WITH 90-MINUTE BATTERY BACK-UP.

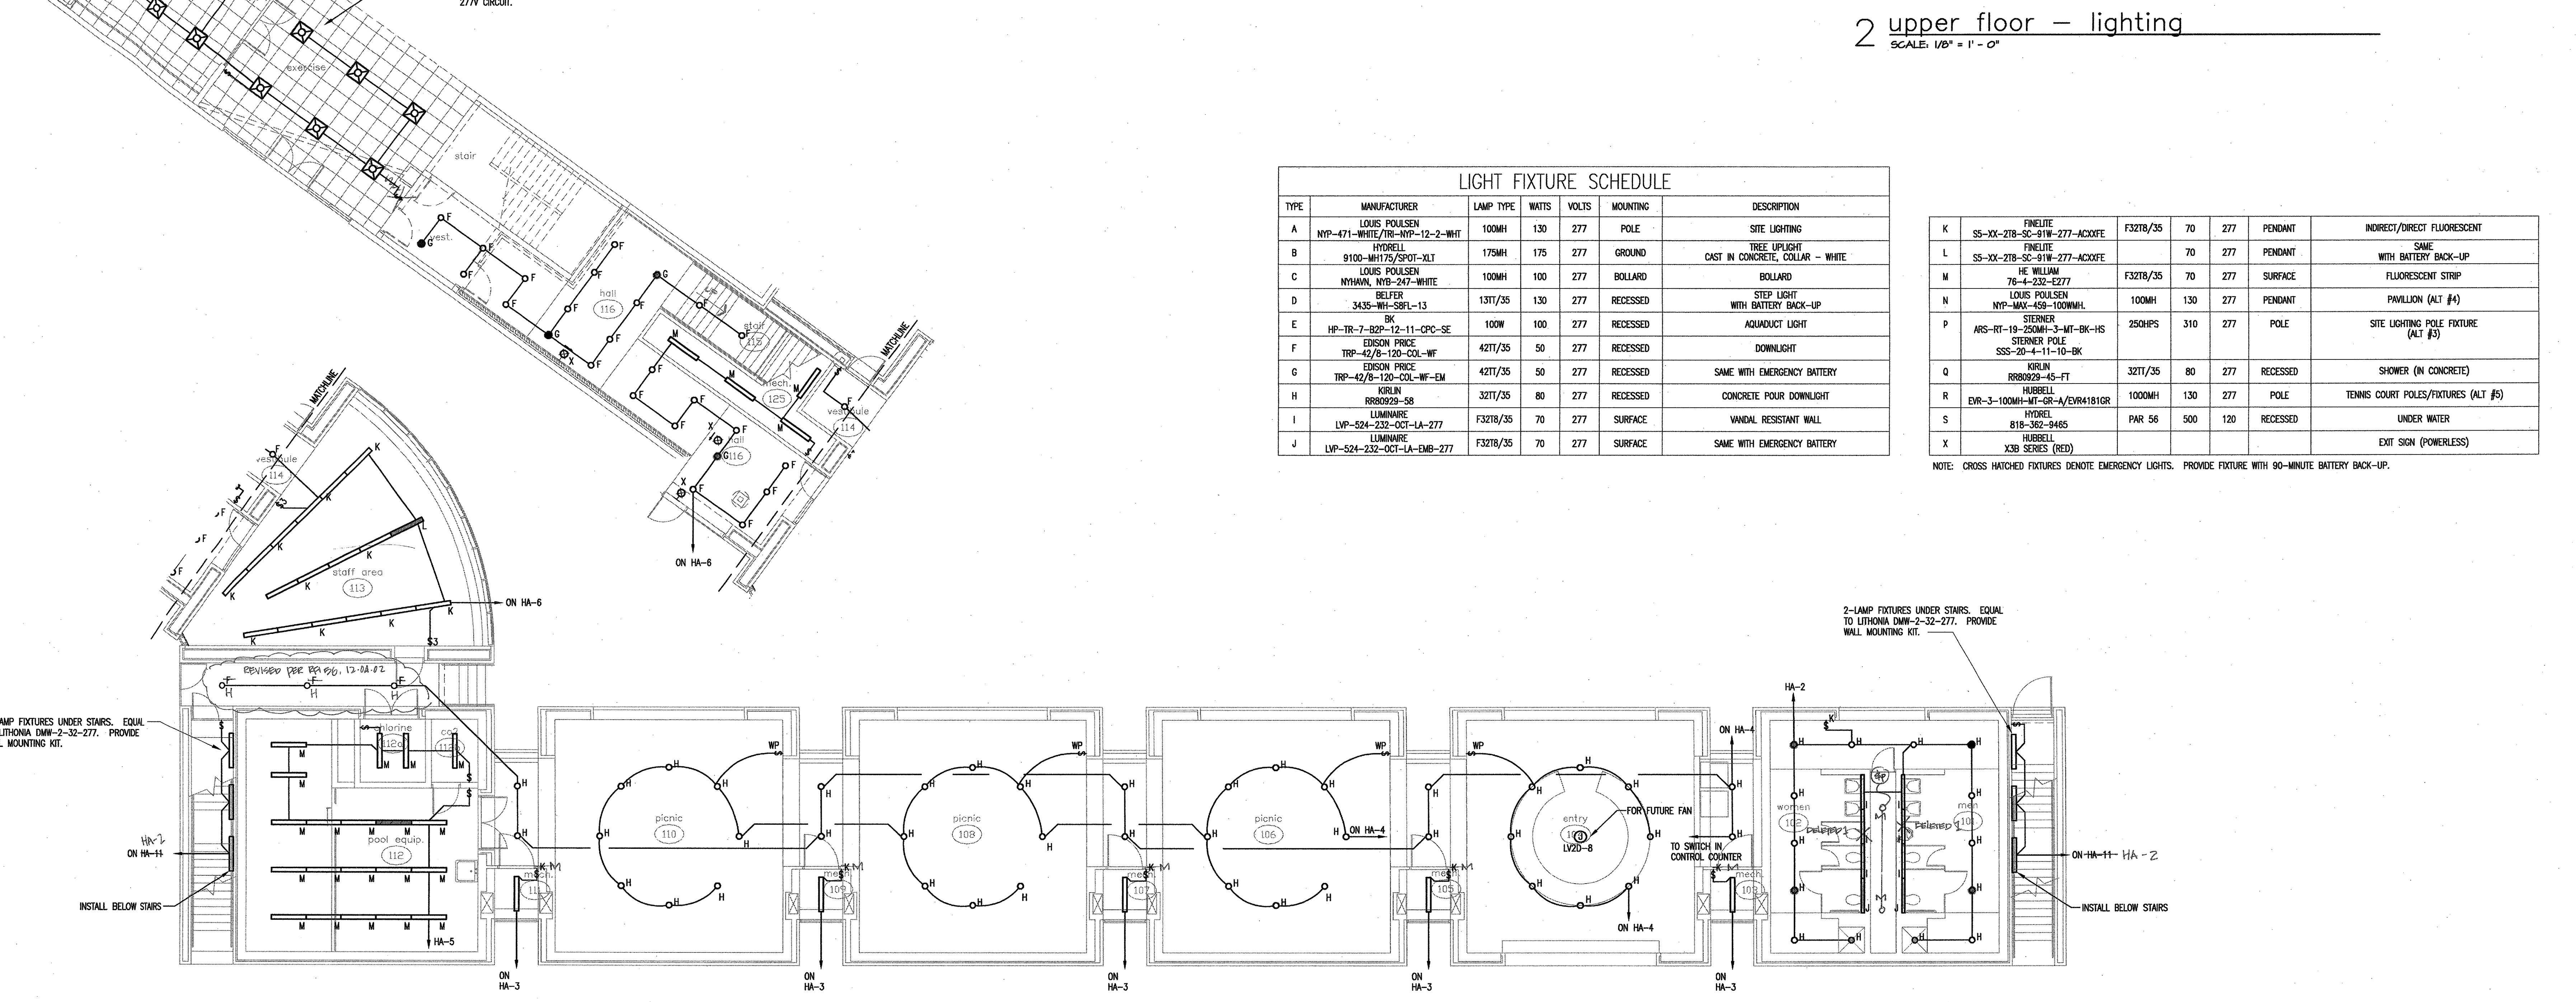

**1 lower floor - lighting**  
 SCALE: 1/8" = 1' - 0"