



**ADDISON ATHLETIC CLUB EXPANSION
 AND
 LEISURE POOL**
 ADDISON, TEXAS

RON HOBBS ARCHITECTS
 614 W. MAIN ST. SUITE #200 GARLAND, TEXAS 75040
 (972) 994-0174 FAX (972) 494-0722


Heif Associates, Inc.
 ENGINEERS ARCHITECTS PLANNERS
 1000 WEST BROADWAY SUITE 2000
 DALLAS, TEXAS 75202
 (214) 750-1000
 FAX (214) 750-1008

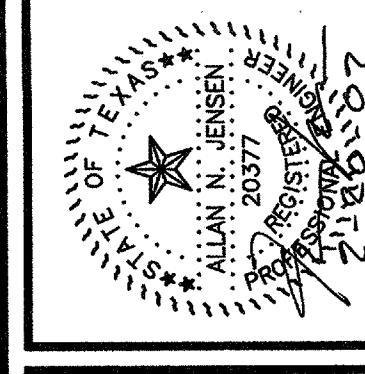

JOB NUMBER
 0012
 SHEET NAME
 PLUMBING SITE PLAN
 AND EXISTING BUILDING
 SHEET NUMBER
 P100

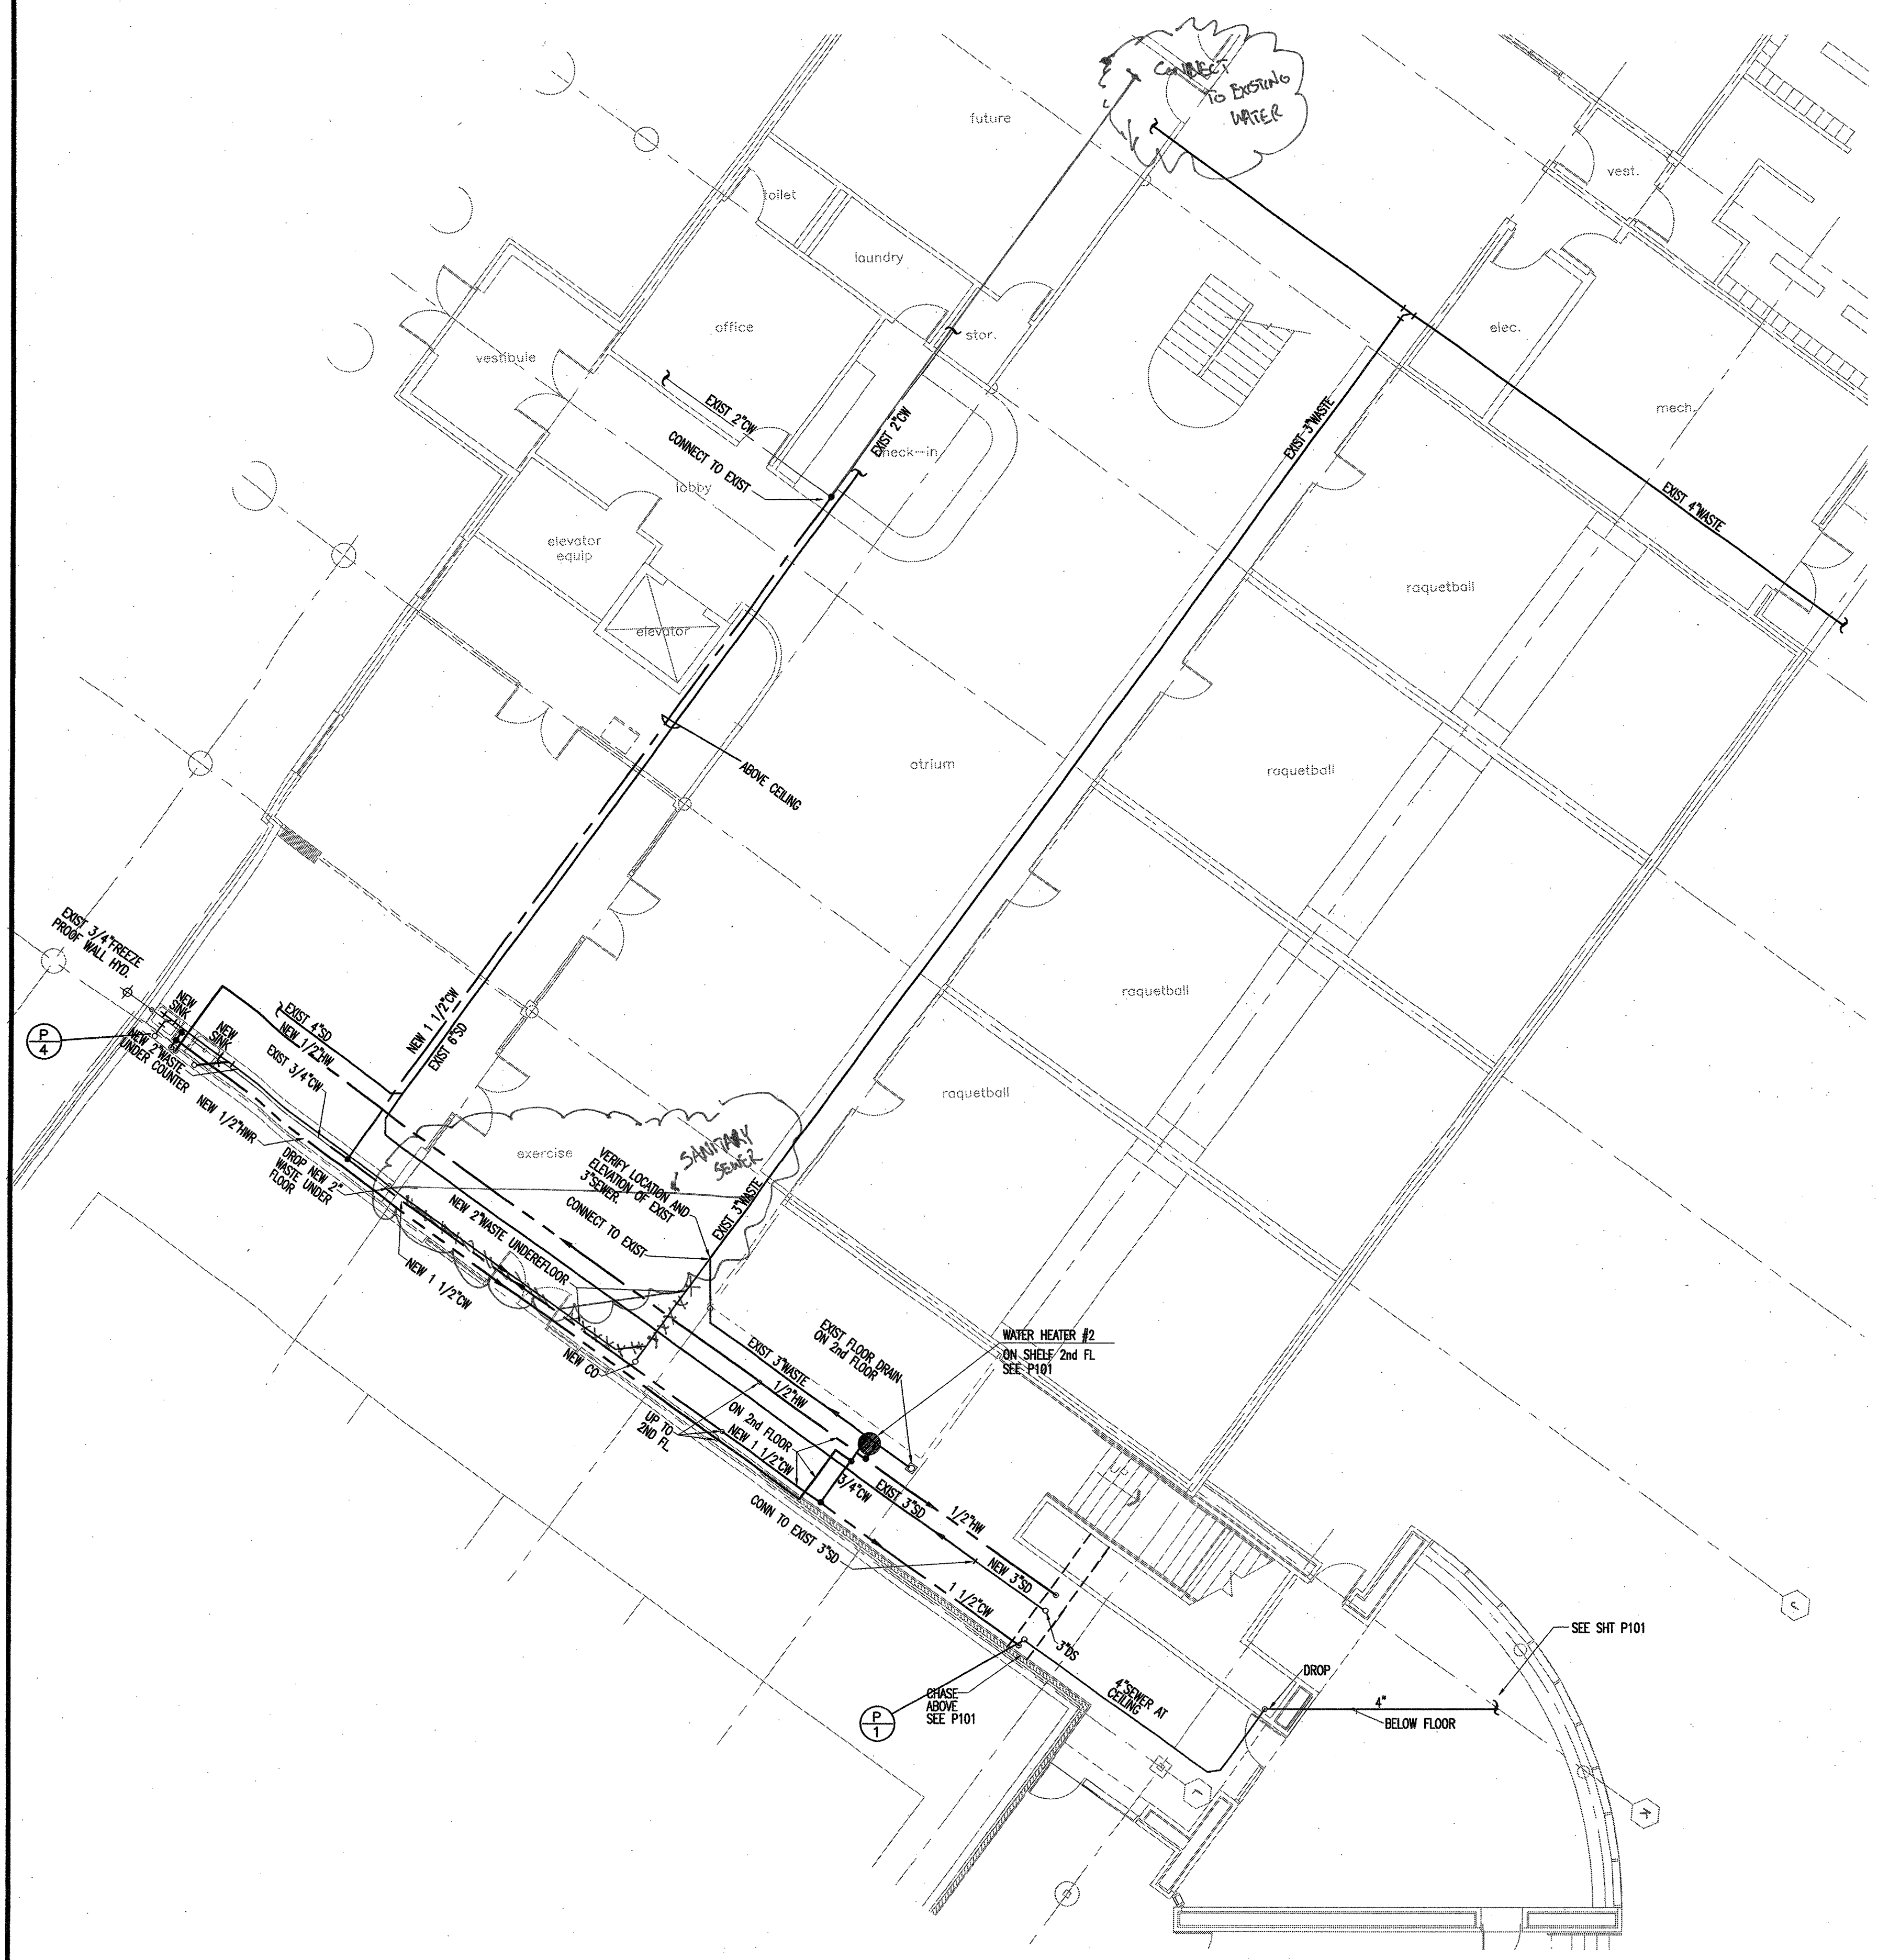

1 lower level floor plan exist building
 1/8"=1'-0"

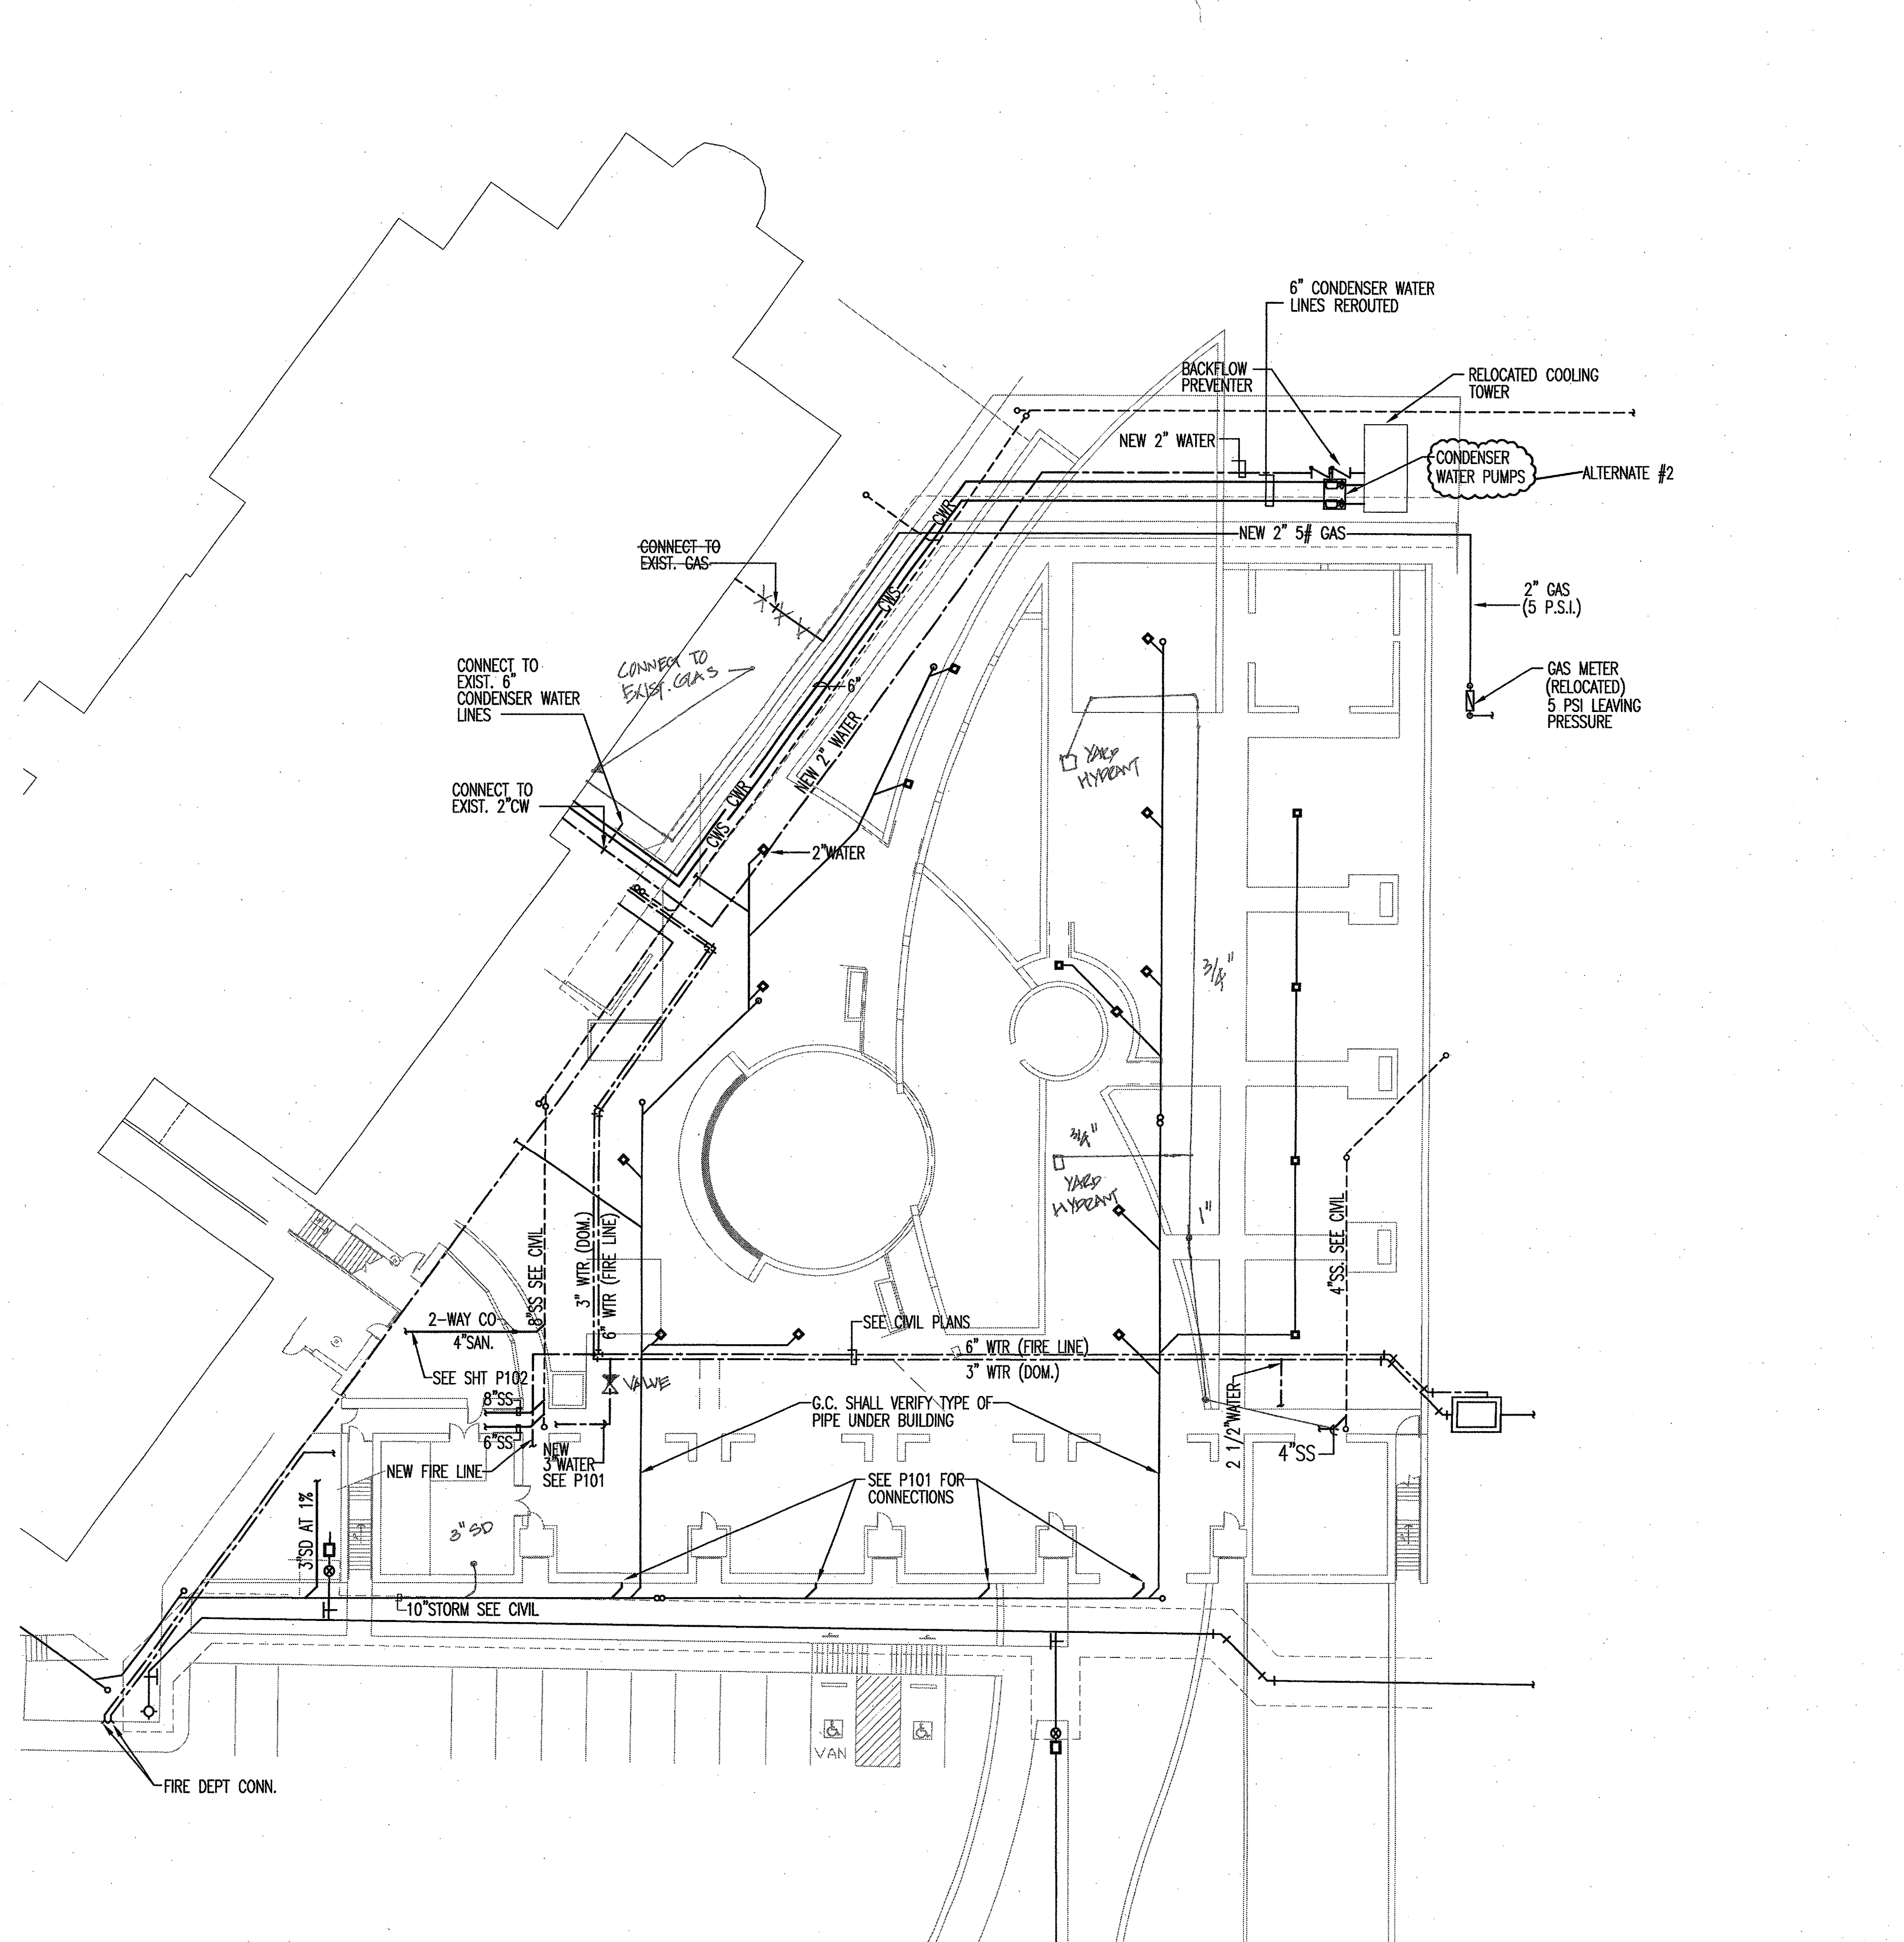

2 site plan - ground level
 1"=20'-0"

PLUMBING SYMBOLS LEGEND

	S OR W	SANITARY OR WASTE PIPING ABOVE SLAB
	S OR W	SANITARY OR WASTE PIPING BELOW SLAB
	SV	SANITARY VENT PIPING
	G	GAS PIPING
	CW	COLD WATER PIPING
	HW	HOT WATER PIPING
	HW R	HOT WATER RETURN
	SD	STORM DRAIN
	DS	DOWNSPOUT
	RD	ROOF DRAIN
	BV	BALL VALVE
	GV	GATE VALVE
	CH. V	CHECK VALVE
	RV	RELIEF VALVE
	HB	HOSE BIBB
		SHOCK ABSORBER STRAINER
	CO	WALL CLEANOUT
	FCO	FLOOR CLEANOUT
	FS	FLOOR SINK
	FD	FLOOR DRAIN
	FFD	FUNNEL DRAIN
	WM	WATER METER
		CONNECT TO EXISTING