
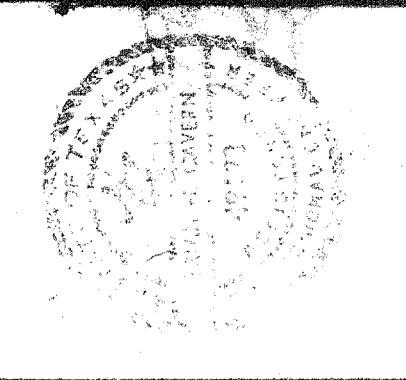


SHEET NO.	
BASIS	
DATE	
COMPOSITE	
FILE	
NO.	

ADDISON RECREATION CENTER
3900 BELTWAY DRIVE
ADDISON, TEXAS

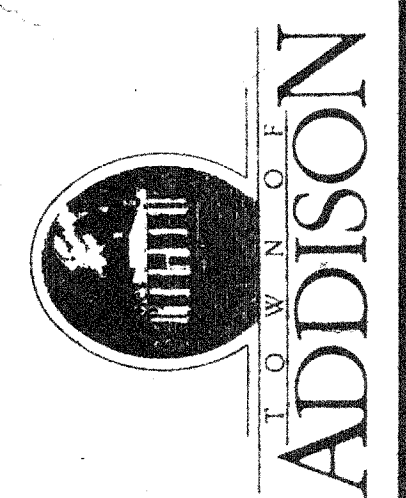


Phoenix Engineering
 HVAC/MECHANICAL
 Consulting Engineers
 Dallas, Texas
 (214) 956-0200
 Fax: (214) 956-0201

SECOND FLOOR
 HVAC PLAN


drawn by: [initials]
 checked by: [initials]
 date: 10/16/97
 revisions:

no. date

ME-3A

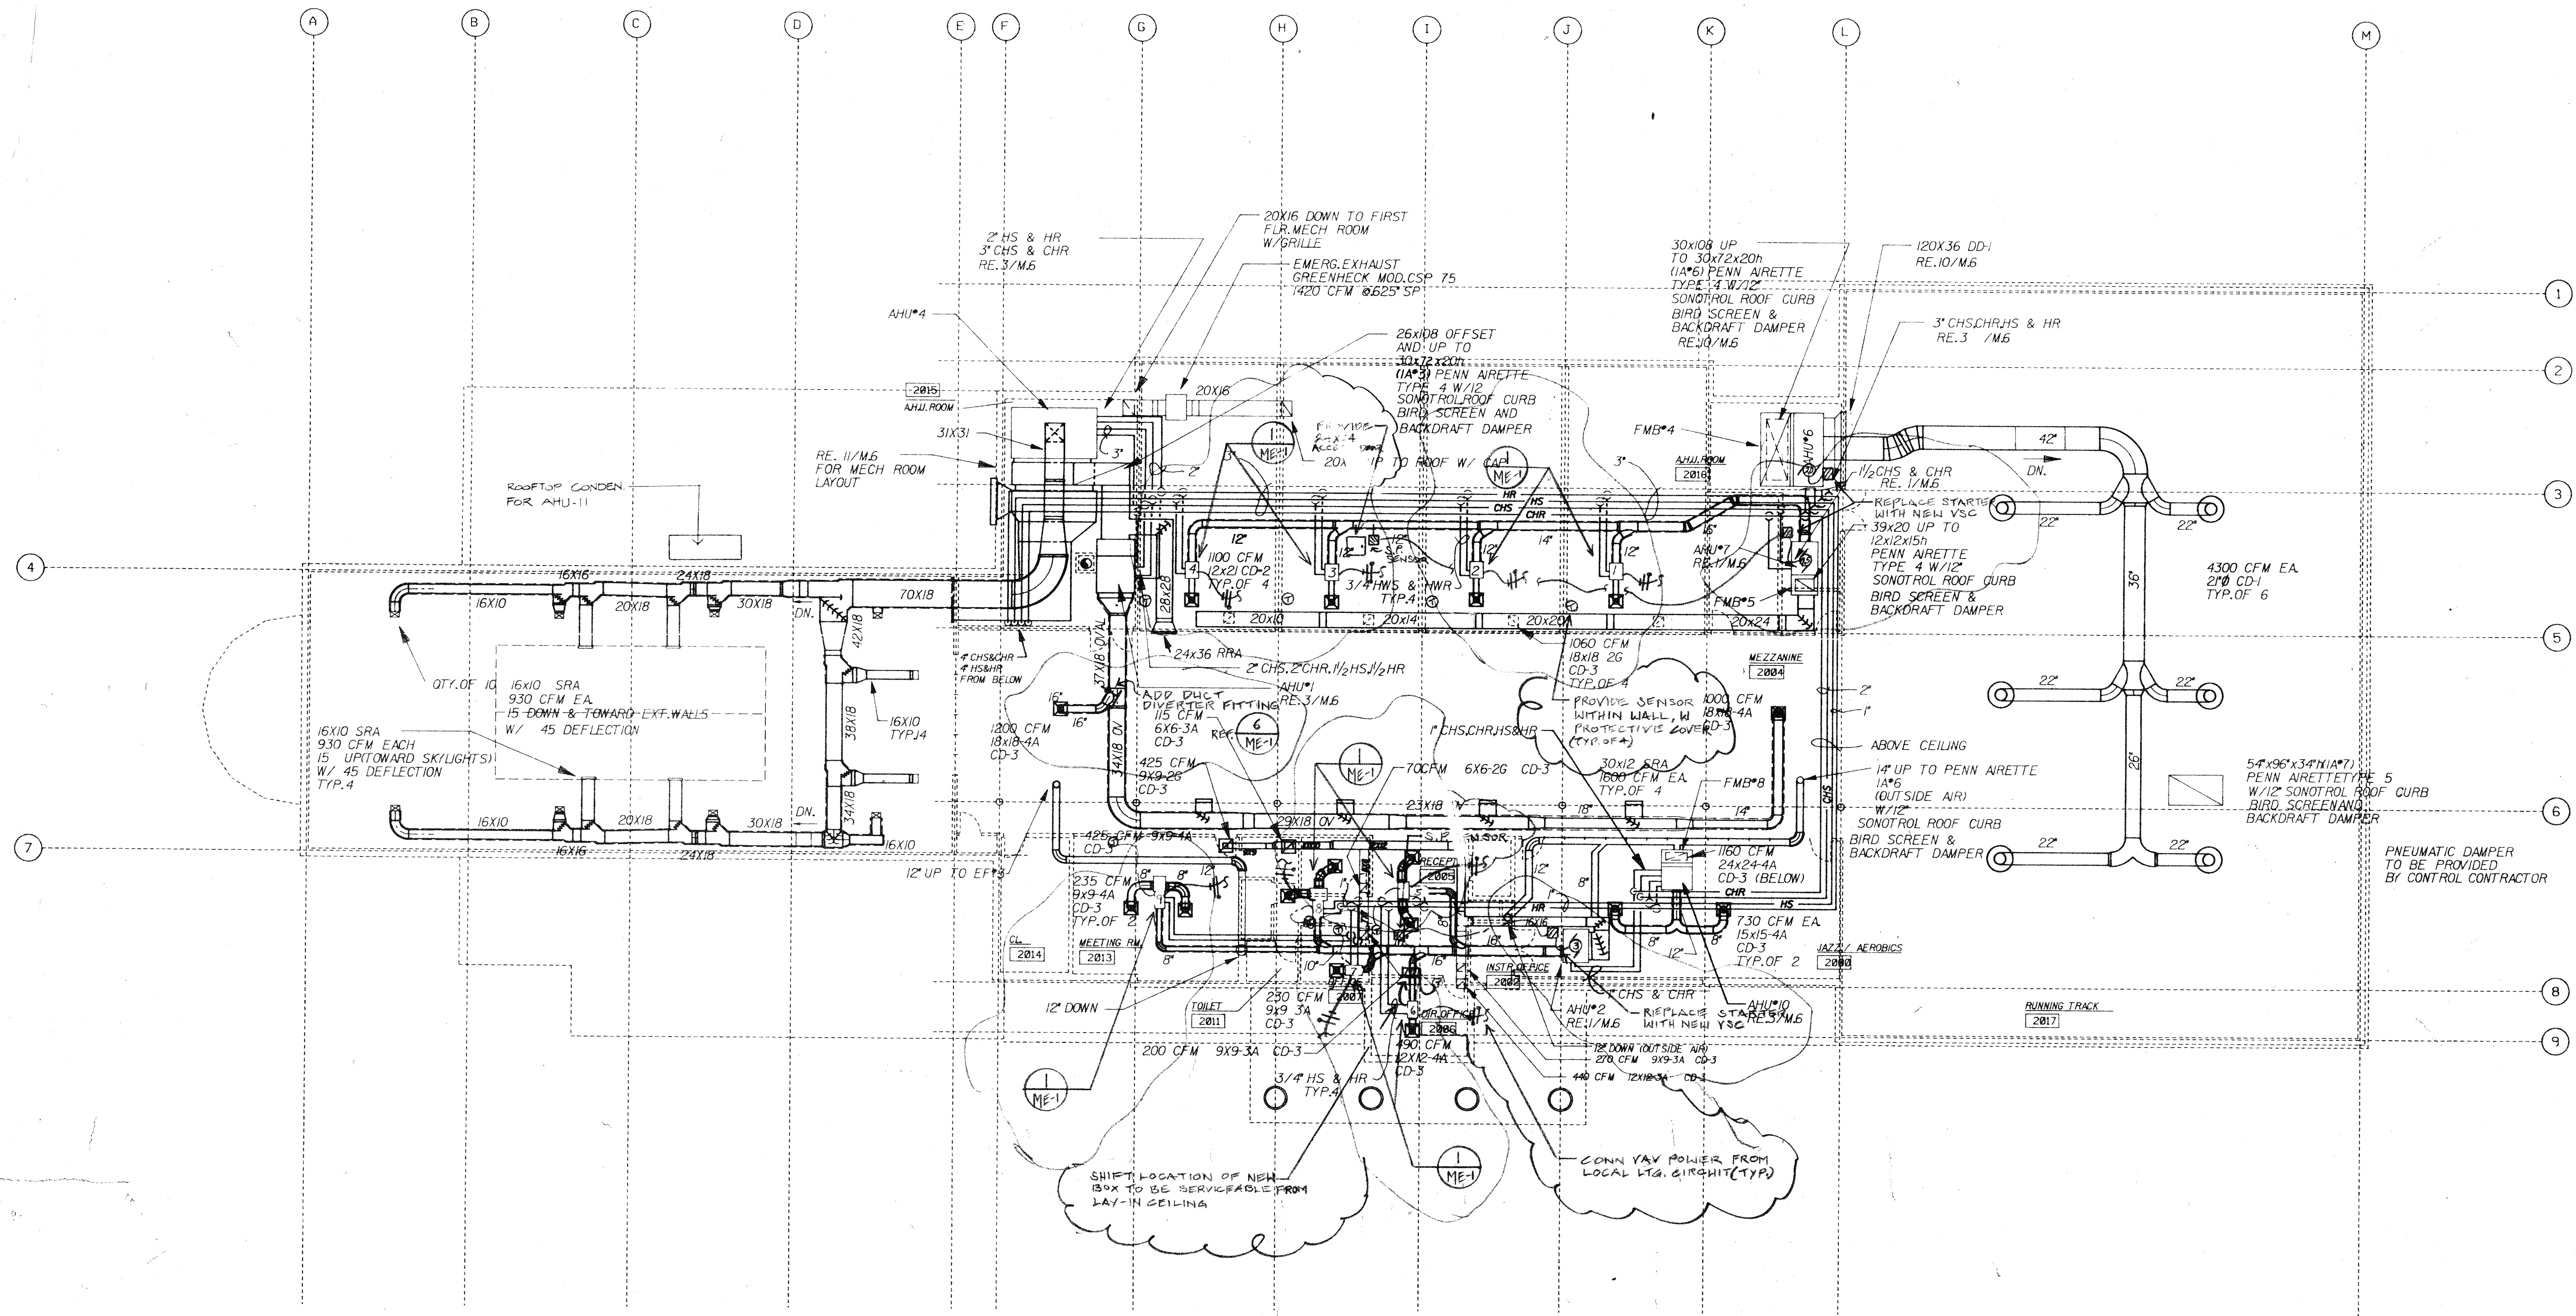

SECOND FLOOR HVAC PLAN
 SCALE: 3/32"=1'-0"

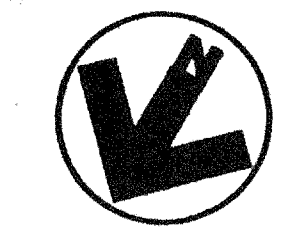

NEW WORK SHOWN
 WITHIN CLOUDS