



SHEET NO.	
BASE	
CL	
LA	
SI	
ME	
COMPOSITE	

**ADDISON RECREATION CENTER**  
 3900 BELTWAY DRIVE  
 ADDISON, TEXAS

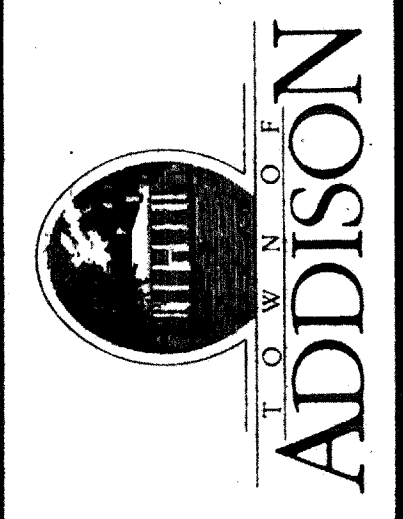

**The Benham Group**  
 Dallas

architects  
 engineers  
 planners  
 1341 w. mockingbird ln.  
 suite 517 e  
 dallas, texas

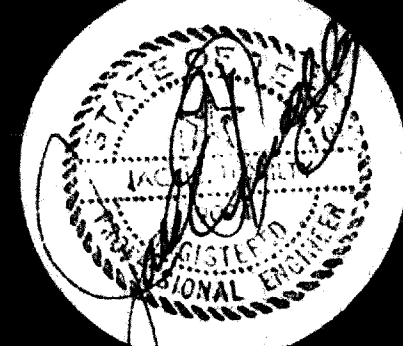


**GROUND FLOOR HVAC PLAN**

drawn **D. LONERGAN**  
 chkd **J. TUMILTY**  
 date **3-19-88**

no. **1** date **4-21-88**

sheet **M-2**

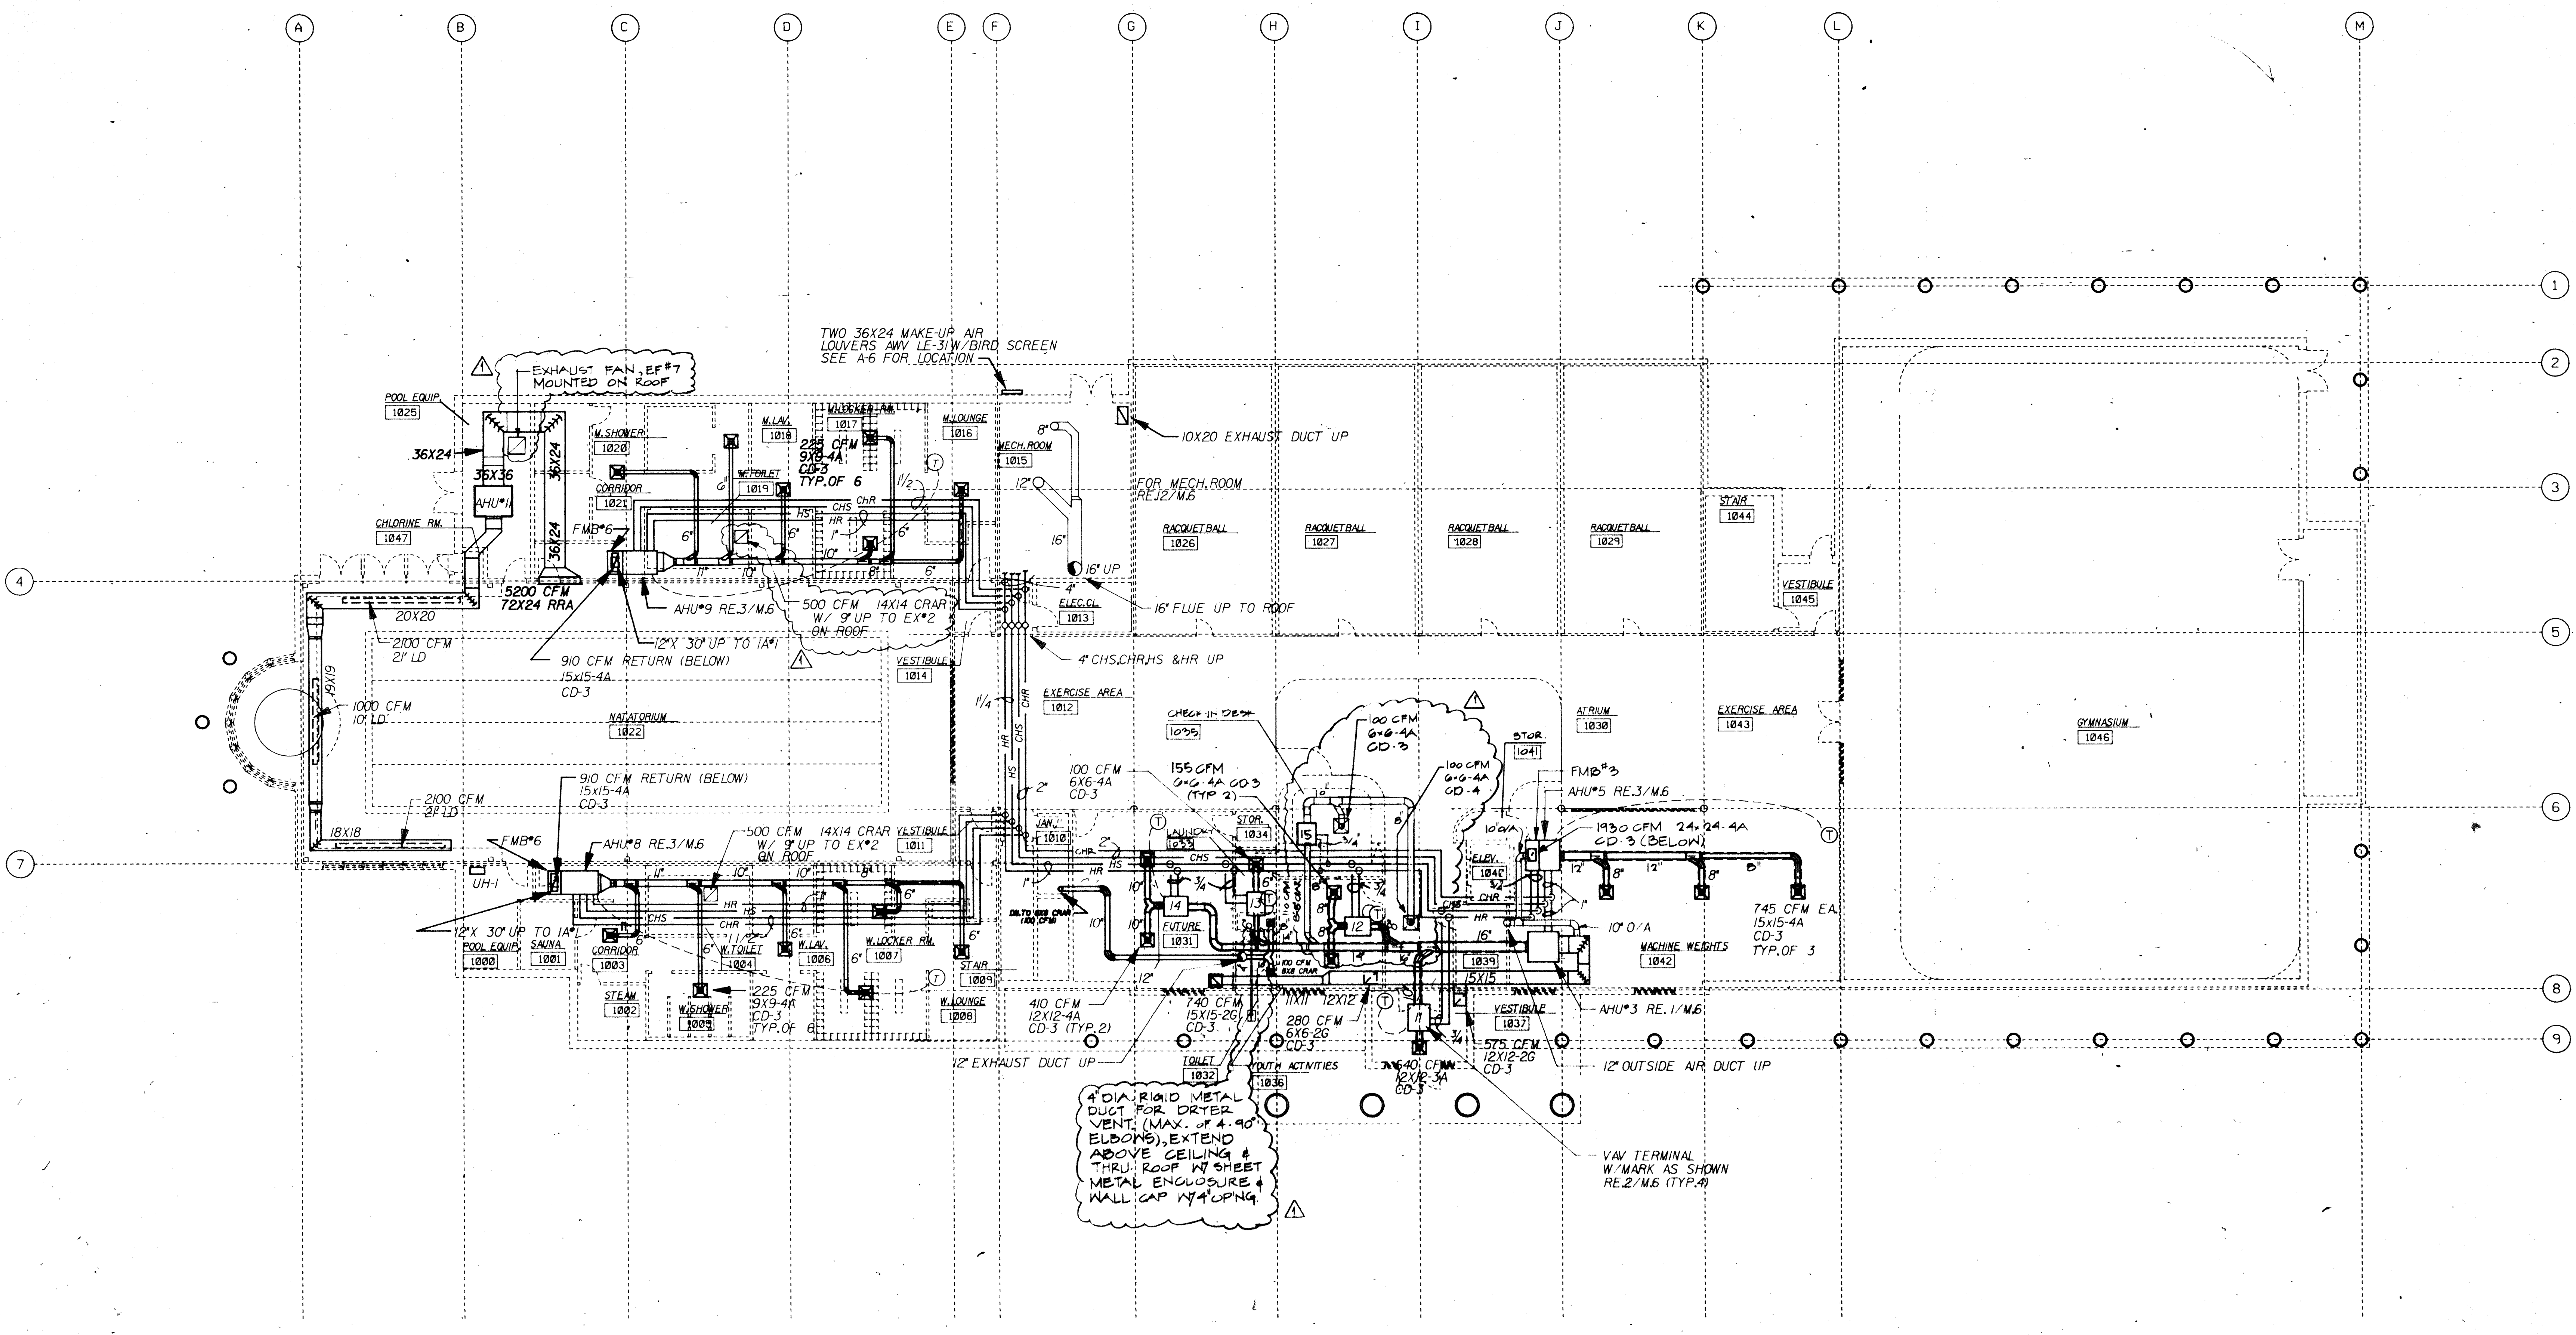

**GROUND FLOOR HVAC PLAN**  
 SCALE: 3/32"=1'-0"

