


SHEET NO.	
BASIS	
DATE	
BY	
CHECKED	
REVISIONS	

ADDISON RECREATION CENTER
3900 BELTWAY DRIVE
ADDISON, TEXAS

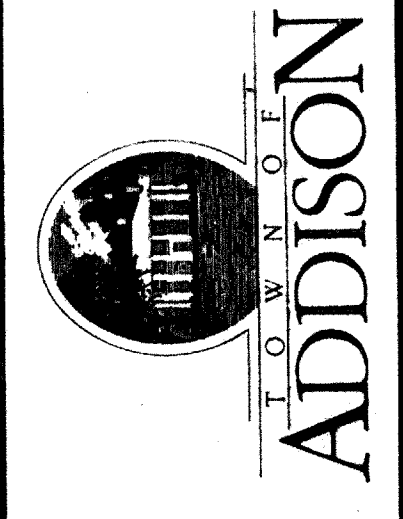

The Benham Group
 Dallas

architects
 engineers
 planners
 1341 w. mockingbird ln.
 suite 517 e
 dallas, texas




PROJECT TITLE
SECOND FLOOR HVAC PLAN

drawn **D. LONERGAN**
 checked **J. TUMILTY**

date **3-10-86**

no. **1** date **4-21-86**

sheet of **M-3**

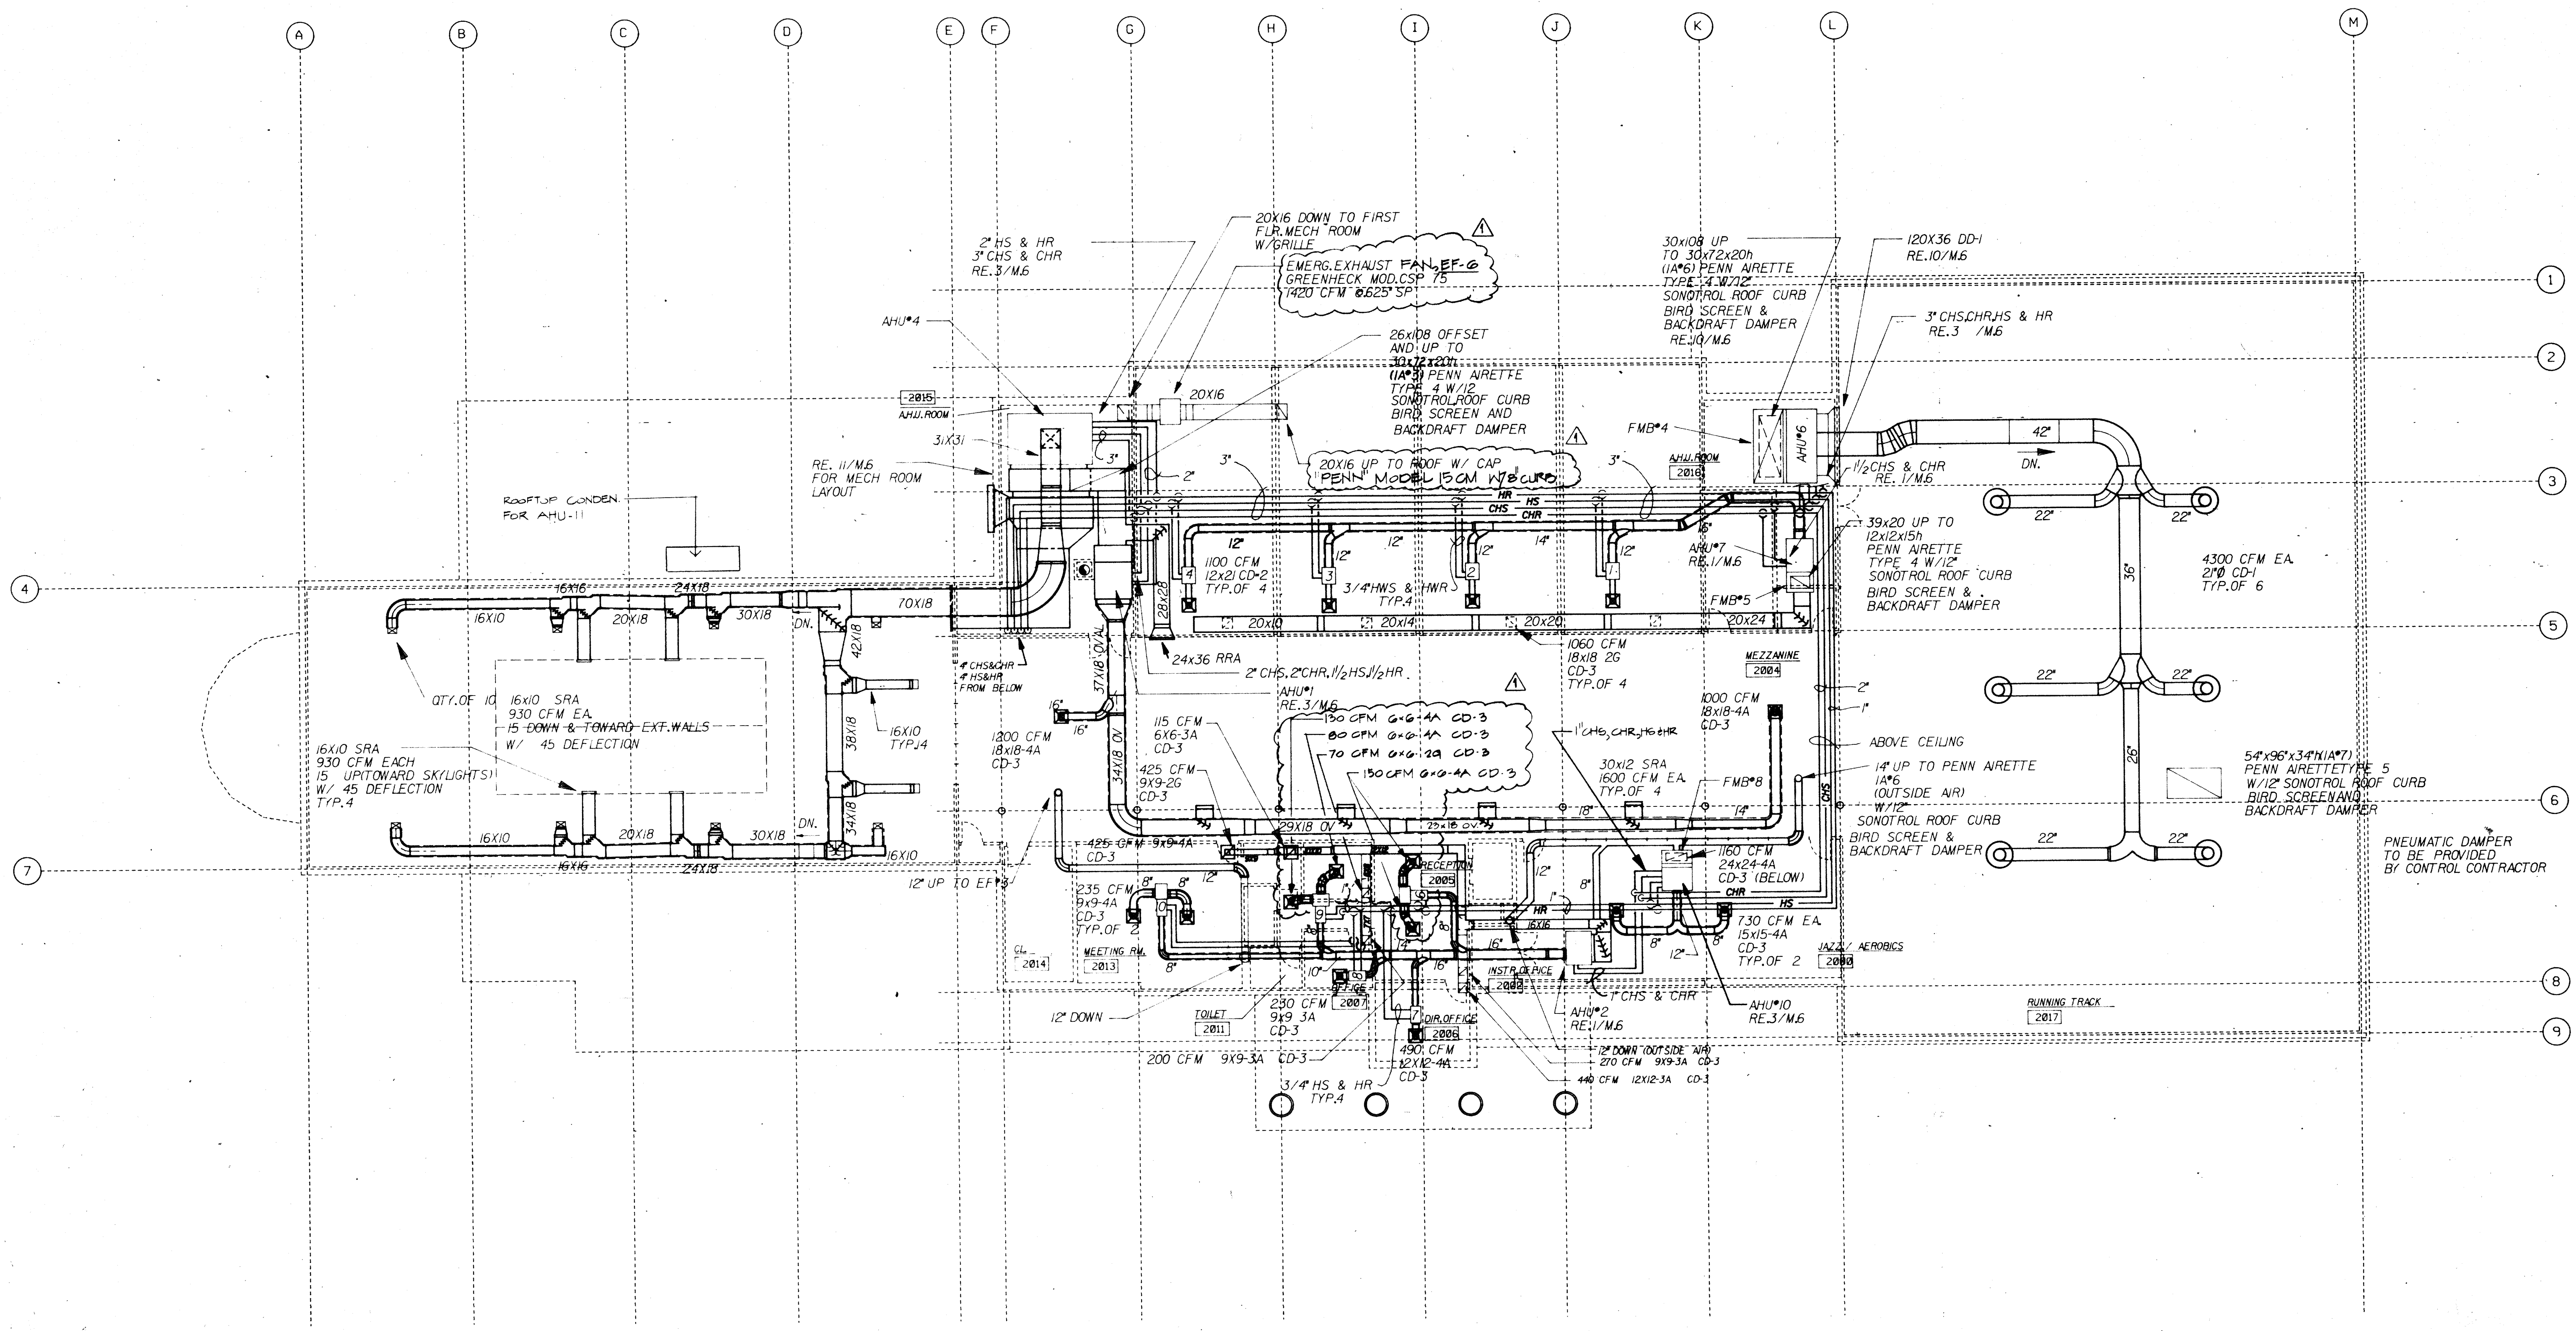

SECOND FLOOR HVAC PLAN
 SCALE: 3/32"=1'-0"

