


SHEET NO.	
BASE	
CLAS	
PLANS	
COMPOSITE	

ADDISON RECREATION CENTER
 3900 BELTWAY DRIVE
 ADDISON, TEXAS

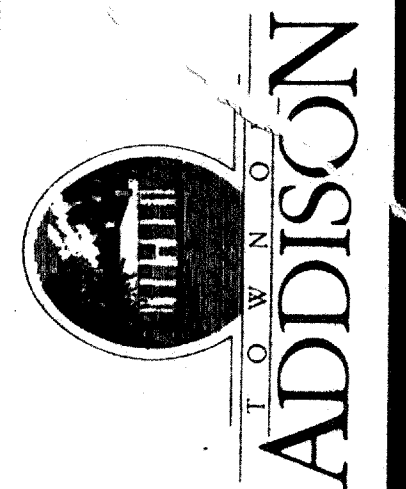

The Benham Group
 Dallas

architects
 engineers
 planners
 1341 w. mockingbird ln.
 suite 517 e
 dallas, texas




GROUND FLOOR PIPING PLAN

Drawn: **D. LOHERGAN**
 Checked: **P. ROBERTS**
 Date: **3-19-86**

no. **1** date **4-21-86**

M-4

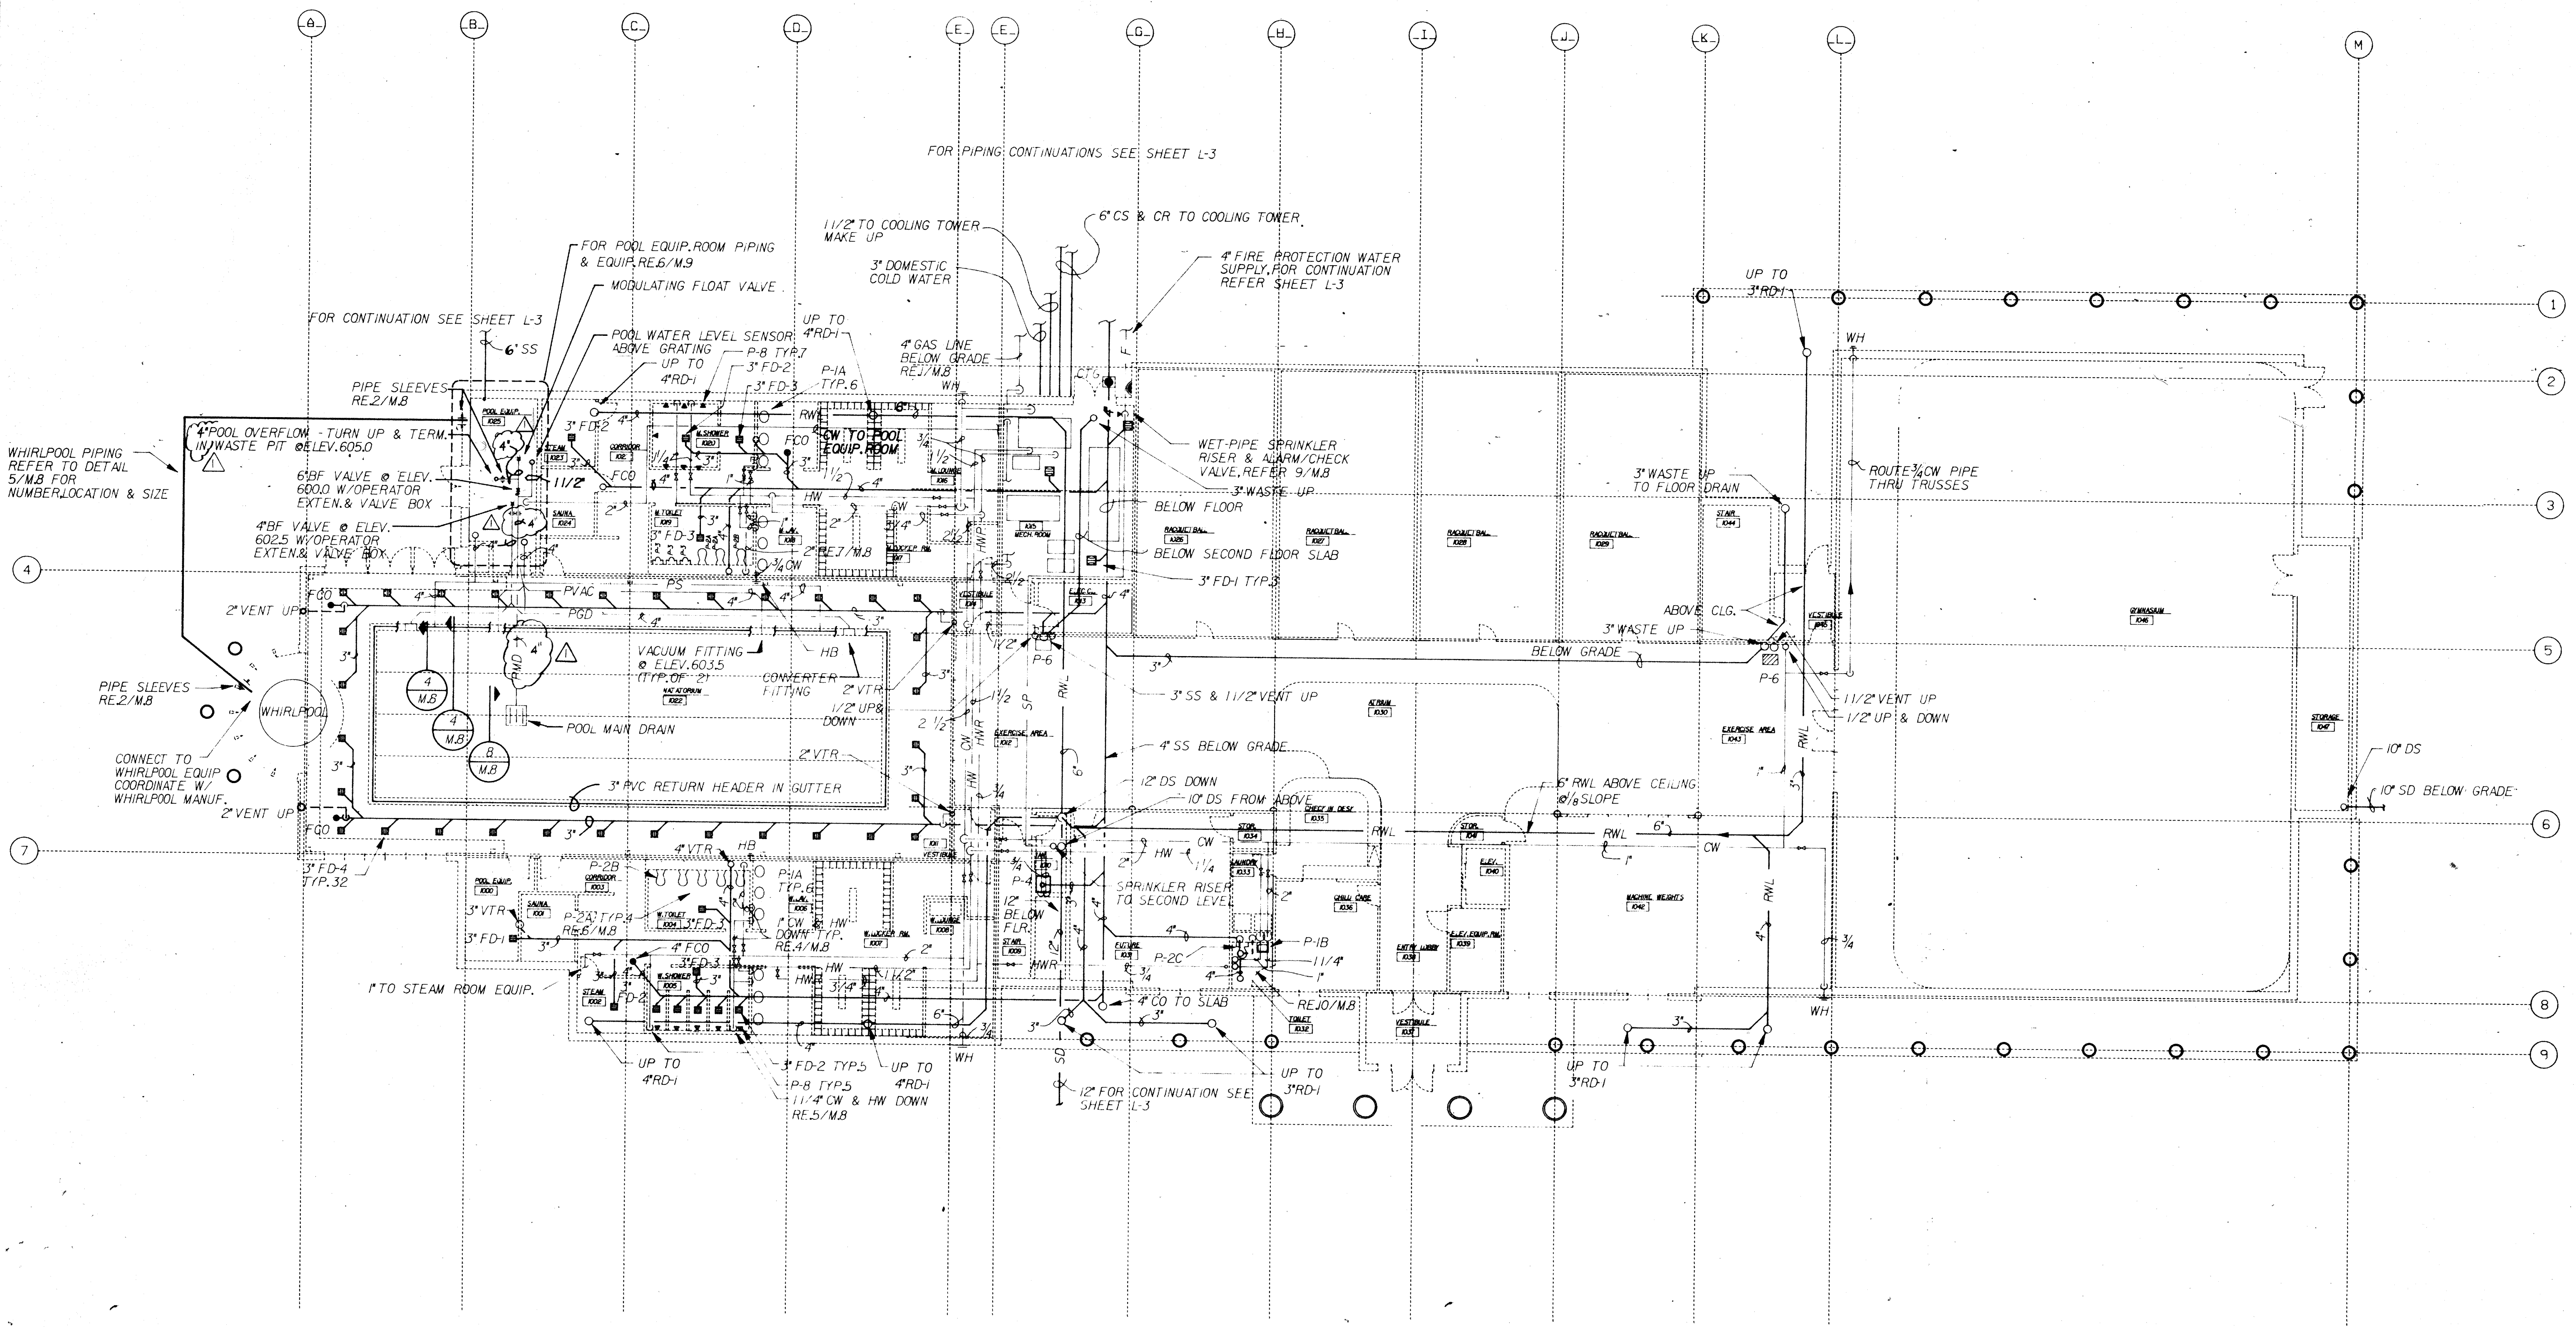

GROUND FLOOR PIPING PLAN
 SCALE: 3/32"=1'-0"