


| | |
|-----------|--|
| SHEET NO. | |
| BASE | |
| C | |
| L | |
| A | |
| S | |
| M | |
| E | |
| COMPOSITE | |

ADDISON RECREATION CENTER
3900 BELTWAY DRIVE
ADDISON, TEXAS

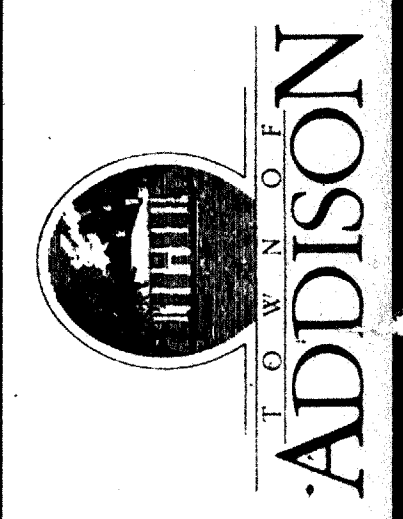

The Benham Group Dallas
 architects
 engineers
 planners
 1341 w. mockingbird ln.
 suite 517 e
 dallas, texas




SECOND FLOOR
 PIPING PLAN

Drawn: **D. LOMERGAN**
 Chk'd: **P. ROBERTS**
 Date: **3-19-86**

| no. | date |
|-----|------|
| | |
| | |
| | |

M-5

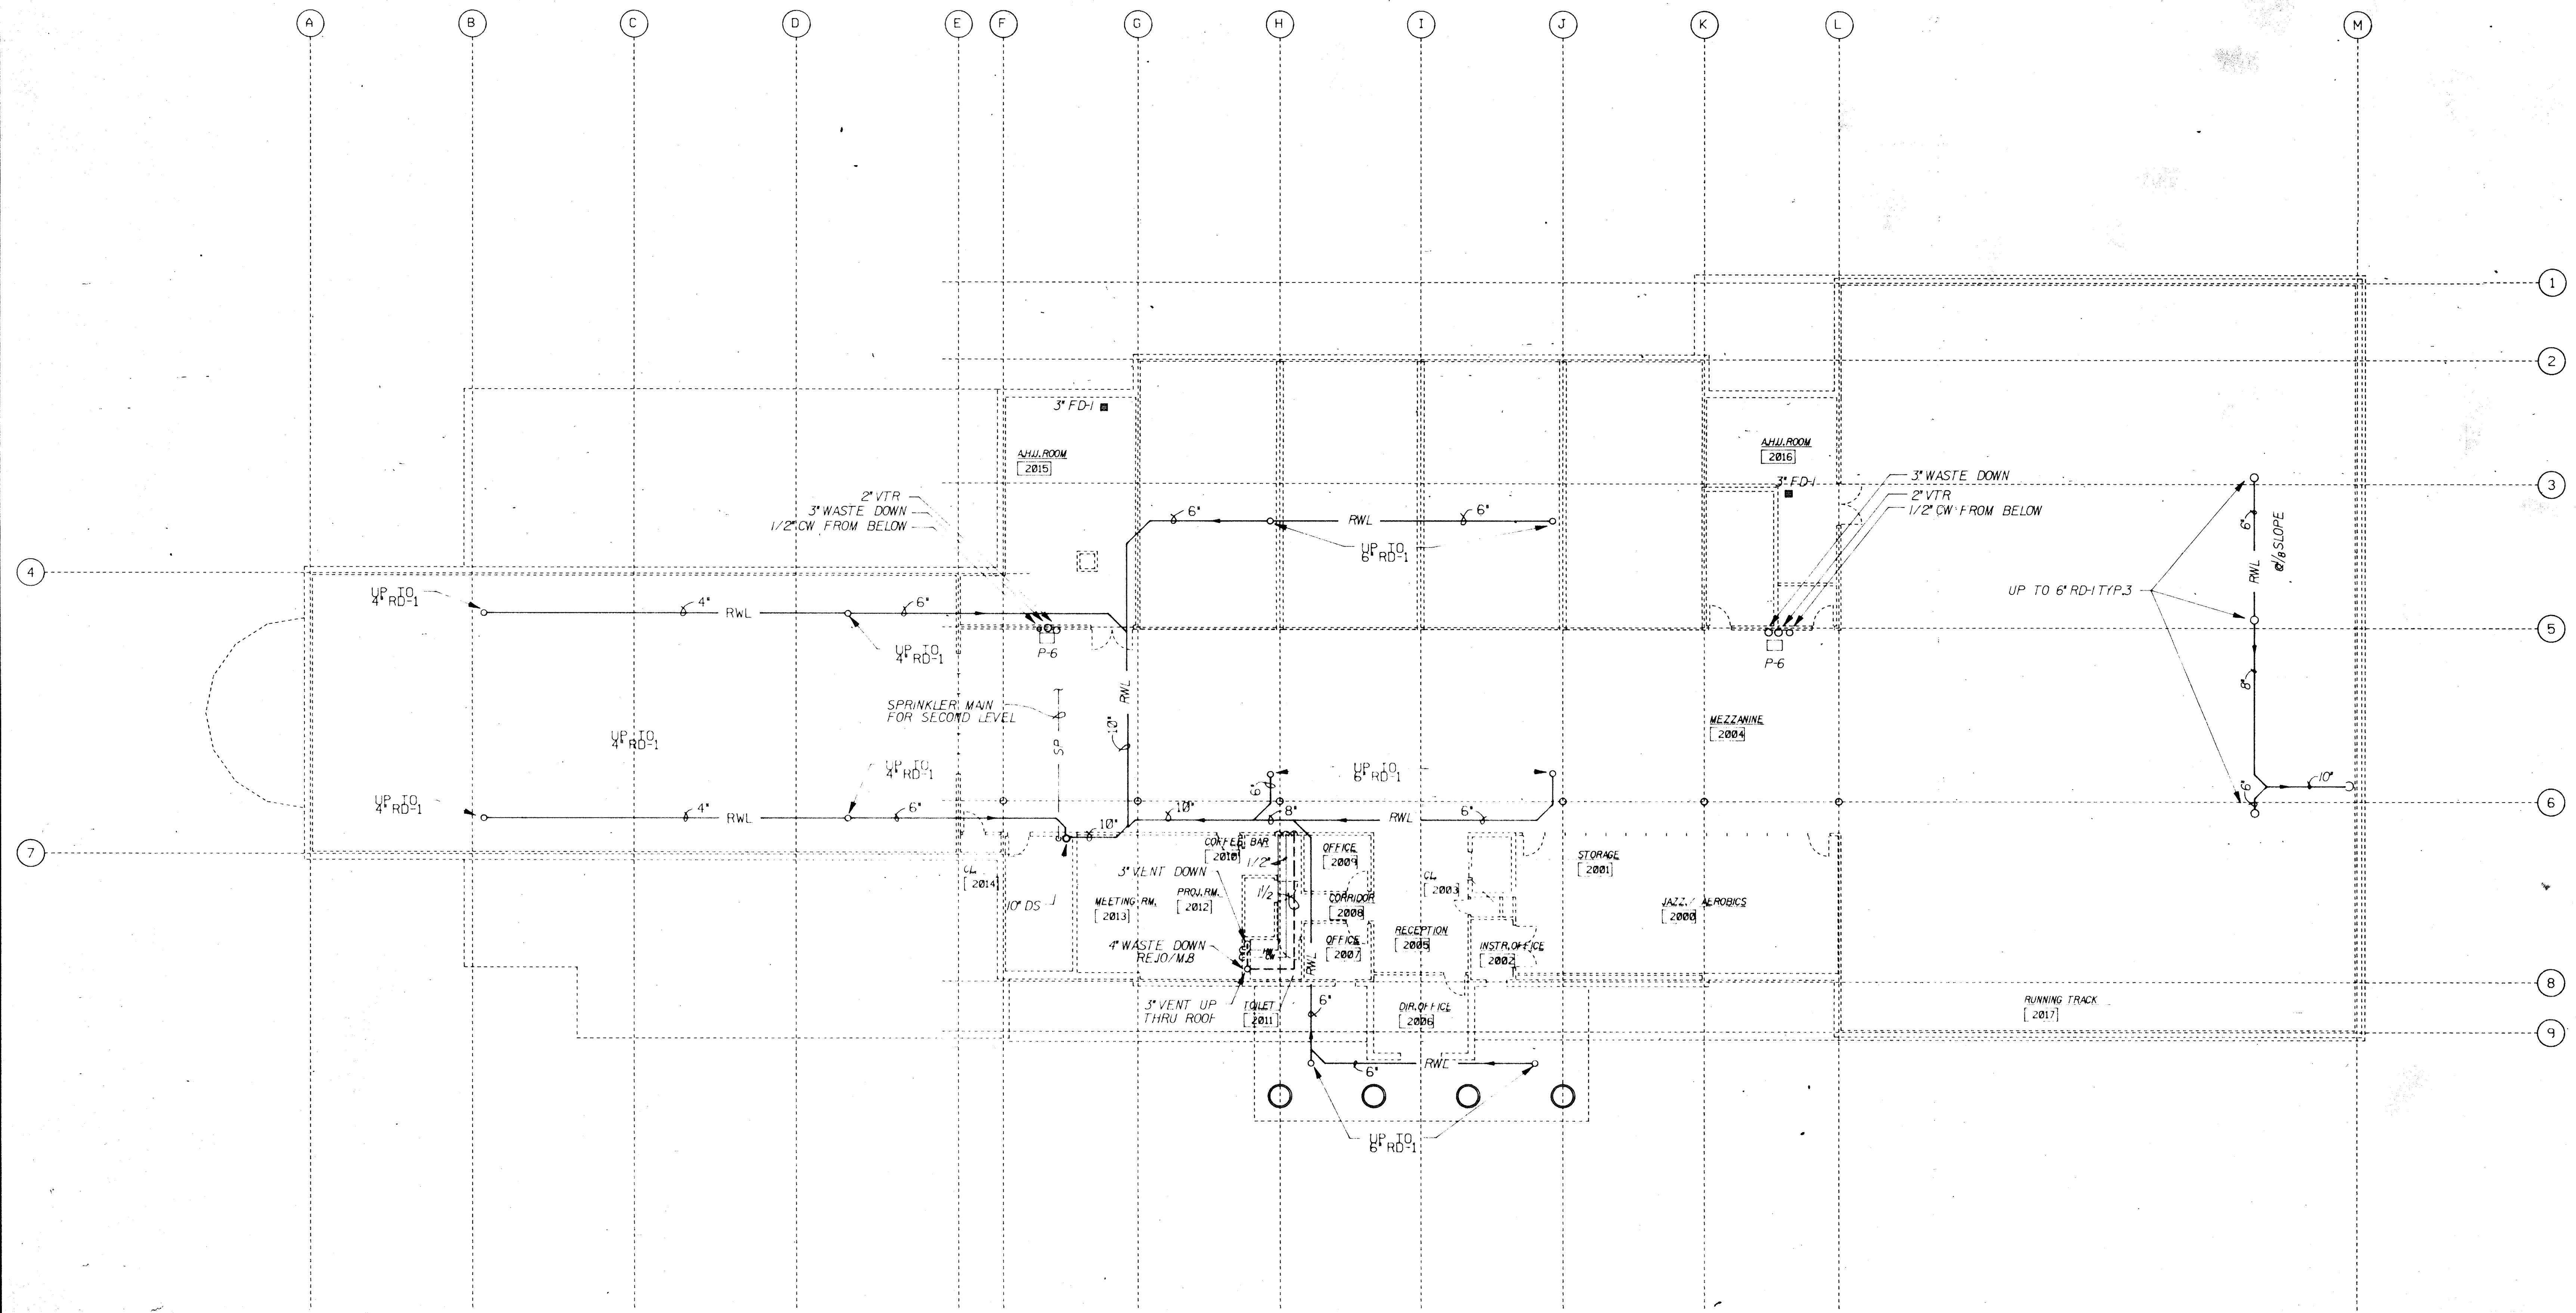

SECOND FLOOR PIPING PLAN
 SCALE: 3/32"=1'-0"

