

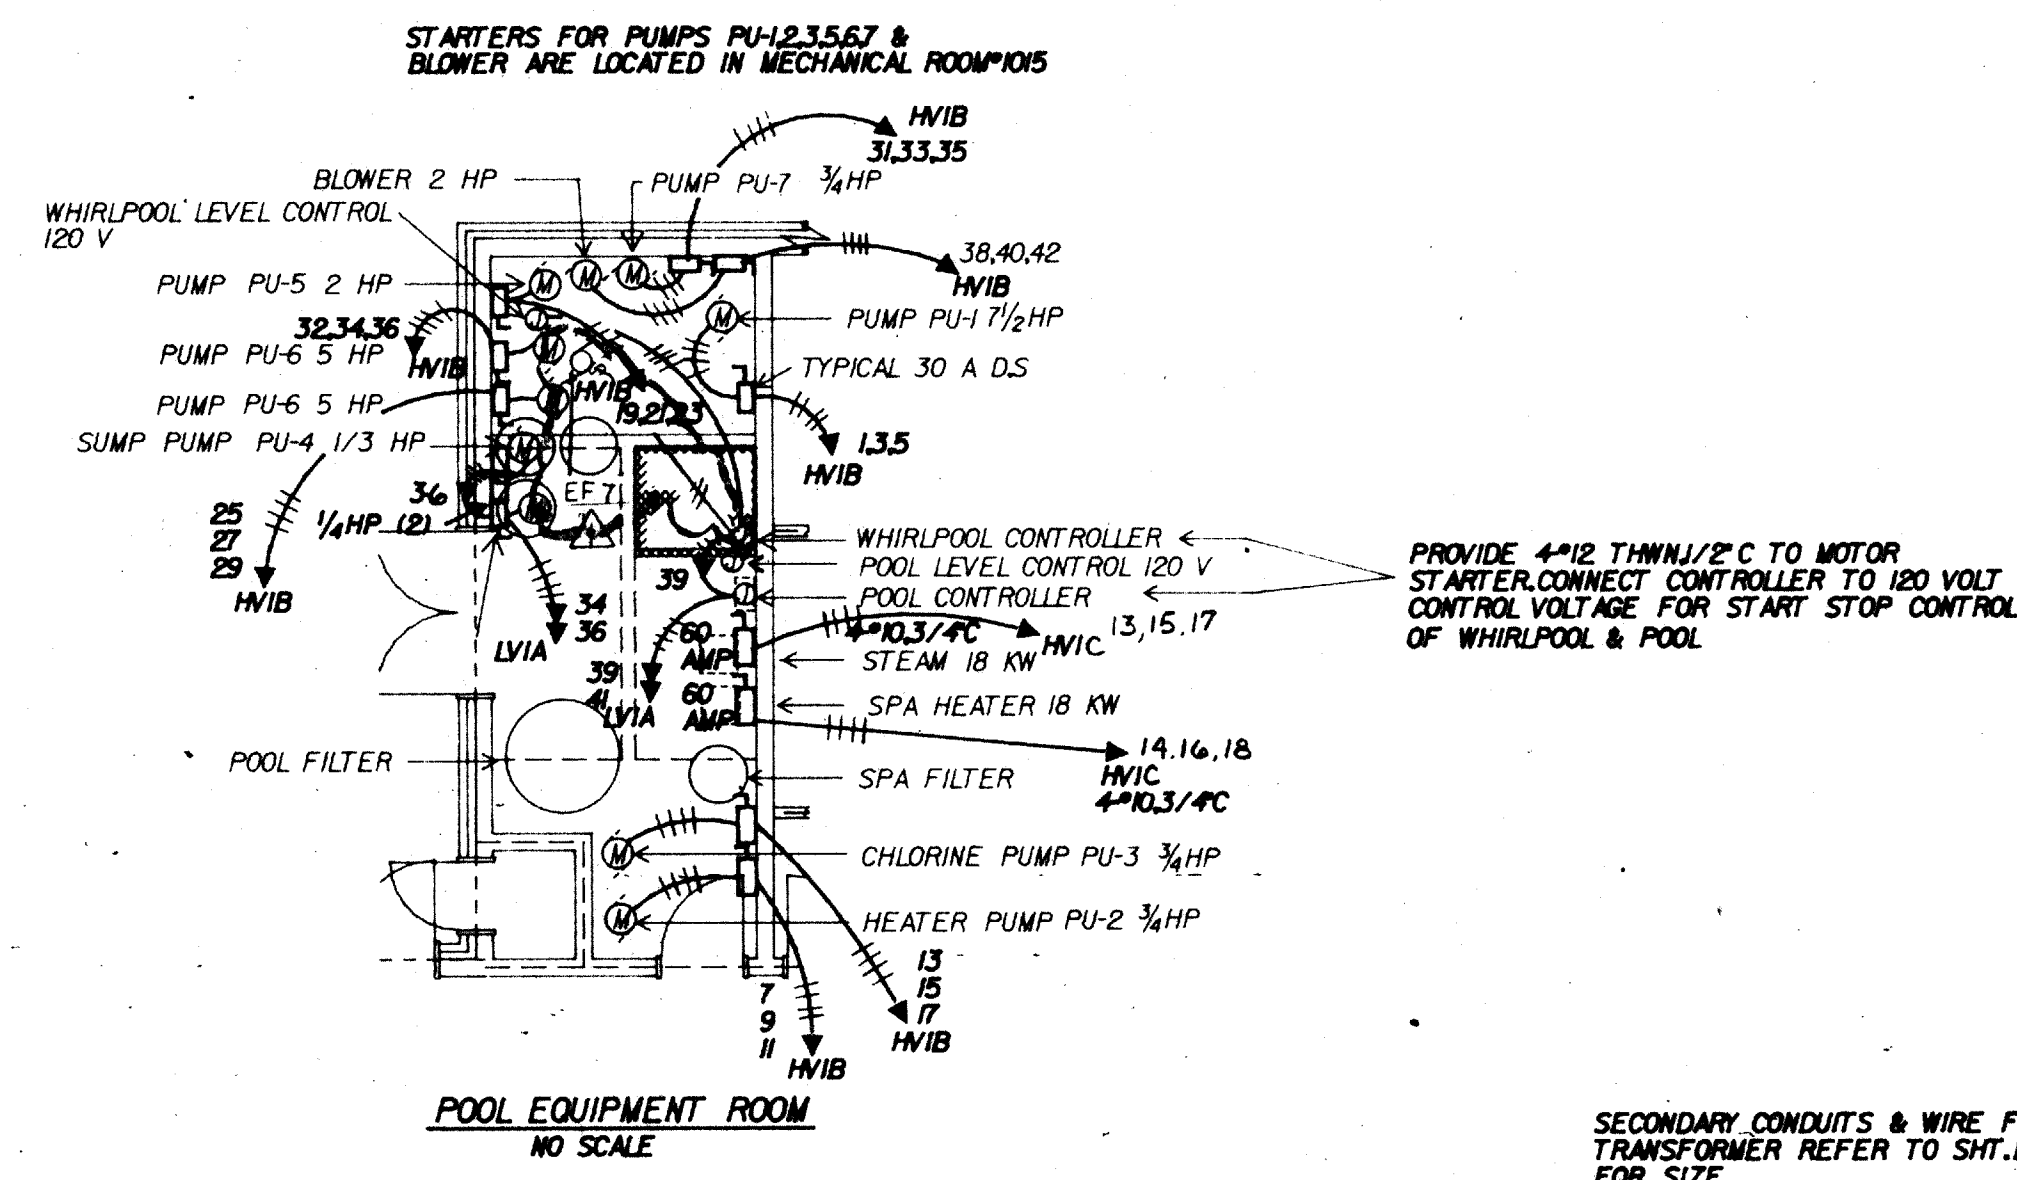


SHEET NO.	
BASE	
C	
A	
S	
M	
E	
COMPOSITE	

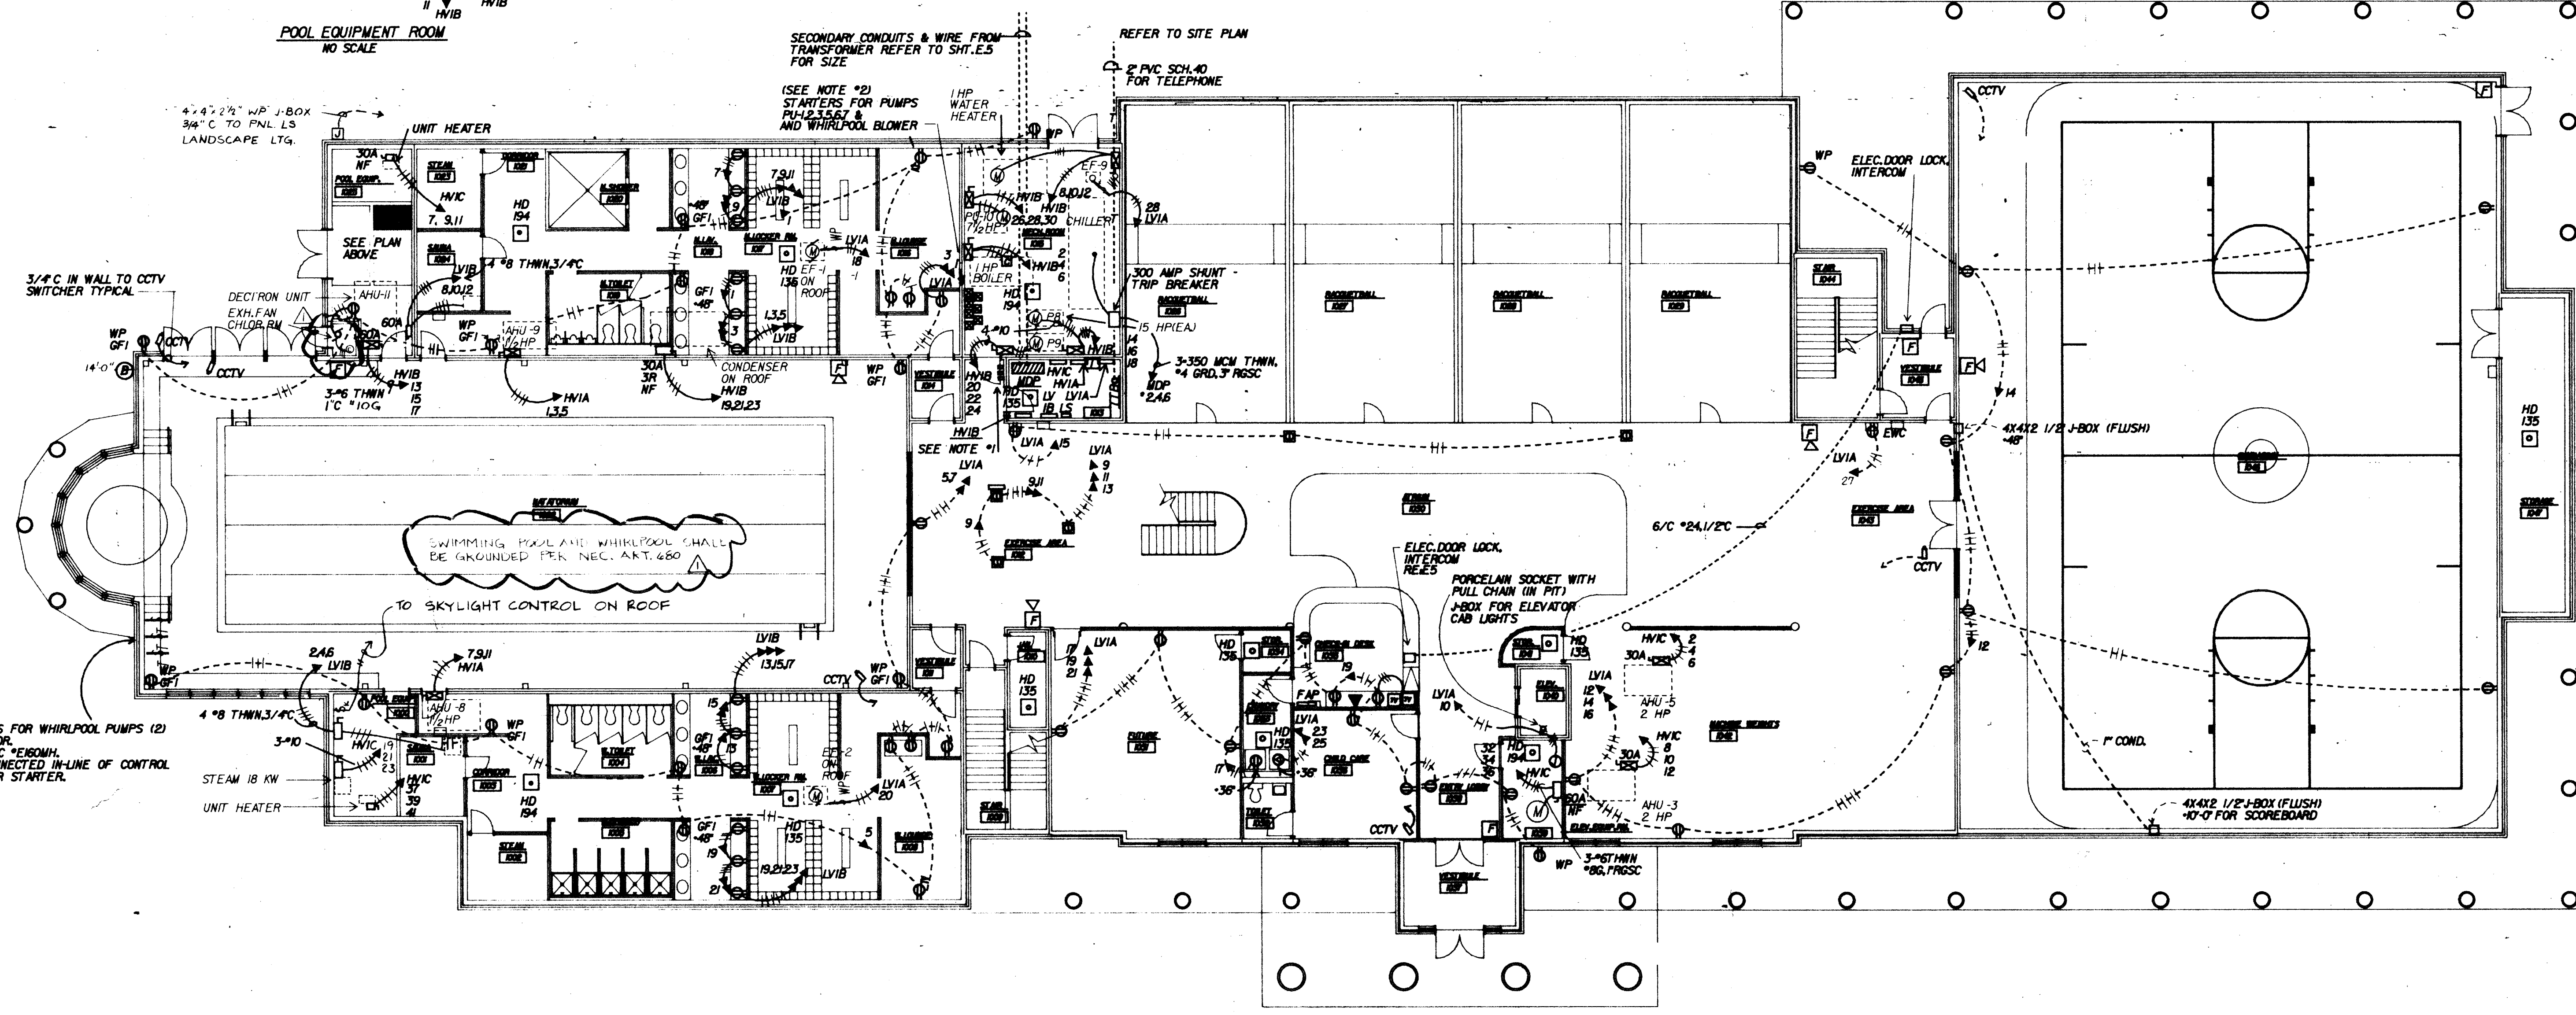


NOTE:


- PROVIDE 120 VOLT SHUNT-TRIP CONTROL SWITCH FOR 300 AMP SHUNT-TRIP BREAKER AT CHILLER. PROVIDE RED LAMINATE LABEL READING "EMERGENCY CHILLER SHUTDOWN". PROVIDE 120 VOLT SHUNT-TRIP CONTROL SWITCH FOR 225 AMP SHUNT-TRIP MAIN BREAKER IN PANEL HWIB. PROVIDE RED LAMINATE LABEL READING "EMERGENCY MACHINERY SHUTDOWN IN MECHANICAL ROOM". PROVIDE 120 VOLT SWITCH FOR VENTILATION FAN # EF-9. PROVIDE RED LAMINATE LABEL READING "EMERGENCY MECHANICAL ROOM VENTILATION FAN".
- EC SHALL FURNISH AND INSTALL MOTOR STARTERS FOR MECHANICAL EQUIPMENT. STARTERS SHALL BE HP RATED 480 VAC 3P WITH A FUSED 120 VOLT CONTROL TRANSFORMER. STARTERS WITH FUSED SWITCH SHALL BE PROVIDED WHERE SHOWN. REFER TO ELECTRICAL LEGEND.
- ALL CIRCUITS EXCLUDING LIGHTING CIRCUITS SHALL HAVE A GROUND WIRE INSTALLED SIZED PER NEC, ARTICLE 250.

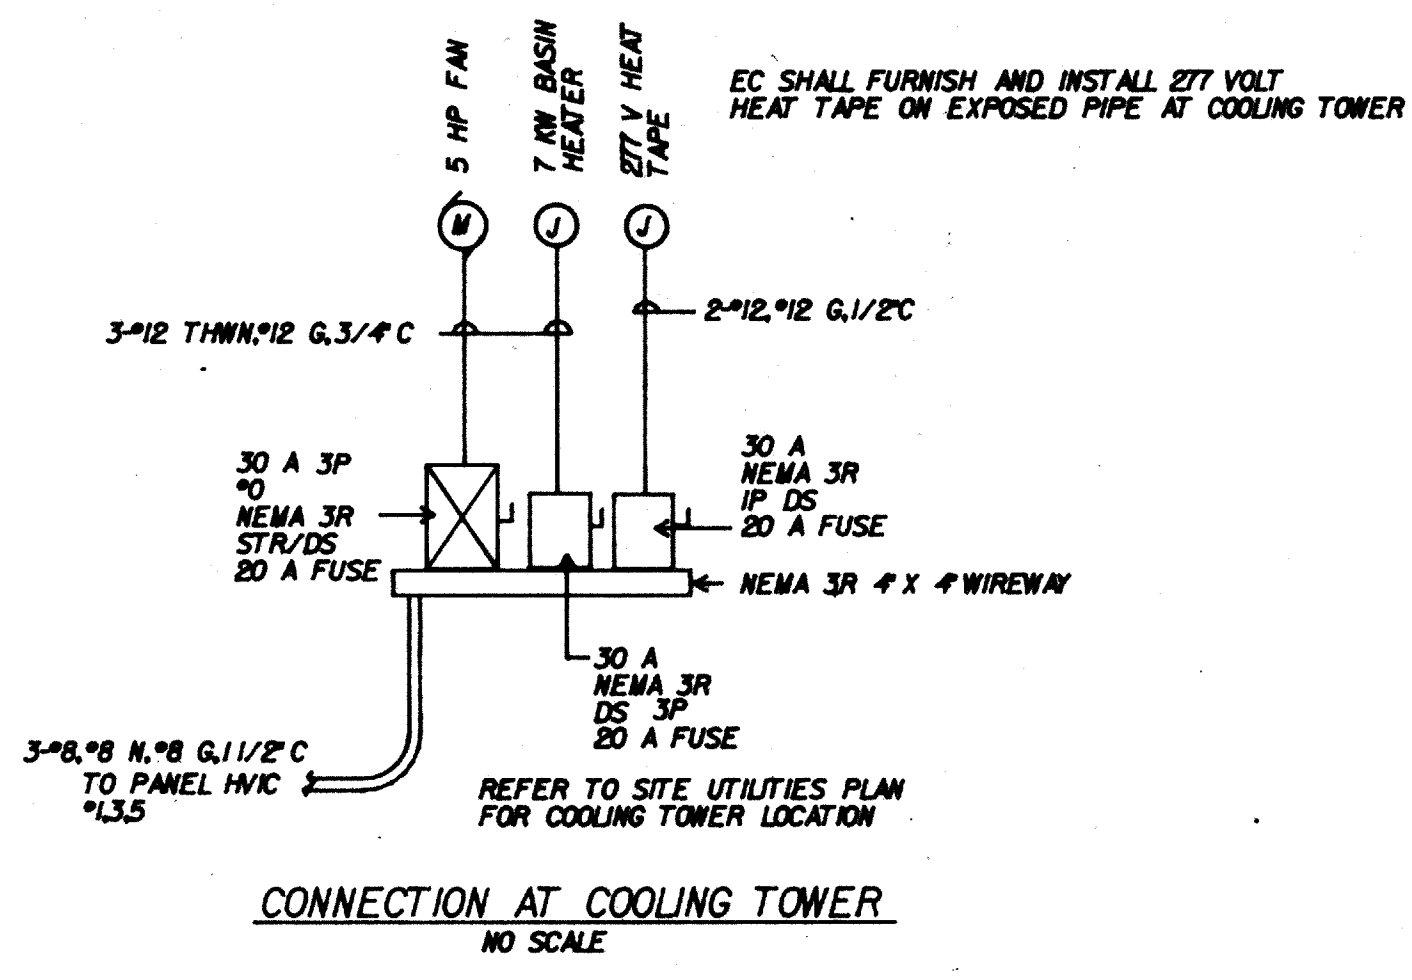

GROUND FLOOR PLAN
SCALE: 3/32"=1'-0"

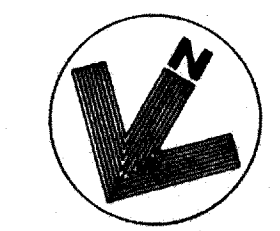

ADDISON RECREATION CENTER
3900 BELTWAY DRIVE
ADDISON, TEXAS

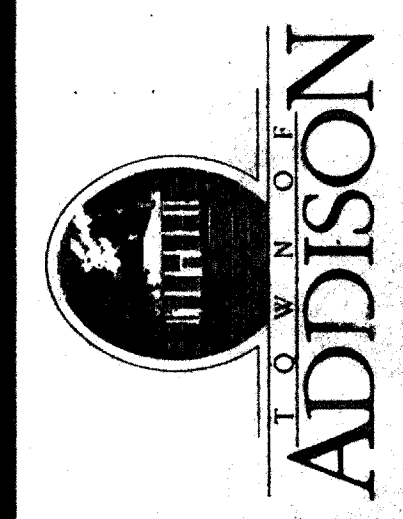

The Benham Group Dallas
architects
engineers
planners
1341 w. mockingbird ln.
suite 517 e
dallas, texas



GROUND FLOOR
POWER PLAN

drawn G. GOINS
chk d. D. WHITMAN
date 3-19-86

revisions
no. date
1 4-21-86

Sheet of E-1