



SHEET NO.	
BASE	
C	
D	
E	
F	
G	
H	
I	
J	
K	
L	
M	
N	
O	
P	
Q	
R	
S	
T	
U	
V	
W	
X	
Y	
Z	

**ADDISON RECREATION CENTER**  
 3900 BELTWAY DRIVE  
 ADDISON, TEXAS

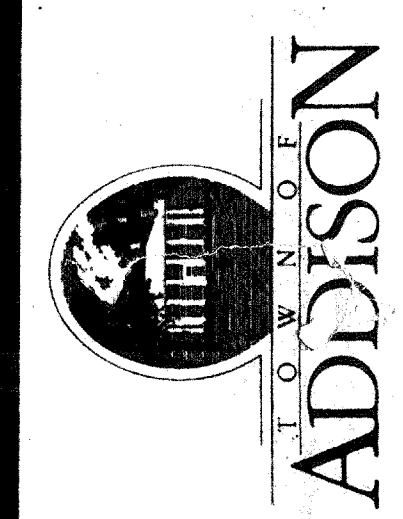

**The Benham Group** Dallas

architects  
 engineers  
 planners  
 1341 w. mockingbird ln.  
 suite 517 e  
 dallas, texas

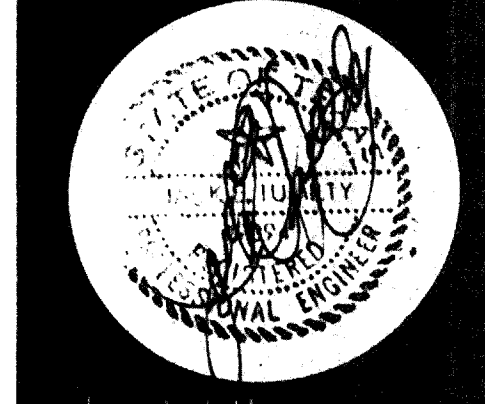



**SECOND FLOOR LIGHTING PLAN**

drawn **G. GOINS**  
 chkd **D. WHITMAN**  
 date **3-19-88**

revisions

no. **Δ** date **4-21-86**

**E-4**

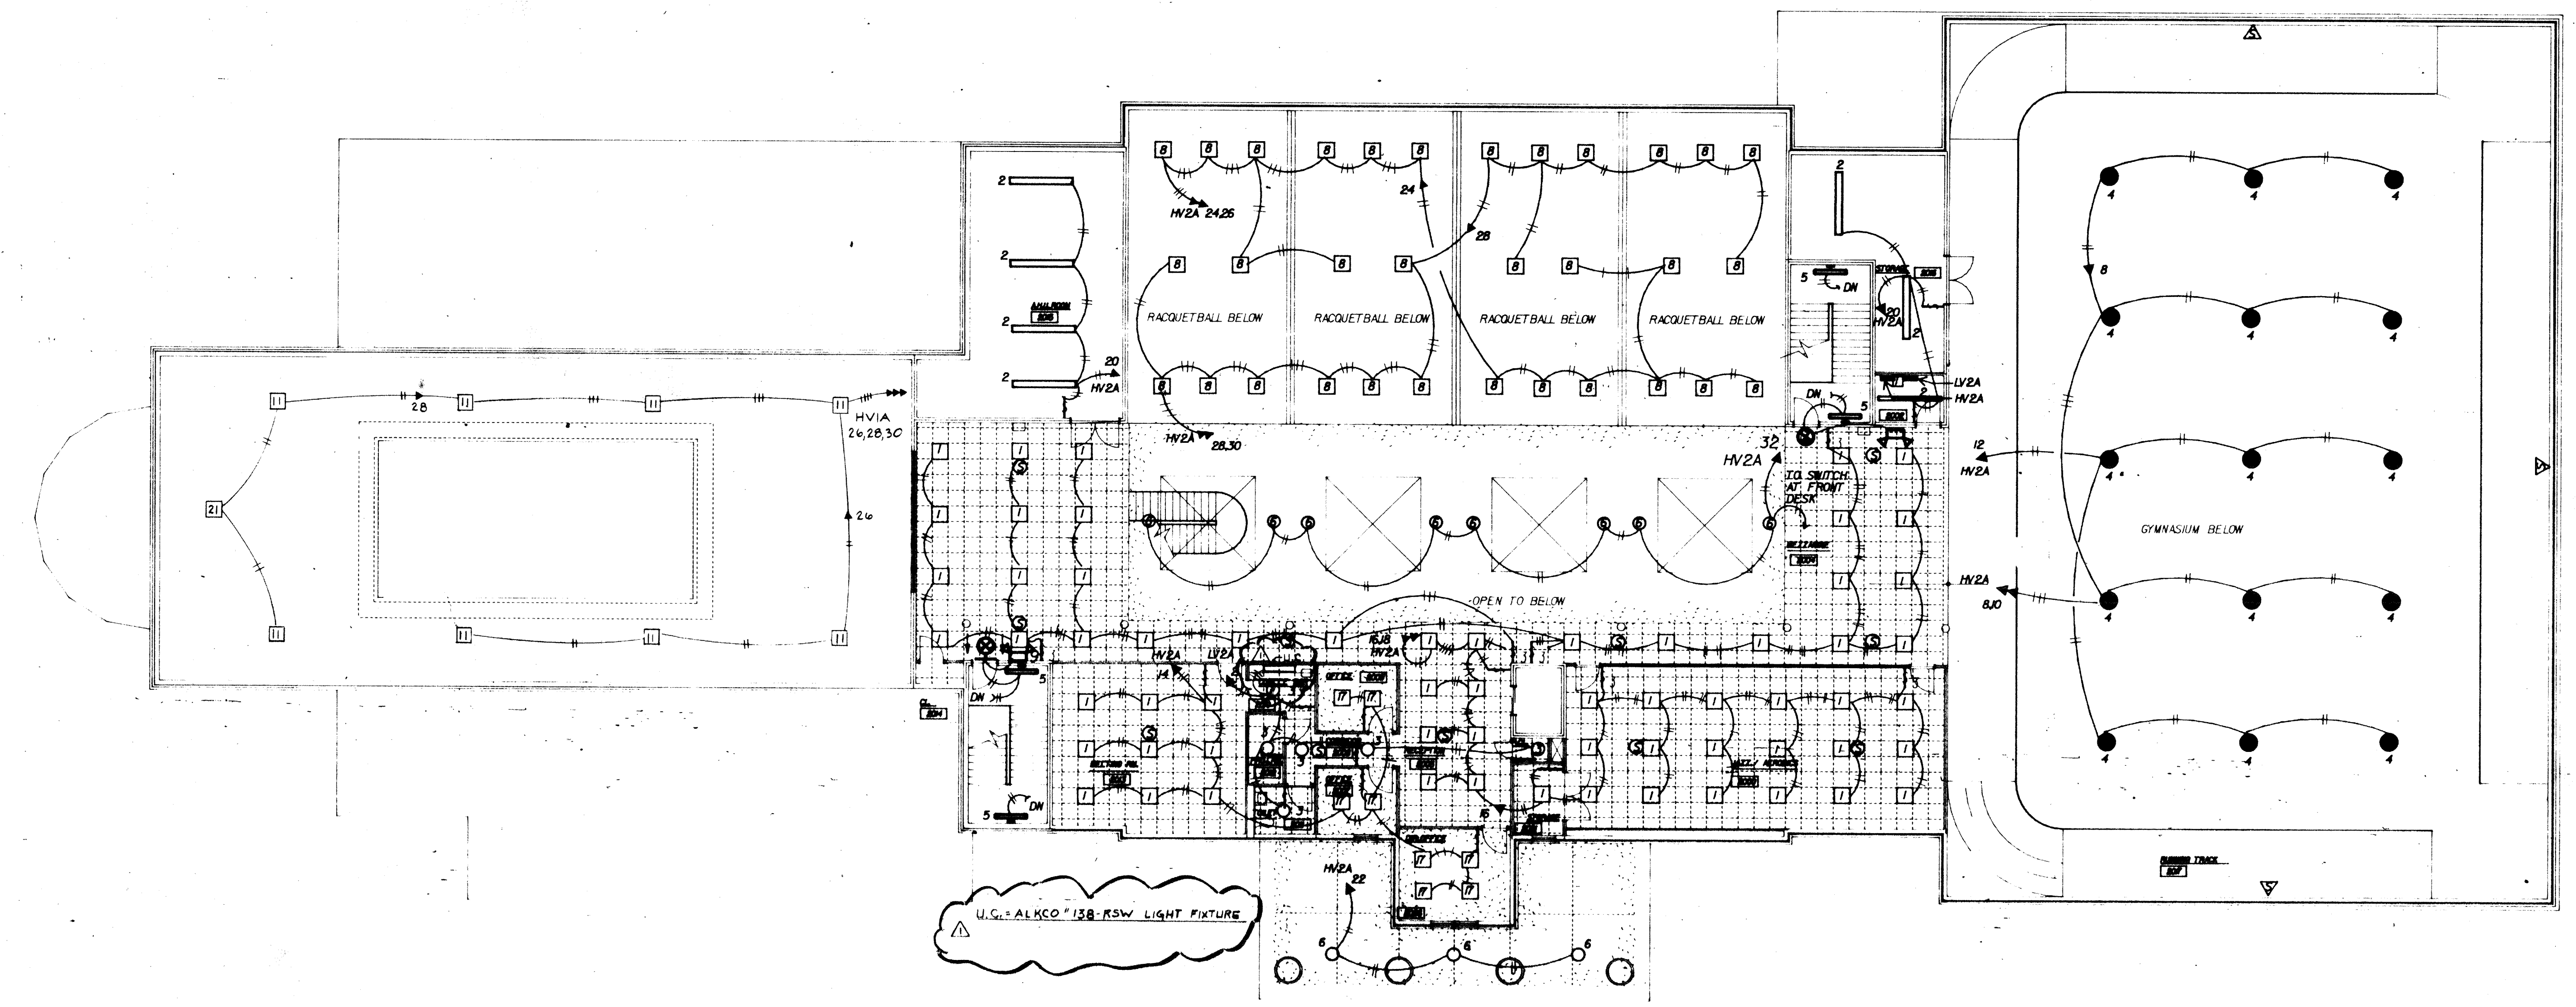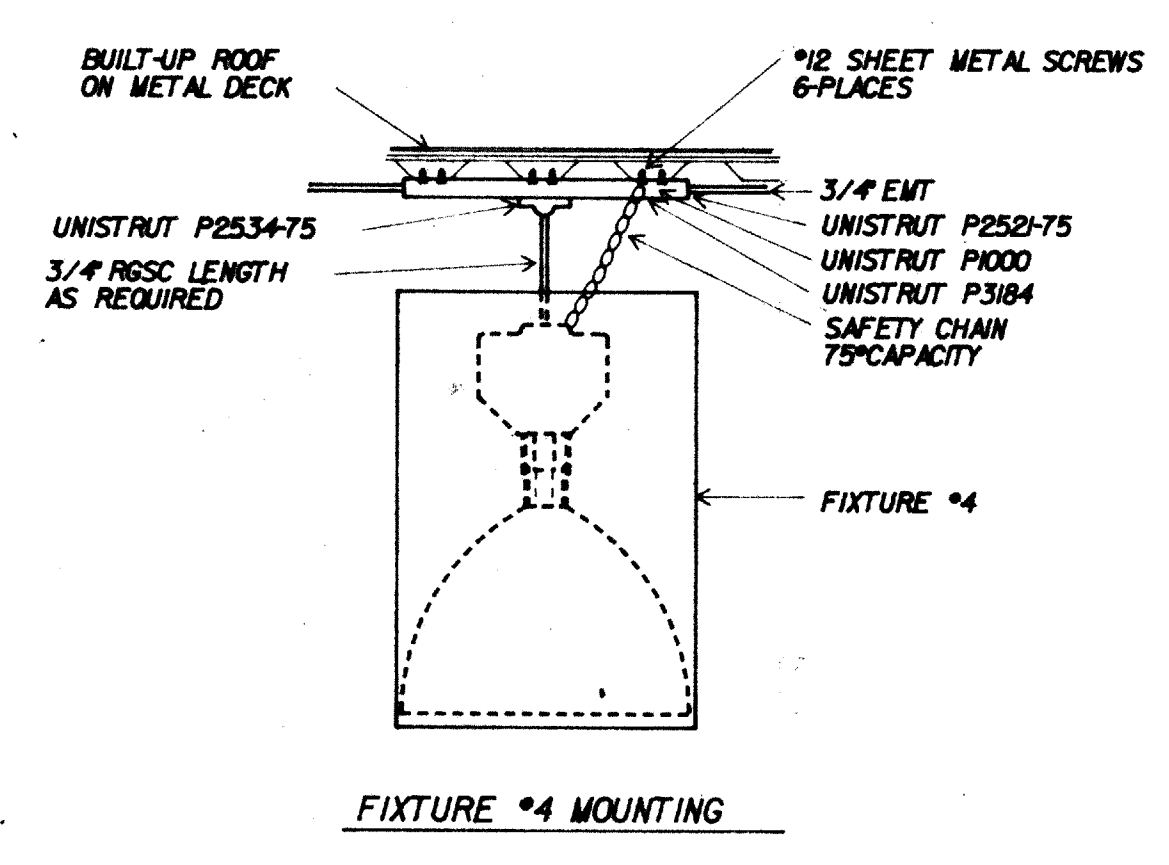

**SECOND FLOOR PLAN**  
 SCALE: 3/32"=1'-0"