


SHEET NO.	
BASE	
C	
L	
A	
S	
M	
E	
COMPOSITE	

**ADDISON RECREATION CENTER**  
 3900 BELTWAY DRIVE  
 ADDISON, TEXAS

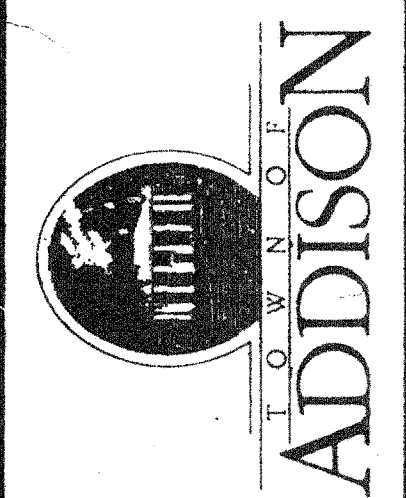


Phyllis Engineering  
 HVAC & Mechanical  
 Consulting Engineers  
 Dallas, Texas  
 P.E. No. 988-0207  
 01/16/97

GROUND FLOOR  
 HVAC PLAN

drawn: MLC  
 checked: \_\_\_\_\_  
 date: 1/16/97  
 REVISIONS

no. \_\_\_\_\_ date \_\_\_\_\_

ME-2A

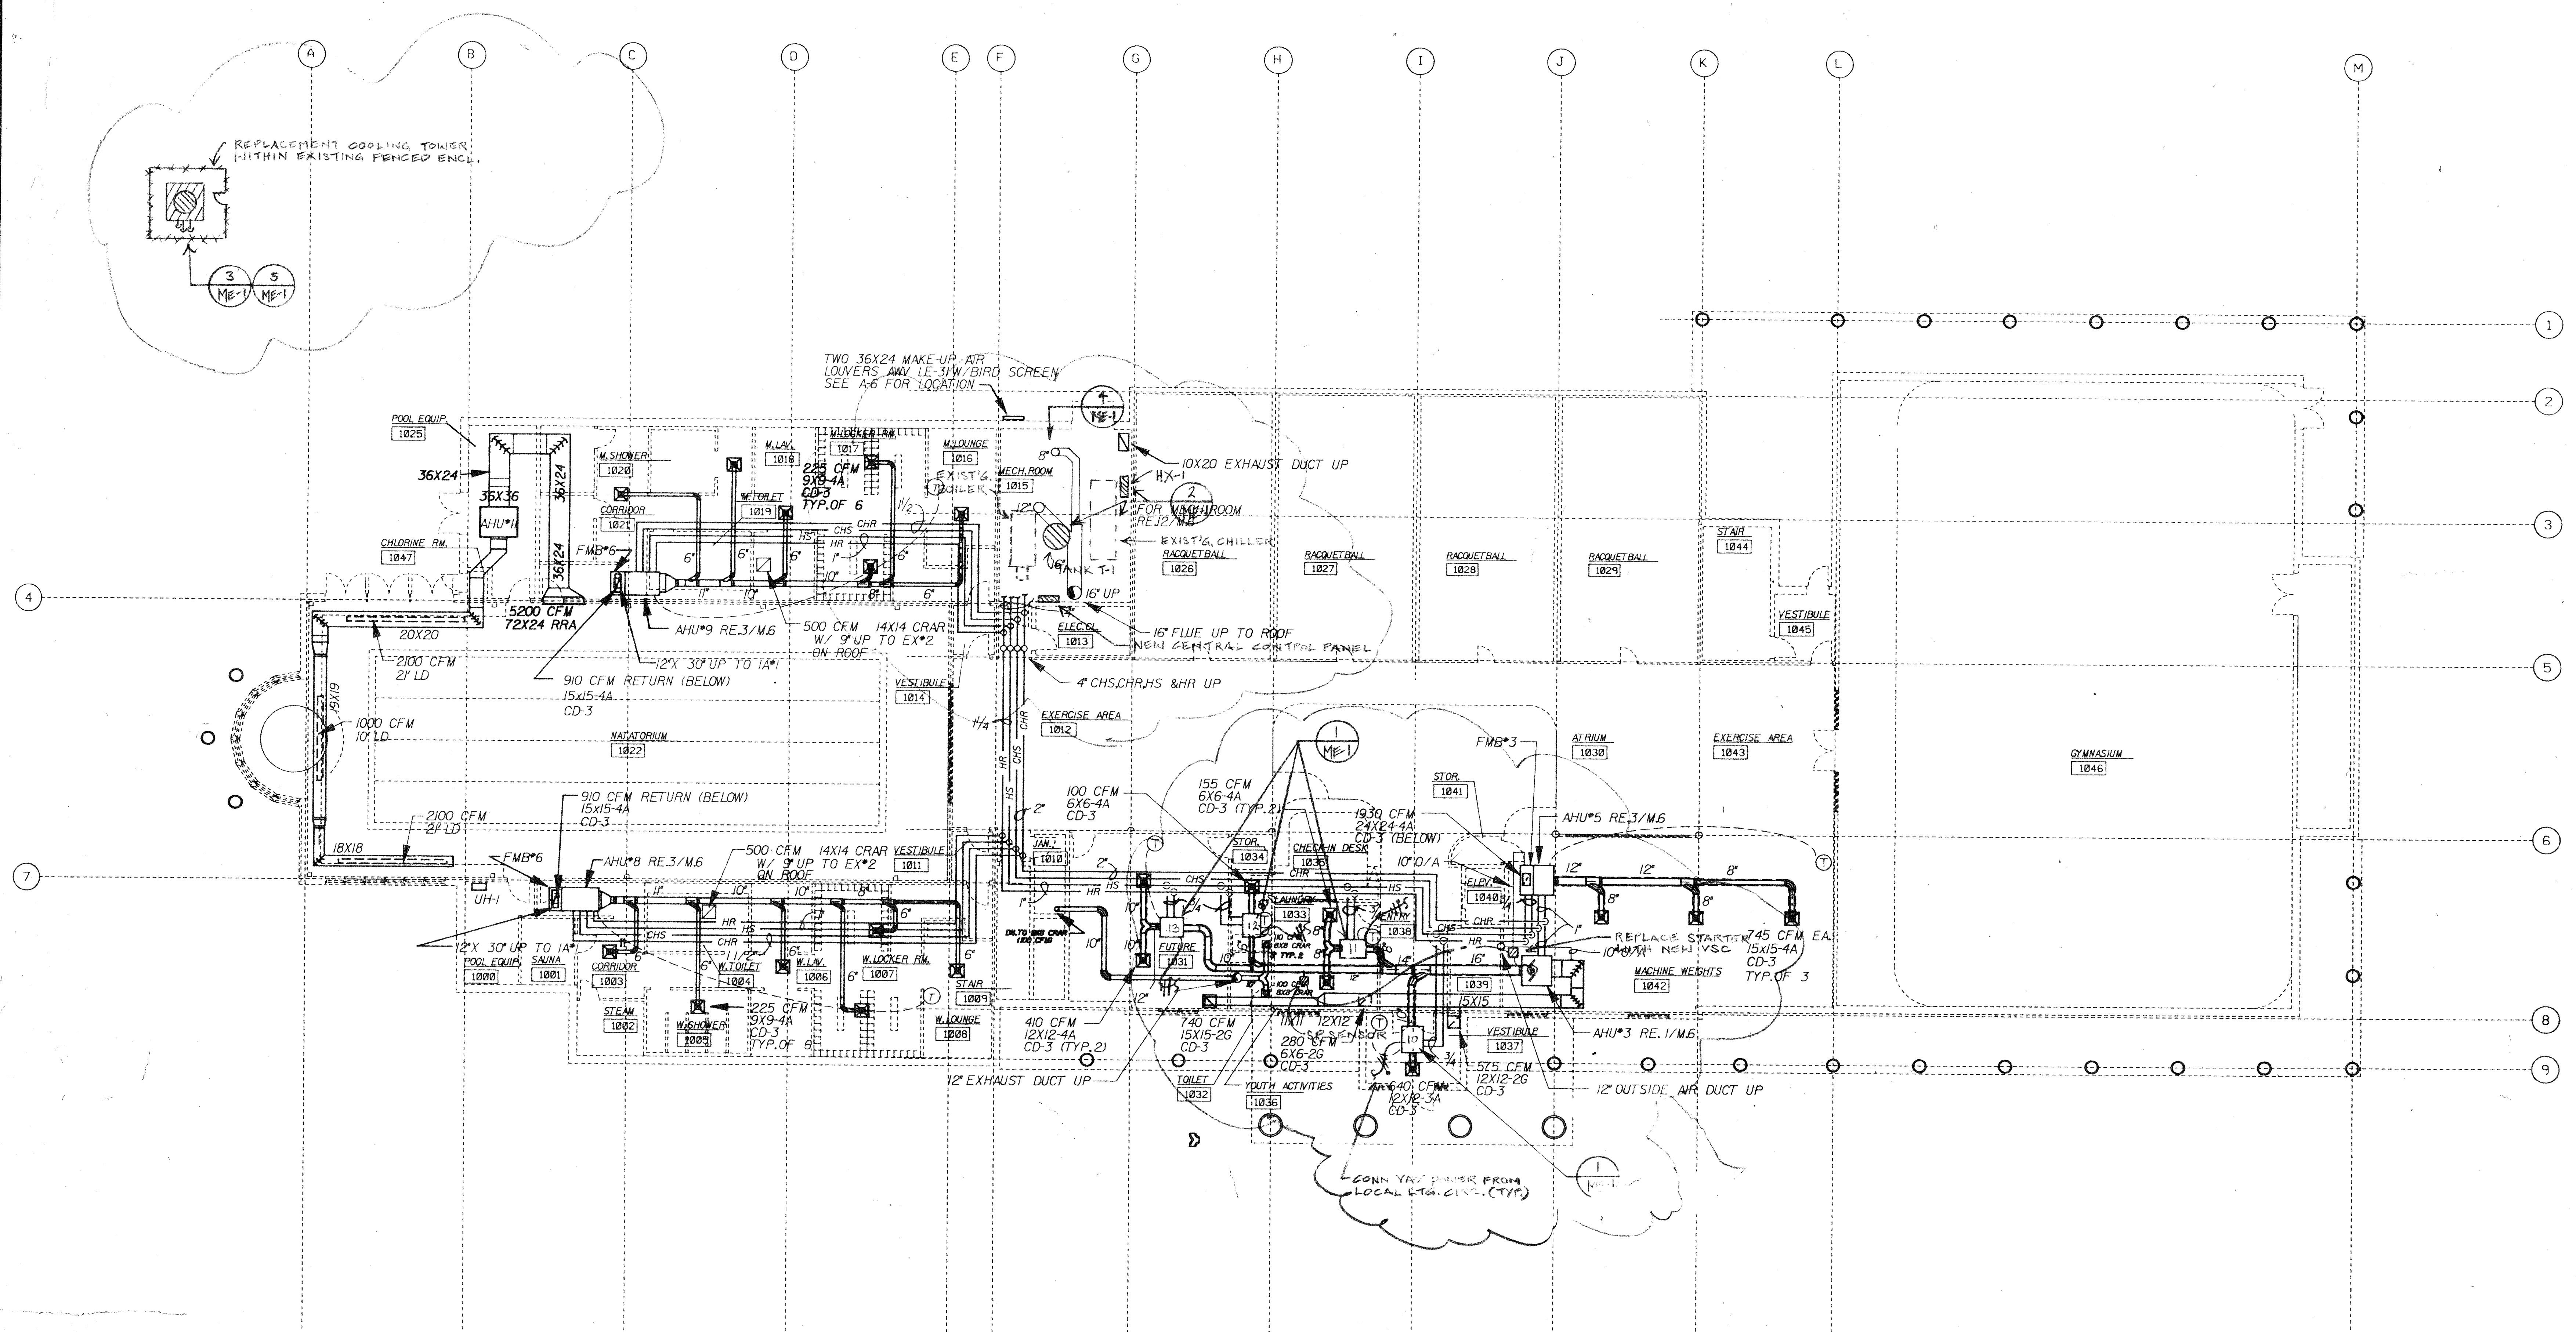

**GROUND FLOOR HVAC PLAN**

SCALE: 3/32"=1'-0"



NEW WORK SHOWN  
 WITHIN CLOUDS