


INDEX TO DRAWINGS

SHT.	DESCRIPTION
C-1	Cover Sheet
C-2	Site Layout
C-3	Grading and Yard Piping Plan
C-4	Yard Piping Profiles
C-5	Sanitary Sewer
C-6	Piping Plan
C-7	Flow Meter Vault and Details
C-8	Miscellaneous Details - Paving
C-9	Miscellaneous Details - Drainage
C-10	Miscellaneous Details - Water
C-11	Miscellaneous Details - Site Work
A-1	Floor and Roof Plan
A-2	Elevations
A-3	Sections and Details
A-4	Details
S-1	Foundation Plan
S-2	Roof Framing Plan & Framing Details
S-3	Foundation Details
S-4	Typical Details & General Notes
S-5	Pump Room Floor Sections & Details
M-1	Mechanical - HVAC
E-1	Legend
E-2	Site Plan
E-3	4160V One Line Diagram
E-4	208V One Line Diagram
E-5	Control Schematics
E-6	Control Schematics
E-7	Schedules
E-8	Plan View - Power & Control
E-9	Plan View - Lighting & HVAC
E-10	Details
E-11	Details
E-12	Details
I-1	Instrumentation Diagram
I-2	Instrumentation Schedules
I-3	Instrumentation Details

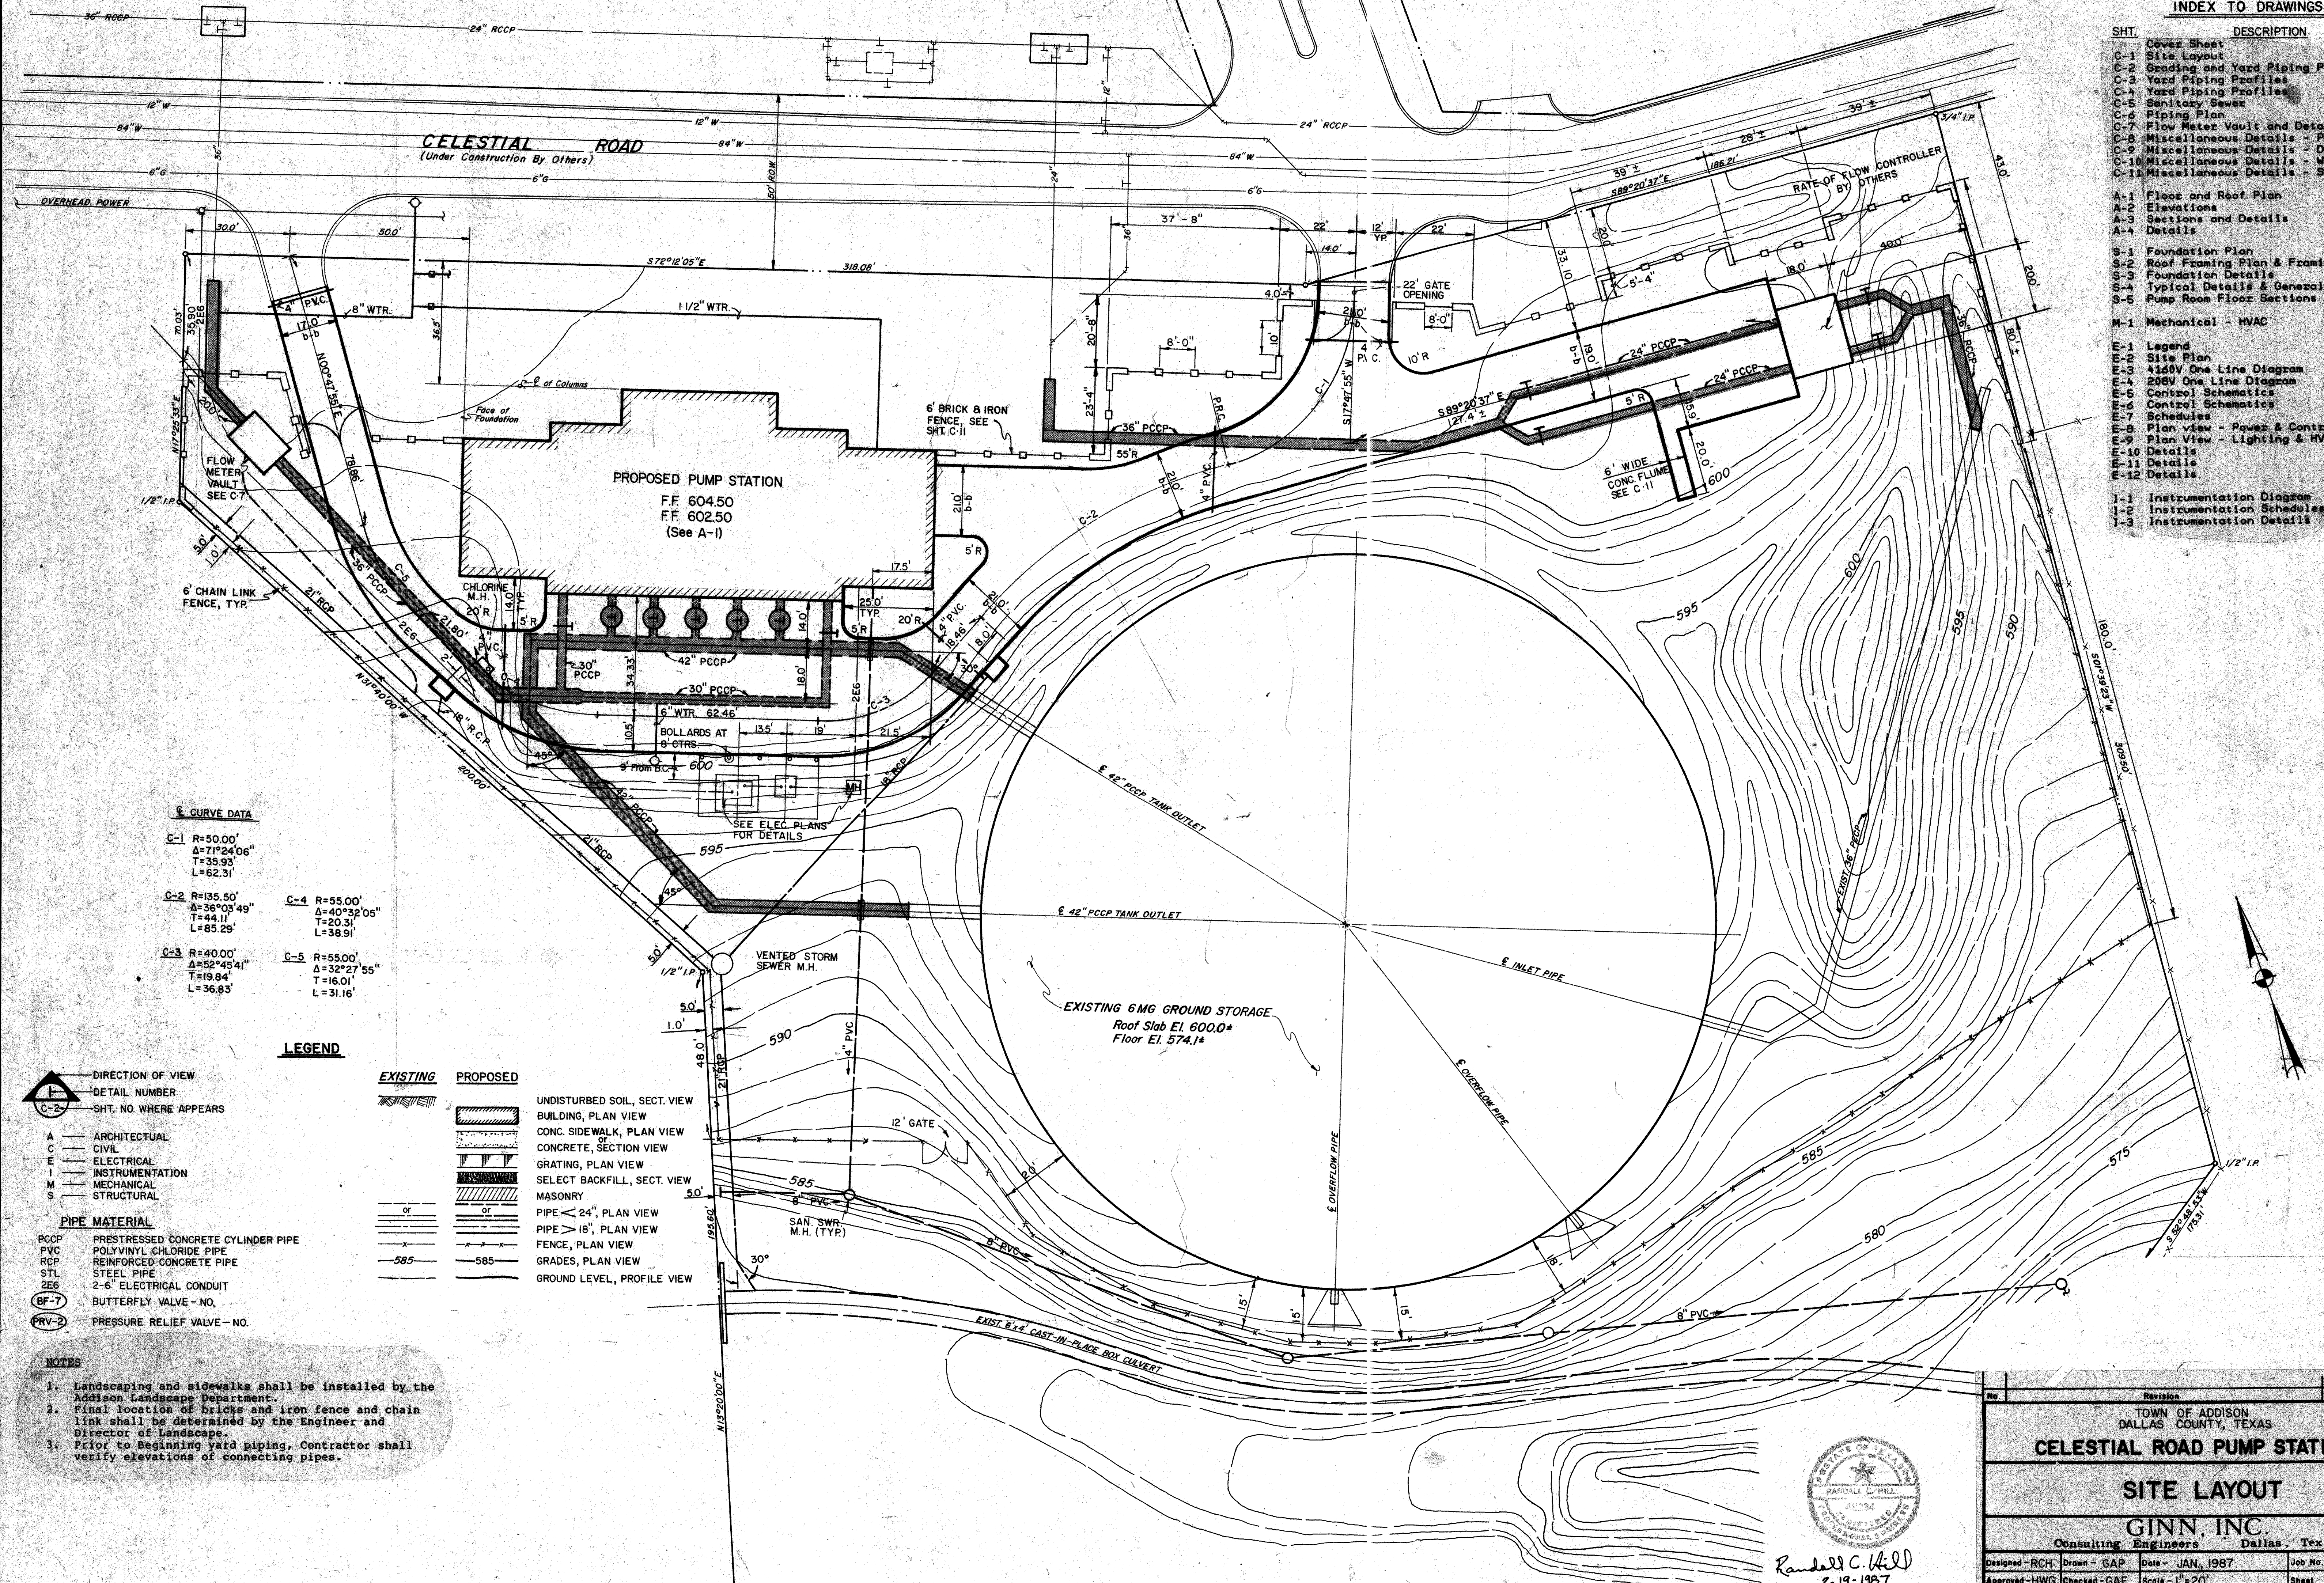

CURVE DATA

C-1	R=50.00'	Δ=71°24'06"	T=35.93'	L=62.31'
C-2	R=135.50'	Δ=36°03'49"	T=44.11'	L=85.29'
C-3	R=40.00'	Δ=52°45'41"	T=19.84'	L=36.83'
C-4	R=55.00'	Δ=40°32'05"	T=20.31'	L=38.91'
C-5	R=55.00'	Δ=32°27'55"	T=16.01'	L=31.16'

LEGEND

DIRECTION OF VIEW	DETAIL NUMBER	SHT. NO. WHERE APPEARS	EXISTING	PROPOSED	DESCRIPTION
A					UNDISTURBED SOIL, SECT. VIEW
C					BUILDING, PLAN VIEW
E					CONC. SIDEWALK, PLAN VIEW
I					CONCRETE, SECTION VIEW
M					GRATING, PLAN VIEW
S					SELECT BACKFILL, SECT. VIEW
					MASONRY
					PIPE < 24", PLAN VIEW
					PIPE > 18", PLAN VIEW
					FENCE, PLAN VIEW
					GRADES, PLAN VIEW
					GROUND LEVEL, PROFILE VIEW

- NOTES**
- Landscaping and sidewalks shall be installed by the Addison Landscape Department.
 - Final location of bricks and iron fence and chain link shall be determined by the Engineer and Director of Landscape.
 - Prior to beginning yard piping, Contractor shall verify elevations of connecting pipes.

Randall C. Hill
 2-19-1987

No.	Revision	By	Date
TOWN OF ADDISON DALLAS COUNTY, TEXAS			
CELESTIAL ROAD PUMP STATION			
SITE LAYOUT			
GINN, INC. Consulting Engineers Dallas, Texas			
Designed - RCH	Drawn - GAP	Date - JAN, 1987	Job No. - 217
Approved - HWG	Checked - CAF	Scale - 1"=20'	Sheet - C-1 OF