




**SECTION 1**  
SCALE - 1/2" = 1'-0"

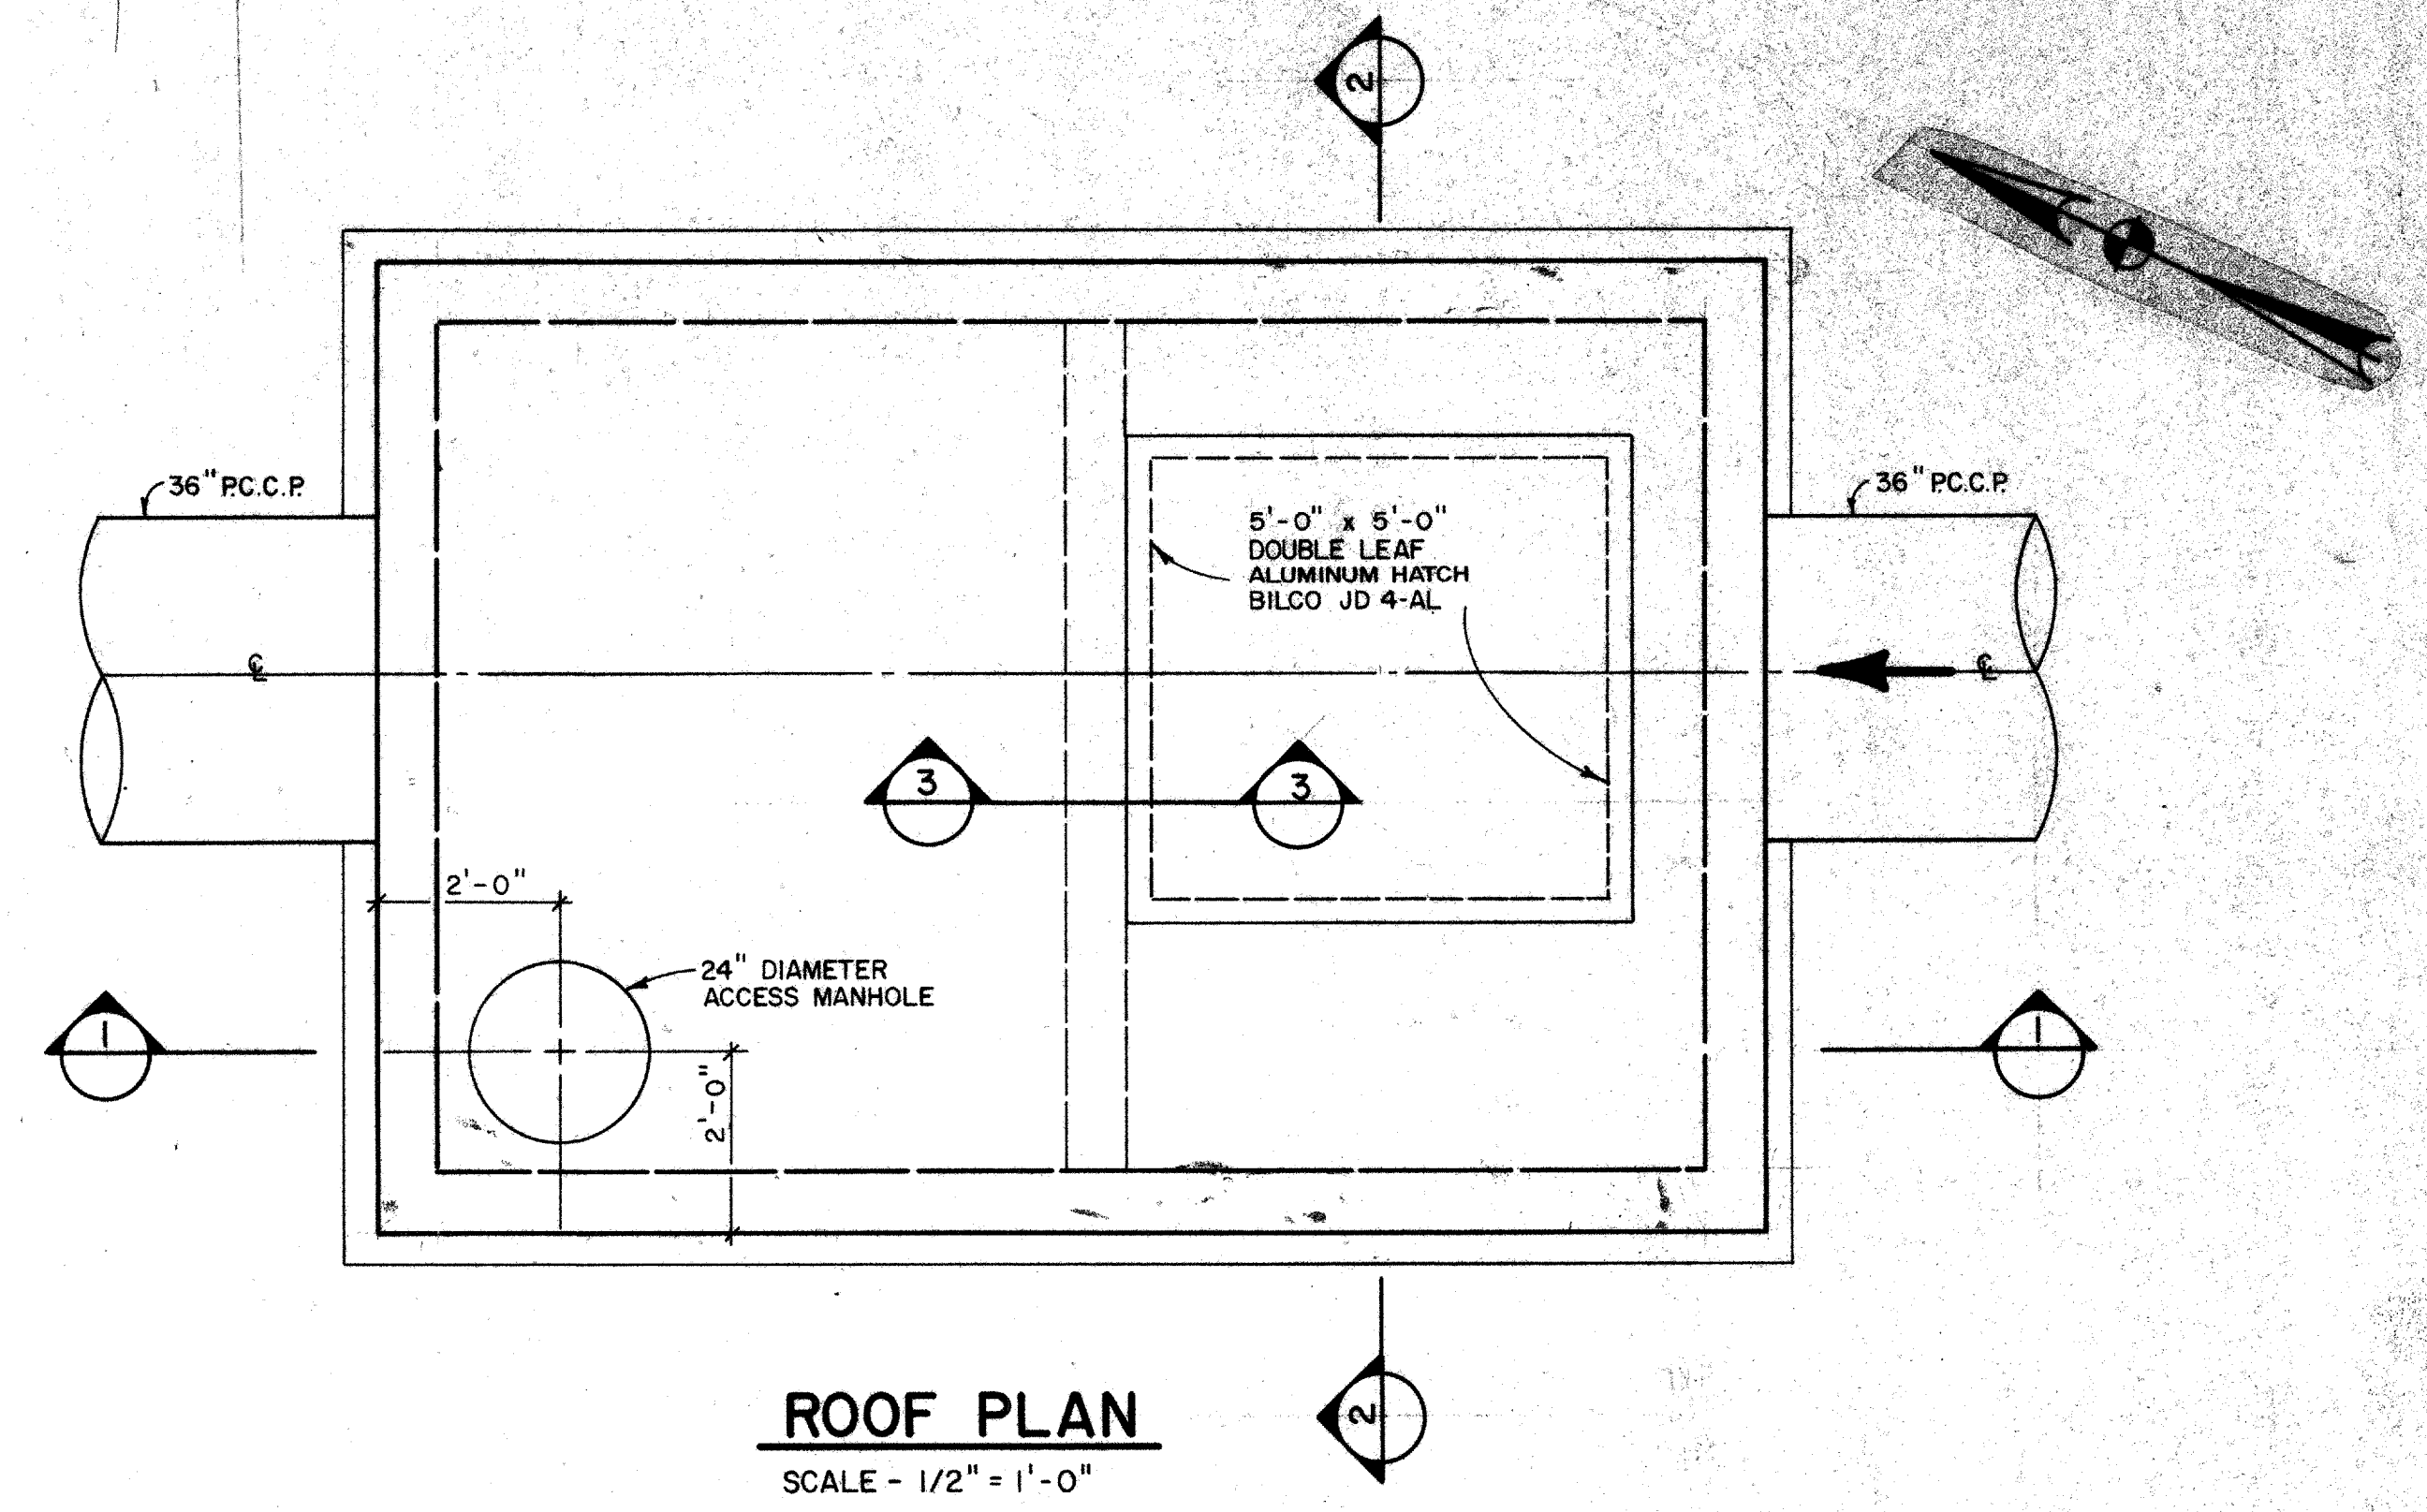


**ROOF PLAN**  
SCALE - 1/2" = 1'-0"

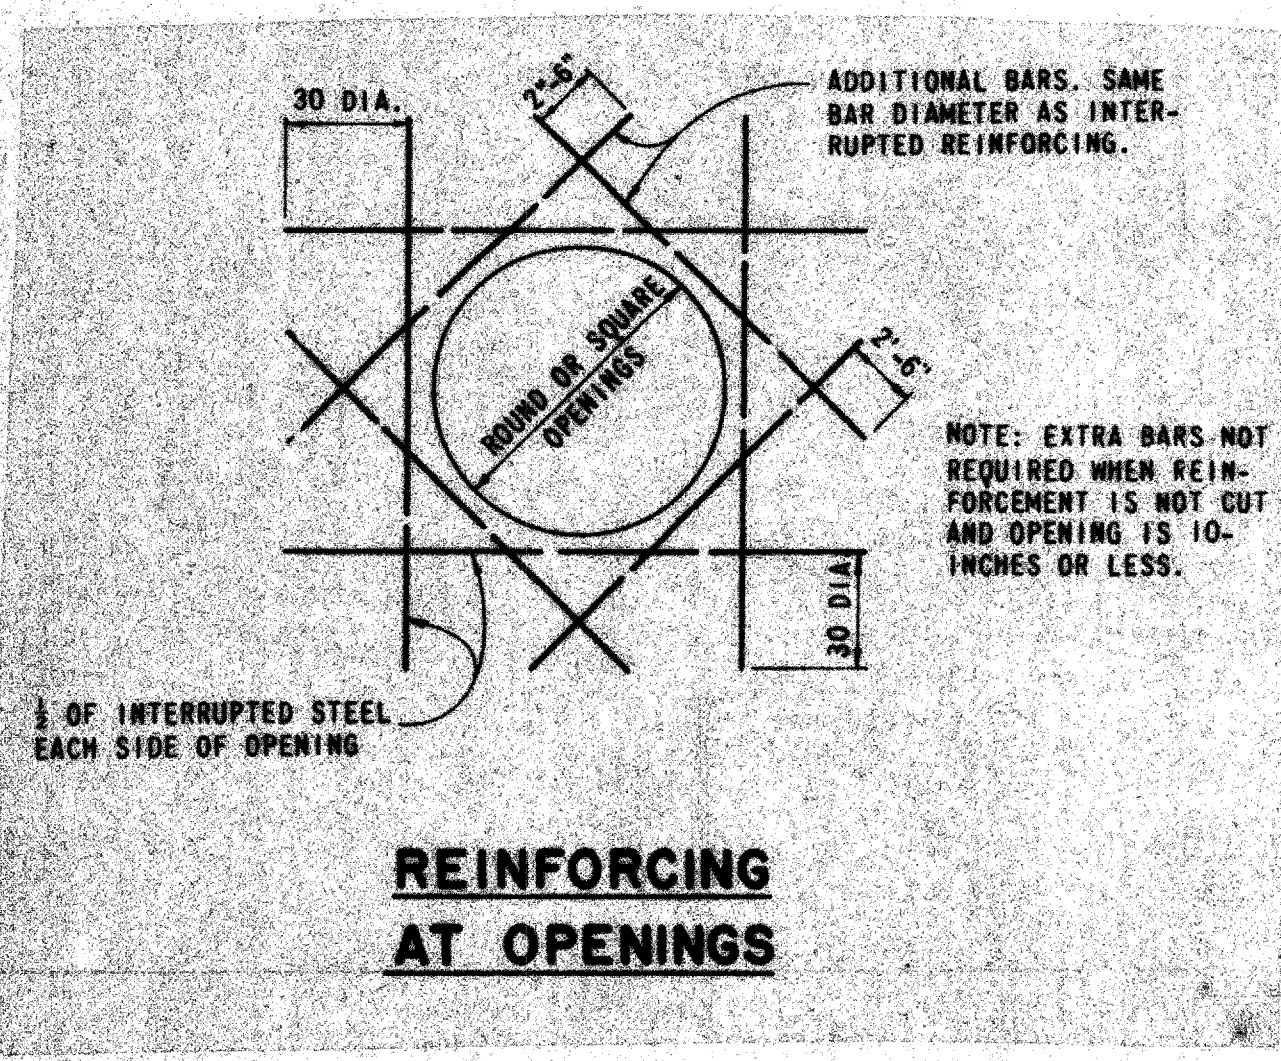


**REINFORCING AT OPENINGS**

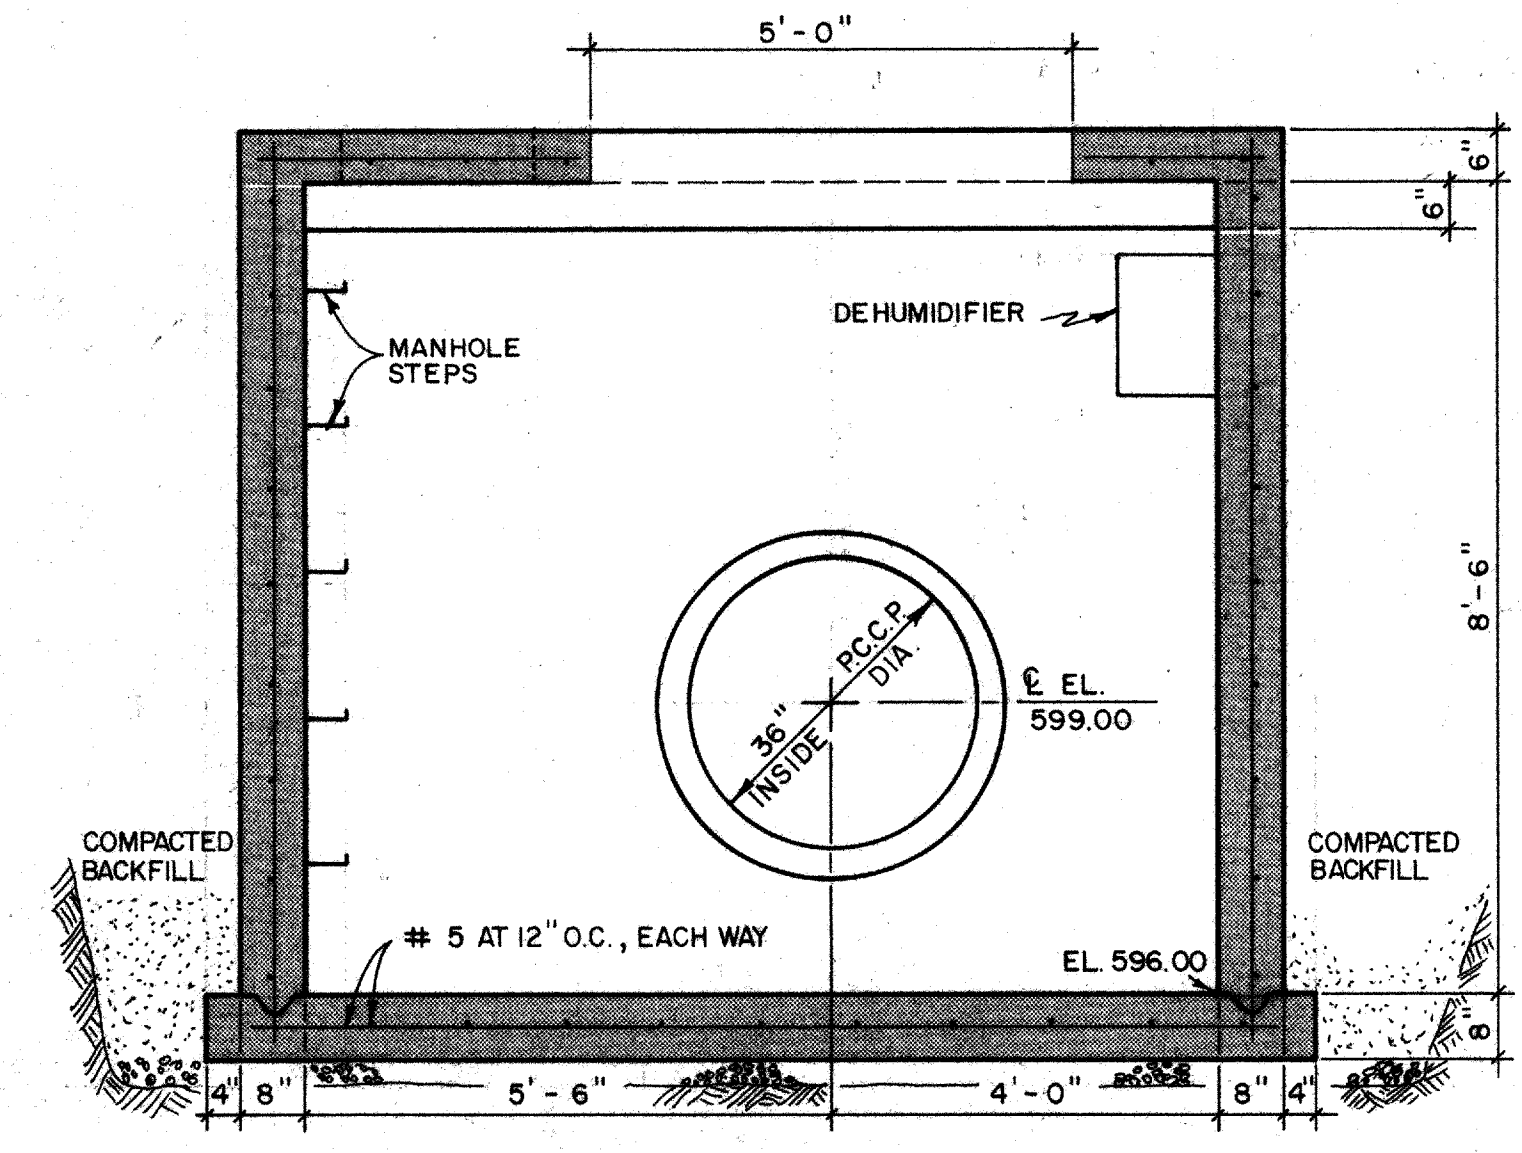


**SECTION 2**  
SCALE - 1/2" = 1'-0"

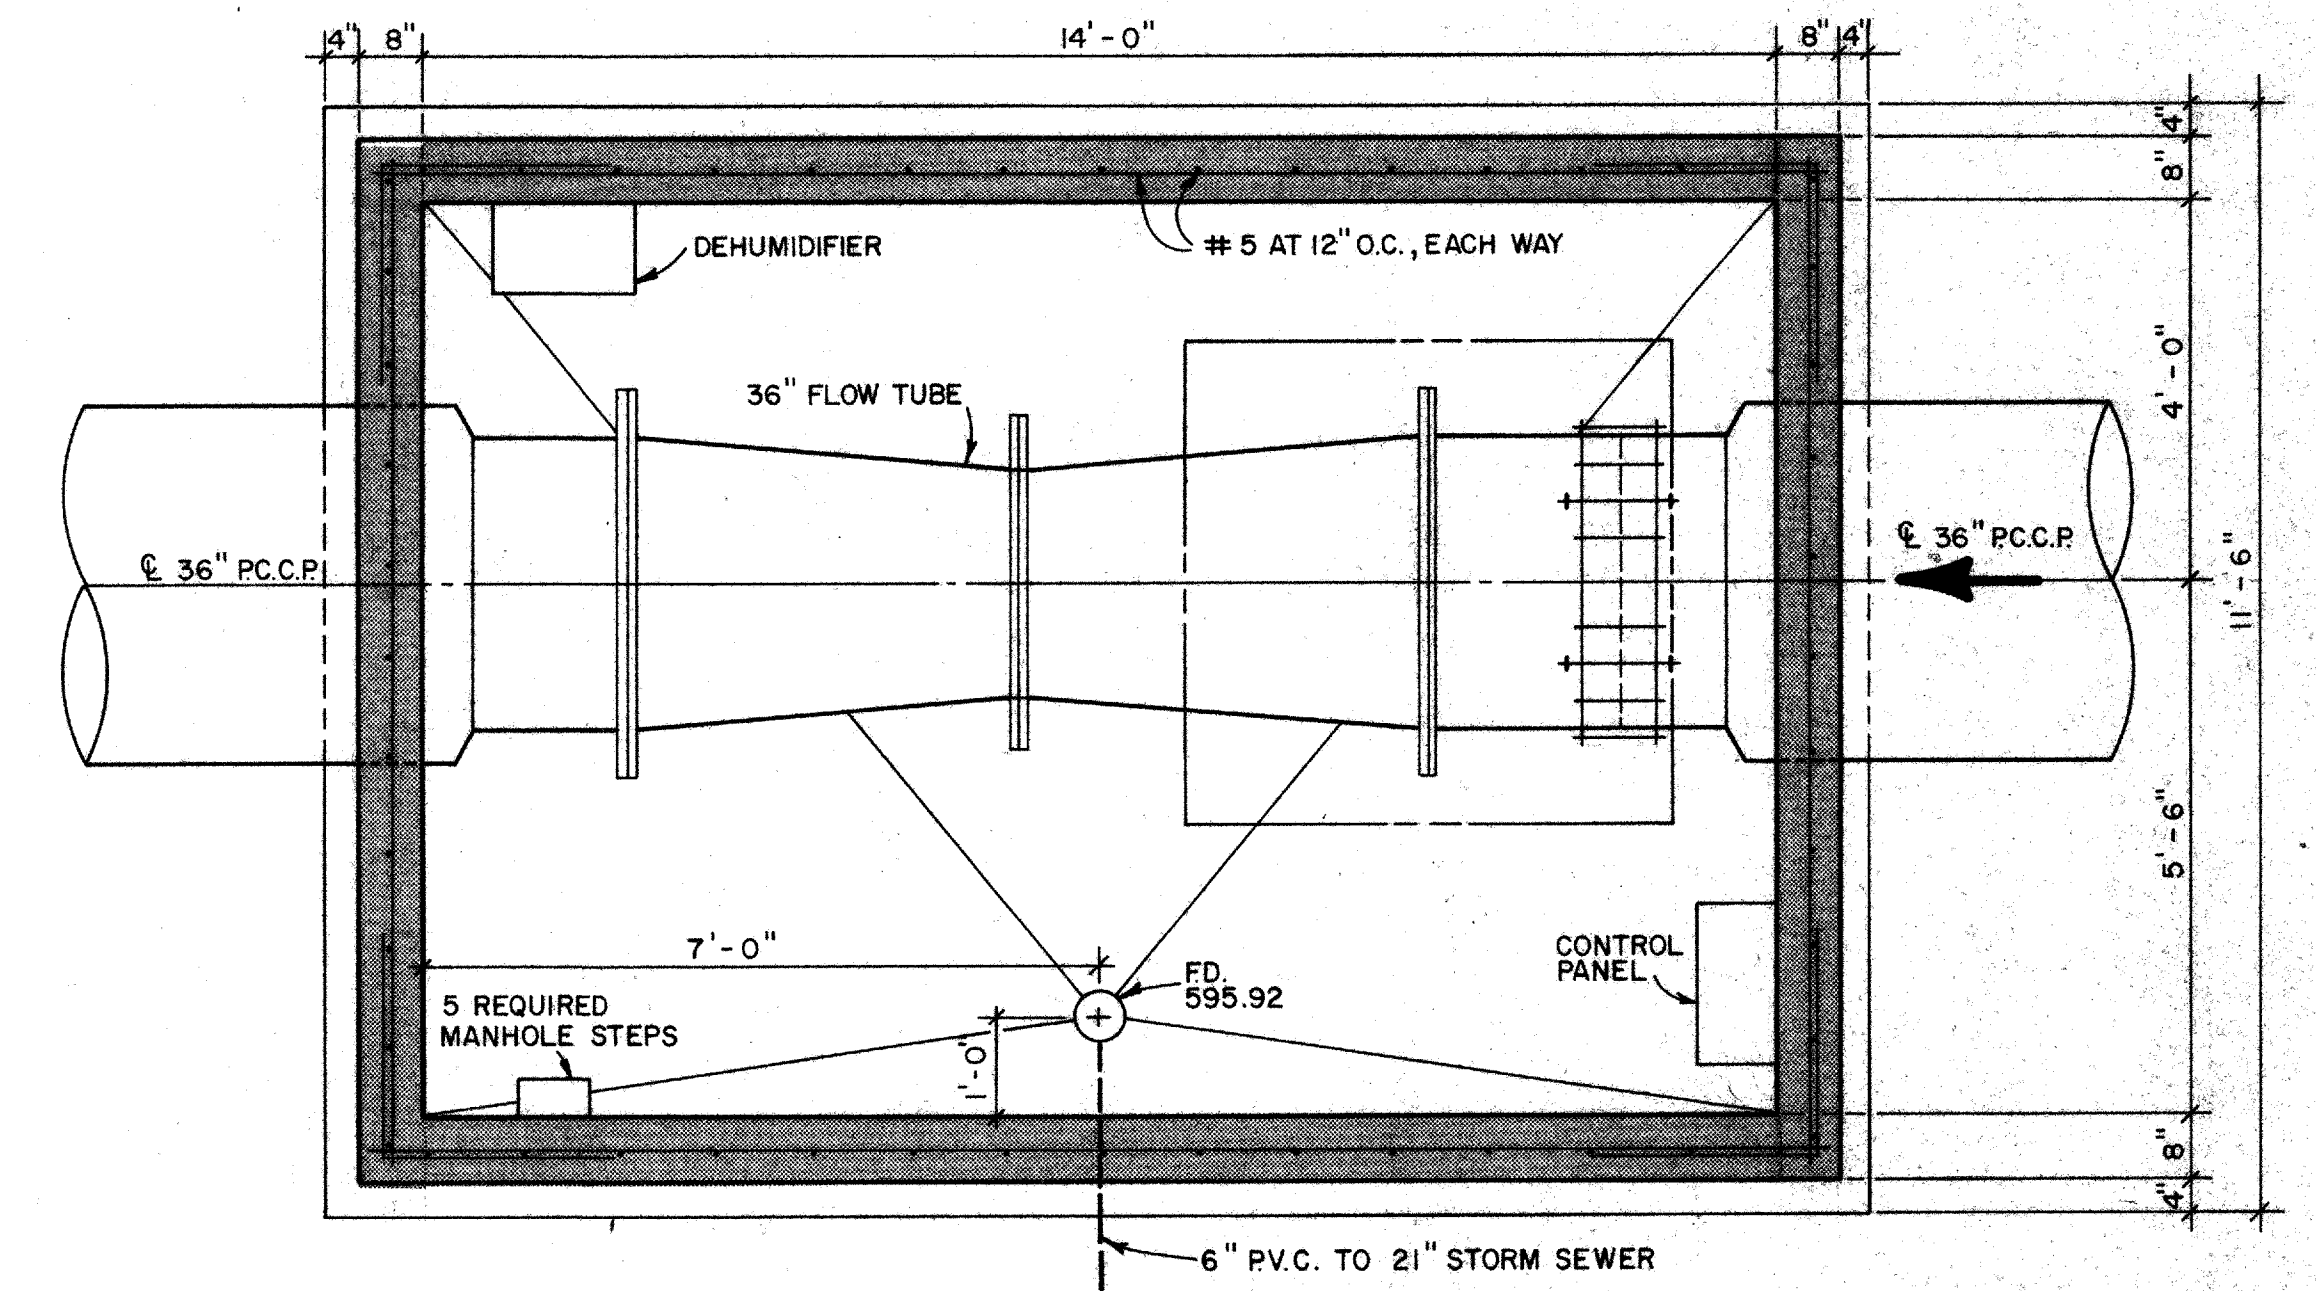


**SECTIONAL PLAN**  
SCALE - 1/2" = 1'-0"

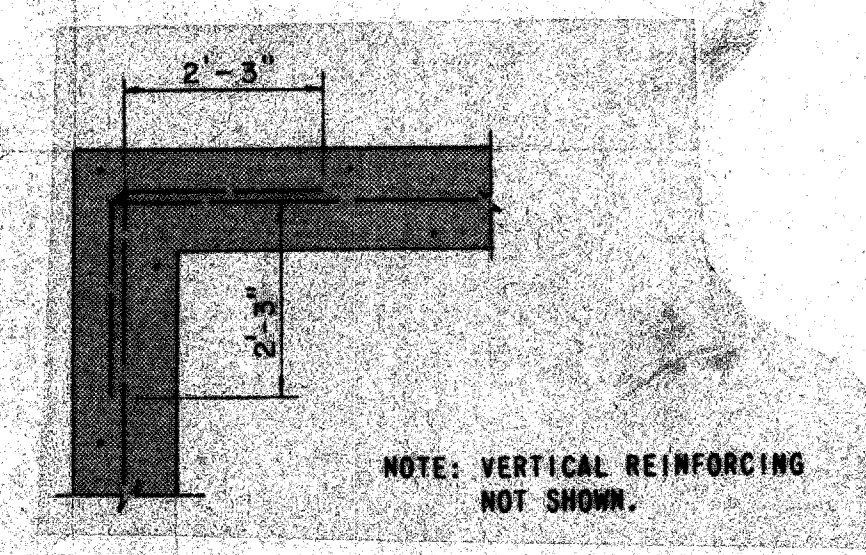

**TYPICAL CORNER REINFORCING DETAILS**  
(PLAN VIEW)

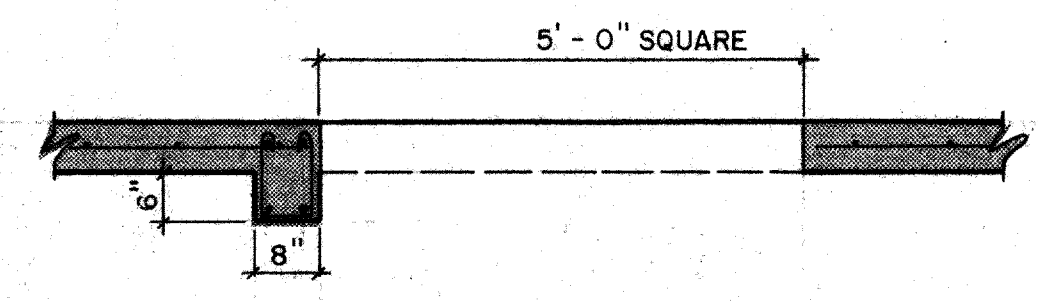

**SECTION 3**  
SCALE - 1/2" = 1'-0"

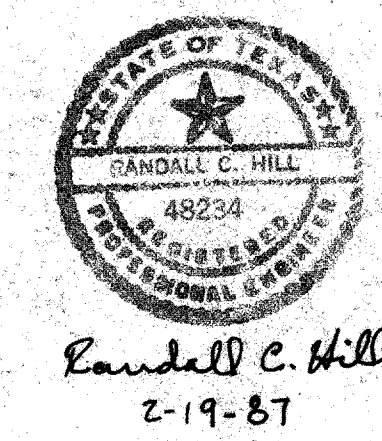

No.	Revision	By	Date
TOWN OF ADDISON DALLAS COUNTY, TEXAS			
<b>CELESTIAL ROAD PUMP STATION</b>			
<b>FLOW METER VAULT &amp; DETAILS</b>			
<b>GINN, INC.</b> Consulting Engineers Dallas, Texas			
Designed - R.C.H.	Drawn - B.S.	Date - JAN., 1987	Job No - 217
Approved - HWG	Checked - G.A.F.	Scale - AS SHOWN	Sheet C7

Randall C. Hill  
2-19-87