




1 SITE PLAN
SCALE 1" = 20'

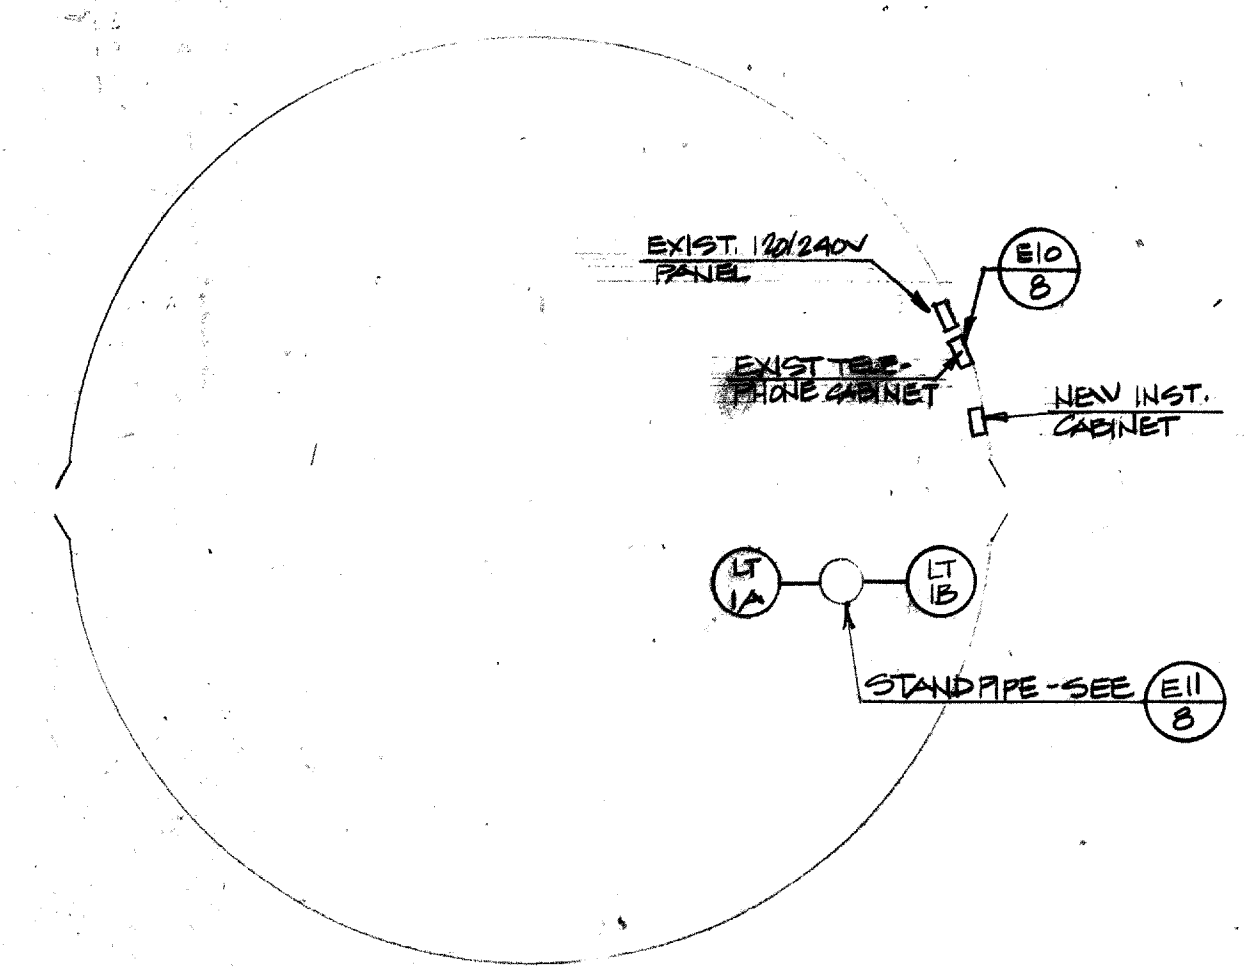

2 ELEVATED TANK PLAN
NO SCALE

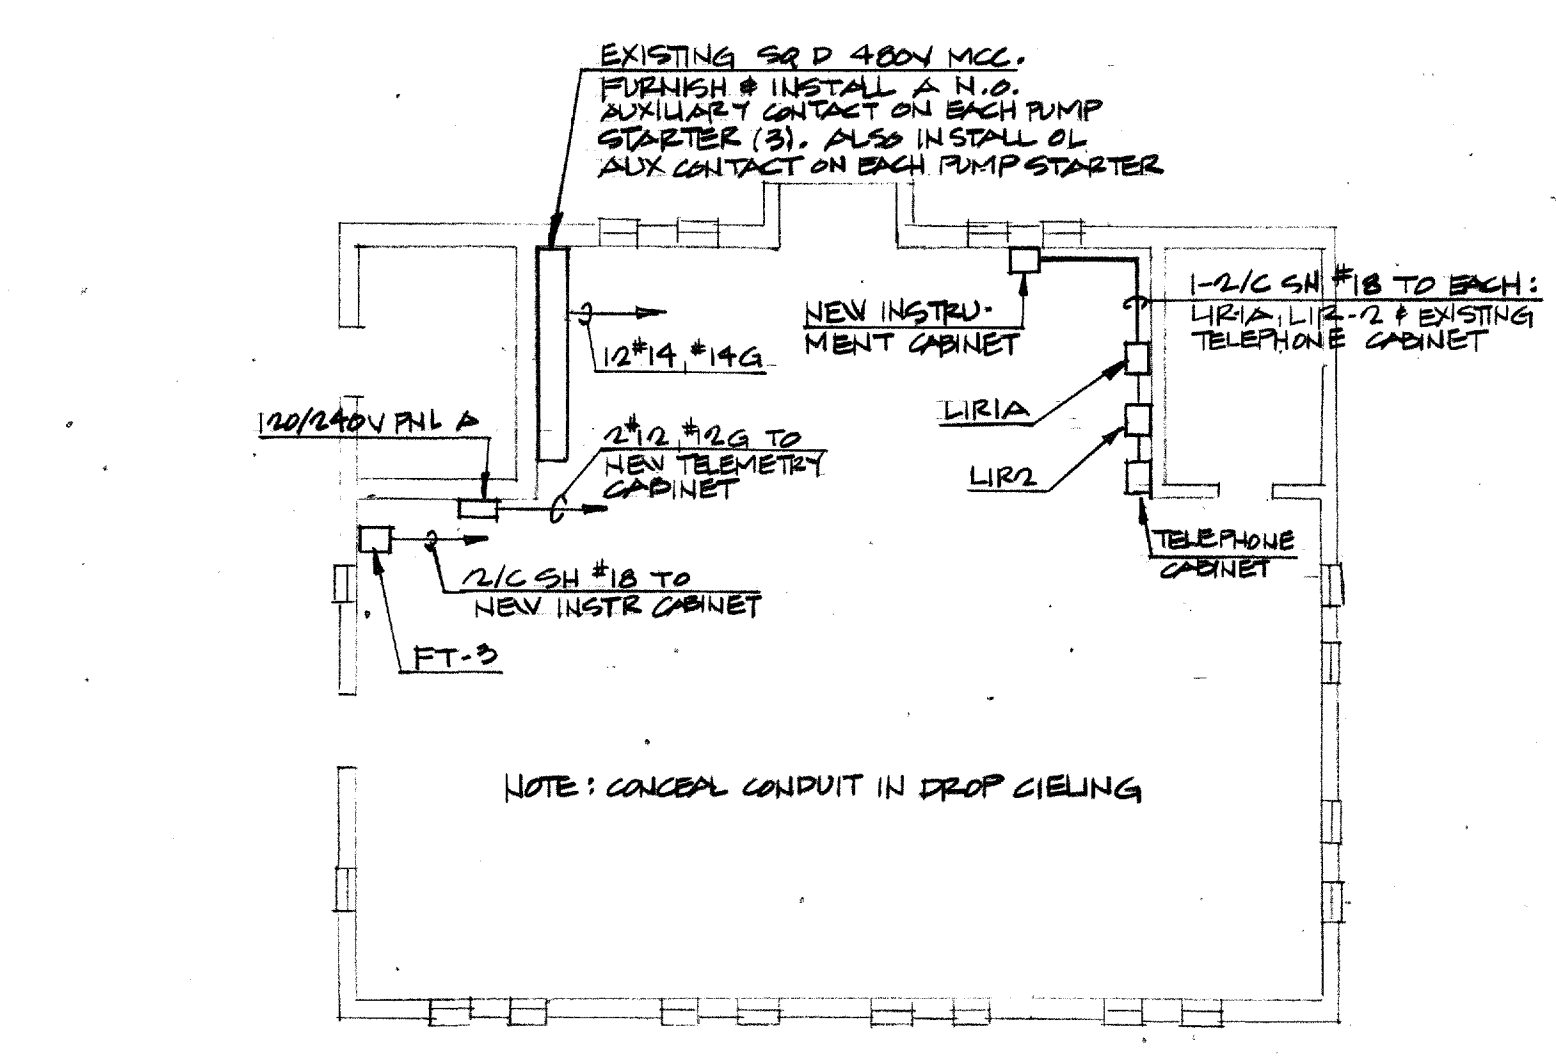

3 SURVEYOR PUMP STATION PLAN
NO SCALE

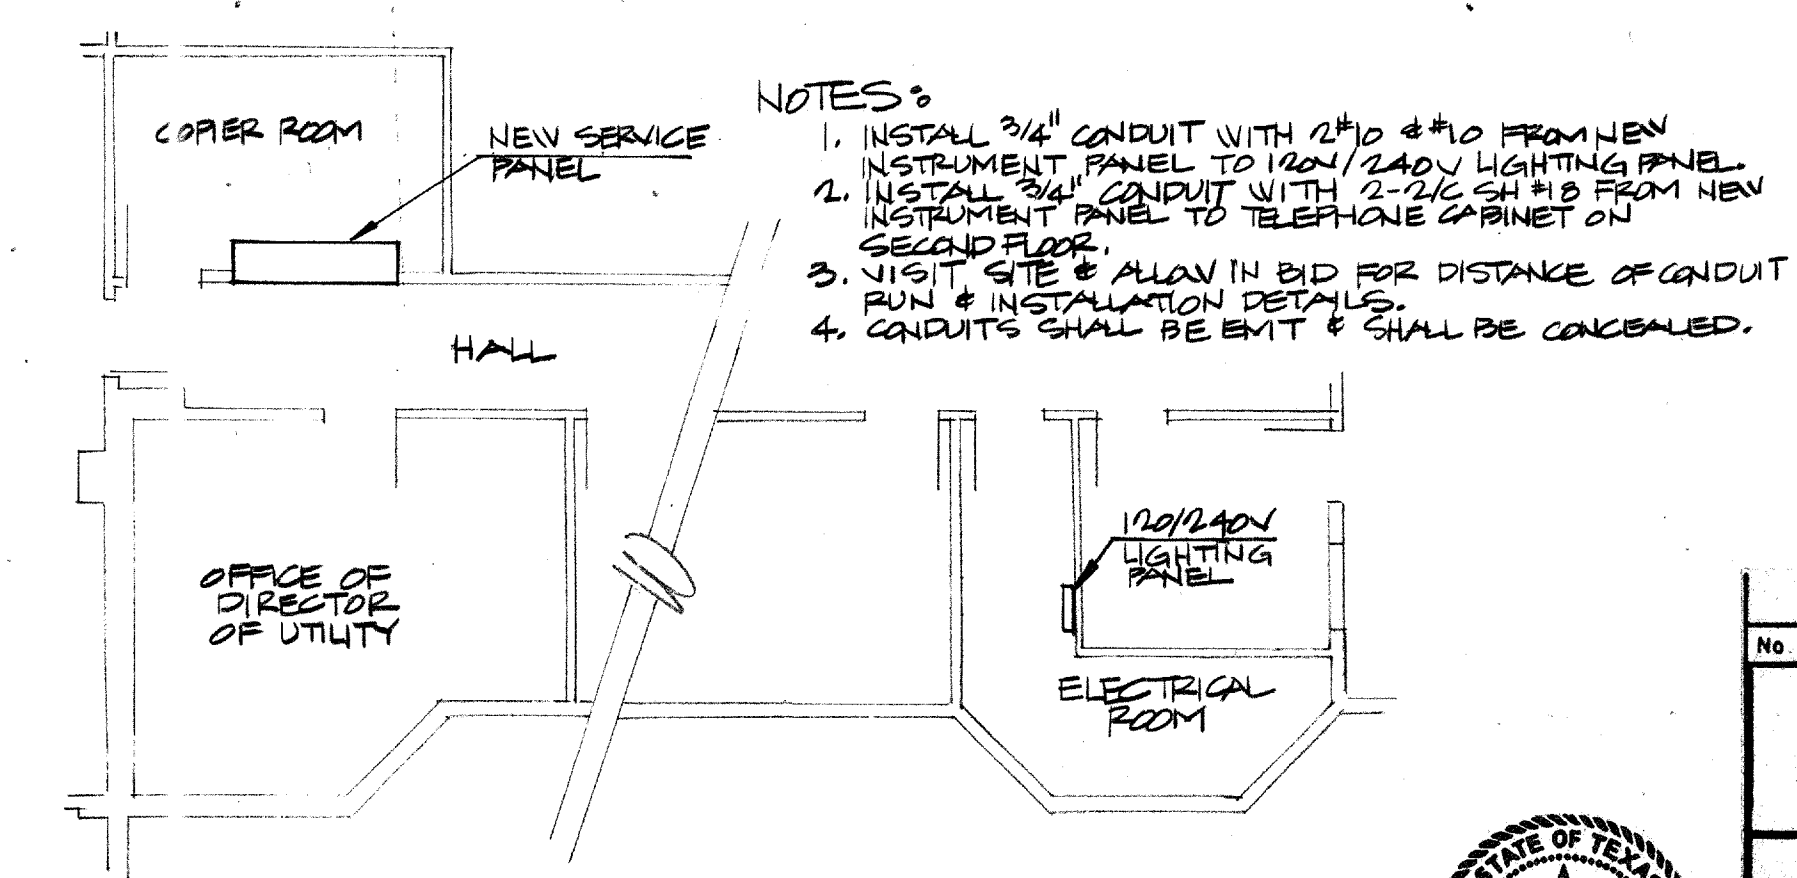

4 SERVICE CENTER PARTIAL PLAN
SCALE 1/8" = 1'-0"



No.	Revision	By	Date
TOWN OF ADDISON DALLAS COUNTY, TEXAS			
CELESTIAL ROAD PUMP STATION			
CHARLES R. McCREARY & ASSOCIATES CONSULTING ENGINEERS SUITE 317 6500 LAJ FREEWAY DALLAS, TEXAS 75240		ELECTRICAL SITE PLAN	
GINN, INC. Consulting Engineers Dallas, Texas			
Designed - JK	Drawn - JW	Date -	Job No. -
Approved -	Checked -	Scale -	Sheet E2 of E12

Joseph J. Kotrla
2-18-87