




4 SECTION-JUNCTION TERMINAL BOXES
NO SCALE

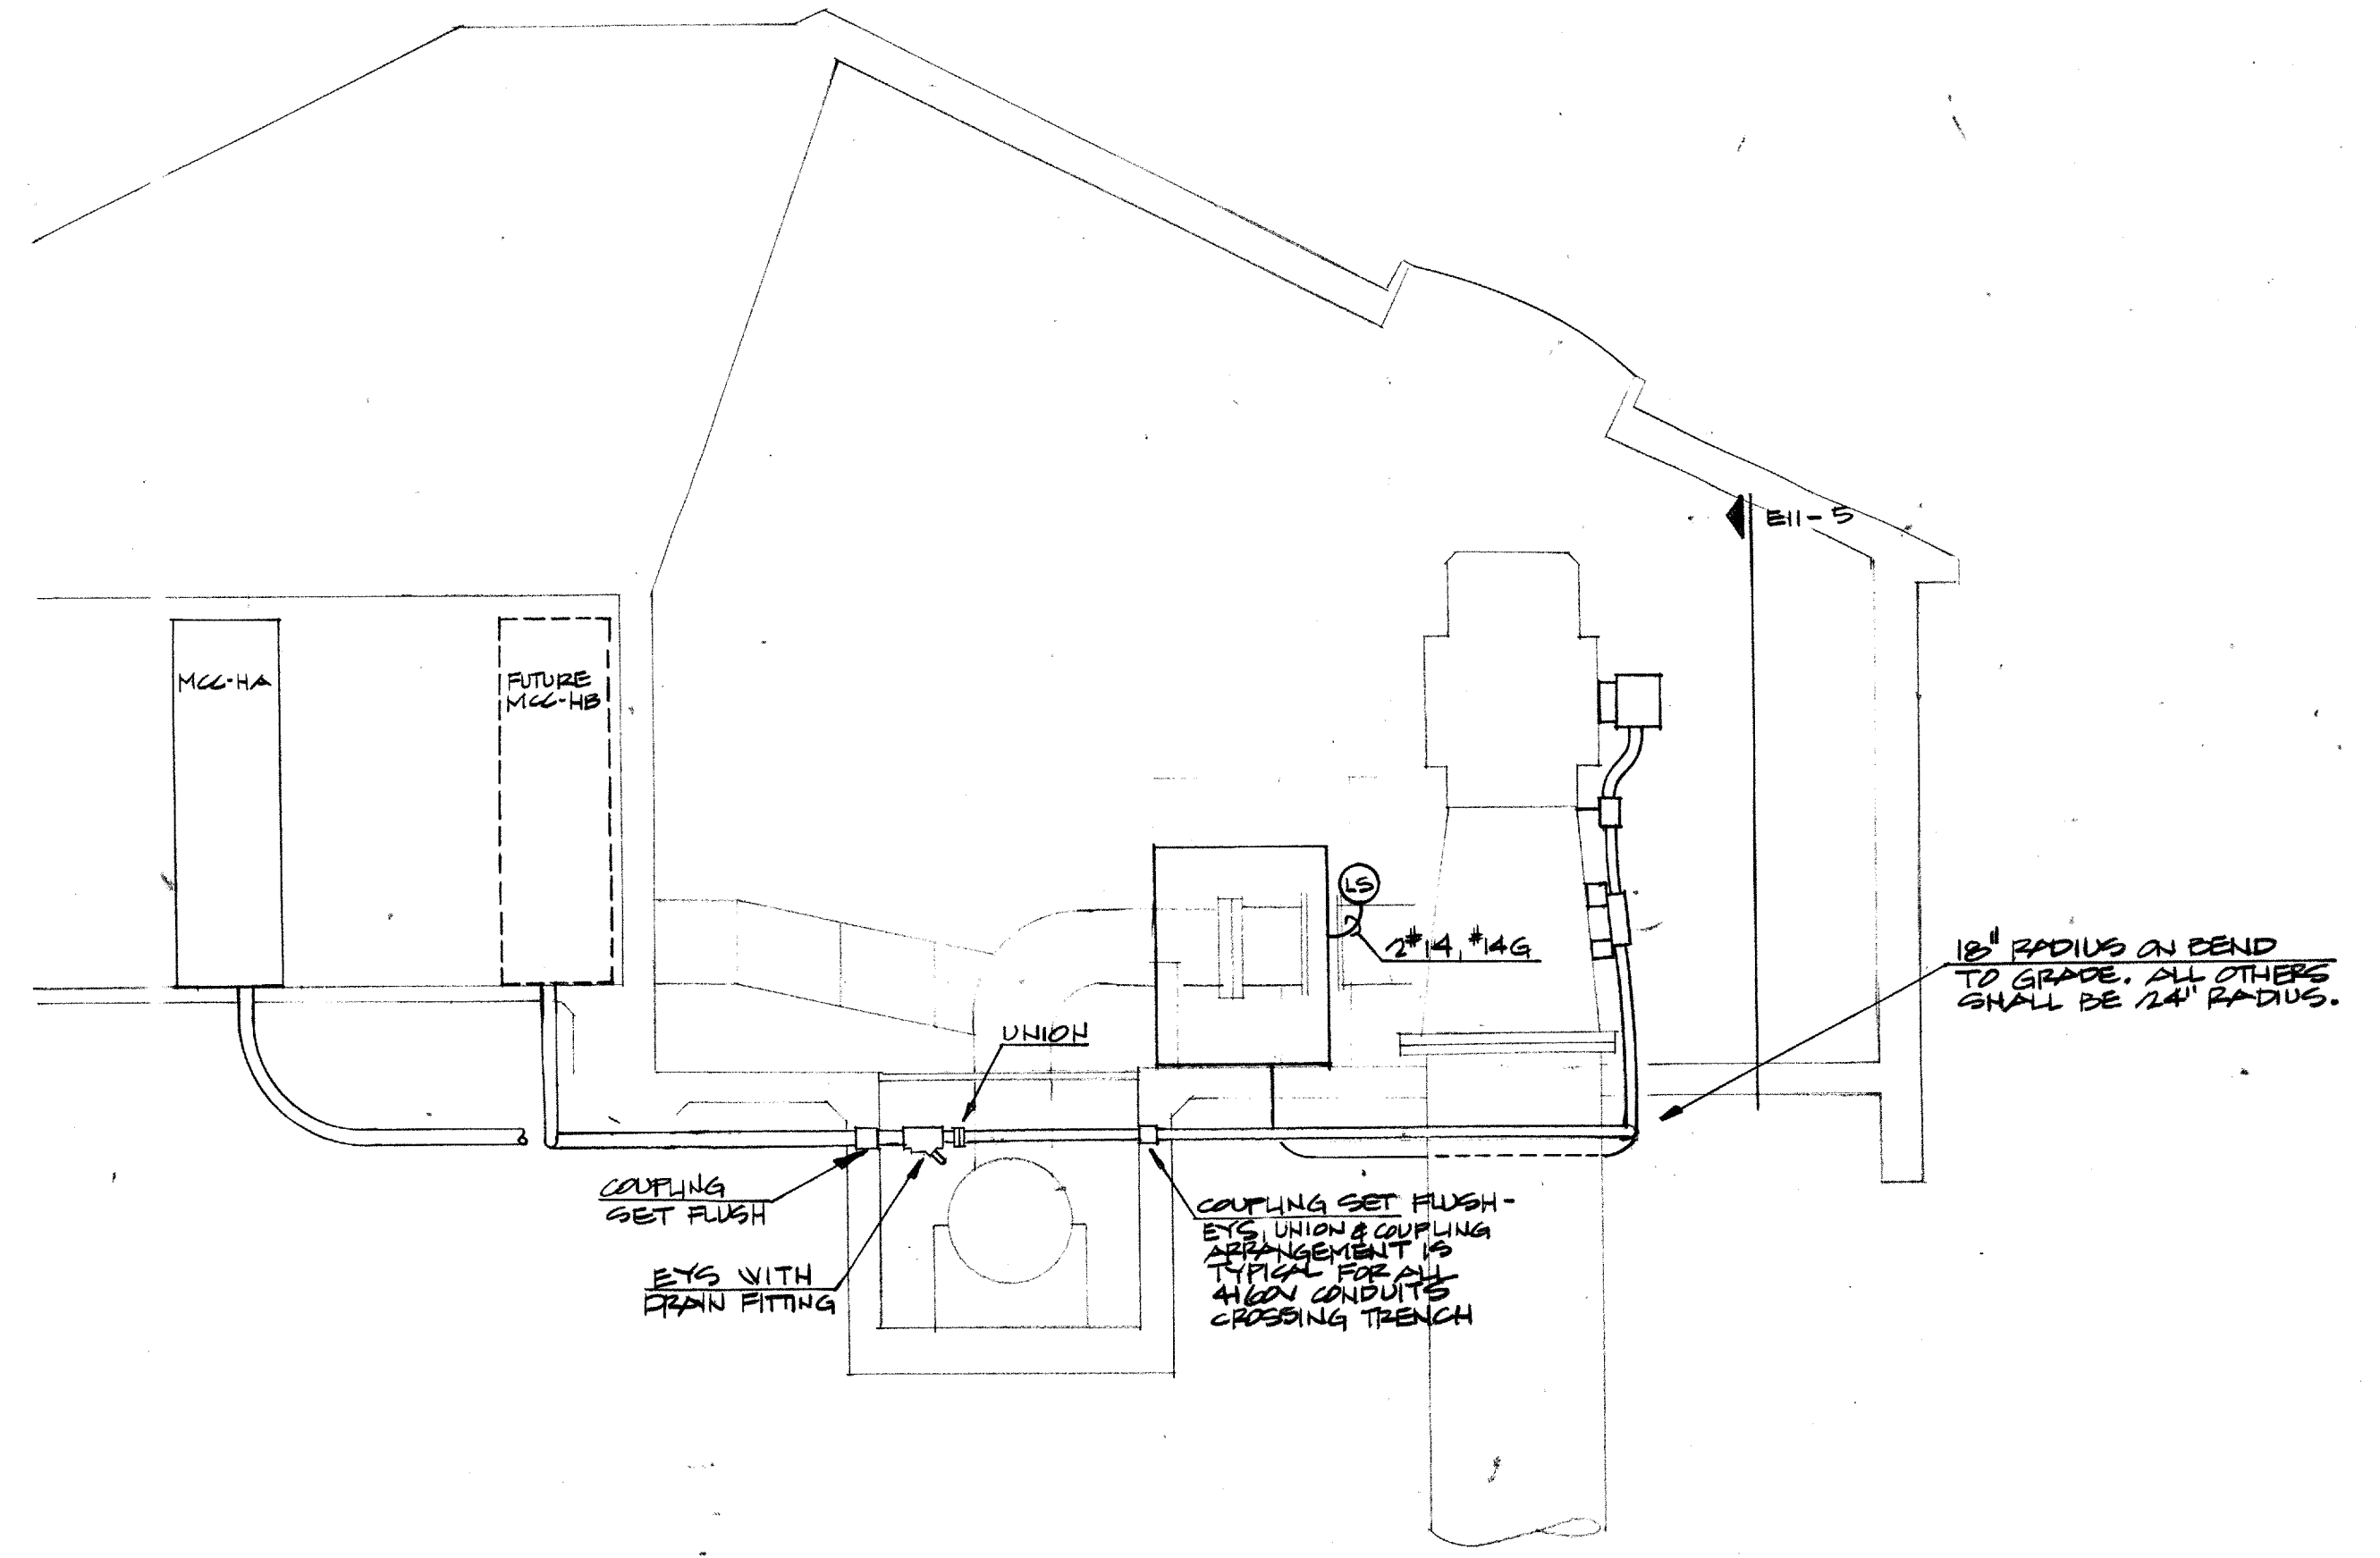


2 SECTION
SCALE 1/4"=1'-0"

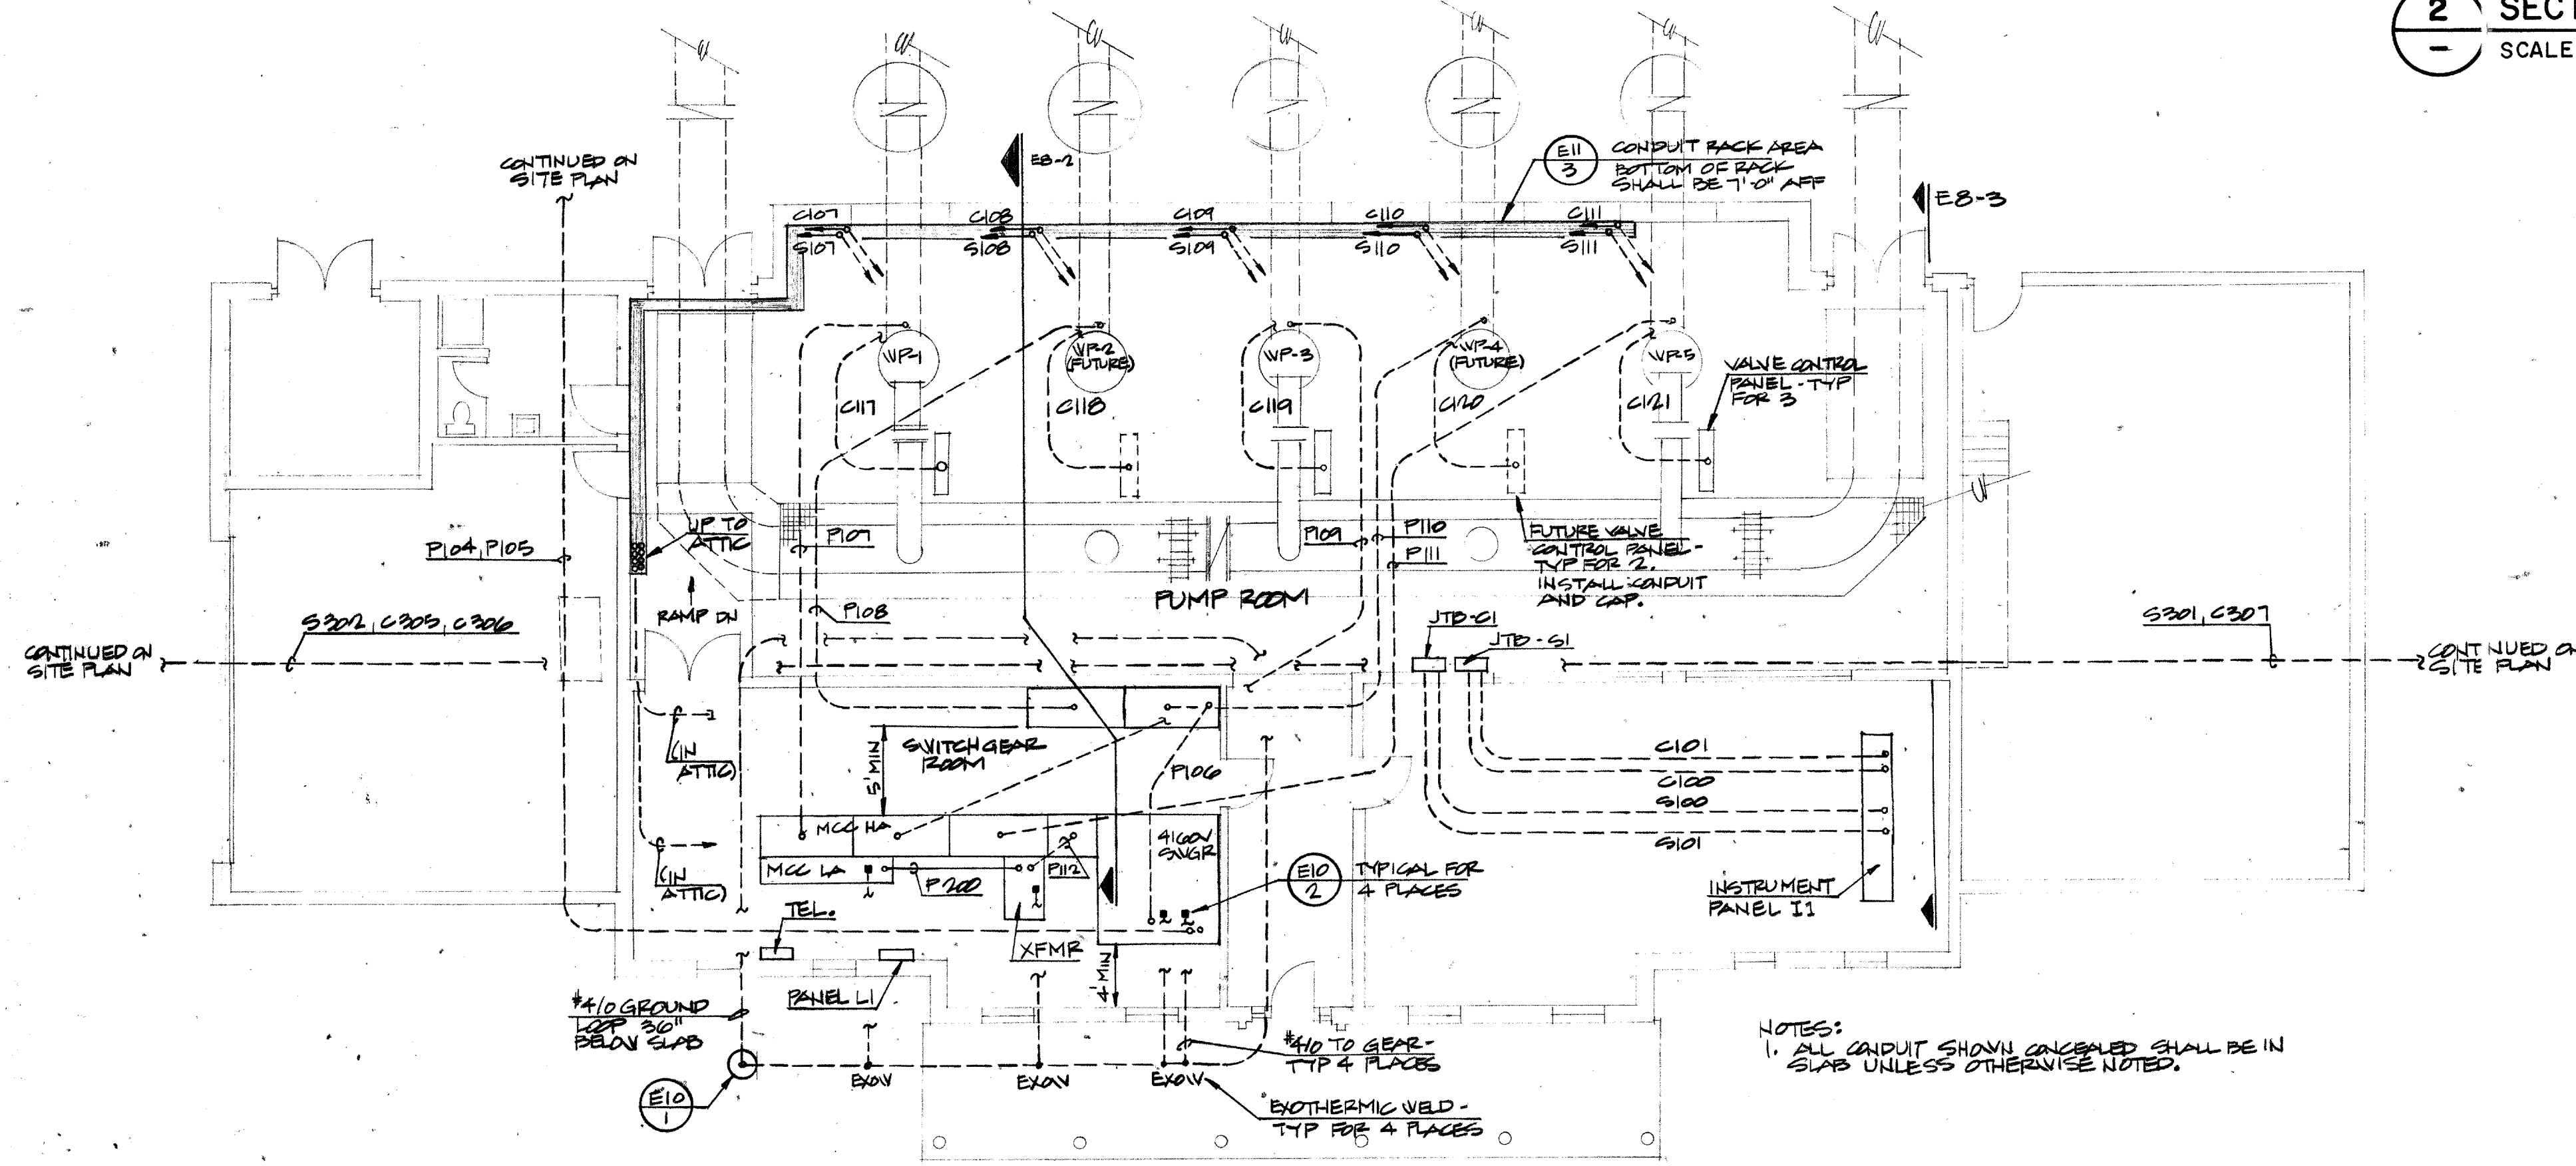

1 ELECTRICAL PLAN
SCALE 1/8"=1'-0"

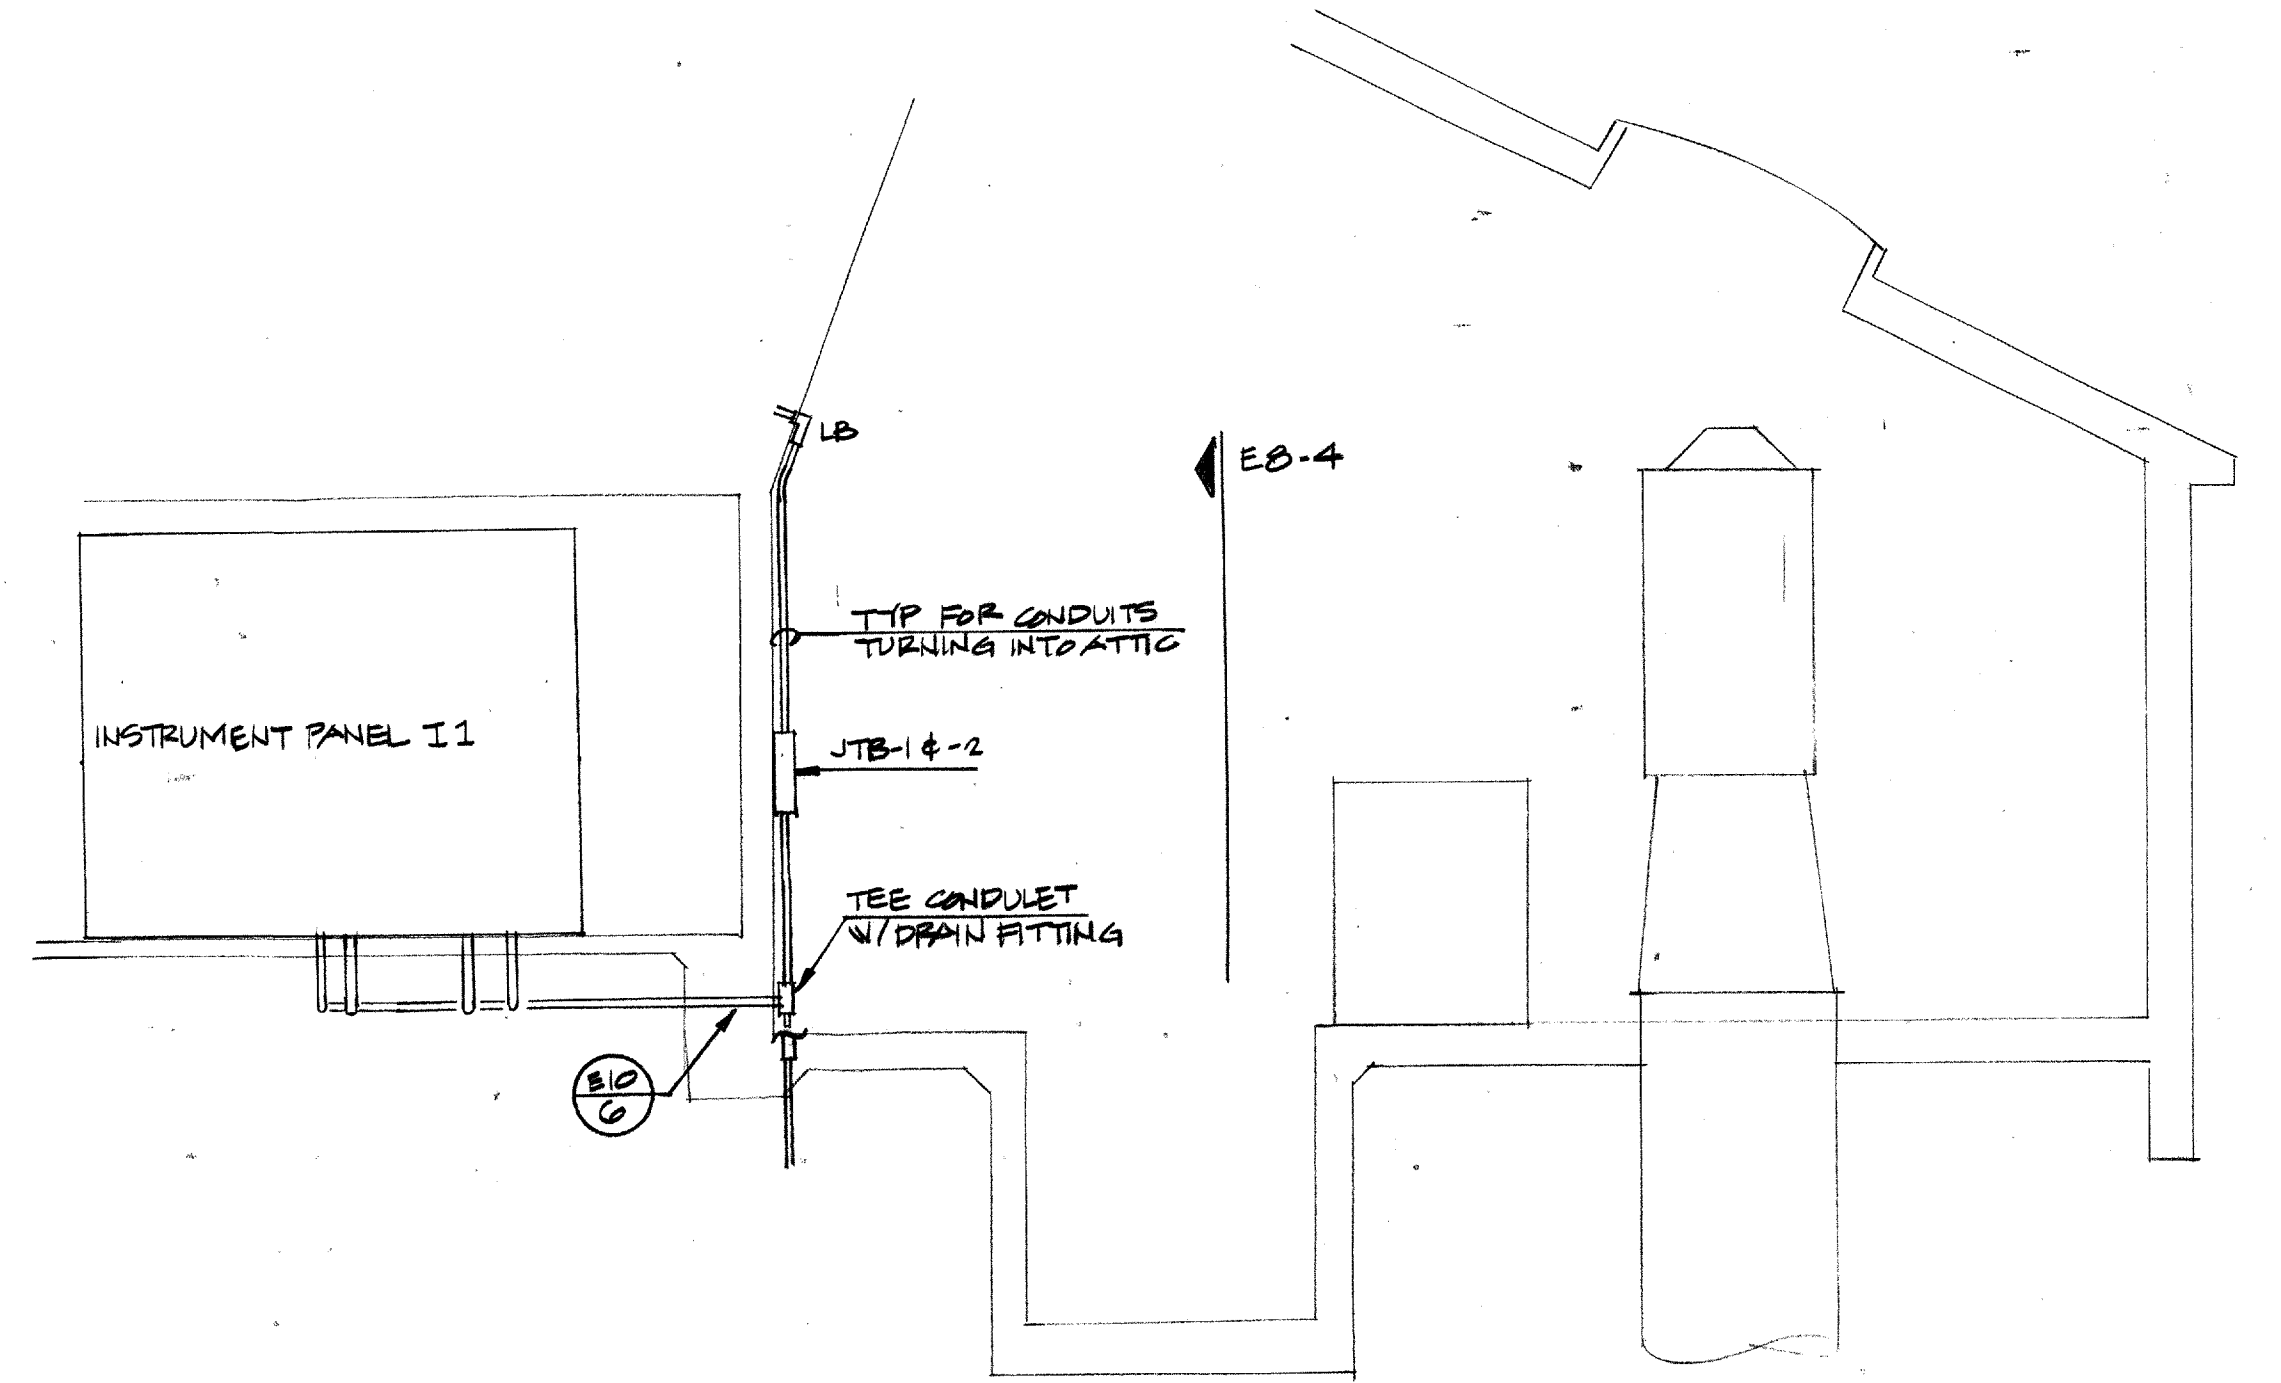

3 SECTION
SCALE 1/4"=1'-0"

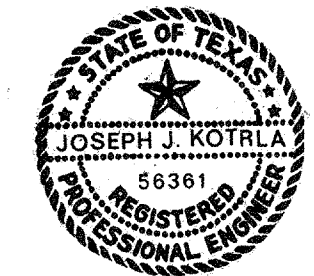

Joseph J. Kotrla
2-18-87

No.	Revision	By	Date
TOWN OF ADDISON DALLAS COUNTY, TEXAS CELESTIAL ROAD PUMP STATION			
CHARLES R. McCREARY & ASSOCIATES CONSULTING ENGINEERS SUITE 577 8501 LA FREYWAY DALLAS, TEXAS 75240		ELECTRICAL PLAN VIEW POWER & CONTROL	
GINN, INC. Consulting Engineers Dallas, Texas			
Designed - JK	Drawn - JW	Date -	Job No. -
Approved -	Checked -	Scale -	Sheet EB OF E 12