




1 ROOF PLAN  
SCALE 1/8" = 1'-0"

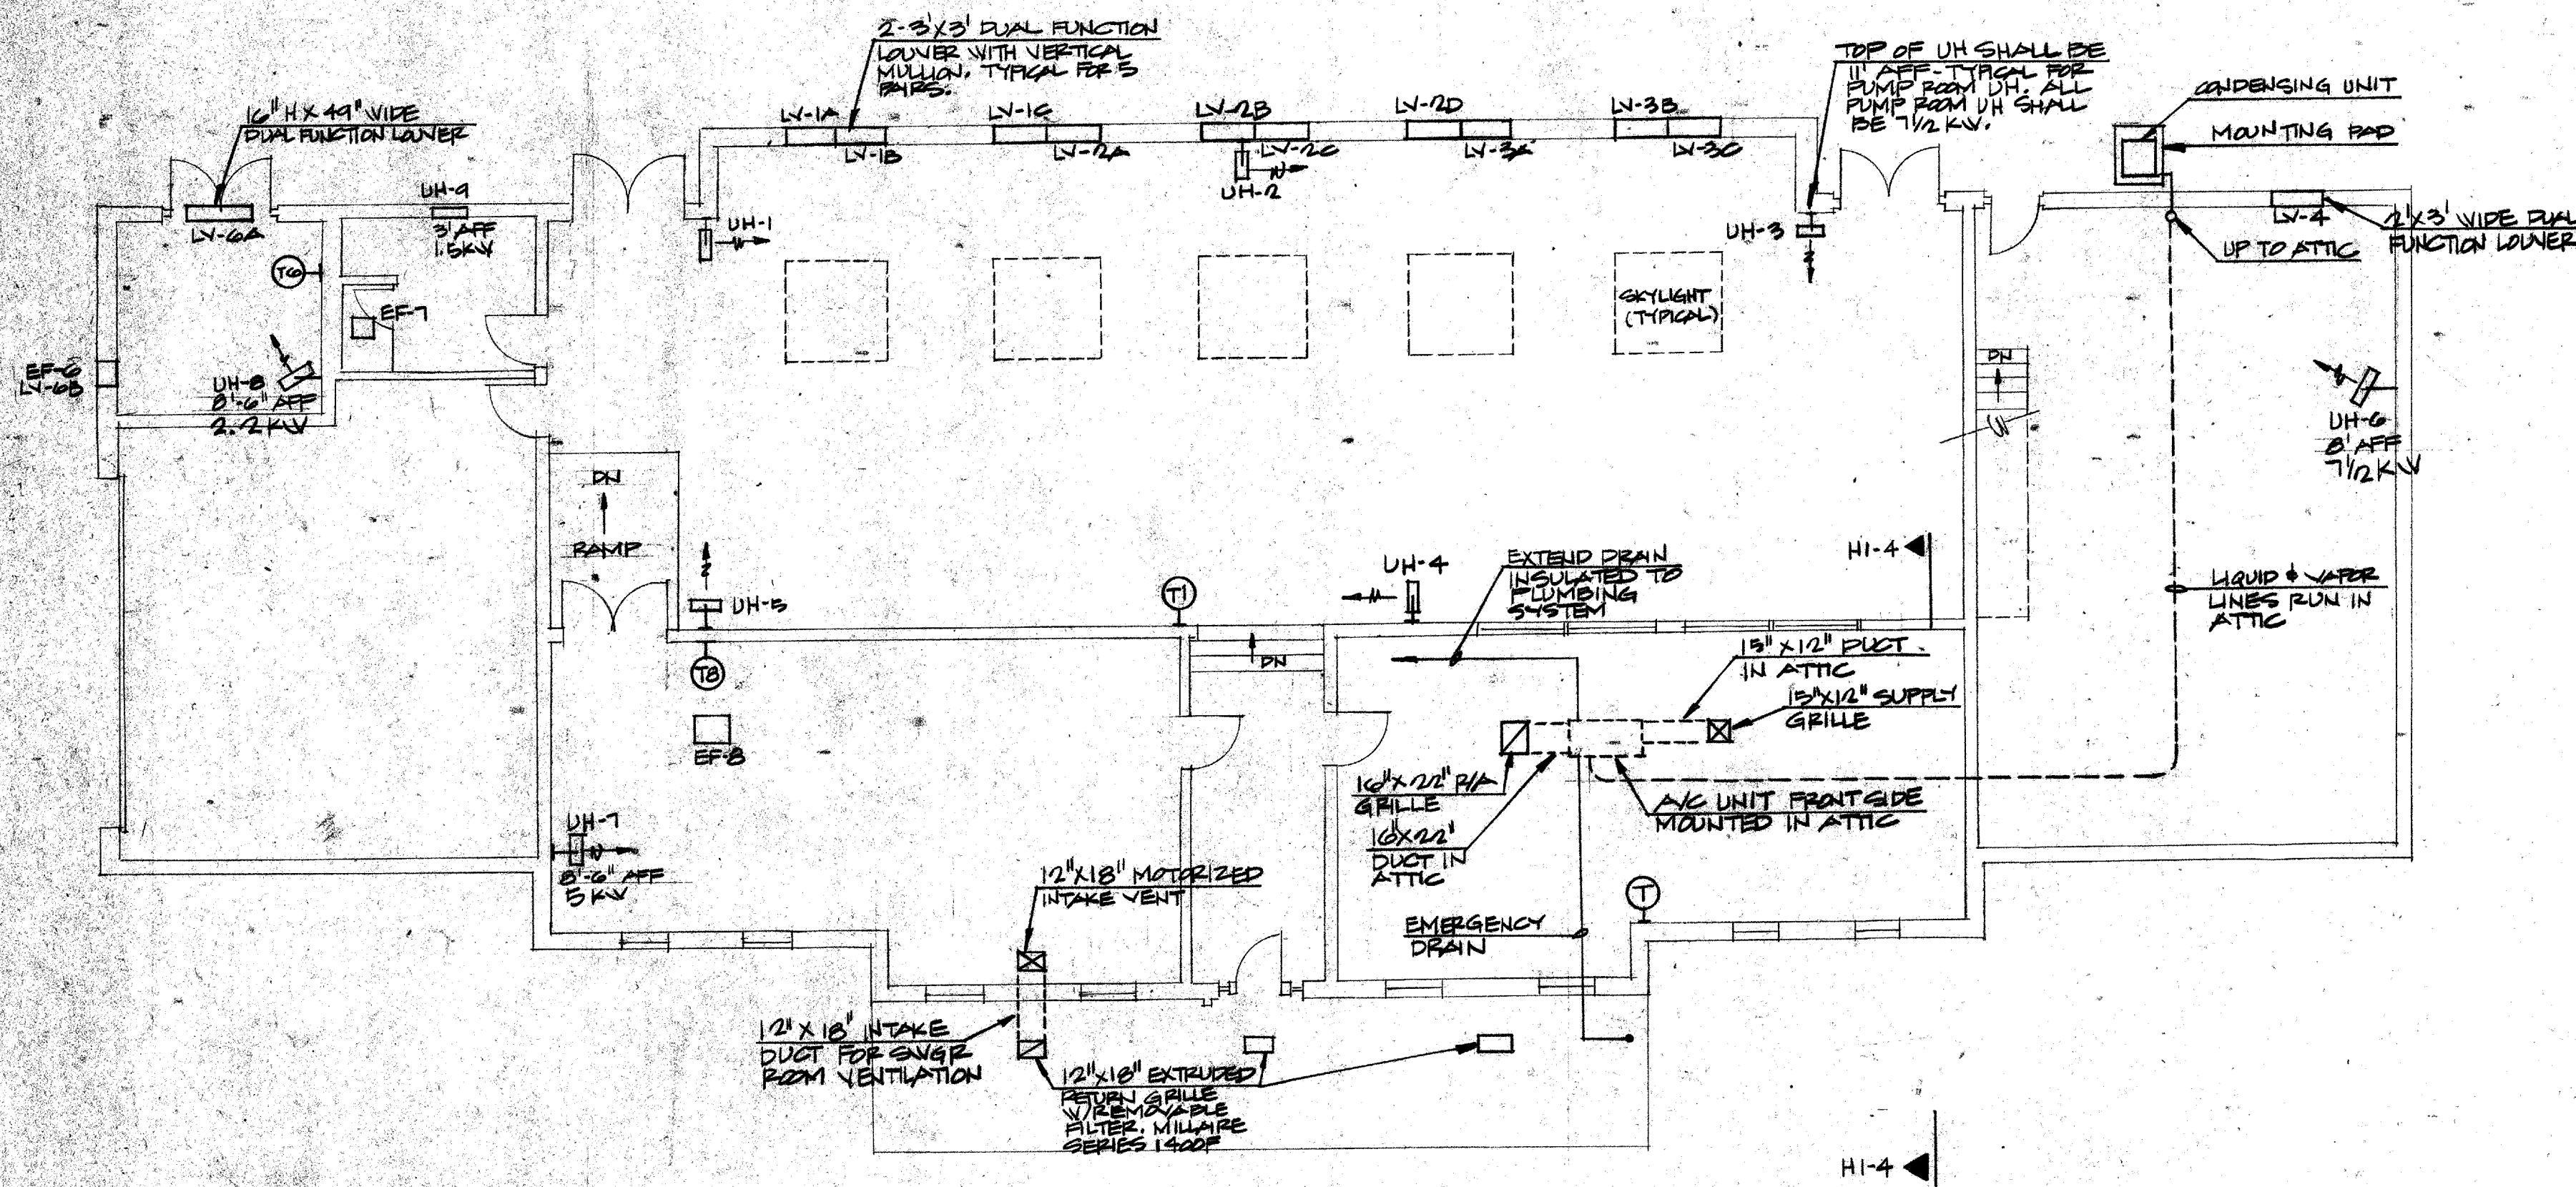


2 HVAC PLAN  
SCALE 1/8" = 1'-0"

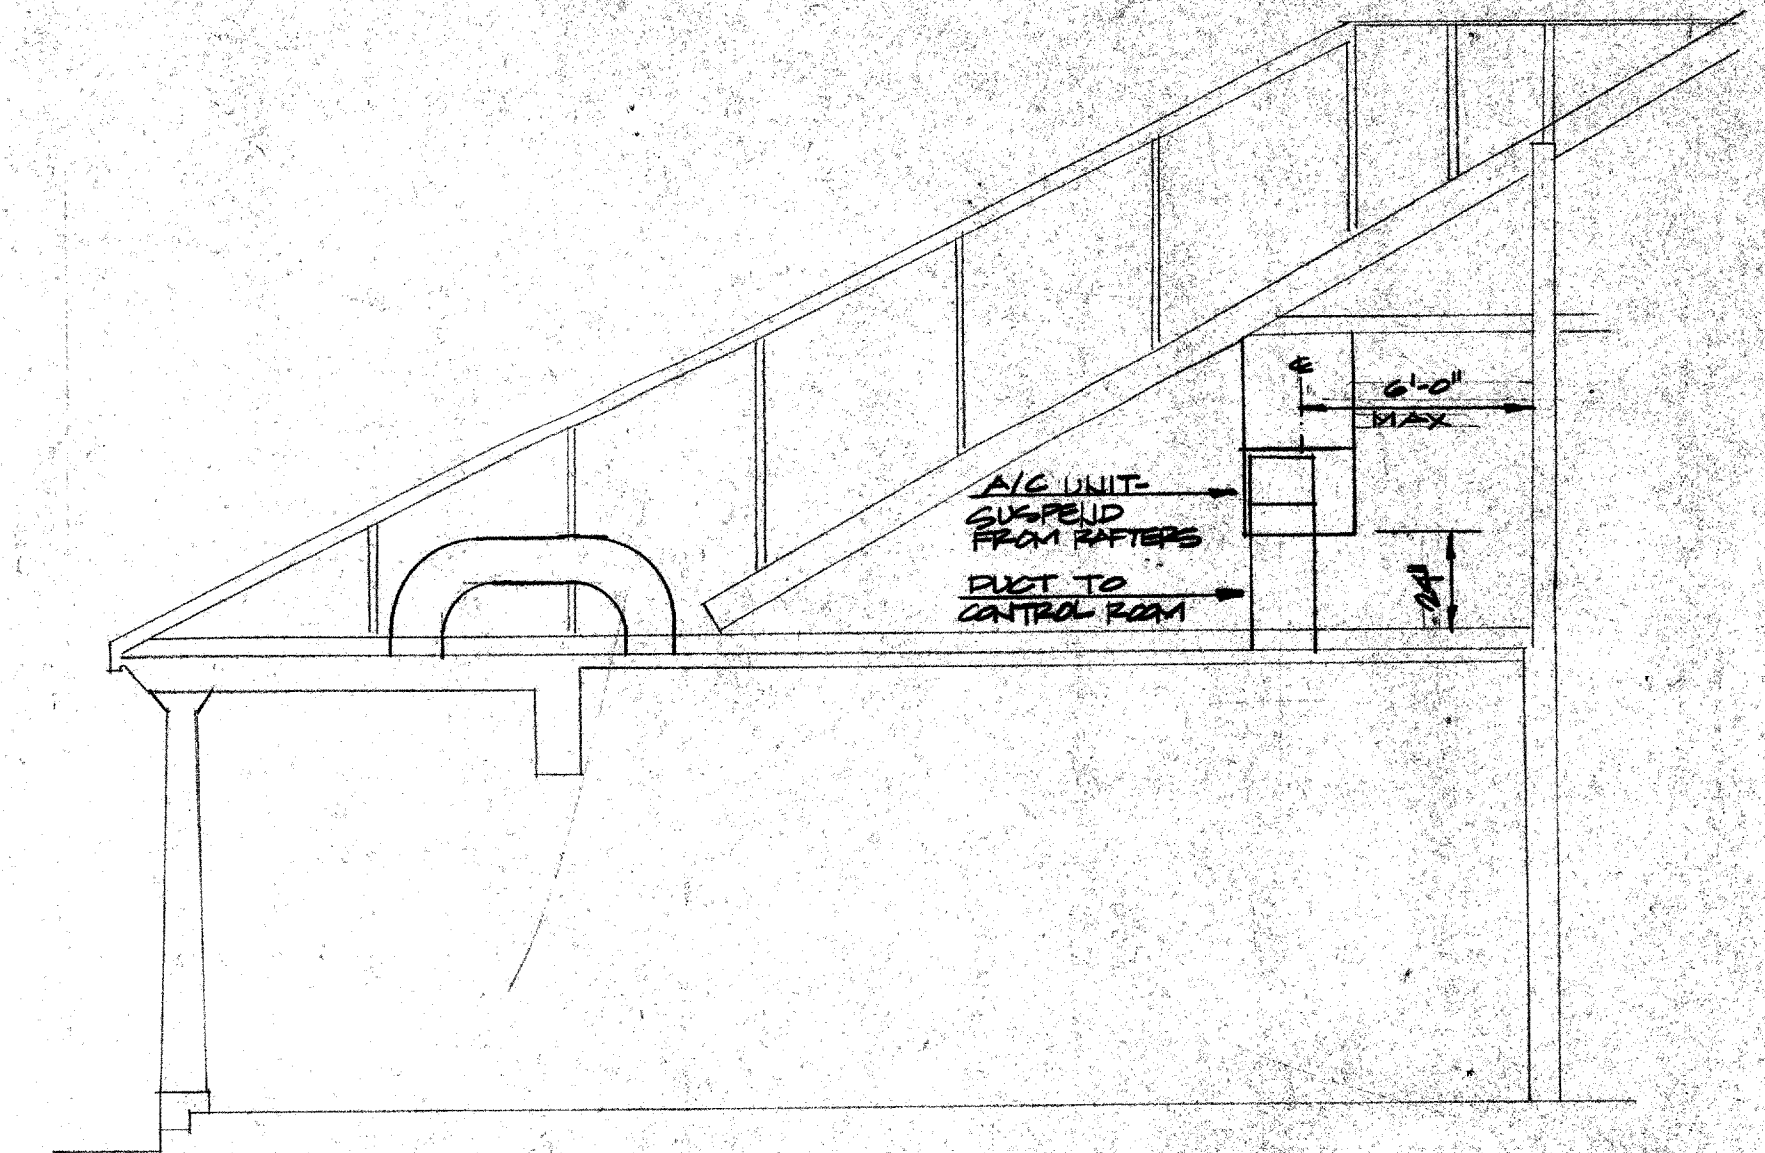


4 SECTION  
NO SCALE

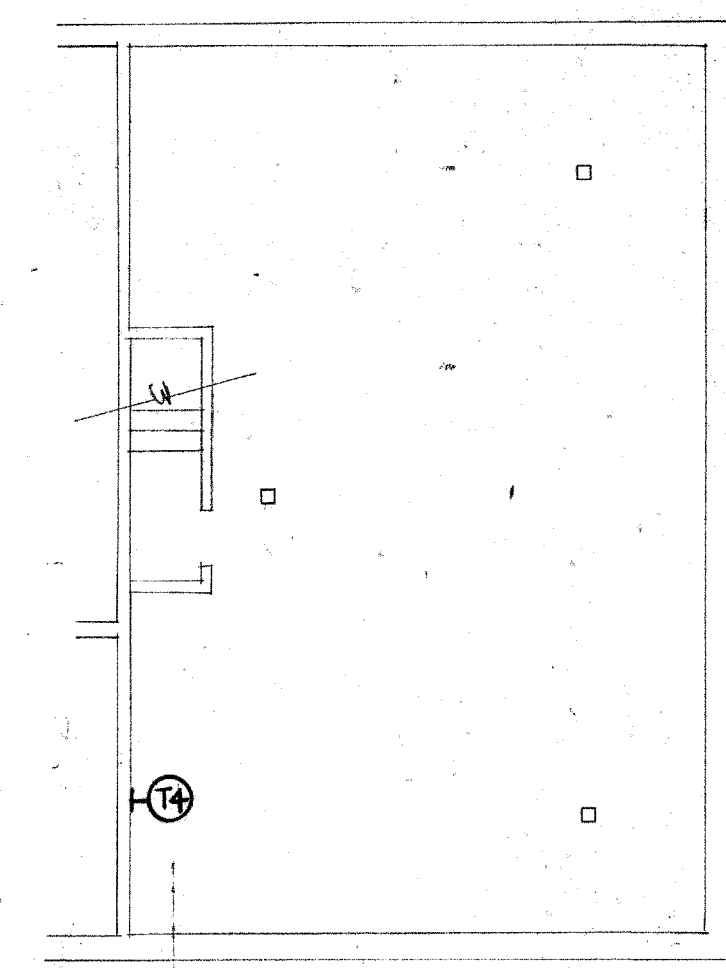

3 ATTIC PLAN  
SCALE 1/8" = 1'-0"

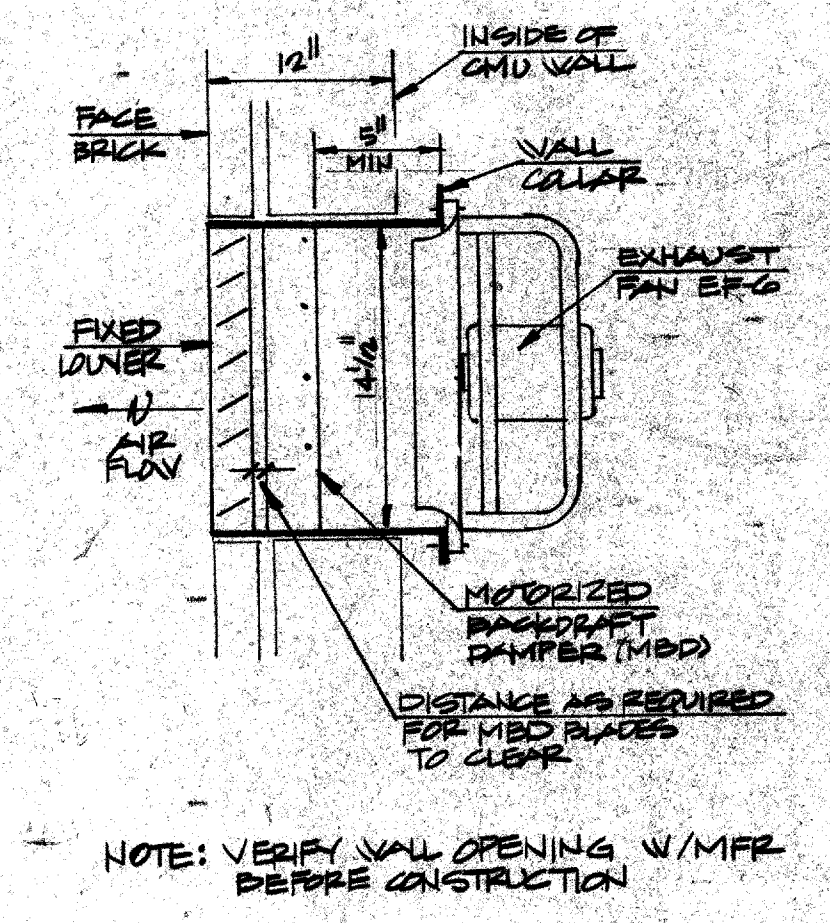

5 DETAIL  
NO SCALE

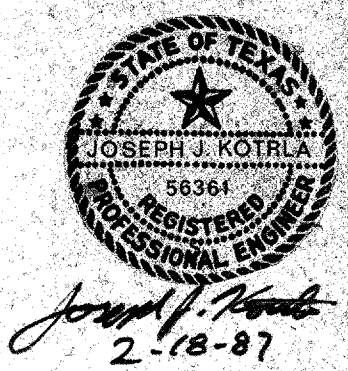

No.	Revision	By	Date
TOWN OF ADDISON DALLAS COUNTY, TEXAS <b>CELESTIAL ROAD PUMP STATION</b>			
CHARLES R. McCREARY & ASSOCIATES CONSULTING ENGINEERS SUITE 217 6501 LAI FREEMAN DALLAS, TEXAS 75244		MECHANICAL HVAC	
<b>GINN, INC.</b> Consulting Engineers Dallas, Texas			
Designed - JK	Drawn - JW	Date -	Job No. -
Approved -	Checked -	Scale -	Sheet M1 of M1

2-18-87