



PART PLAN-KITCHEN

SCALE: 1/4" = 1'-0"

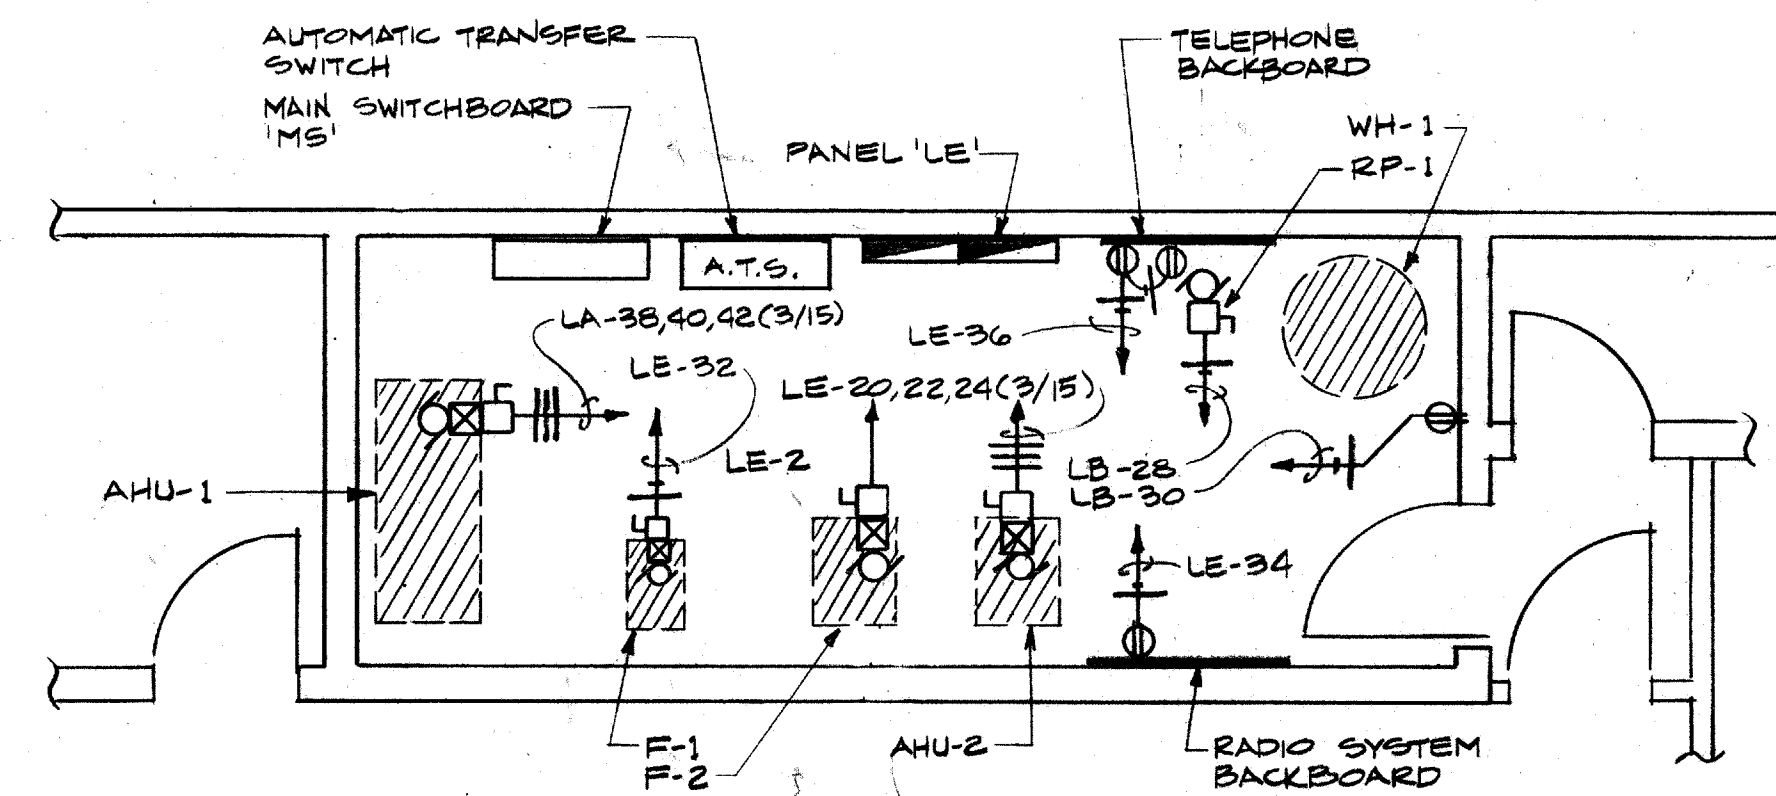

PART PLAN-MECH. ROOM

SCALE: 1/4" = 1'-0"

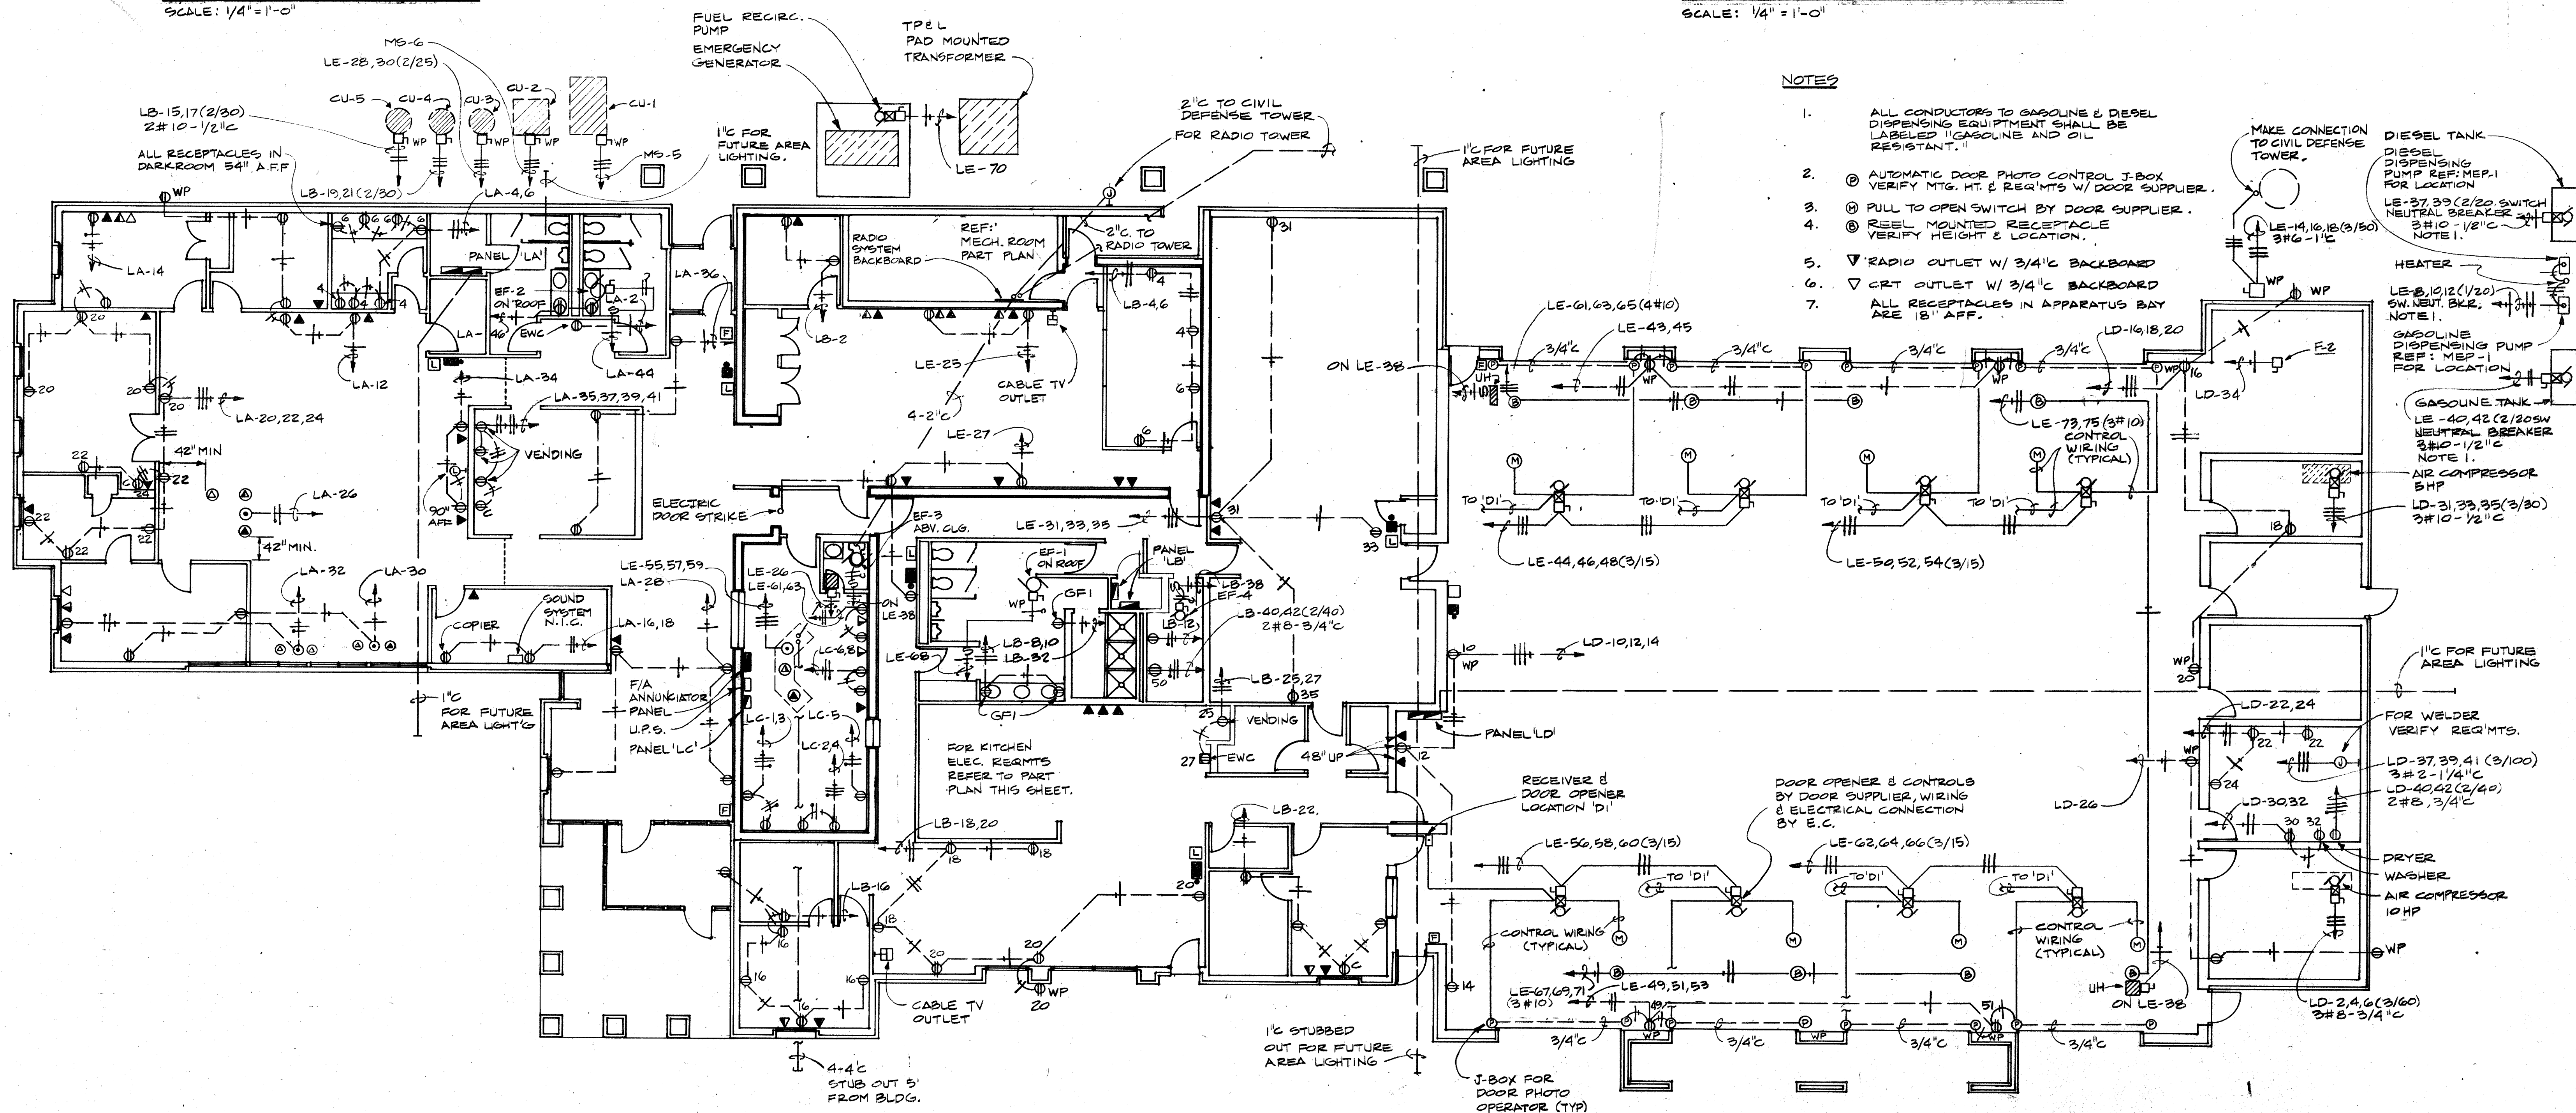

NOTES

1. ALL CONDUCTORS TO GASOLINE & DIESEL DISPENSING EQUIPMENT SHALL BE LABELED "GASOLINE AND OIL RESISTANT".
2. (C) AUTOMATIC DOOR PHOTO CONTROL J-BOX VERIFY MTG. HT. & REQ'TS W/ DOOR SUPPLIER.
3. (O) PULL TO OPEN SWITCH BY DOOR SUPPLIER.
4. (R) REEL MOUNTED RECEPTACLE VERIFY HEIGHT & LOCATION.
5. (V) RADIO OUTLET W/ 3/4" BACKBOARD
6. (D) CRT OUTLET W/ 3/4" BACKBOARD
7. ALL RECEPTACLES IN APPARATUS BAY ARE 15' AFF.

FLOOR PLAN - POWER

SCALE 1/8" = 1'-0"

S. TOUB & ASSOC.
CONSULTING ENGINEERS
DALLAS, TEXAS

DAVID A. DILLARD, AIA
ARCHITECTURE
4310 Westside Drive • Suite E
Dallas, Texas 75239 • (214) 528-2842

CITY OF ADDISON
FIRE DEPARTMENT
CENTRAL OFFICES &
FIRE STATION #1
AIRPORT PARKWAY &
ADDISON ROAD, ADDISON, TX.

FLOOR PLAN -
POWER

PROJECT NO SHEET NO
82.00 E2
DATE
6/29/82