



**NOTES**


- TANK SYSTEMS TO BE SUPPLIED WITH REMOTE ELECTRONIC LEVEL GAUGE (GAUGES TO BE LOCATED IN COMMUNITY DISPATCH AREA)
- FUEL PUMPS - RED JACKET SUBMERSIBLE PUMPS, 3/4 HP, FIBERGLAS TANK, PUMP SHAFT LENGTH AS REQ'D FOR TANK SUPPLIES.

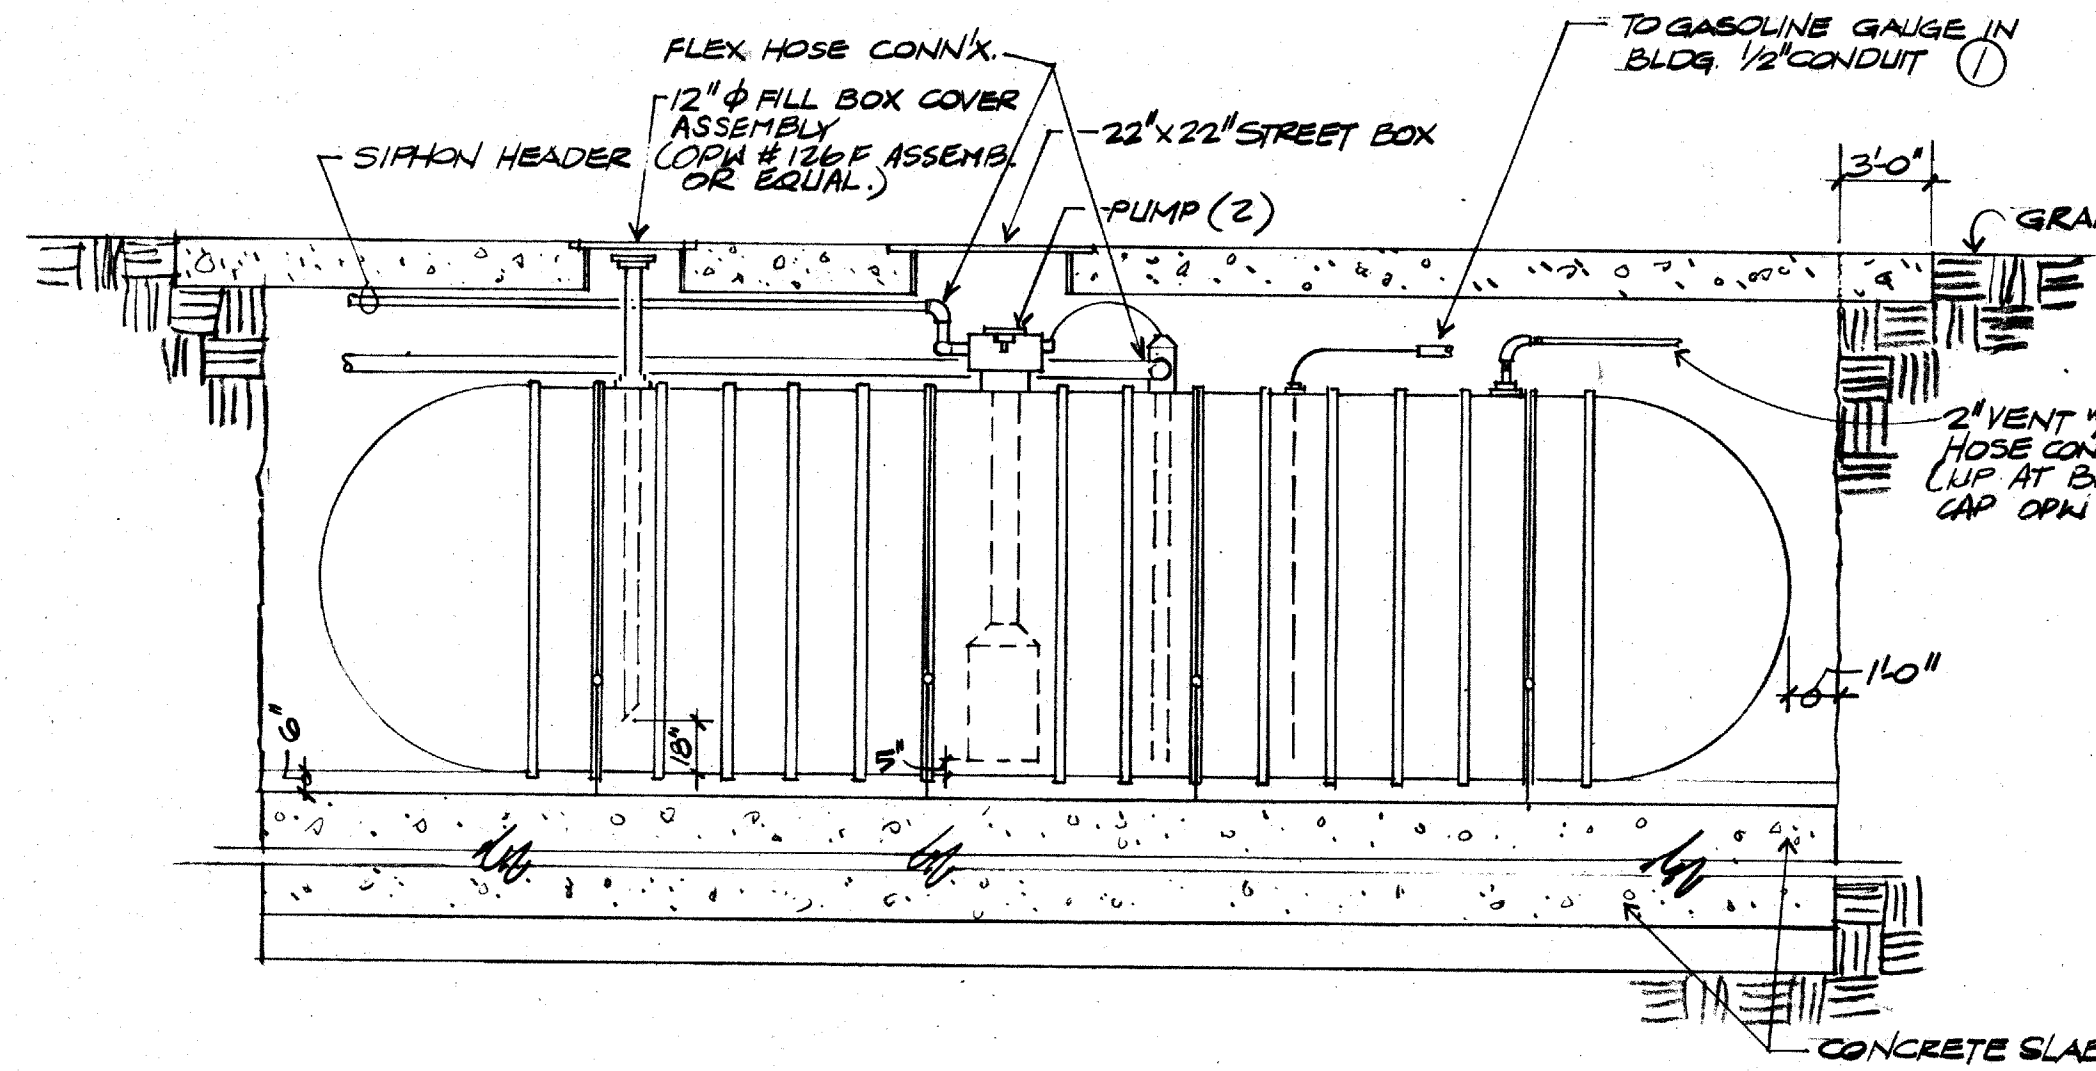

**PIPING DIAGRAM THRU UNDERGROUND STORAGE TANK**  
NOT TO SCALE

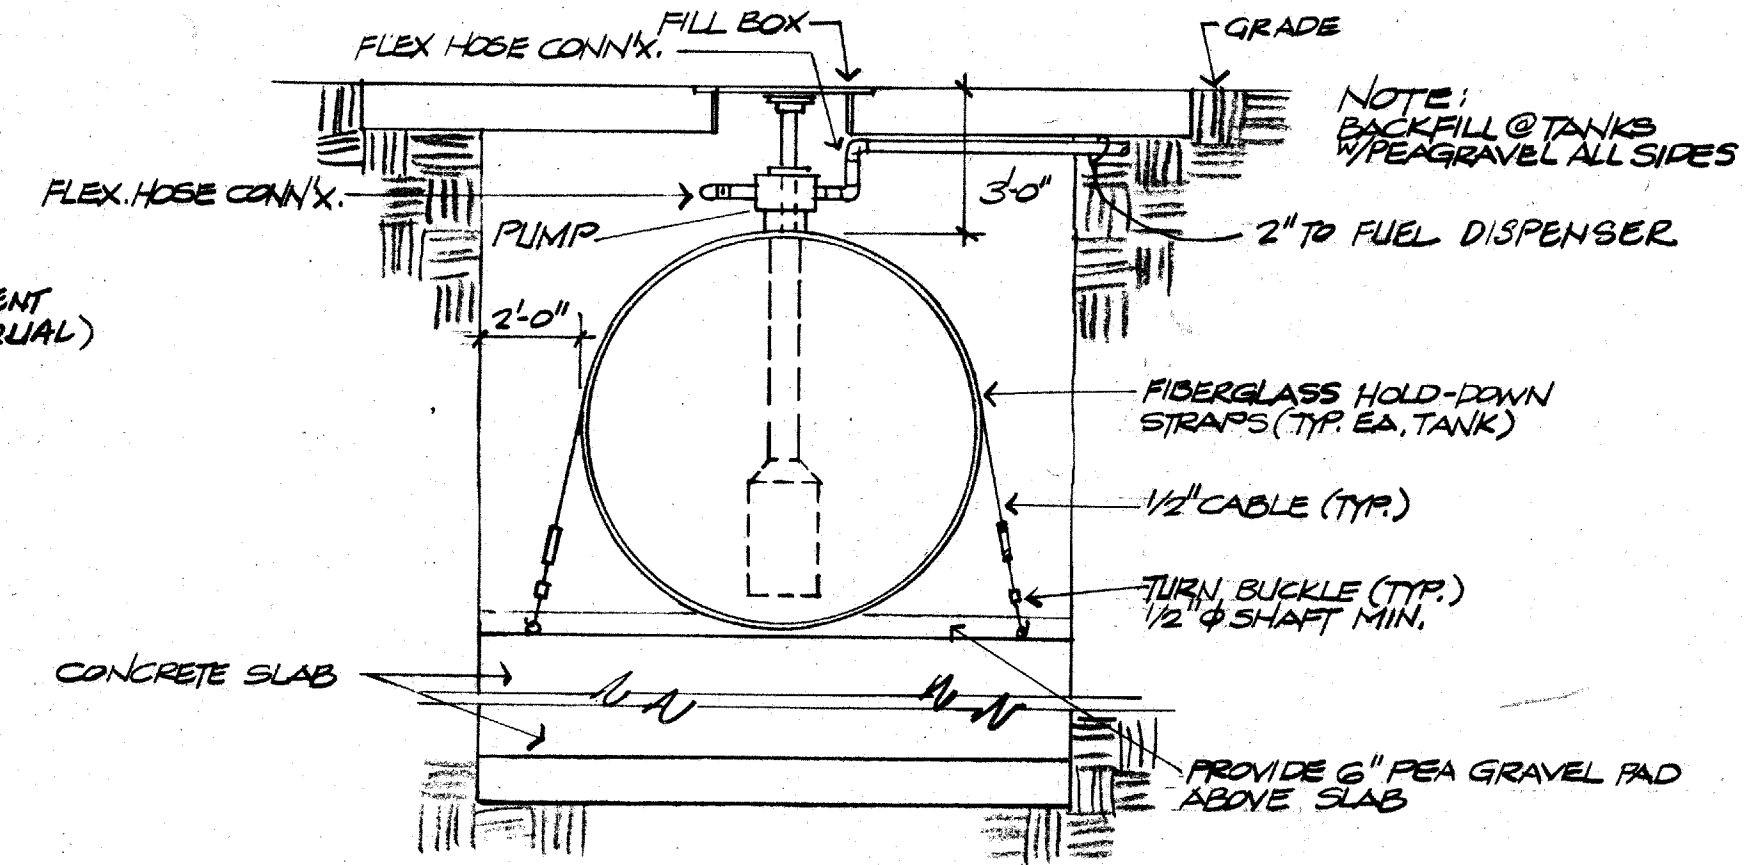


**SECTION THRU UNDERGROUND TANK**  
NOT TO SCALE

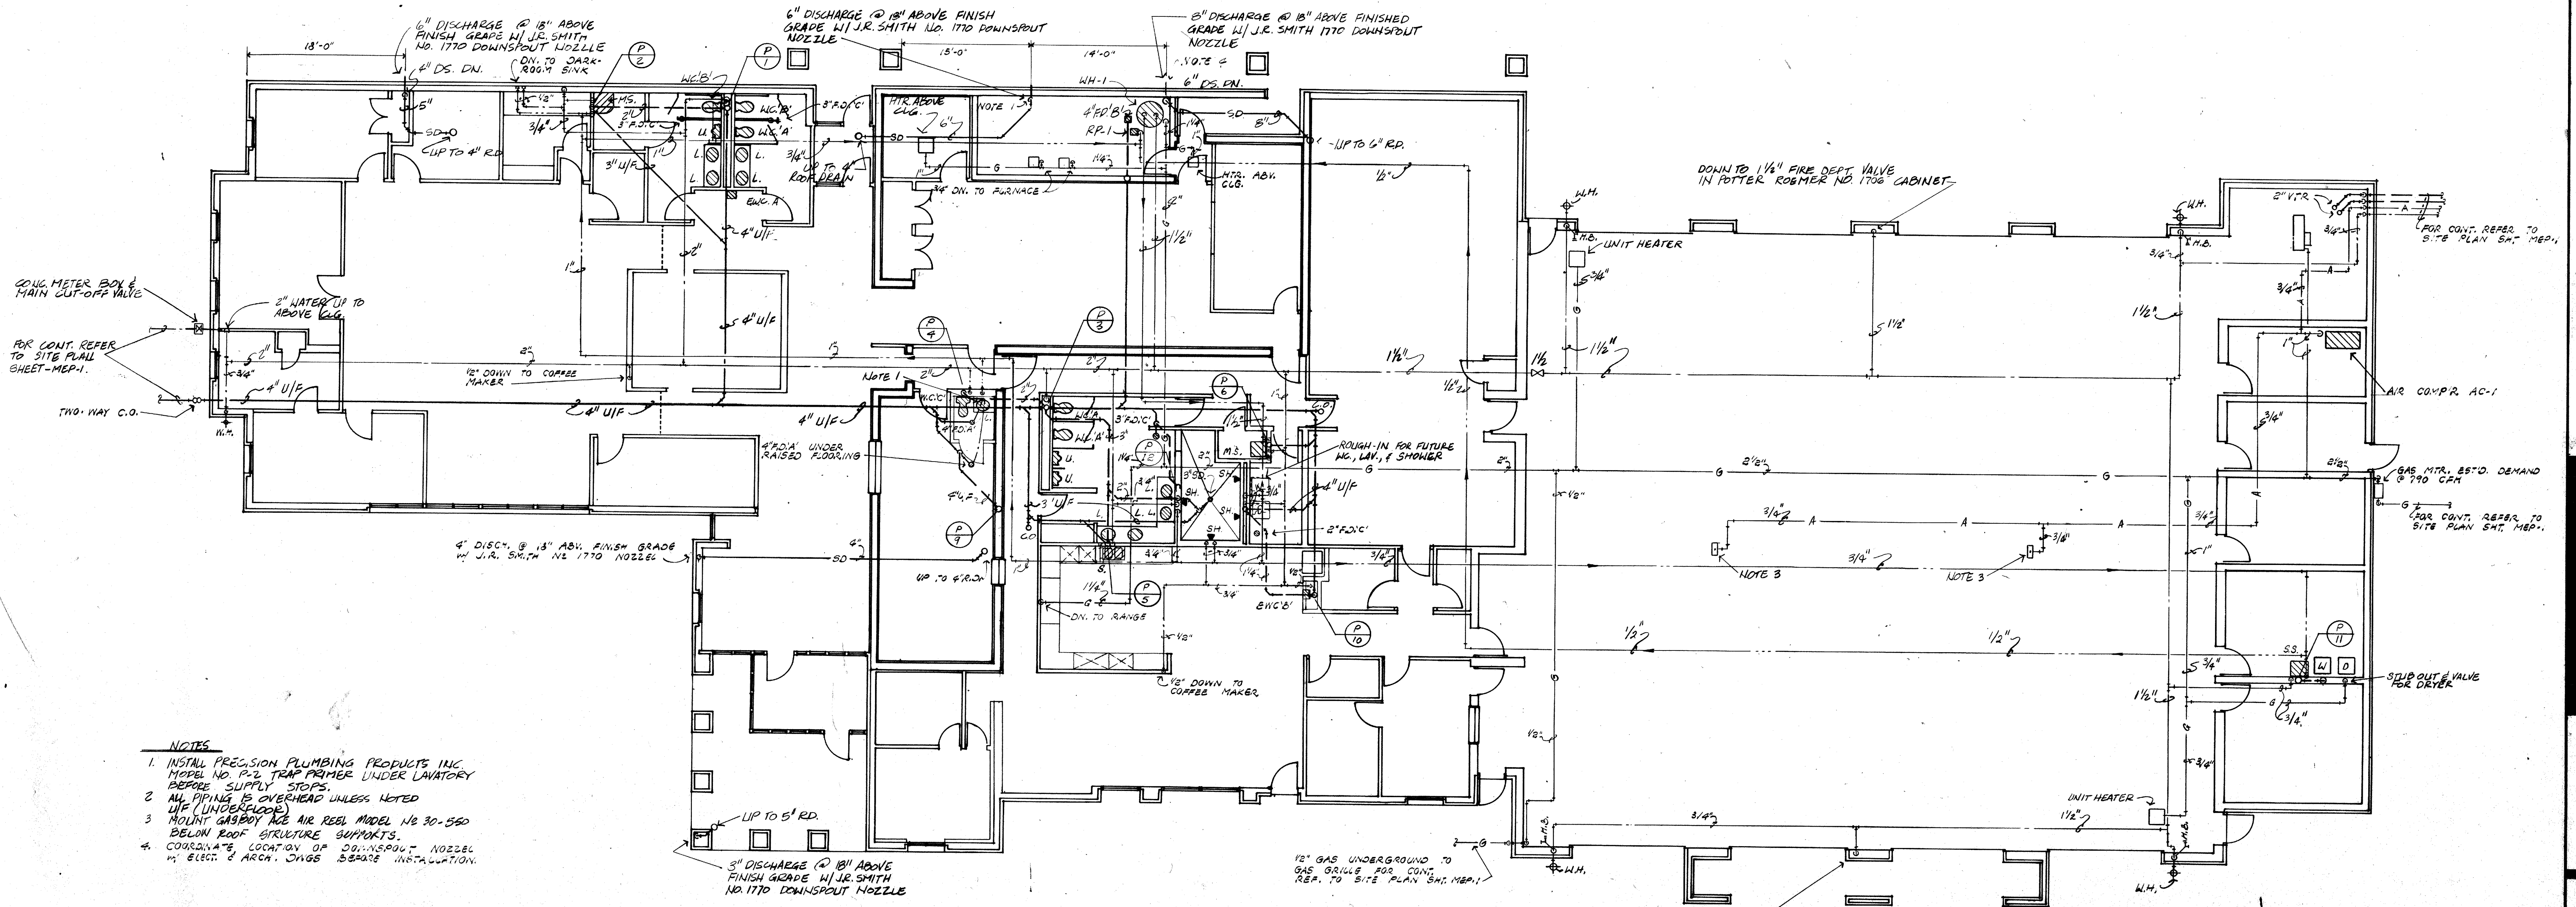

**FLOOR PLAN - PLUMBING**  
SCALE 1/8" = 1'-0"

- NOTES**
- INSTALL PRECISION PLUMBING PRODUCTS INC. MODEL NO. P-2 TRAP PRIMER UNDER LAVATORY BEFORE SUPPLY STOPS.
  - ALL PIPING IS OVERHEAD UNLESS NOTED U/F (UNDER FLOOR).
  - ROUNDTOP GASBOY AIR REEL MODEL NO. 30-550 BEHIND ROOF STRUCTURE SUPPORTS.
  - CONSULTATE LOCATION OF SUBMERSIBLE NOZZLE IN ELEC. & ARCH. DINGS BEFORE INSTALLATION.

S. TOUB & ASSOC.  
CONSULTING ENGINEERS  
DALLAS, TEXAS

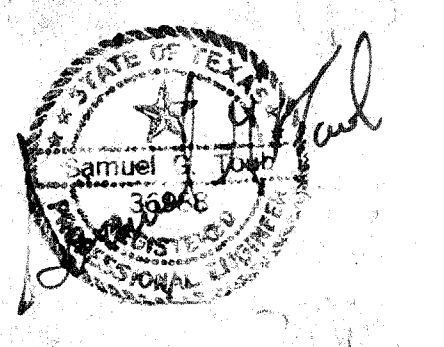

DAVID A. DELAND AND  
ARCHITECTURE  
4311 Westside Drive • Suite F  
Dallas, Texas 75207 • (214) 528-2442

CITY OF ADDISON  
FIRE DEPARTMENT

CENTRAL OFFICES #  
FIRE STATION NO. 1

AIRPORT PARKWAY #  
ADDISON ROAD, ADDISON, TX.

FLOOR PLAN -  
PLUMBING

PROJECT NO. SHEET NO.  
82.06

DATE  
6/25/82

**P2**