

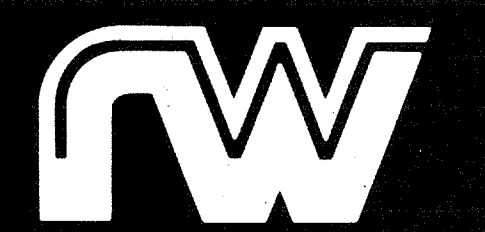


SHEET TIME	
SHEET:	
ASSIGN TO:	
DWG. NO.	DATE
REVISED	BY
CHECKED	DATE
REVISIONS	BY
KEYNOTING	BY


DRAWN BY			CHECKED BY		
REVISIONS			NO. DESCRIPTION DATE		

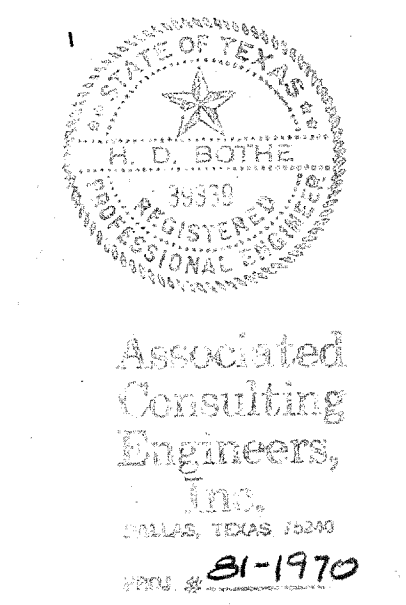

rowls & welty inc.
 Architects / Planners
 16475 Dallas Parkway, Suite 660
 Dallas, Texas 75248 (214) 931-0090

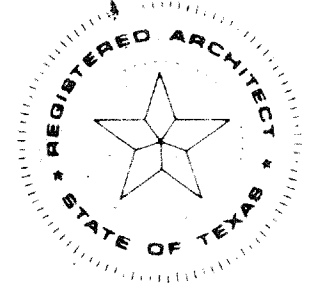



ADDISON FIRE STATION NO. 2

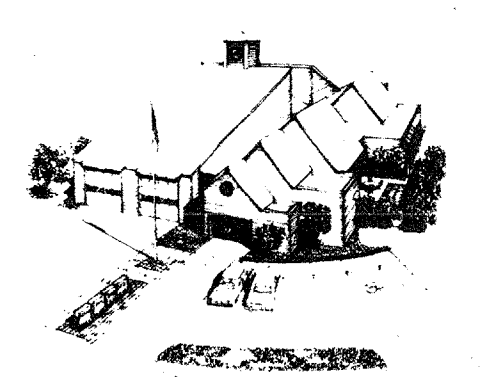

ADDISON, TEXAS

SHEET TITLE
 LIGHTING PLAN & SCHEDULE

81080 SHEET NO.
 PROJECT NO. E-3
 DATE 12-2-81 OF 23

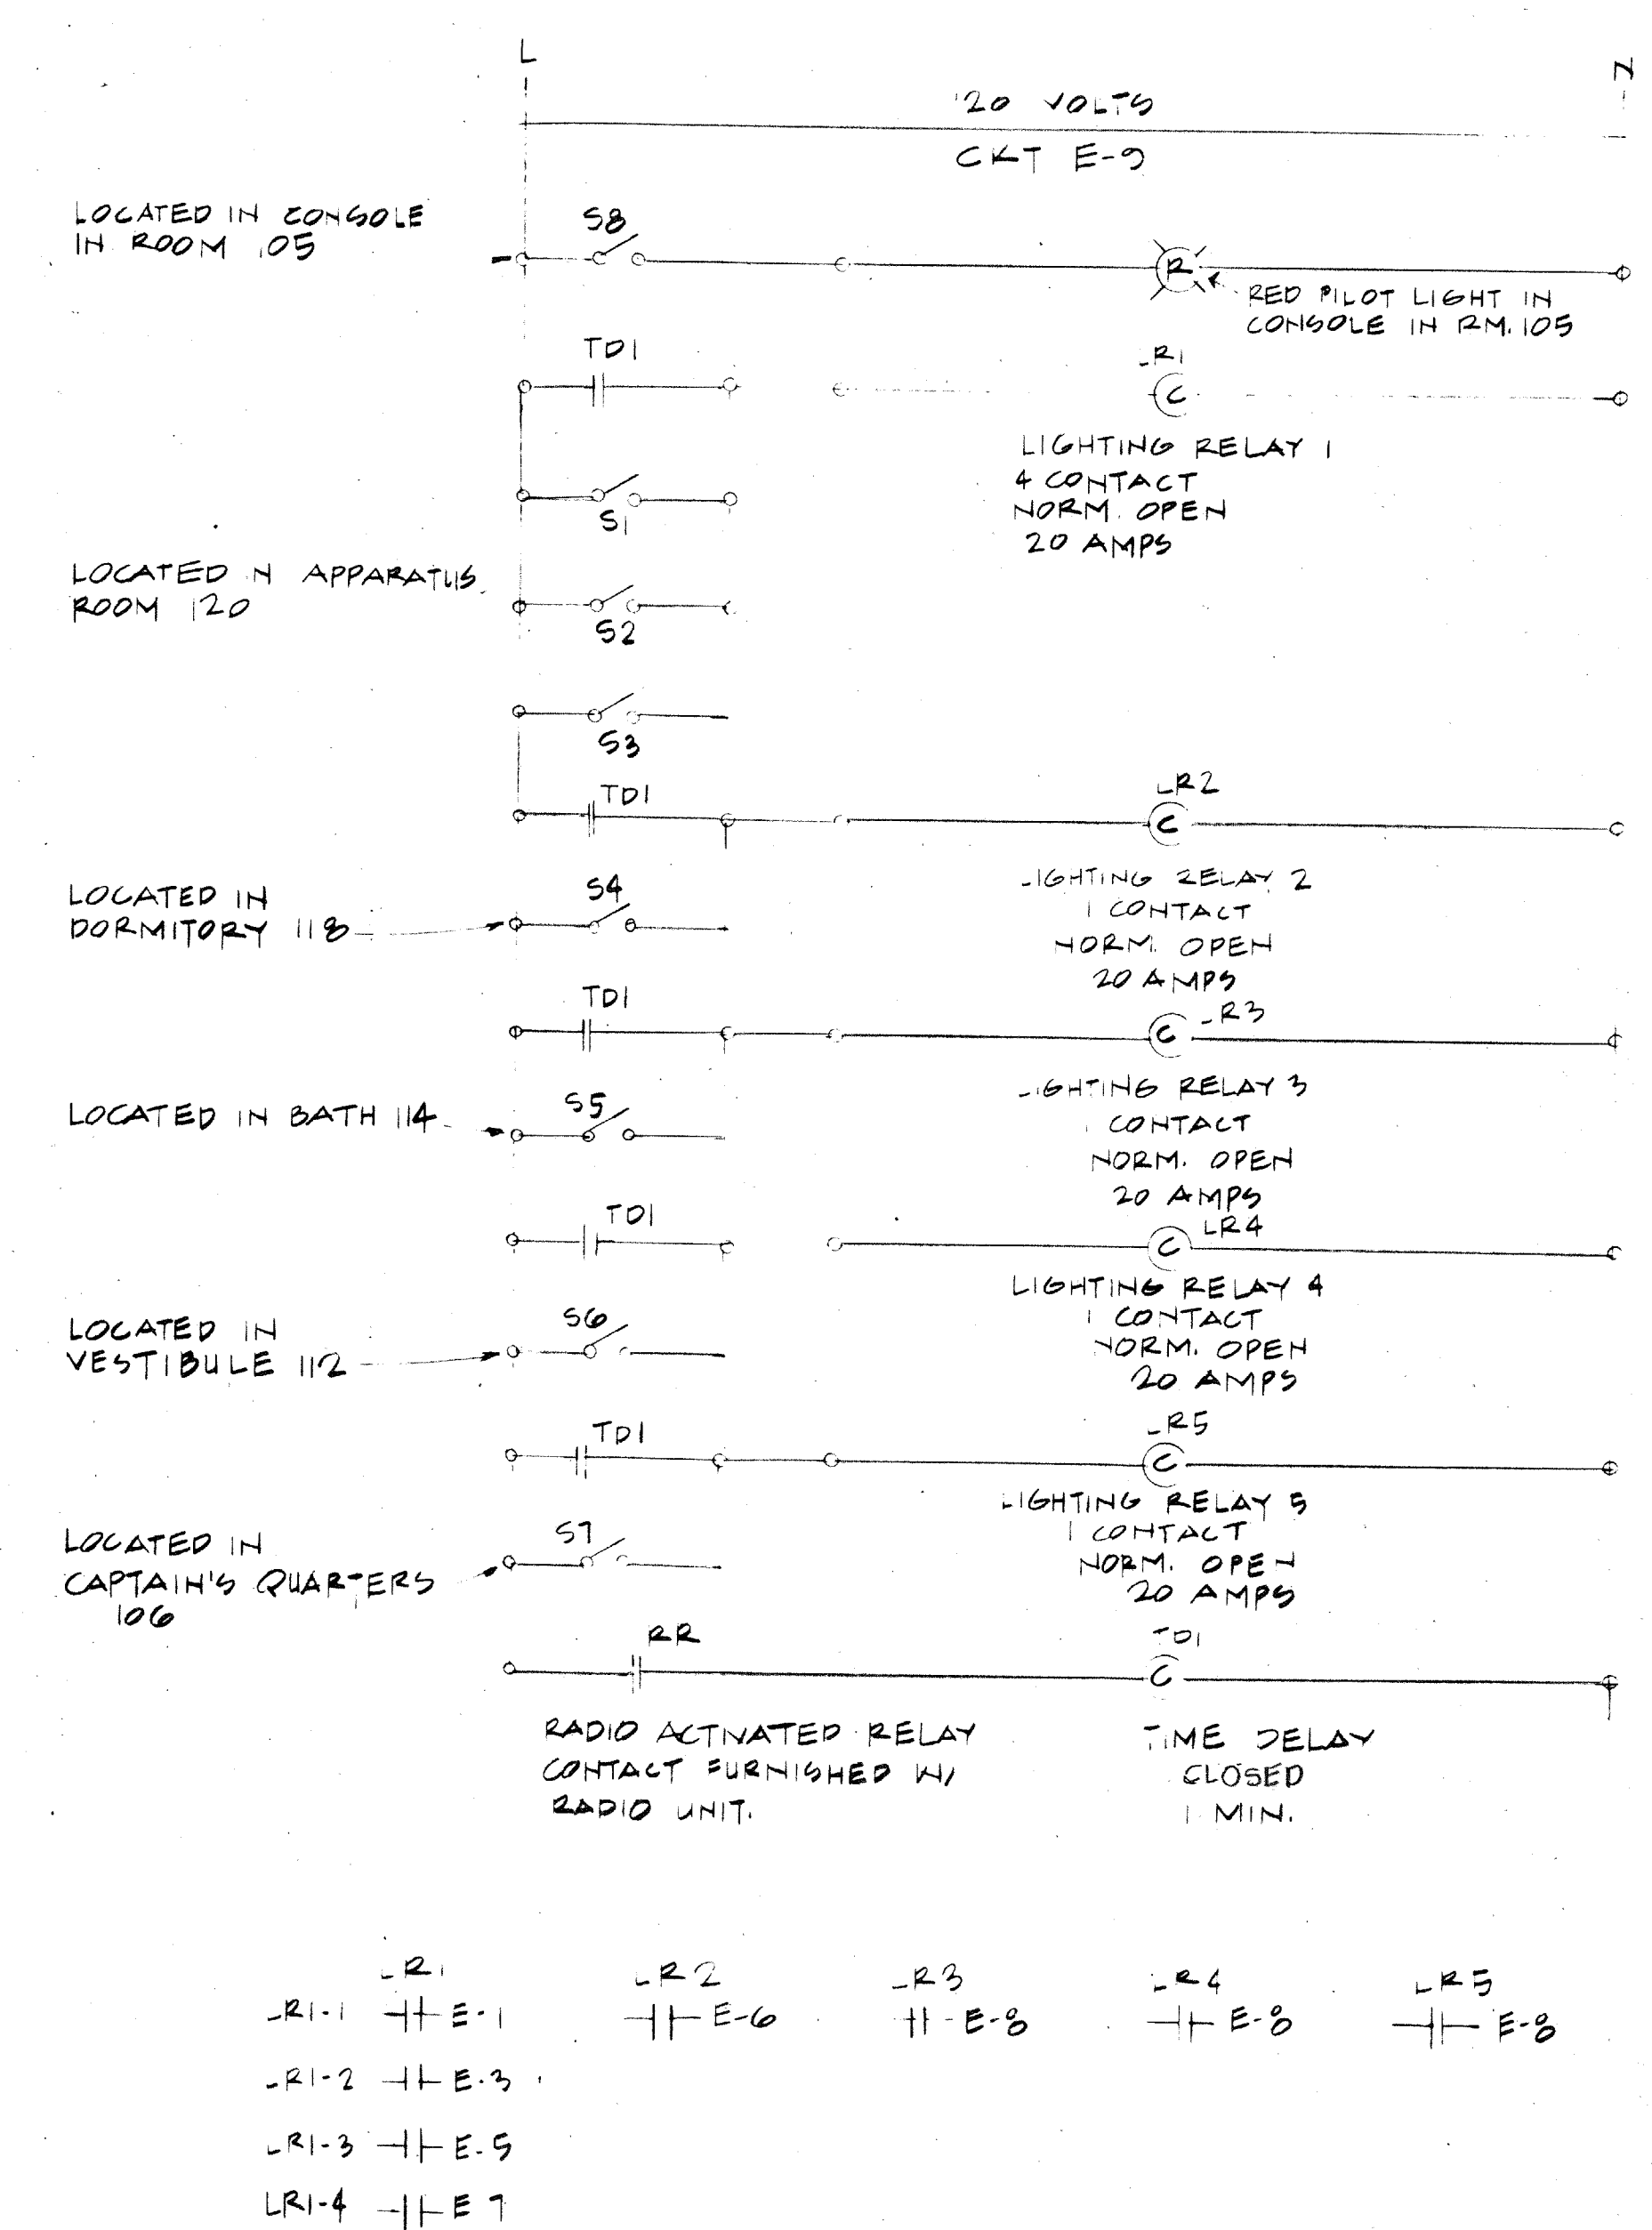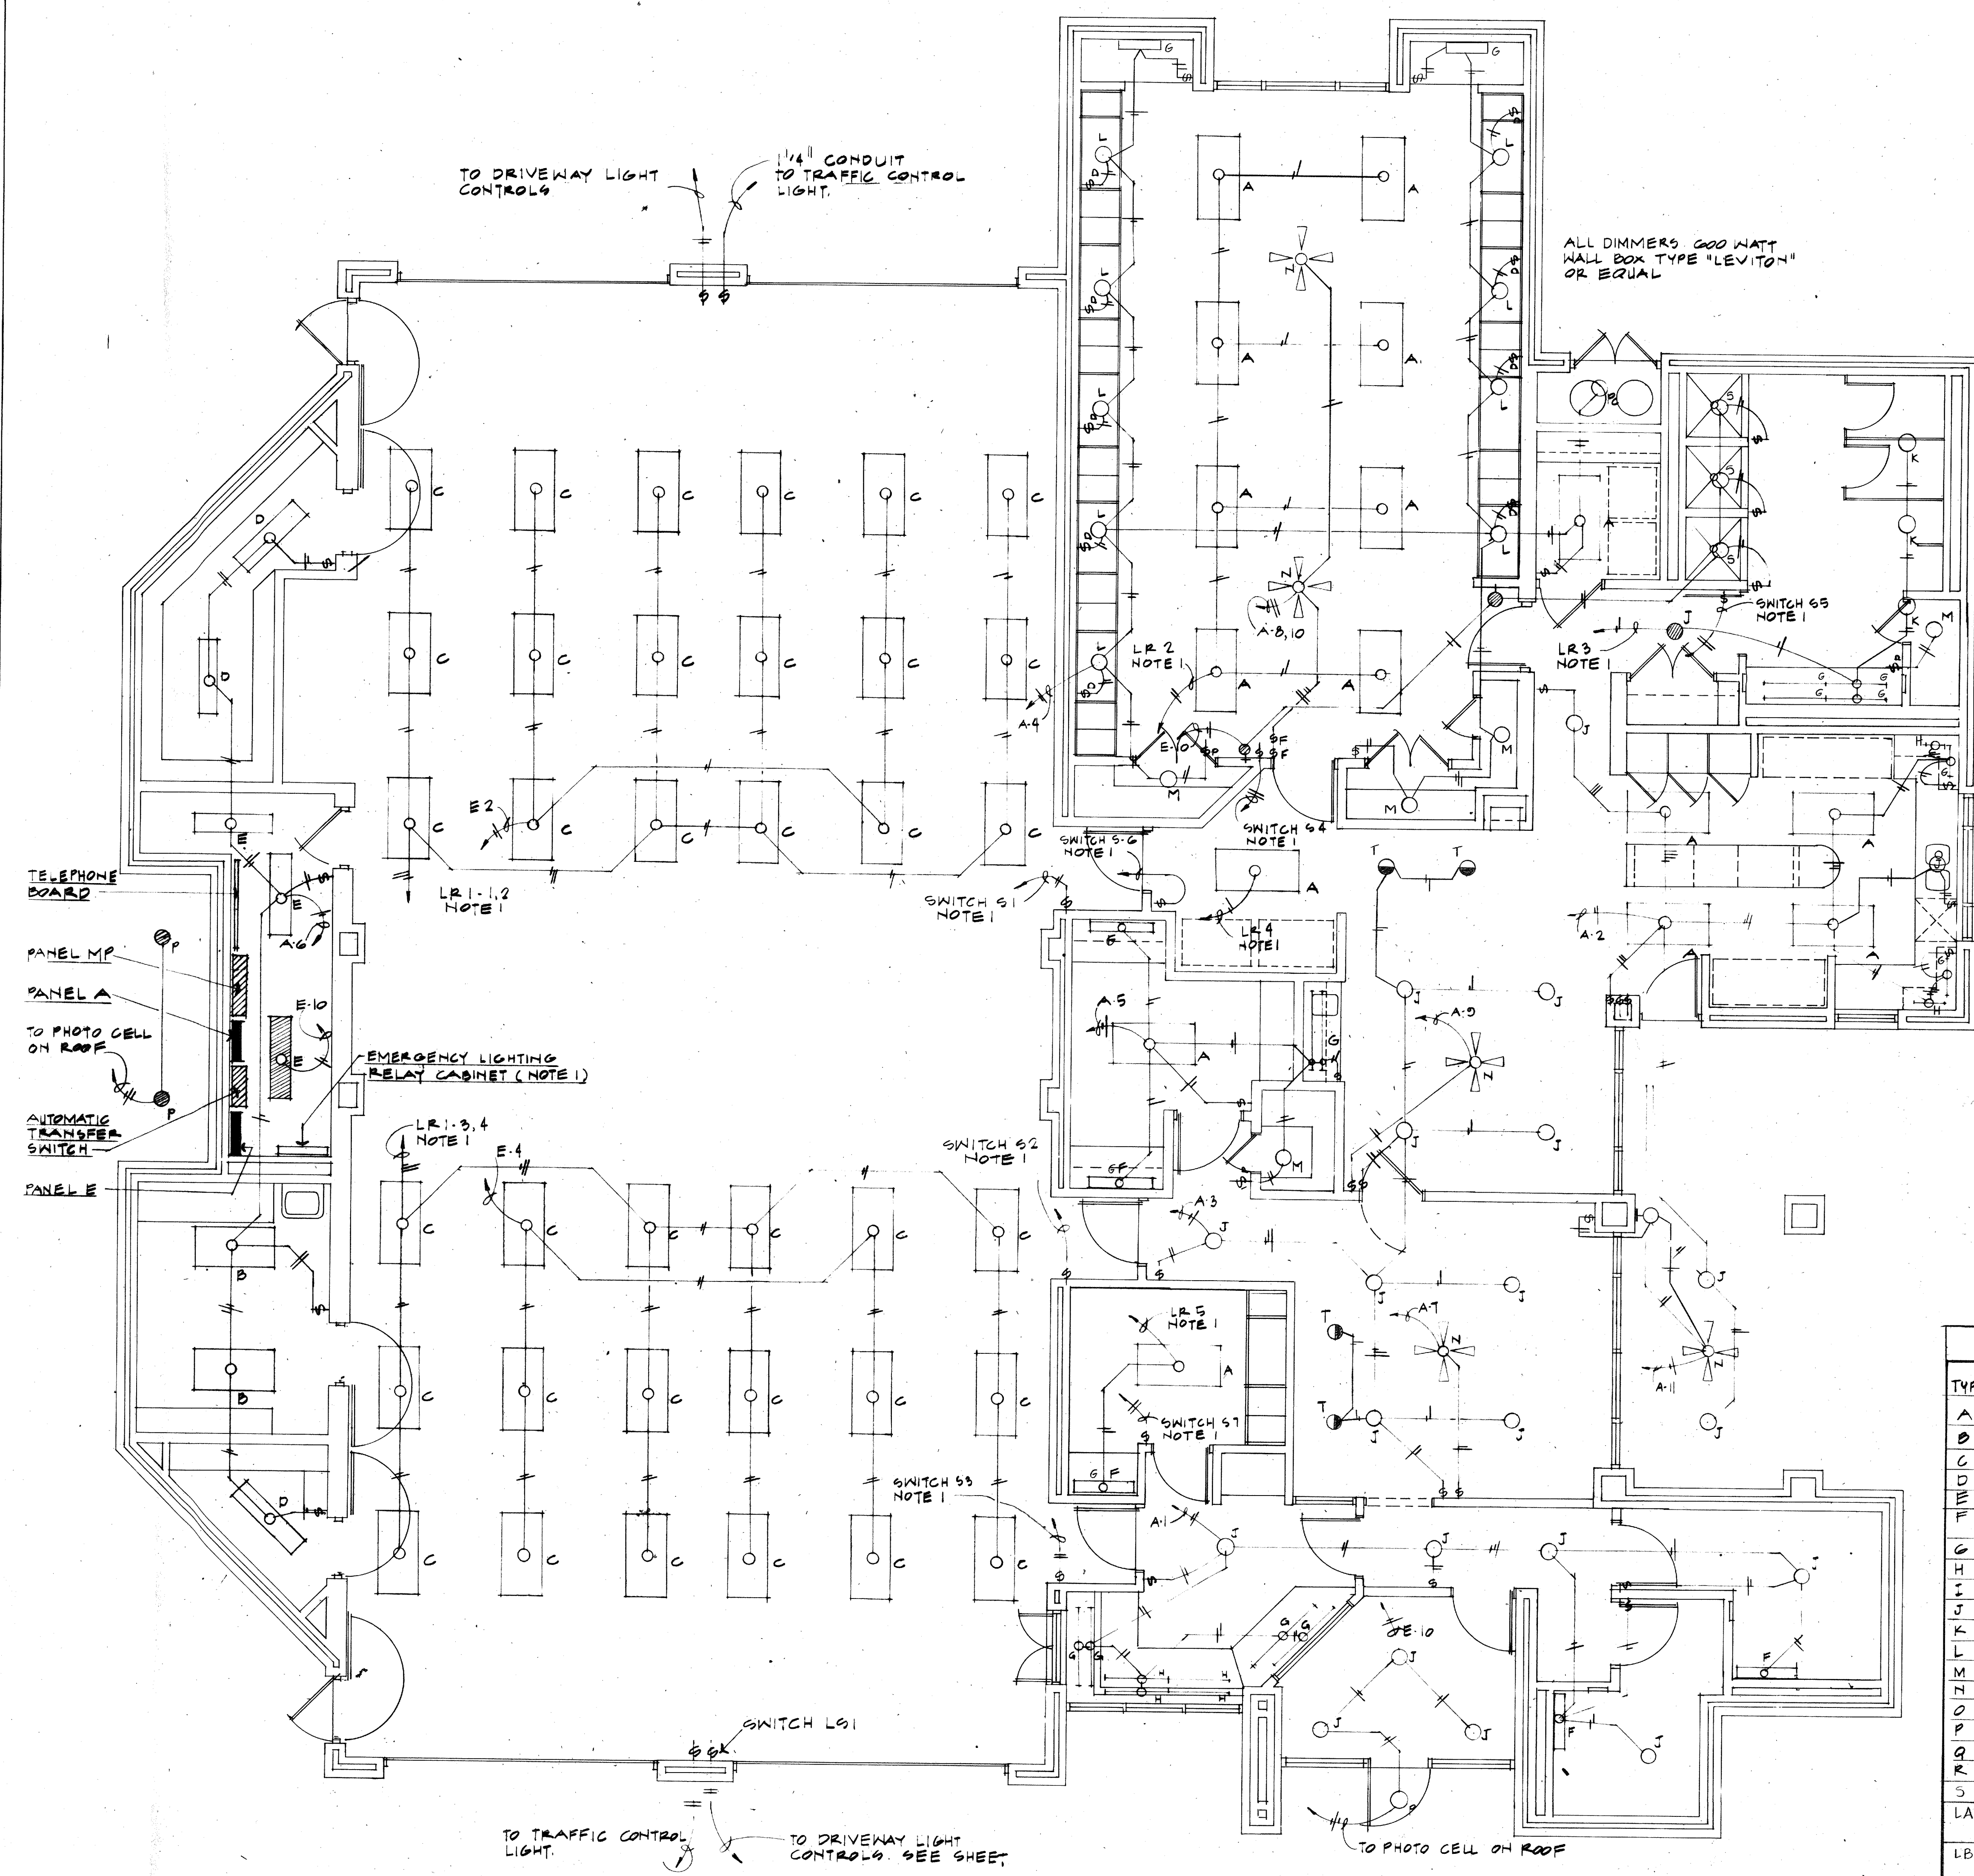

INTERIOR LIGHTING CONTROL DIAGRAM
 NO SCALE

LIGHTING FIXTURE SCHEDULE - CEILING FANS						
TYPE	MFG. CAT. NO.	VOLTS	LAMPS / FIX.	MOUNTING	REMARKS	
A	WRIGHT LIGHT R10-240-24 PA/2 RA	120	2-F40 CW	RECESSED	PRISMATIC ACRYLIC LENS	
B	WRIGHT LIGHT CKAM-240-M15	120	2-F40 CW	SURFACE	PRISMATIC ACRYLIC LENS	
C	WRIGHT LIGHT R0-440-24 PA/2-RA	120	4-F40 CW	RECESSED	PRISMATIC ACRYLIC LENS	
D	WRIGHT LIGHT CPA/2-240-12	120	2-F40 CW	SURFACE	WRAP AROUND LENS	
E	WRIGHT LIGHT S-48	120	1-F40 CW	CHAIN HUNG BAFF	WIRE GUARD	
F	DAYBRIGHT 35242	120	2-F30 CW	WALL MOUNTED AS DIRECTED	PRISMATIC ACRYLIC LENS	
G	WRIGHT LIGHT S-48	120	1-F40 CW	IN LIGHTING COVE		
H	SIMILAR TO G	120	1-F30 CW	IN LIGHTING COVE		
I	NOT USED					
J	LIGHTOLIER 7054	120	1-50 WATT A-10	RECESSED		
K	LIGHTOLIER 7084	120	1-15 WATT ER-30	WALL BRACKET	WHITE FINISH	
L	LIGHTOLIER 7050	120	1-15 WATT ER-30	RECESSED	BLACK MULTIGROOVE BAFF-E	
M	PASS AND SEYMOUR	120	1-100 WATT	SURFACE	WHITE FINISH	
N	CEILING FAN ENCON 43F-40 DESIGNER	120		SURFACE		
O	NOT USED					
P	LIGHTOLIER 7100	120	1-50W PAR 38 FLOW	RECESSED		
Q	NOT USED					
R	PASS AND SEYMOUR	120	1-100 WATT 4-10	SURFACE	PULL CHAIN	
S	HALO #H17-720	120	1-60W AM	RECESSED	SHOWFLIGHT	
LA	GARDCO #BH113-120-400MH-BRP WITH VALMONT #400C 200DI-PP-FBC	120	1-400, MH	POLE	PAINT POLE TO MATCH FIXTURE	
LB	GARDCO #BH11FM-120-400MH-BRP WITH VALMONT #400C 200DI-PP-FBC	120	1-400W, MH	POLE	PAINT POLE TO MATCH FIXTURE	
LC	GARDCO #BH11FS-120-175MH-BRP	120	1-175W, MH	WALL		
LD	GARDCO #BH11FS-120-175MH-BRP WITH VALMONT #400C140DI-PP-FBC	120	1-175W, MH	POLE	PAINT POLE TO MATCH FIXTURE	
T	LIGHTOLIER #7024	120	1-100W, A19	RECESSED	WASHER	

E301 LIGHTING PLAN
 SC-1/4"=1'-0"

NOTES:
 1. SEE ALARM ACTIVATED LIGHTING SCHEMATIC THIS SHEET.

OVERLAY RECIPES	