



REVISIONS
 NO. DATE REVISION
 1 11/15/95
 2 11/15/95
 3 11/15/95
 100 11/15/95

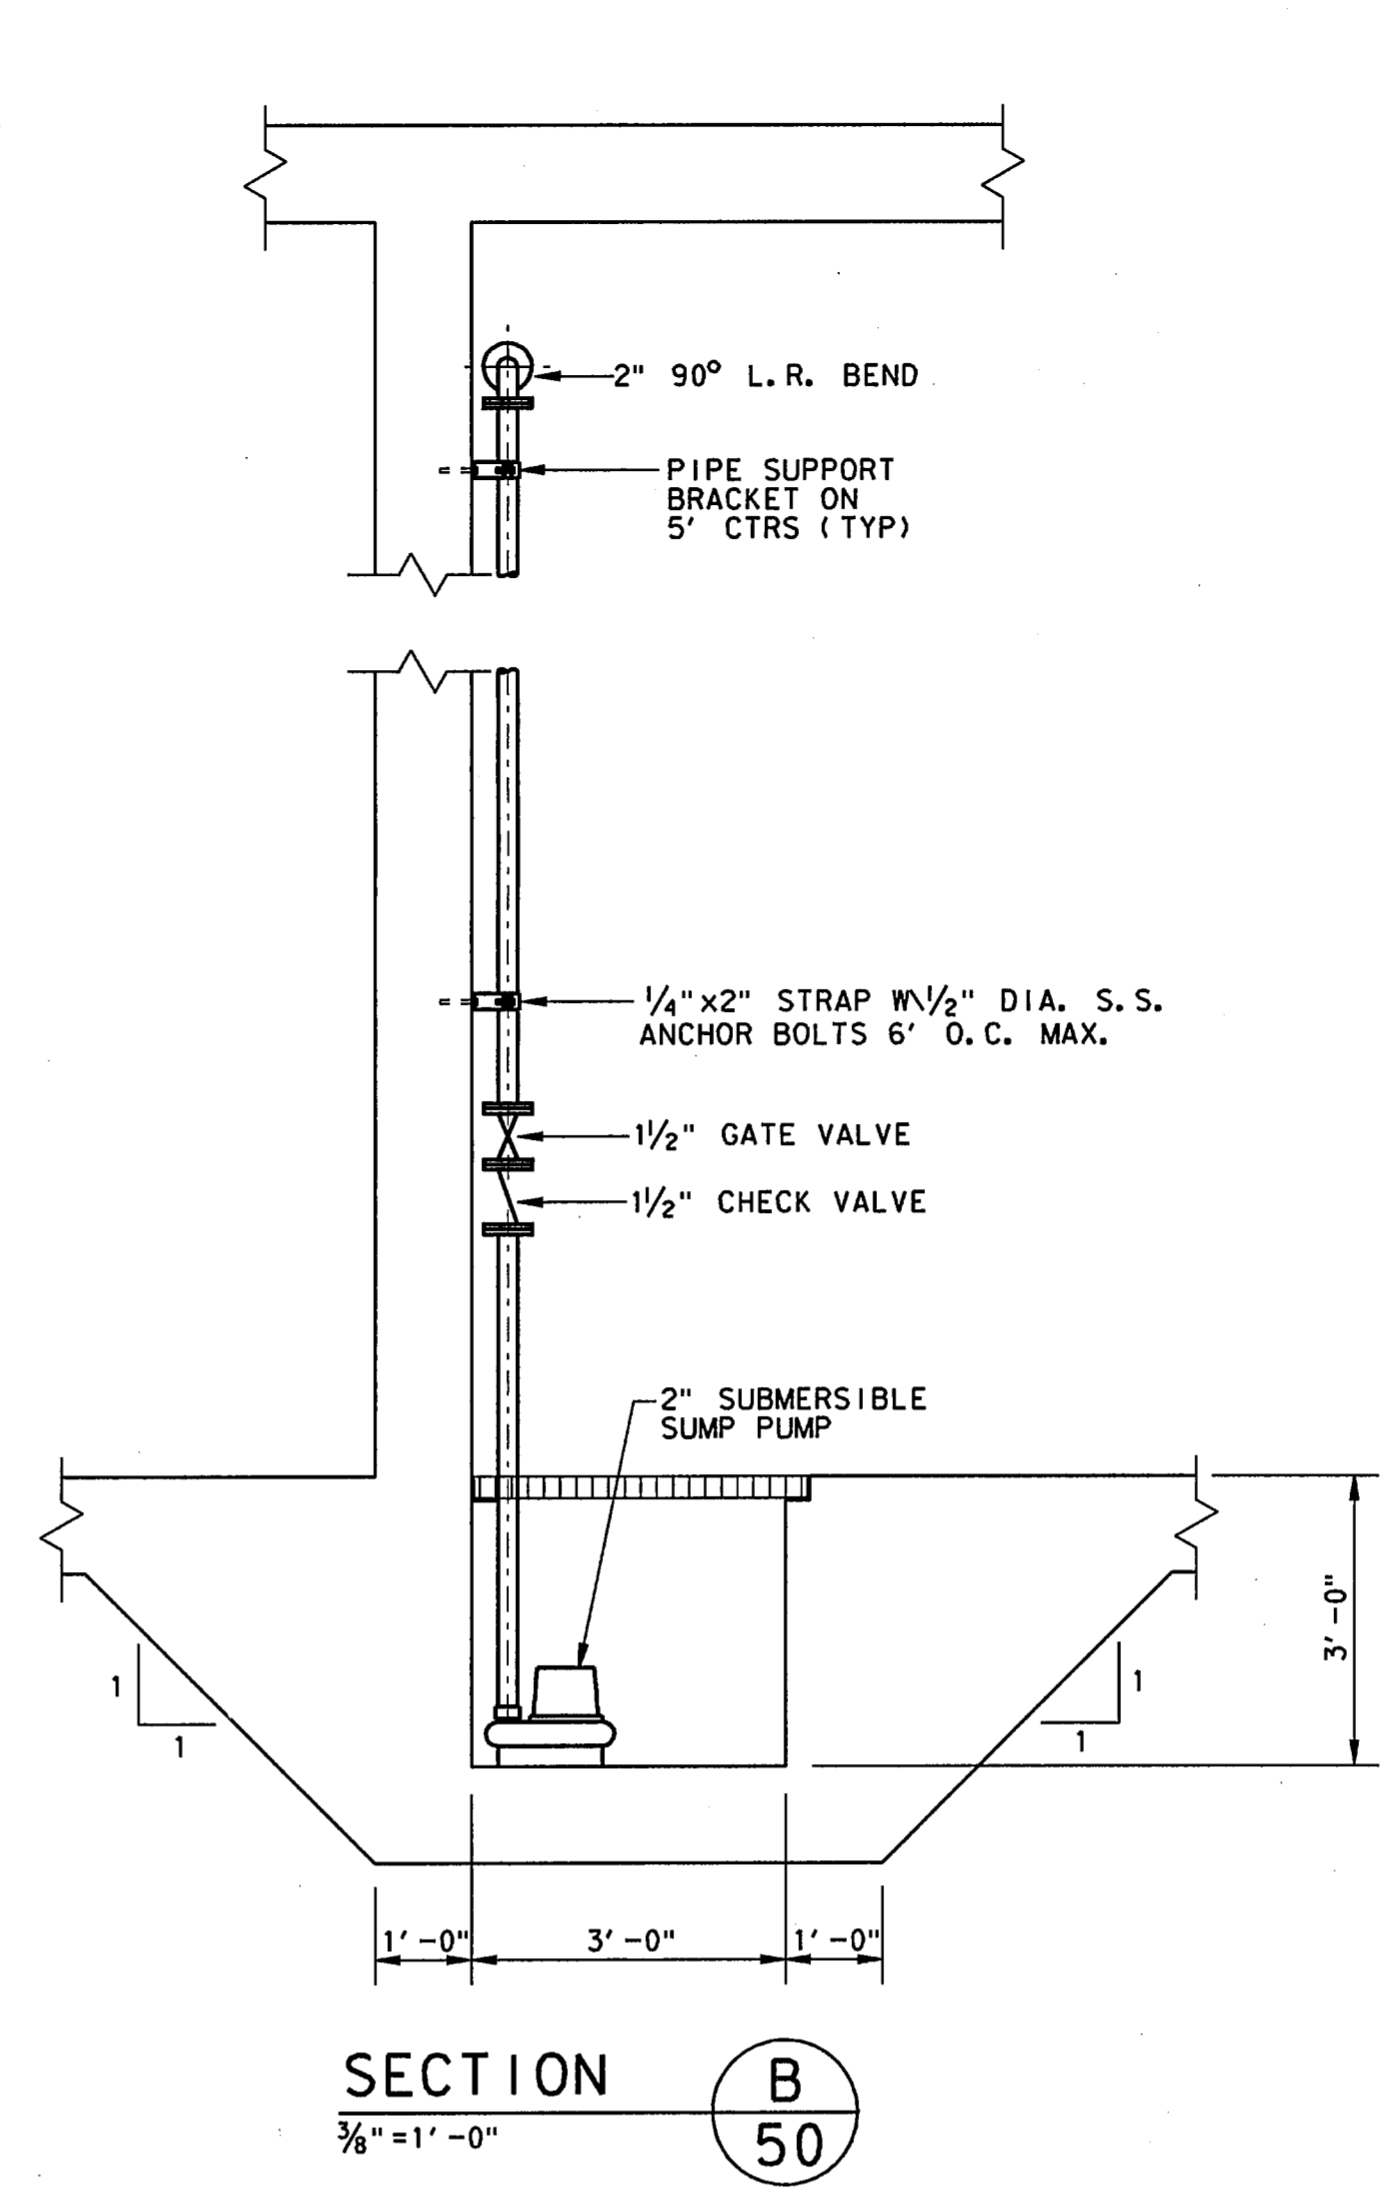

| 4 | | | |
|---|------------|----------|------------|
| 3 | | | |
| 2 | | | |
| 1 | | | |
| NO. | DATE | REVISION | APPROV. |
| TOWN OF ADDISON, TEXAS | | | |
| MIDWAY/BELTLINE SANITARY SEWER PHASE II | | | |
| LIFT STATION MECHANICAL PLAN SECTIONS | | | |
| Carter & Burgess <small>Consultants in Engineering, Architecture, Planning and the Environment</small> CARTER & BURGESS, INC. <small>7950 EMBROOK DRIVE, SUITE 250 DALLAS, TX 75247-4961</small> | | | |
| Unit | Scale | Date | 04-05-96 |
| Designed | J. Lindner | Checked | J. Lindner |
| Drawn | R. Howman | Approved | J. Lindner |
| Job No. | 93327601D | Sheet | 51 of 63 |

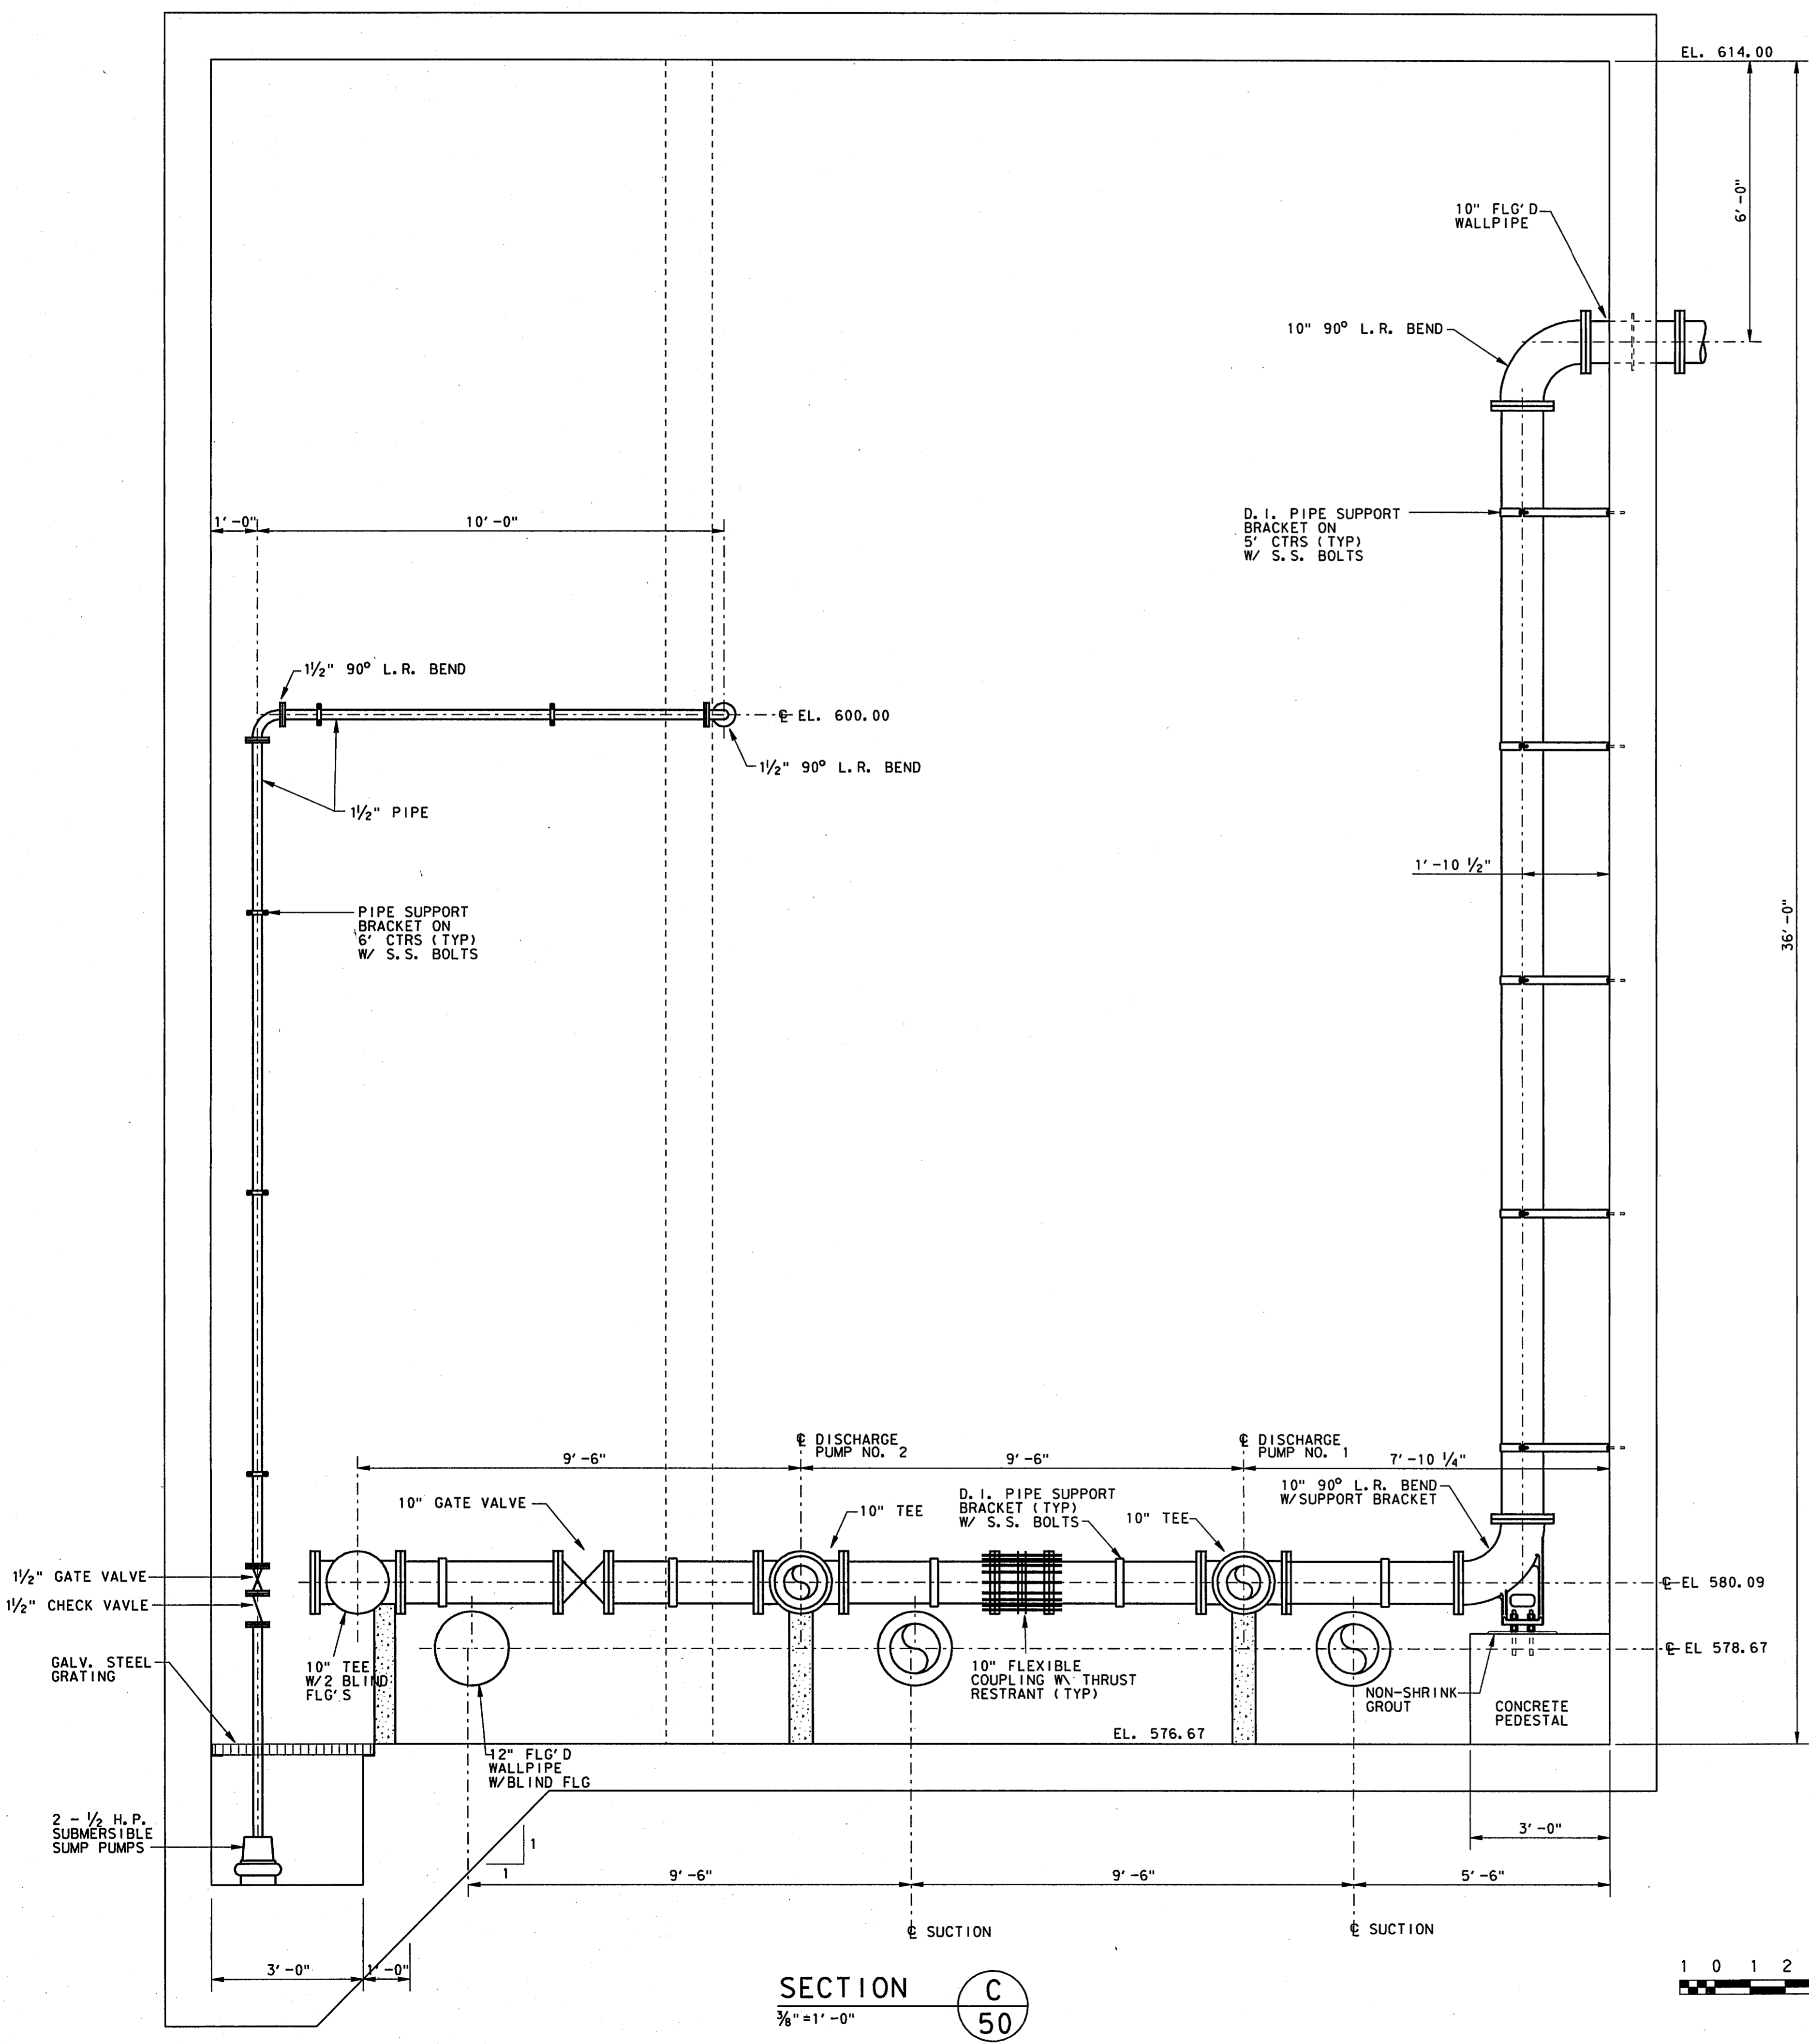