



A LOWER LEVEL LIGHTING/POWER
SCALE: 1/4" = 1'-0"

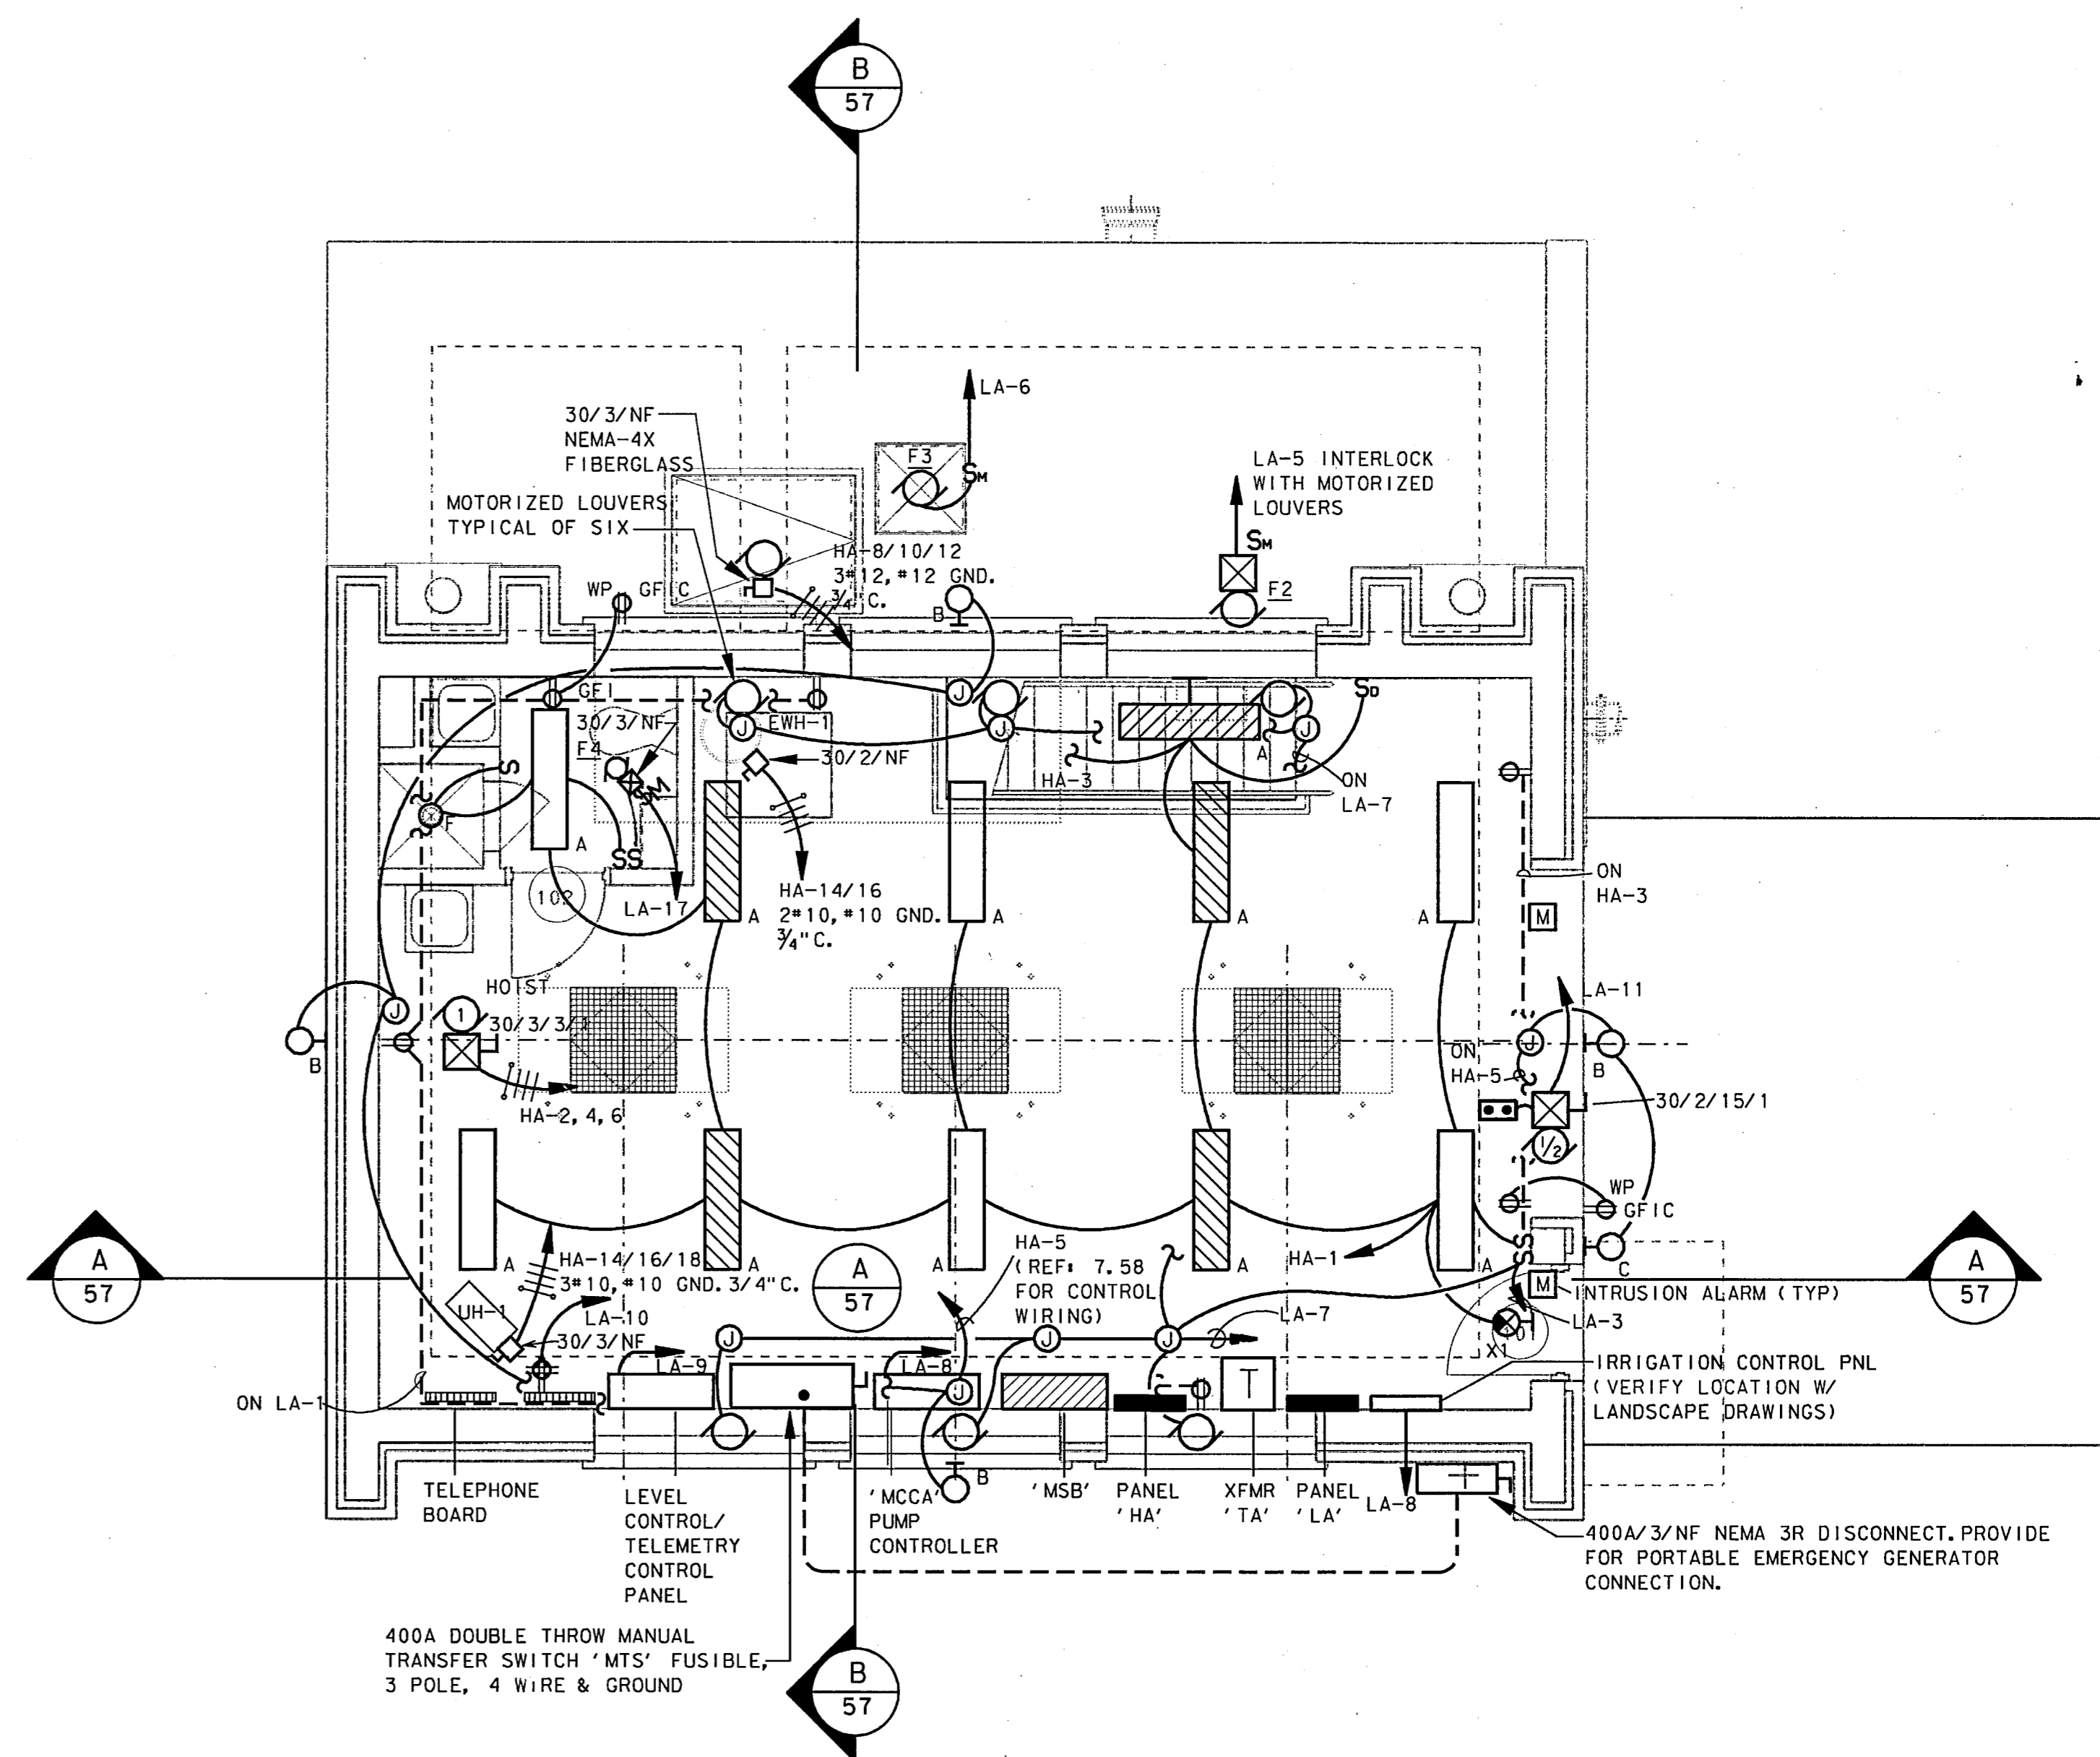

B GROUND LEVEL LIGHTING/POWER
SCALE: 1/4" = 1'-0"

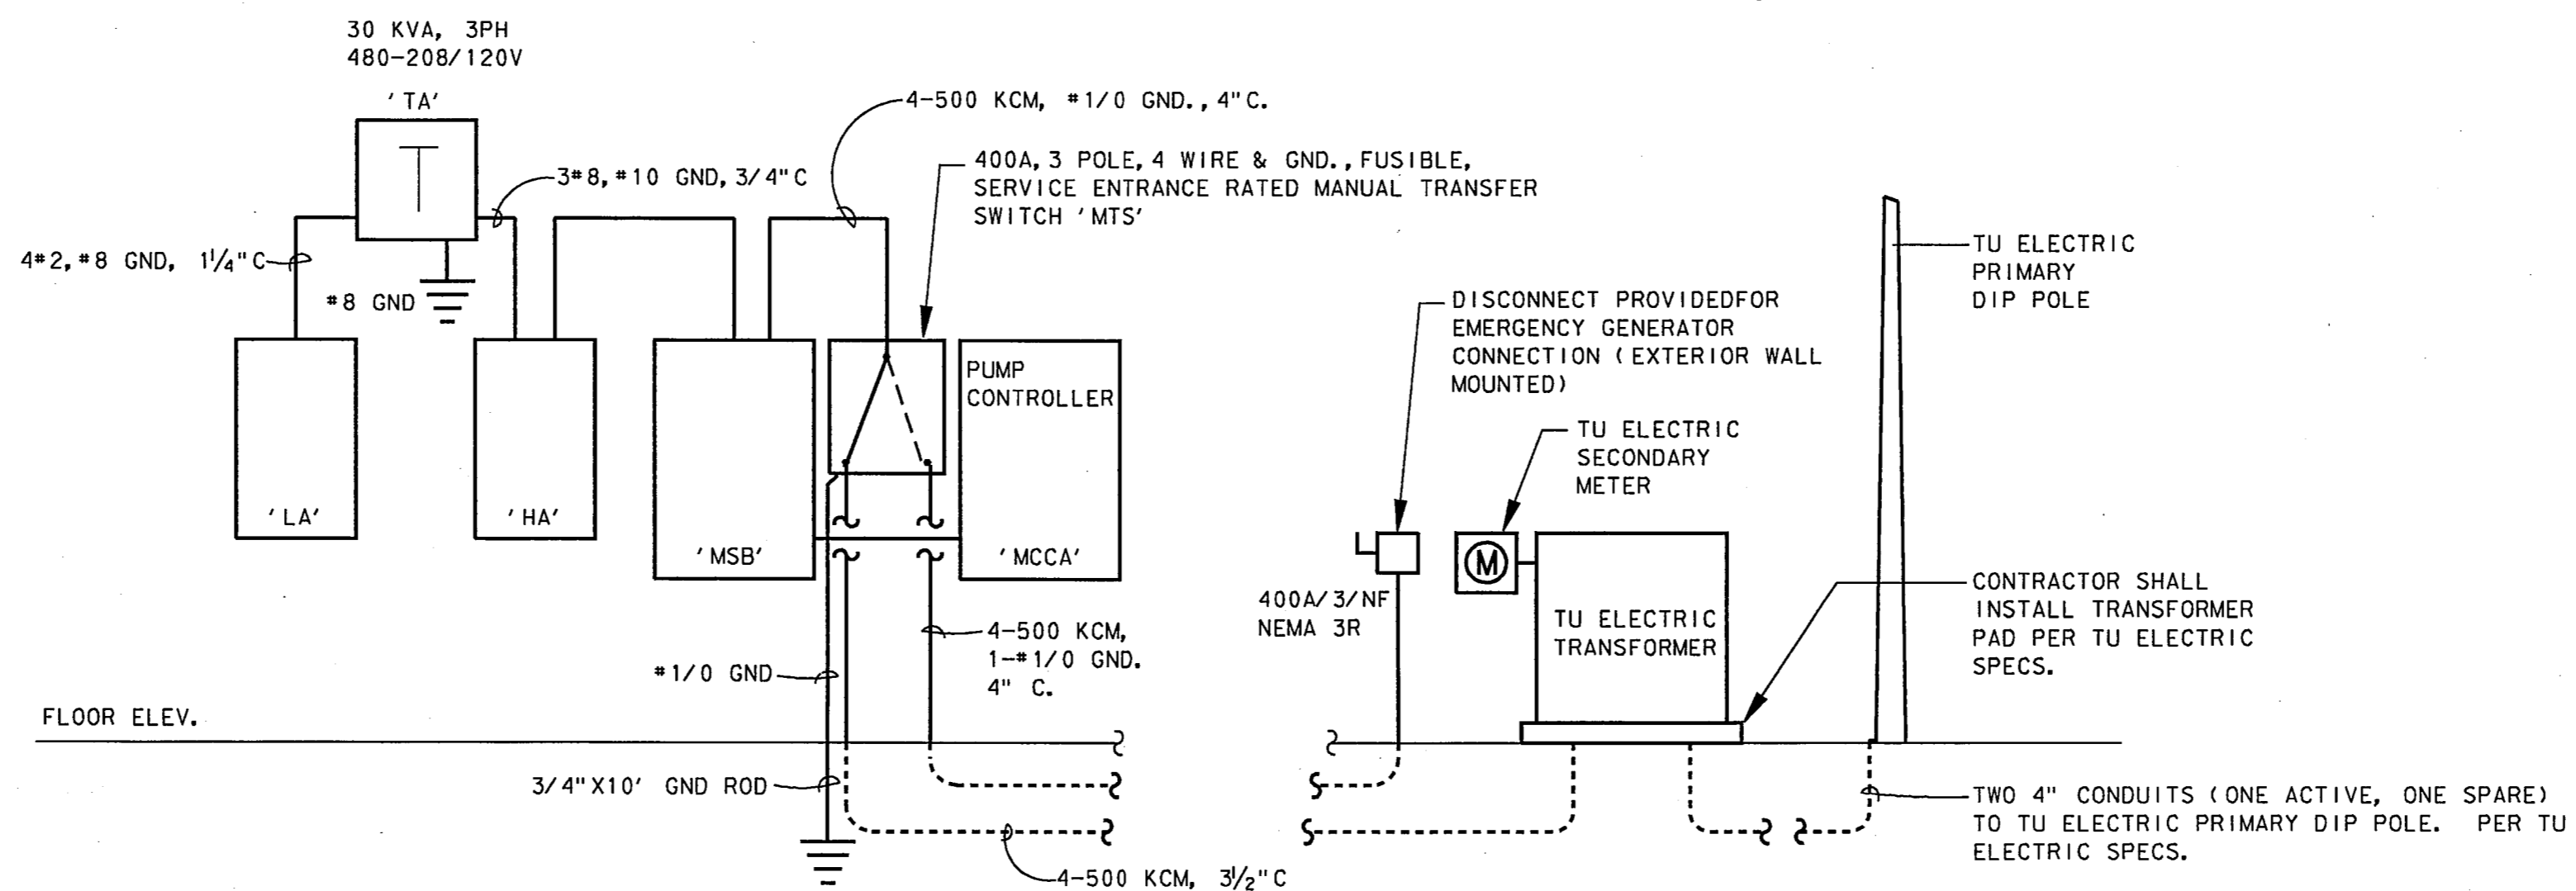


C ELECTRICAL RISER DIAGRAM
SCALE: NO SCALE

4			
3			
2			
1			
NO.	DATE	REVISION	APPROV.

TOWN OF ADDISON, TEXAS
MIDWAY/BELTLINE SANITARY SEWER
PHASE II
LIFT STATION
ELECTRICAL FLOOR PLAN

Carter Burgess
Consultants in Engineering, Architecture,
Planning and the Environment
CARTER & BURGESS, INC.
7950 ELMBROOK DRIVE, SUITE 250
DALLAS, TX 75247-4961

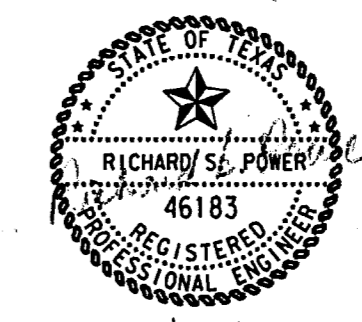

Unit#	Scale	Date	04-05-96
Designed	R. F. Power	Checked	R. F. Power
Drawn	J. WEBB	Approved	J. Lindner
		Job No.	93327601D
		Sheet	56 of 63