

SCHEDULE OF DRAWINGS

ARCHITECTURAL

- A1 · SITE PLAN
- A2 · GROUND LEVEL FLOOR PLAN
- A3 · SECOND LEVEL FLOOR PLAN
- A4 · EXTERIOR ELEVATIONS
- A5 · ROOF PLAN, ELEVATION
- A6 · PARTIAL BUILDING SECTION
- A7 · WALL SECTIONS
- A8 · INTERIOR ELEVATIONS
- A9 · DOOR SCHEDULE
- A10 · ROOM FINISH SCHEDULE, 1/4" PLAN DETAILS
- A11 · PARTIAL BUILDING SECTIONS
- A12 · DOOR / WINDOW DETAILS
- A13 · CONSTRUCTION DETAILS
- A14 · CONSTRUCTION DETAILS
- A15 · REFLECTED CEILING PLANS

STRUCTURAL


- S1 · FOUNDATION PLAN
- S2 · SECOND FLOOR, & LOW ROOF FRAMING PLAN
- S3 · ROOF FRAMING PLAN, DETAILS
- S4 · DETAILS, NOTES, & SCHEDULES
- S5 · DETAILS
- S6 · DETAILS
- S7 · DETAILS

MECHANICAL, ELECTRICAL, & PLUMBING

- MEP1 · UTILITY SITE PLAN
- M2 · GROUND FLOOR PLAN
- M3 · SECOND FLOOR PLAN
- M4 · SCHEDULES / DETAILS
- P2 · GROUND FLOOR PLAN
- P3 · SECOND FLOOR PLAN
- P4 · SCHEDULES / DETAILS
- P5 · RISER DIAGRAMS
- E2 · GROUND FLOOR PLAN-LIGHTING
- E3 · GROUND FLOOR PLAN-POWER
- E4 · SECOND FLOOR PLAN-LIGHTING
- E5 · SECOND FLOOR PLAN-POWER
- E6 · GROUND FLOOR COMMUNICATIONS SYSTEM
- E7 · ELECTRICAL RISER DIAGRAM / SCHEDULES

NOTES


1. FINISH GRADES SHOWN INDICATE ASSUMED GRADES FOR FOUNDATION DESIGN PURPOSES ONLY. FINISH GRADING IS NOT IN CONTRACT.

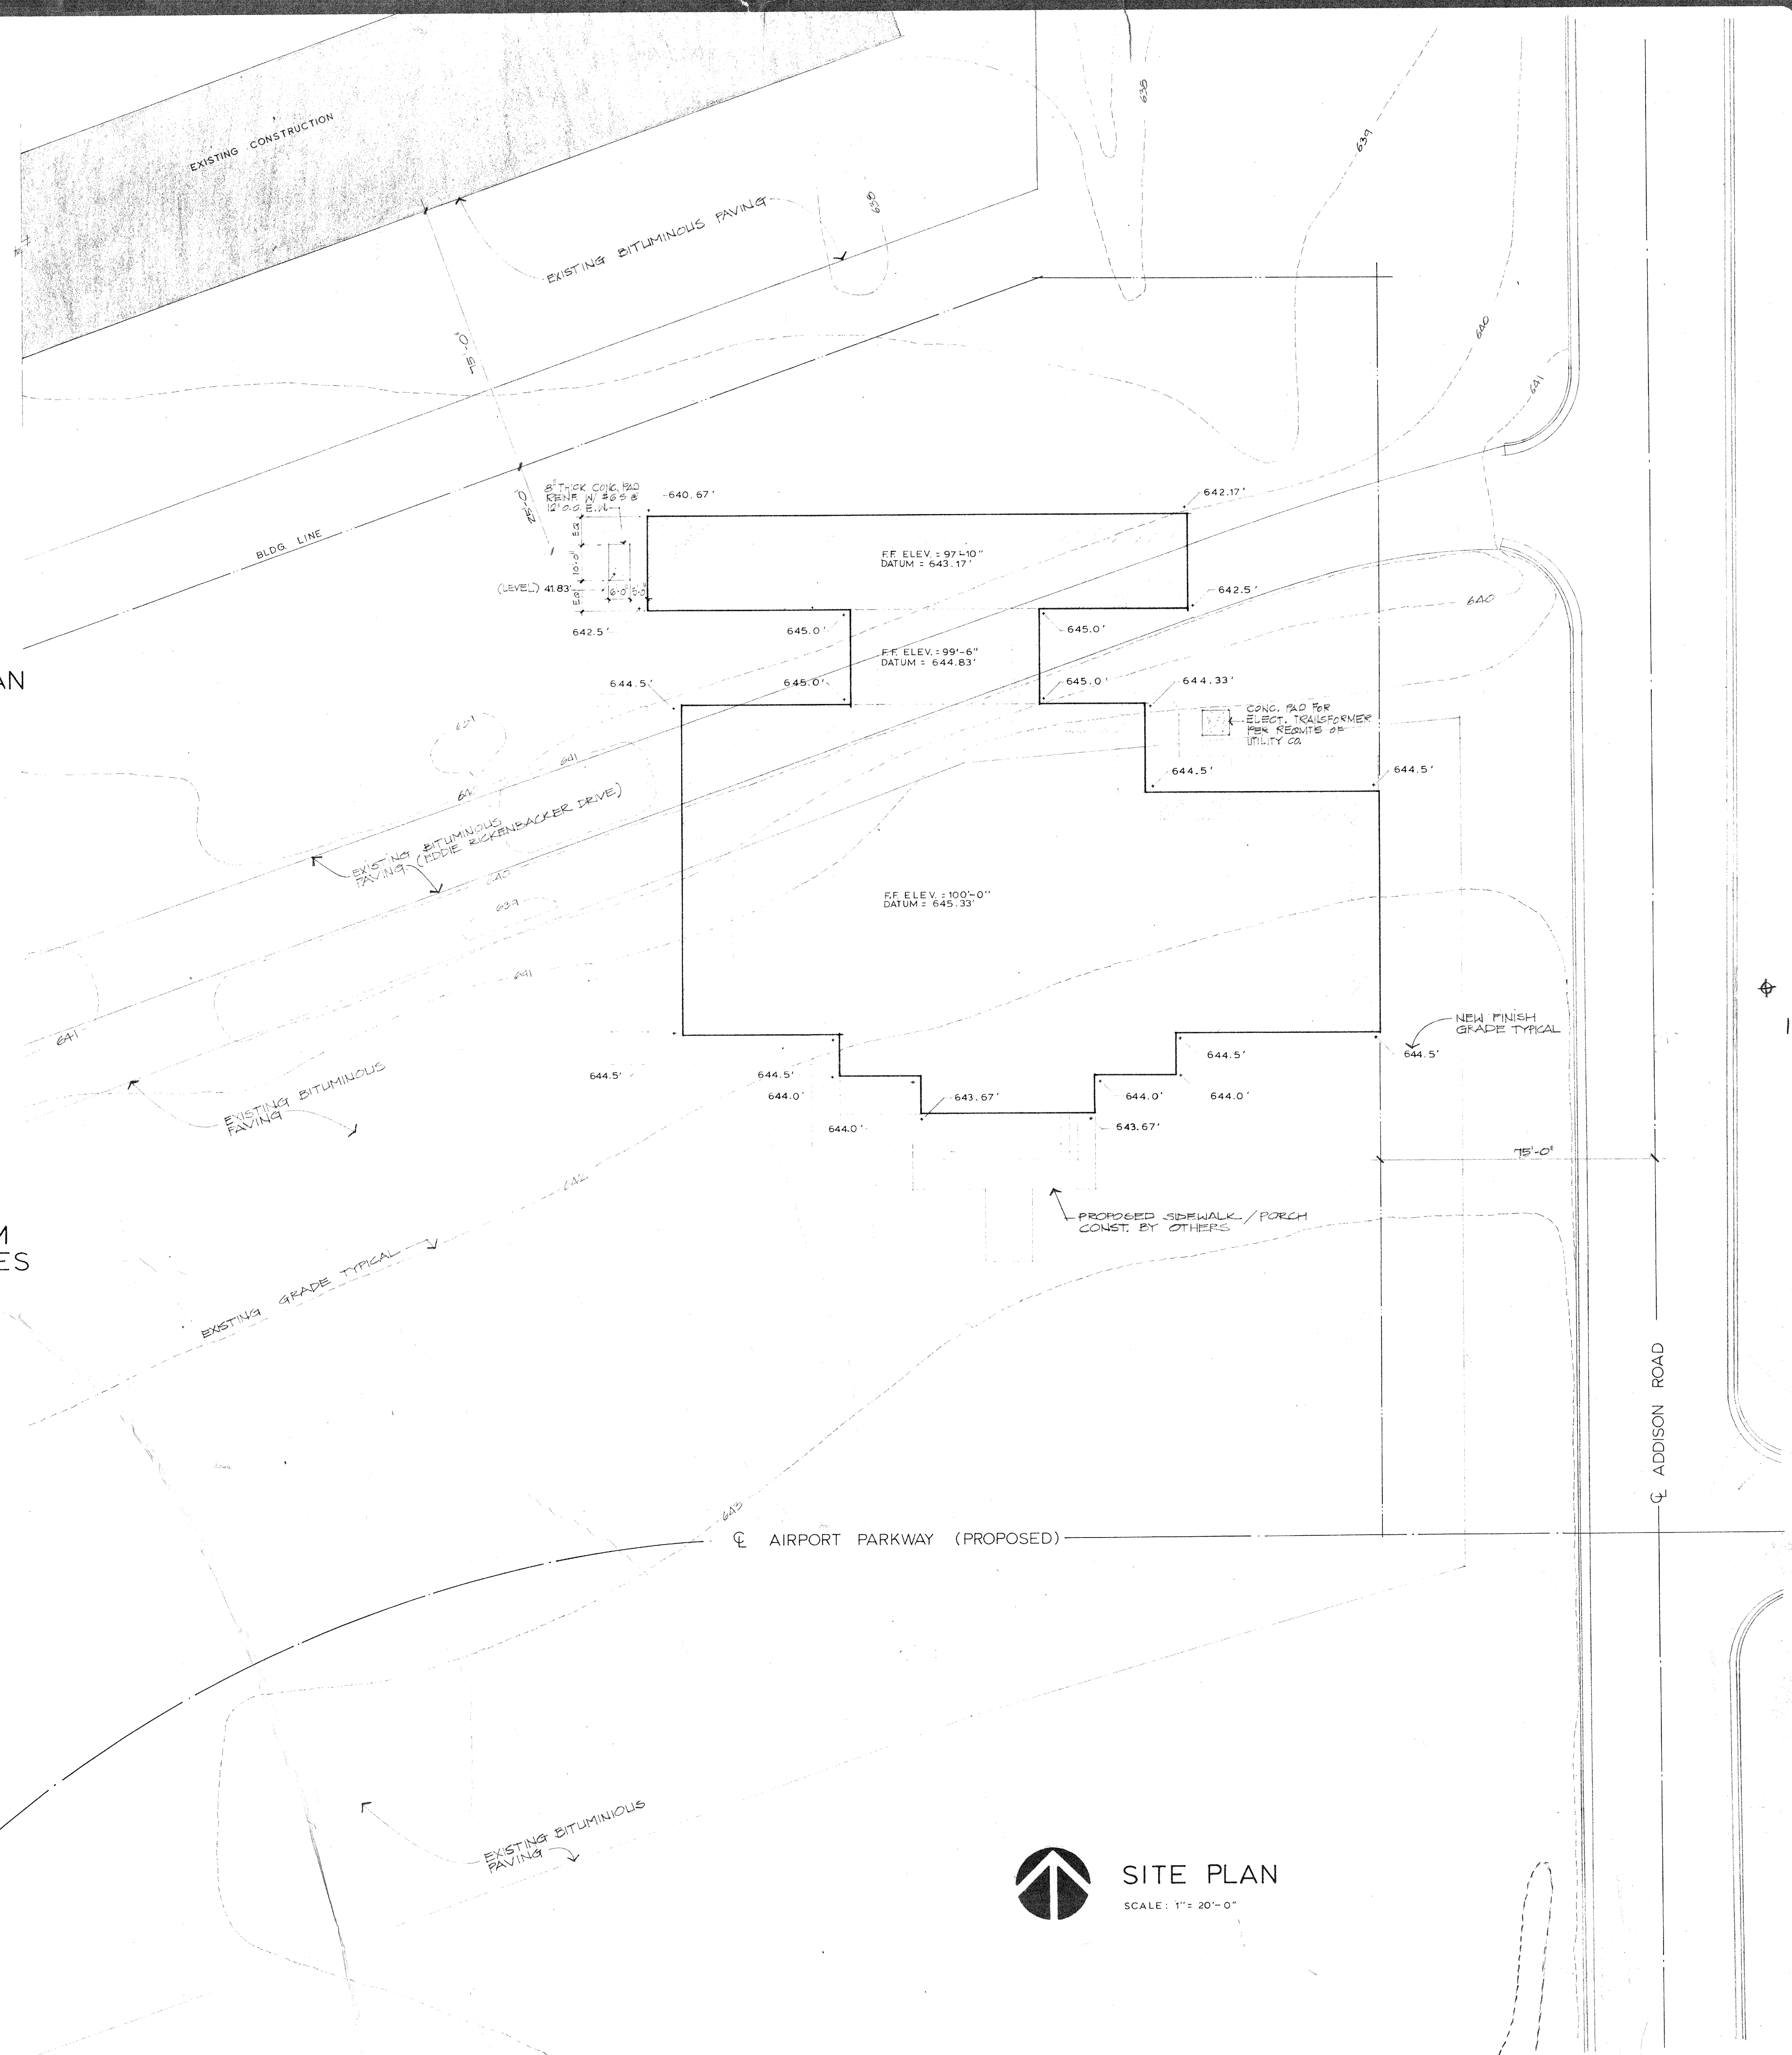

 SITE PLAN
SCALE: 1" = 20'-0"

SHEPHERD + BOYD
ARCHITECTS/PLANNERS & INTERIORS
8205 DOUGLAS AVENUE
SUITE 500
DALLAS, TEXAS 75203
TELEPHONE 214/691-5000

A NEW POLICE FACILITY FOR THE
TOWN OF ADDISON
47 AIRPORT PARKWAY

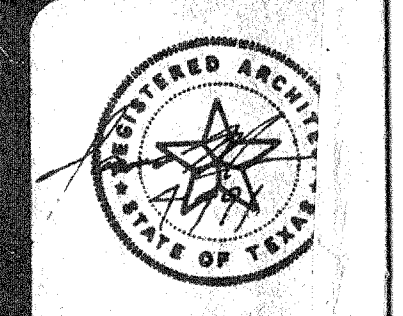

REVISION

DATE
JULY 12 1982
JOB NO. 318

SHEET
A1