


CITY OF ADDISON DALLAS COUNTY, TEXAS

CONSTRUCTION PLANS FOR:

ACADEMY DRIVE WASTEWATER METER STATION

INDEX TO DRAWINGS

TITLE	SHEET
PLAN AND DETAILS	1
SITE PLAN AND DETAILS	2

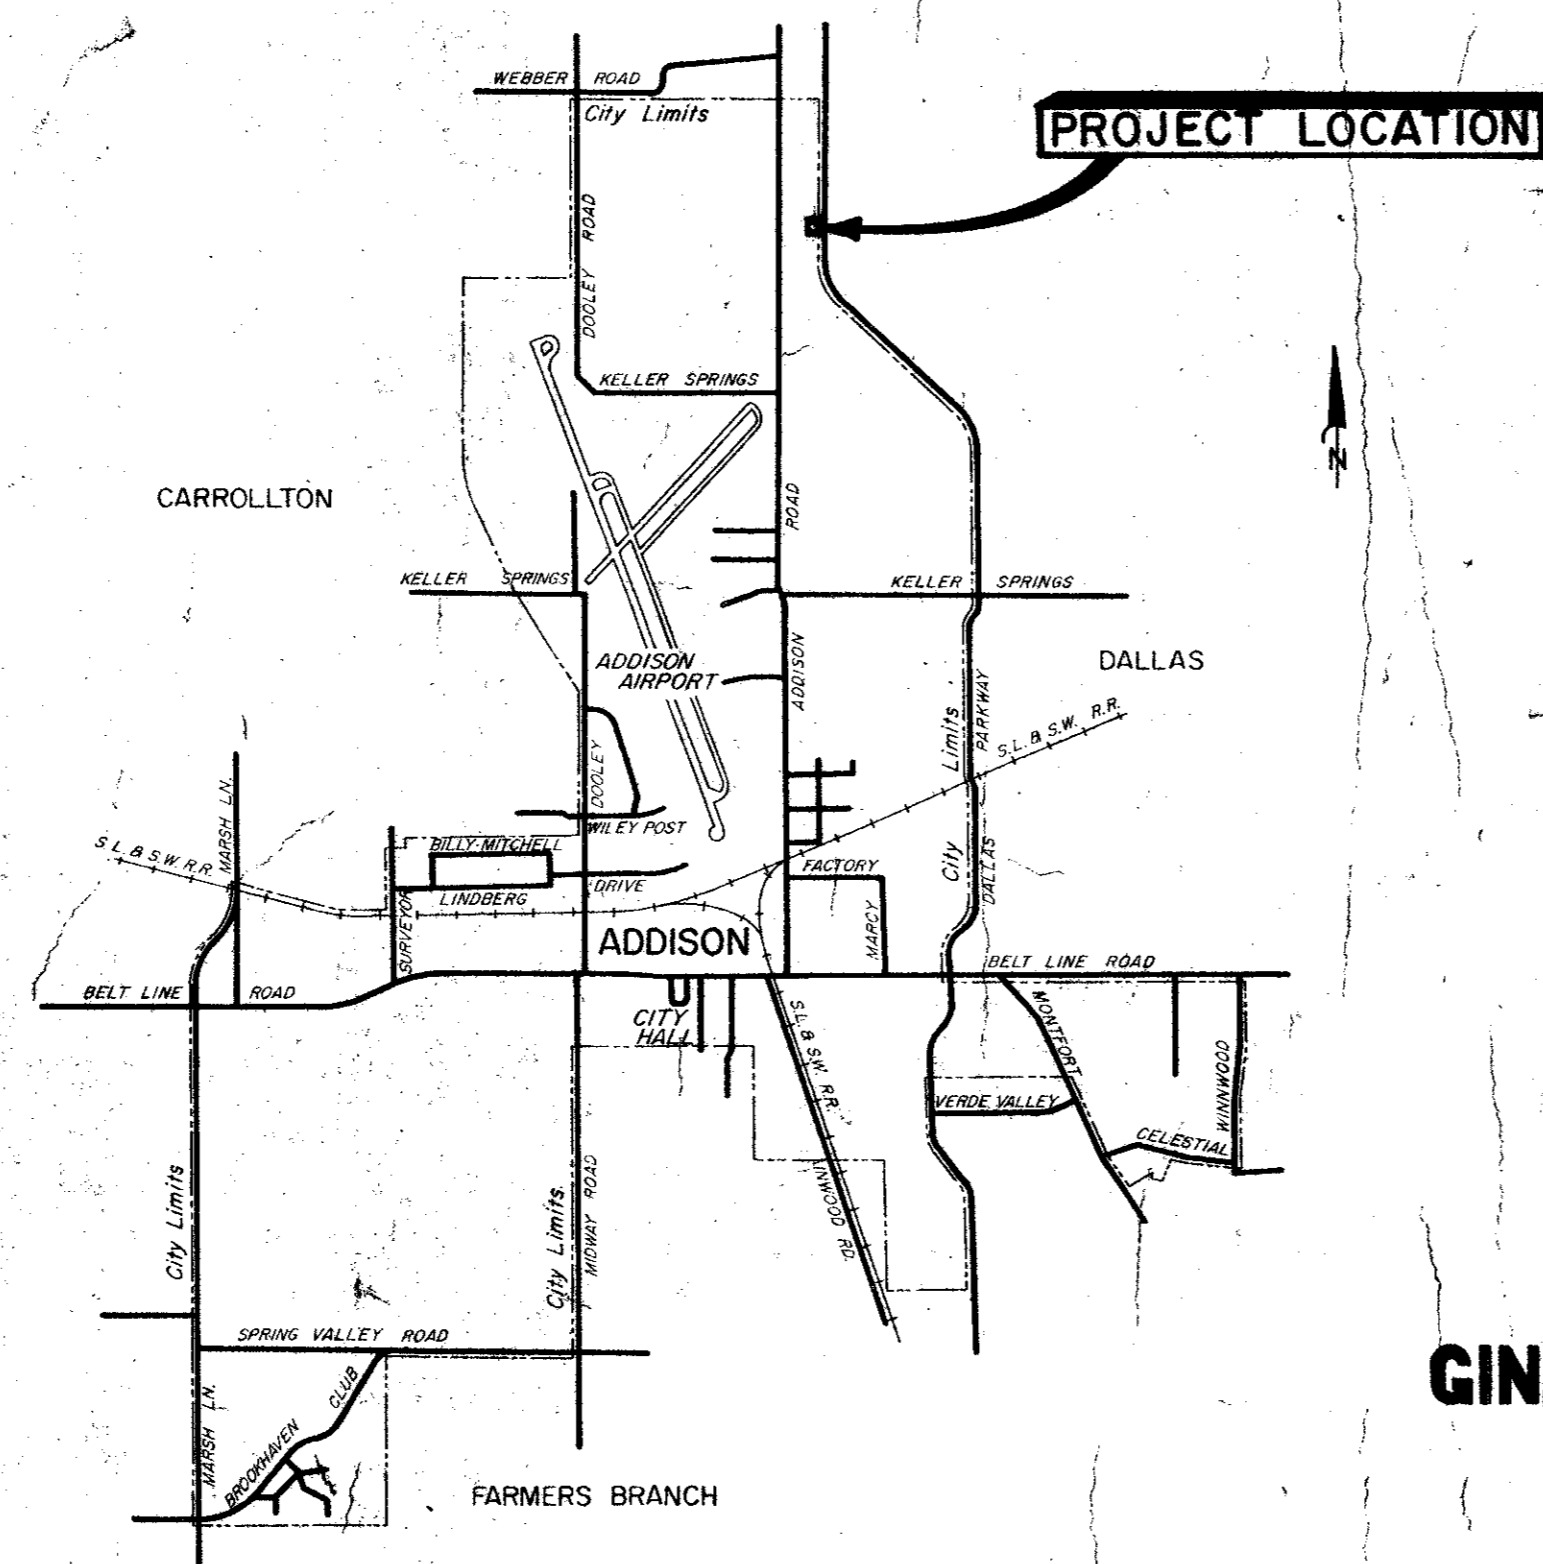

JERRY J. REDDING - MAYOR
COUNCILMEN:

JOHN B. ALLEN
RICHARD RODER
WILLIAM F. SELLMAYER
A. E. MARCY
TERRY ROBERTS

J. MILLIGAN - CITY ADMINISTRATOR

GINN & STACY, INC.
CONSULTING ENGINEERS
DALLAS, TEXAS
1978


CITY OF ADDISON DALLAS COUNTY, TEXAS

CONSTRUCTION PLANS FOR:

ACADEMY DRIVE WASTEWATER METER STATION

INDEX TO DRAWINGS

TITLE	SHEET
PLAN AND DETAILS	2
SITE PLAN AND DETAILS	3

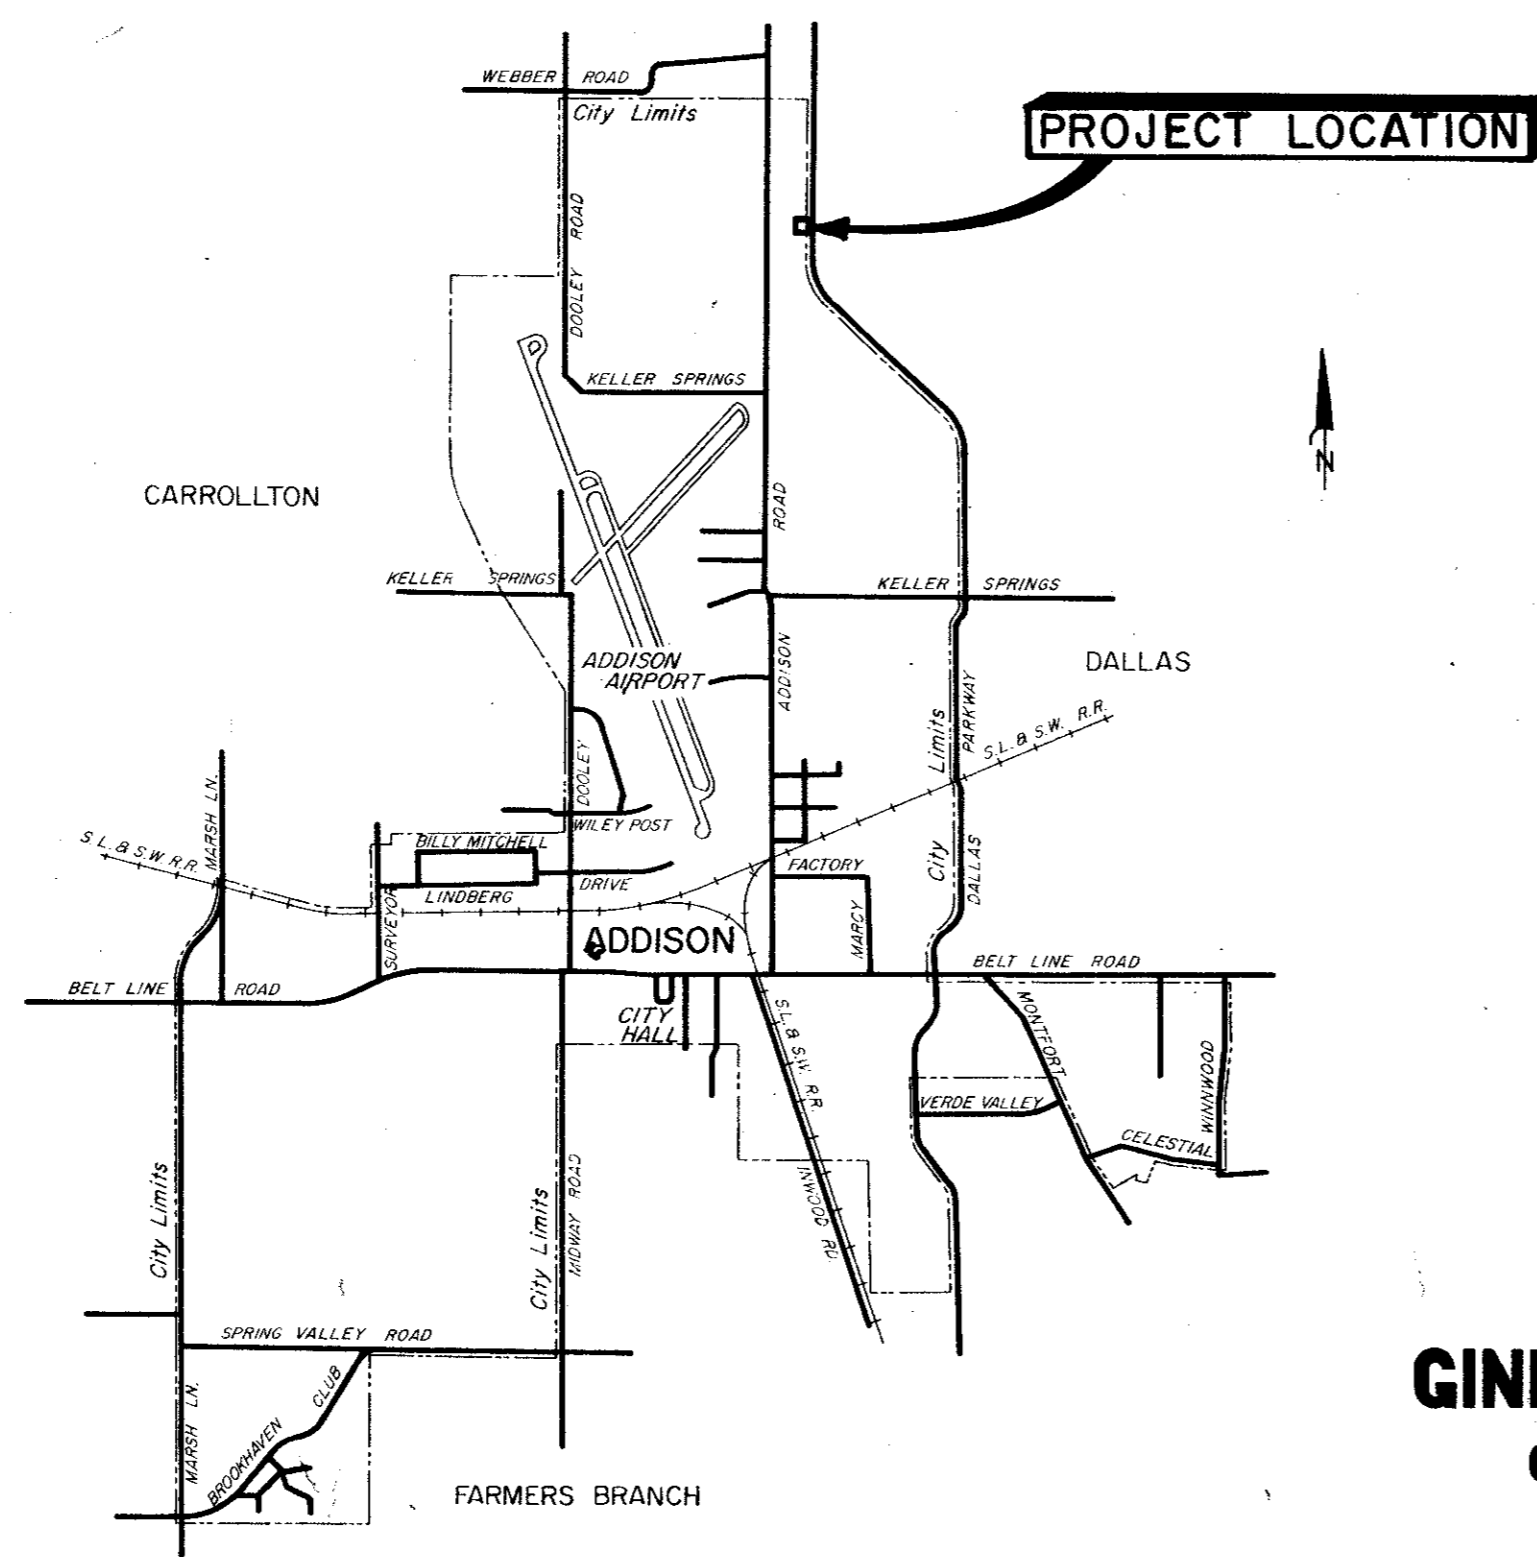


JERRY J. REDDING - MAYOR
COUNCILMEN:


JOHN B. ALLEN
RICHARD RODER
WILLIAM F. SELLMAYER
A. E. MARCY
TERRY ROBERTS

J. MILLIGAN - CITY ADMINISTRATOR



GINN & STACY, INC.
CONSULTING ENGINEERS
DALLAS, TEXAS
1978

PRELIMINARY
NOT FOR CONSTRUCTION

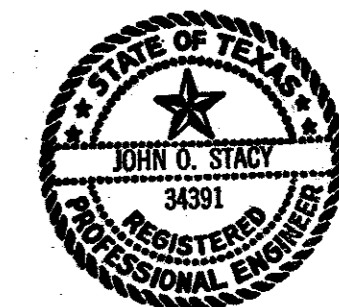

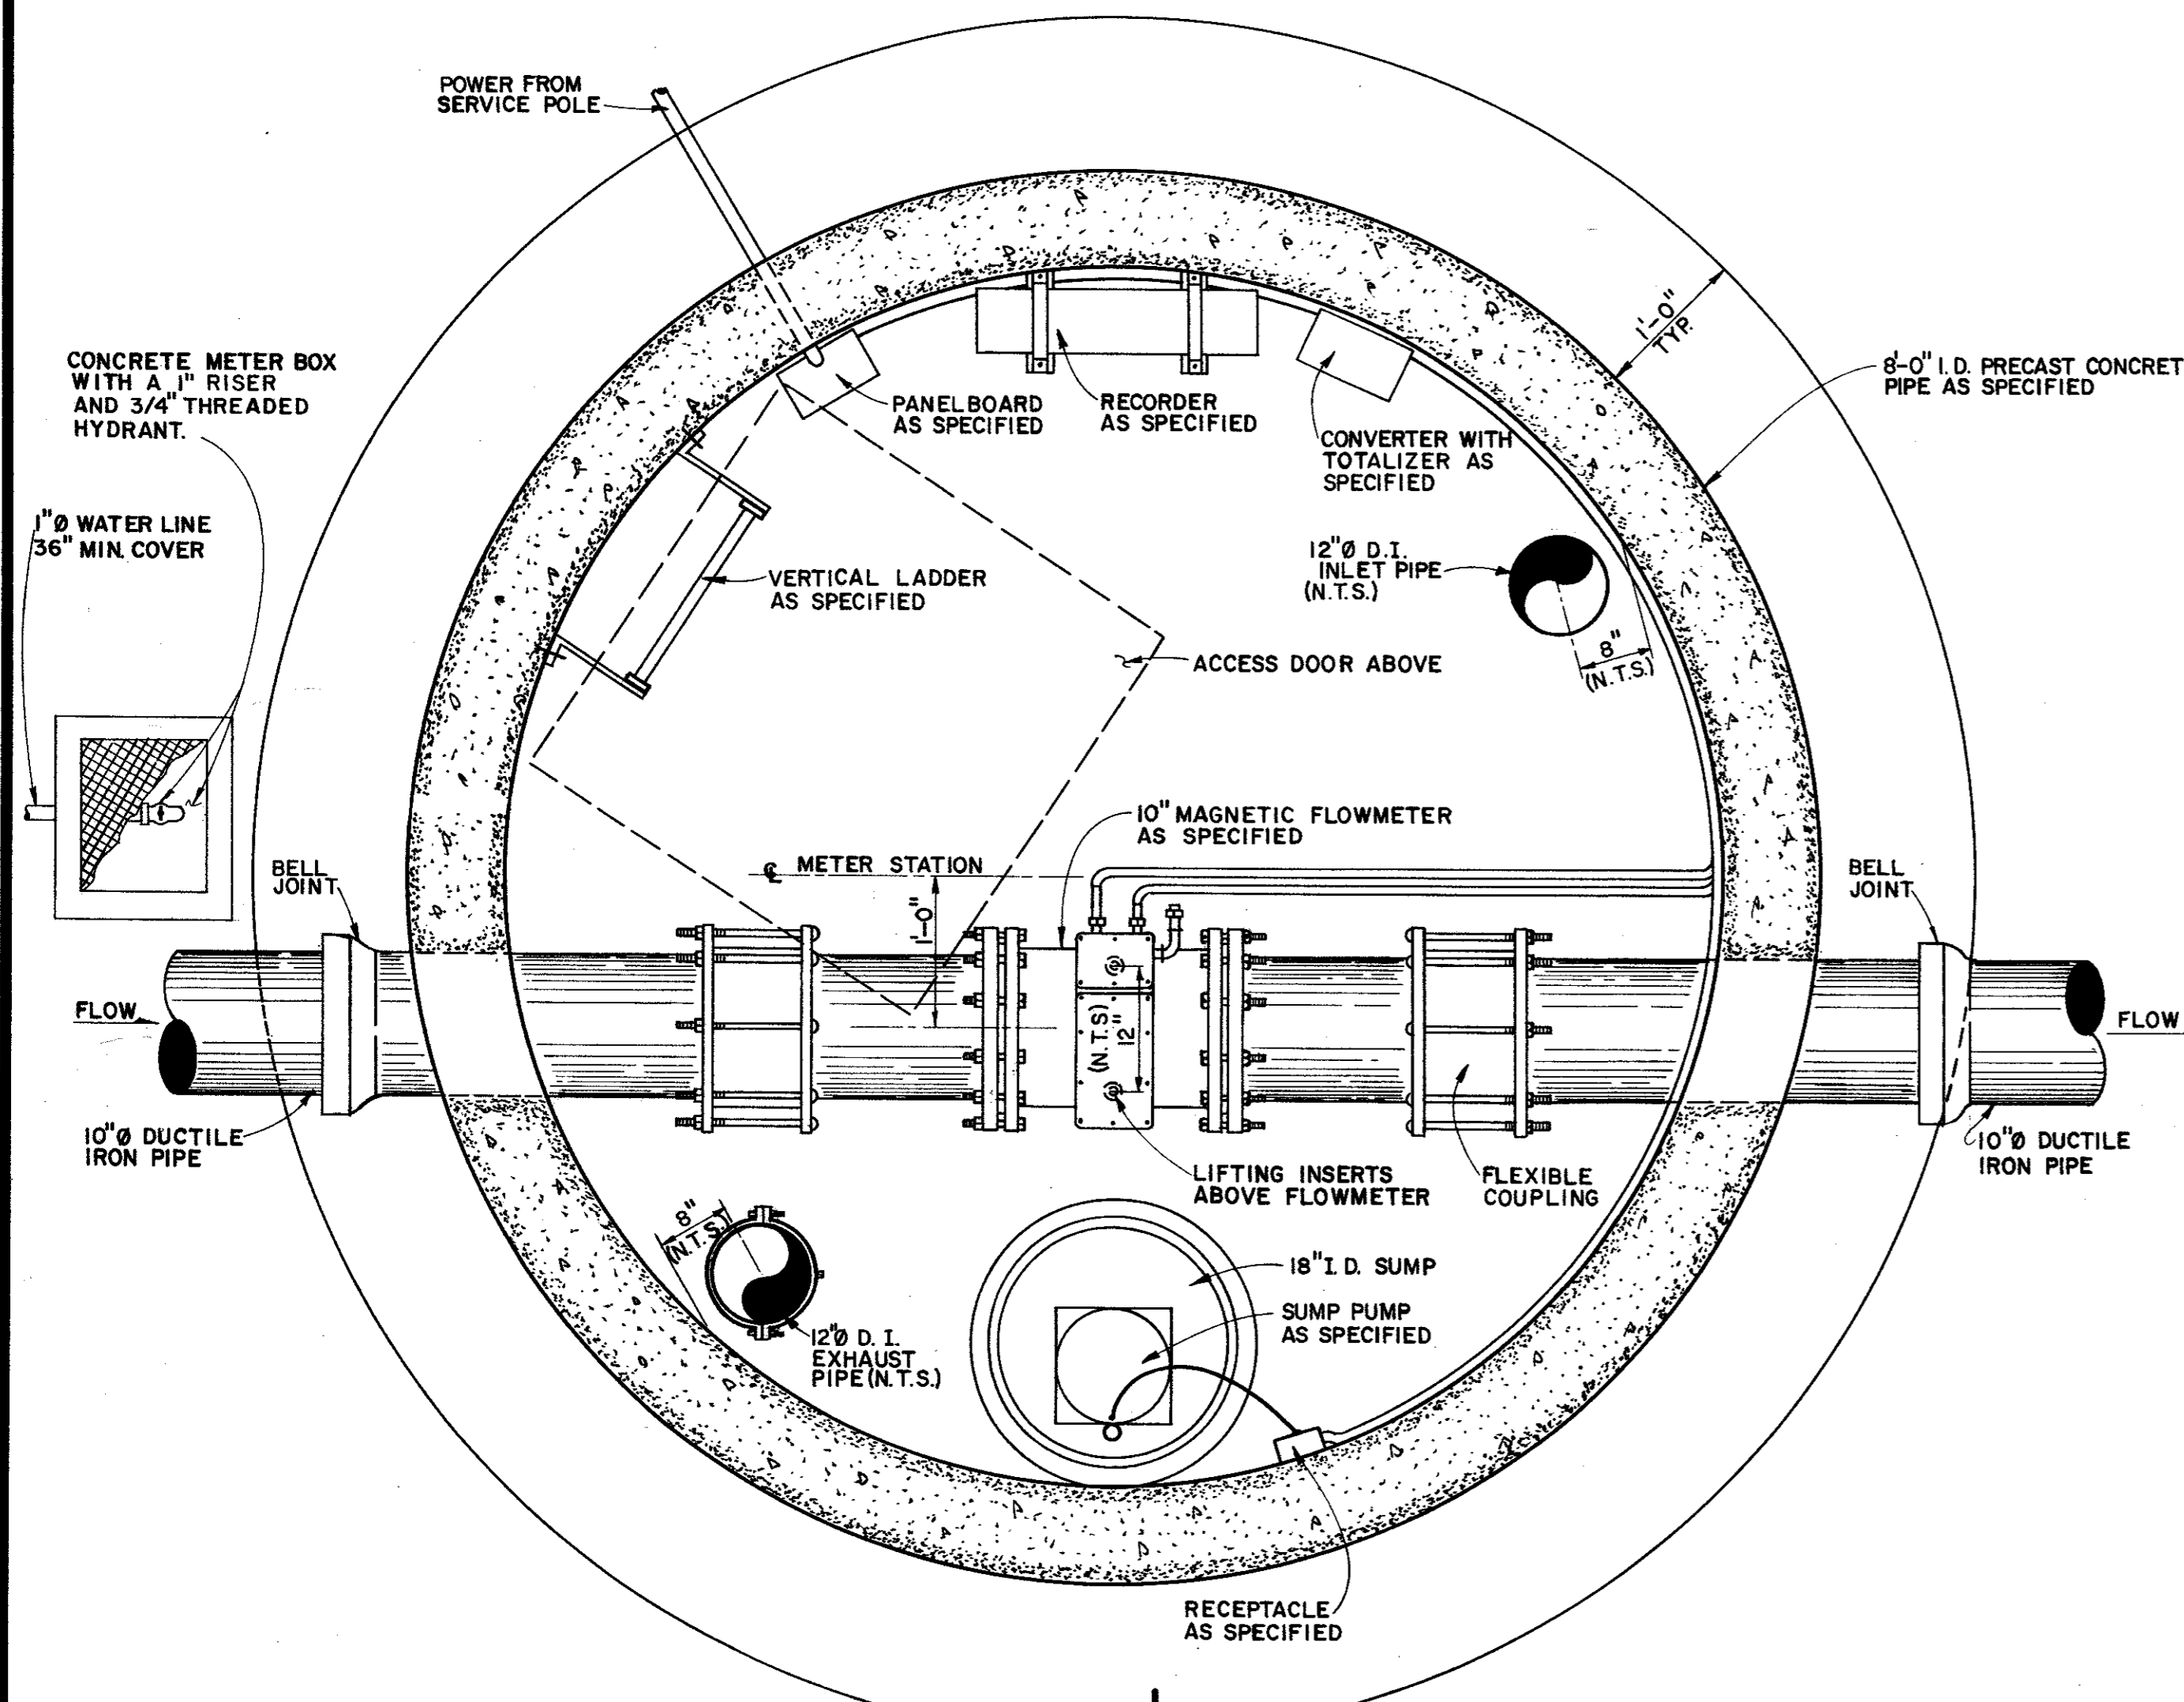


METER STATION PLAN
SCALE: 1"=1'-0"

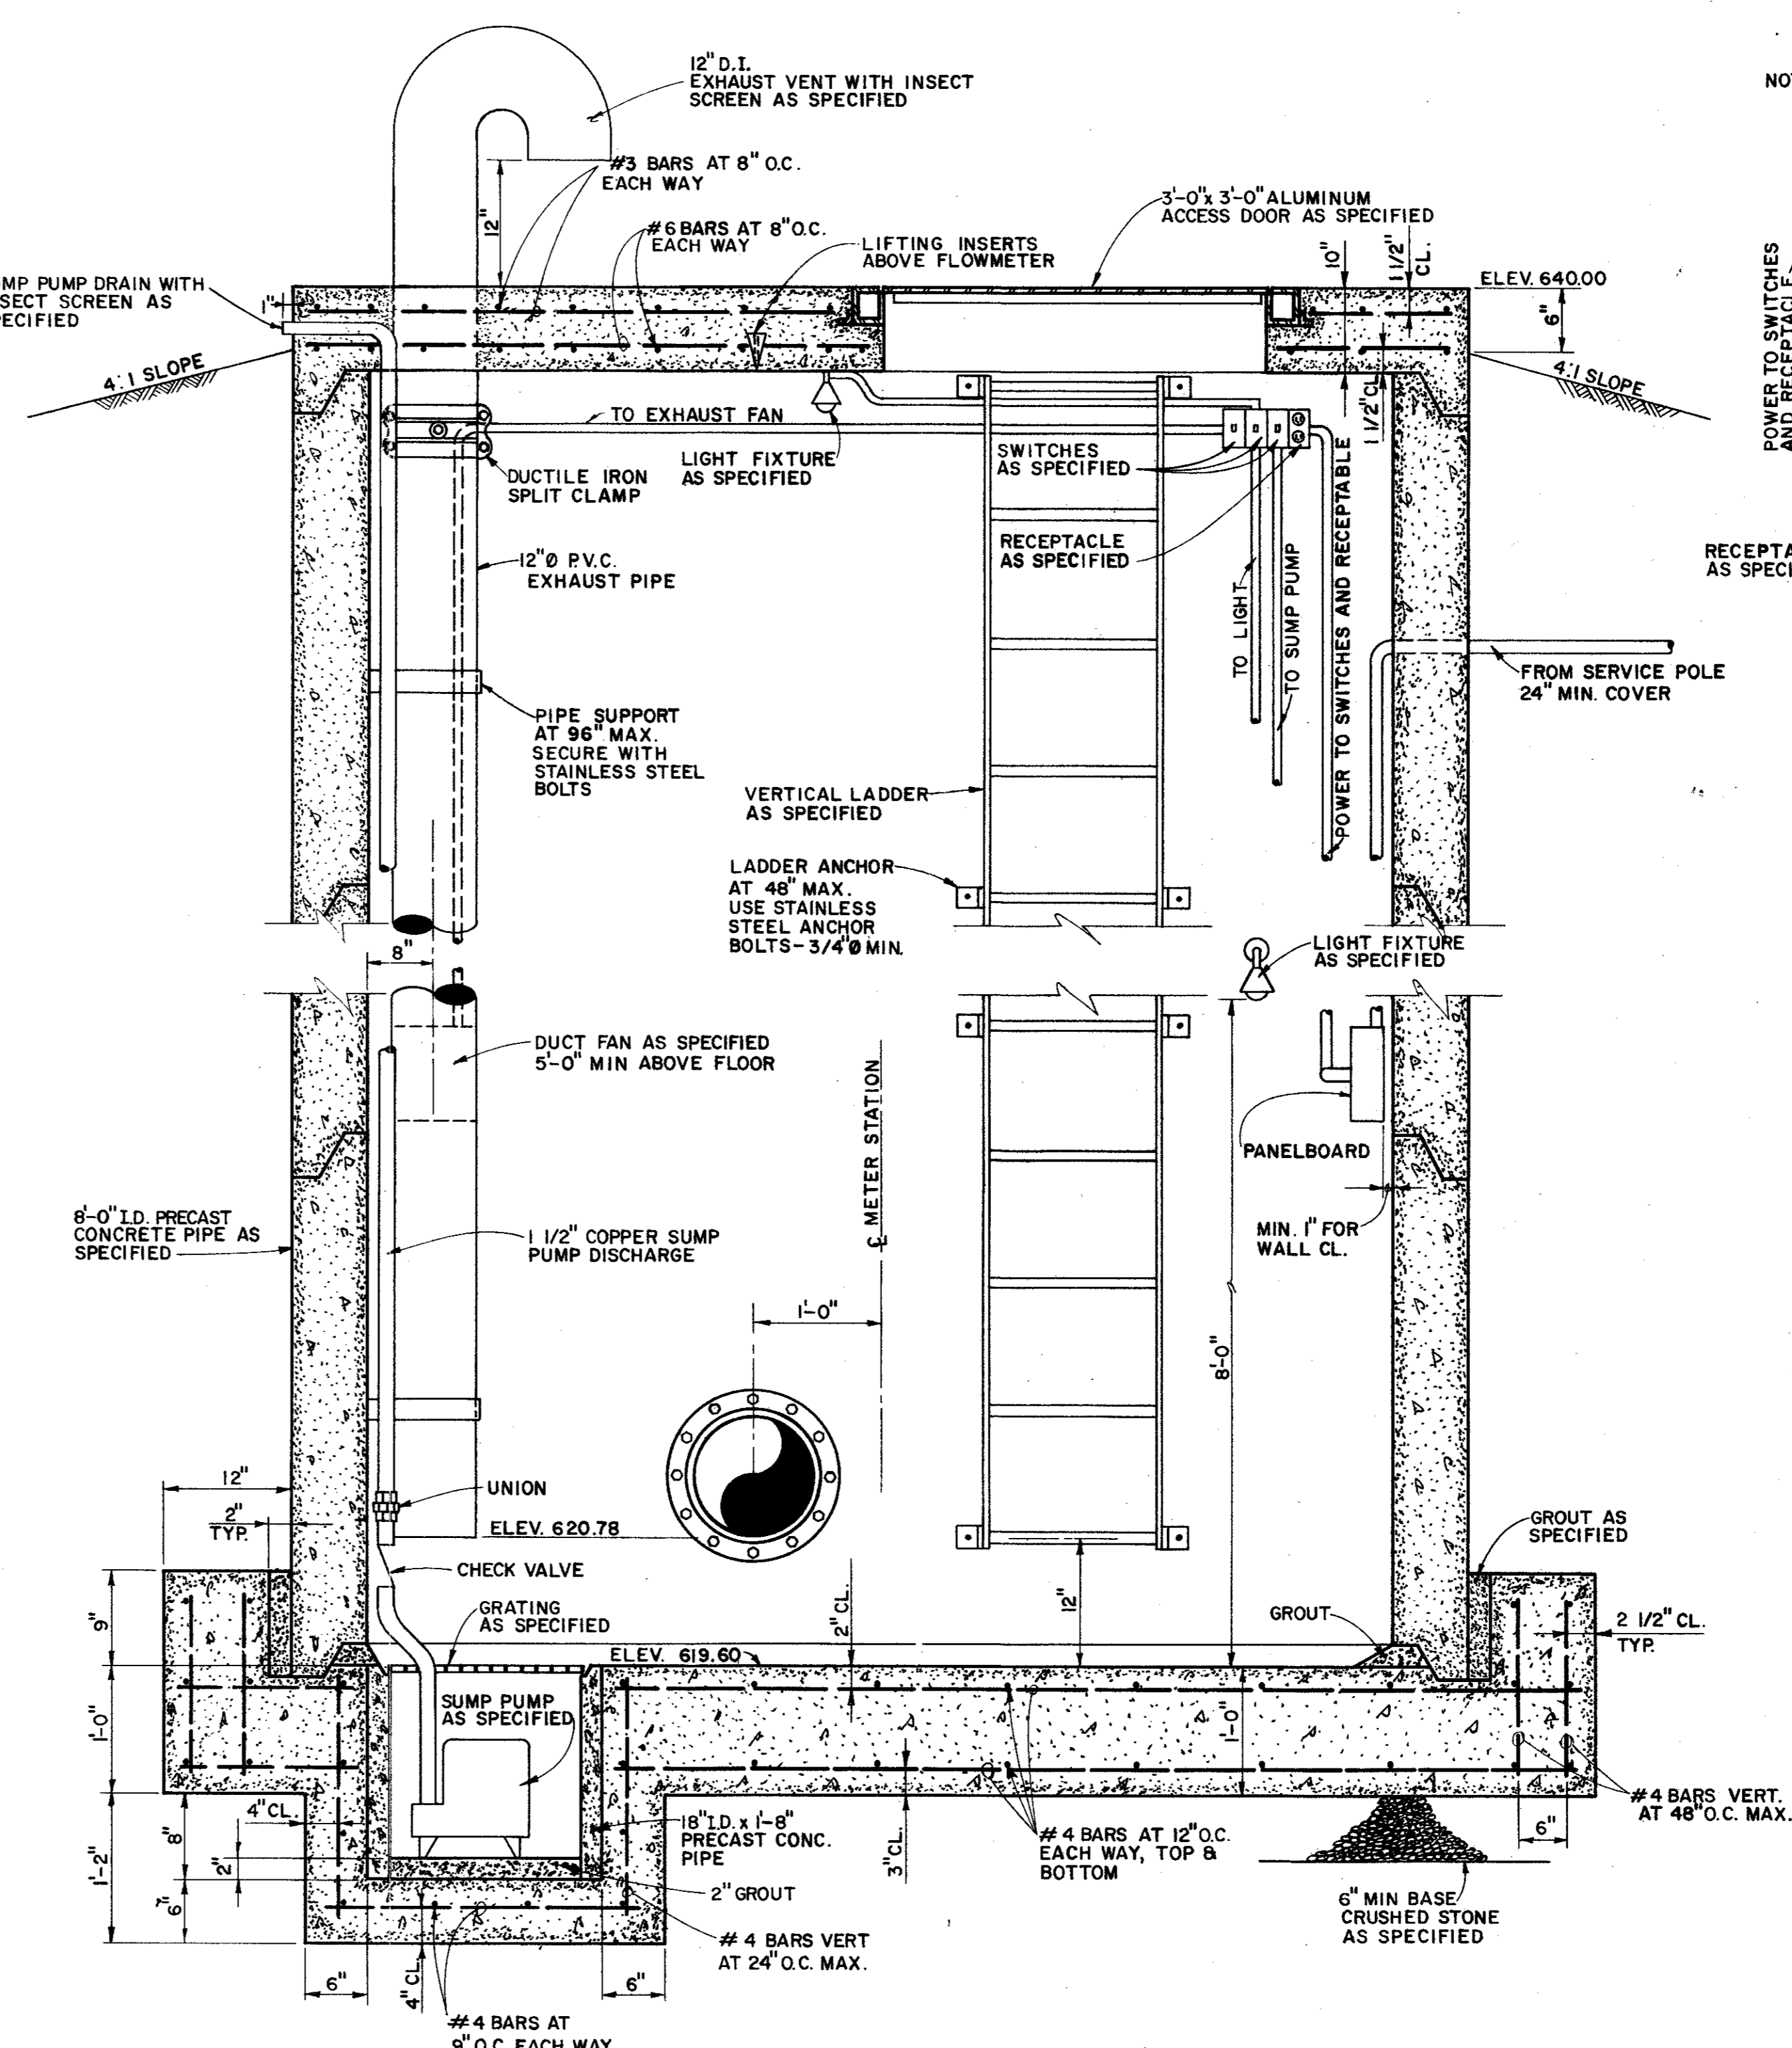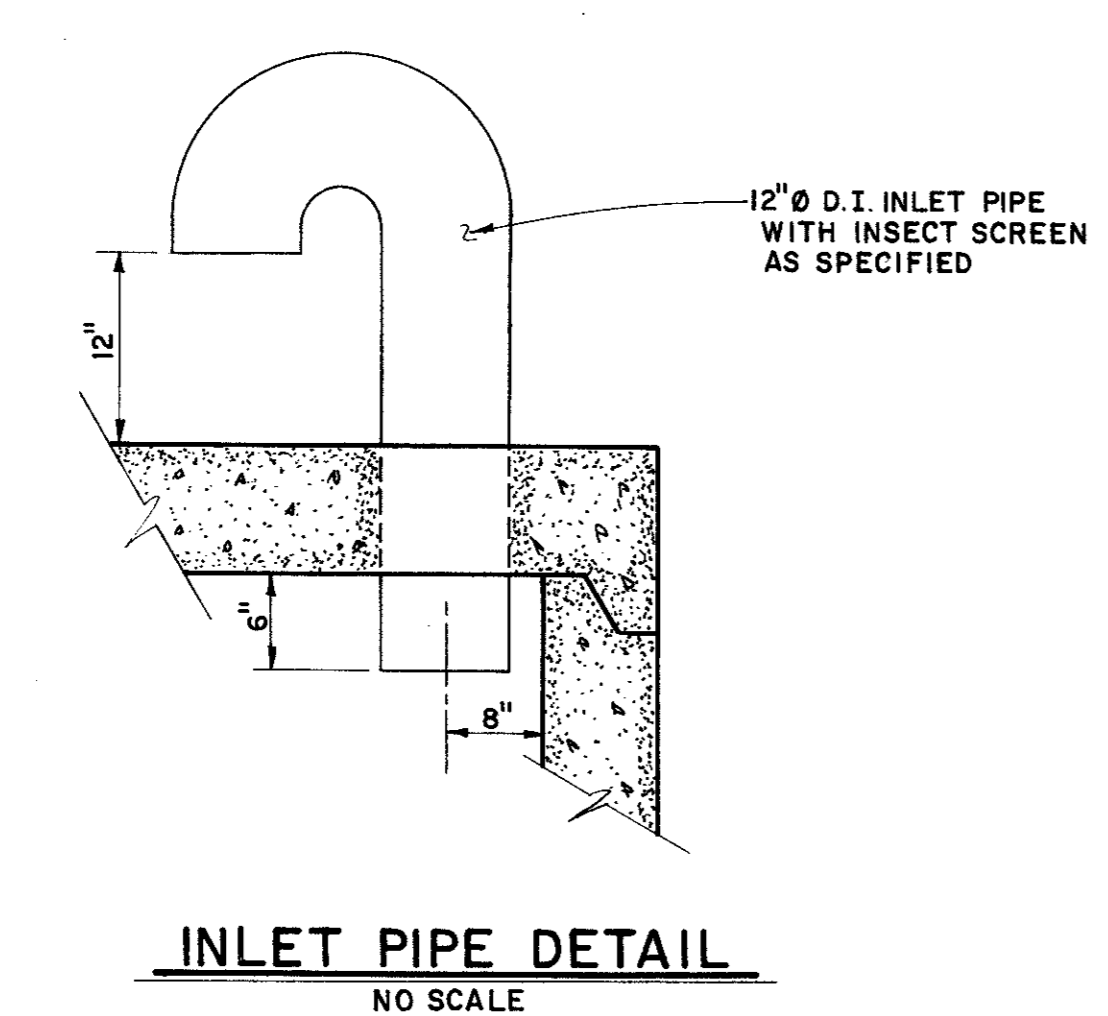

SECTION "A"
NO SCALE

NOTE: ALL ELECTRICAL EQUIPMENT TO BE MOUNTED WITH A MINIMUM OF A ONE INCH (1") STAND-OFF FROM THE WALL.

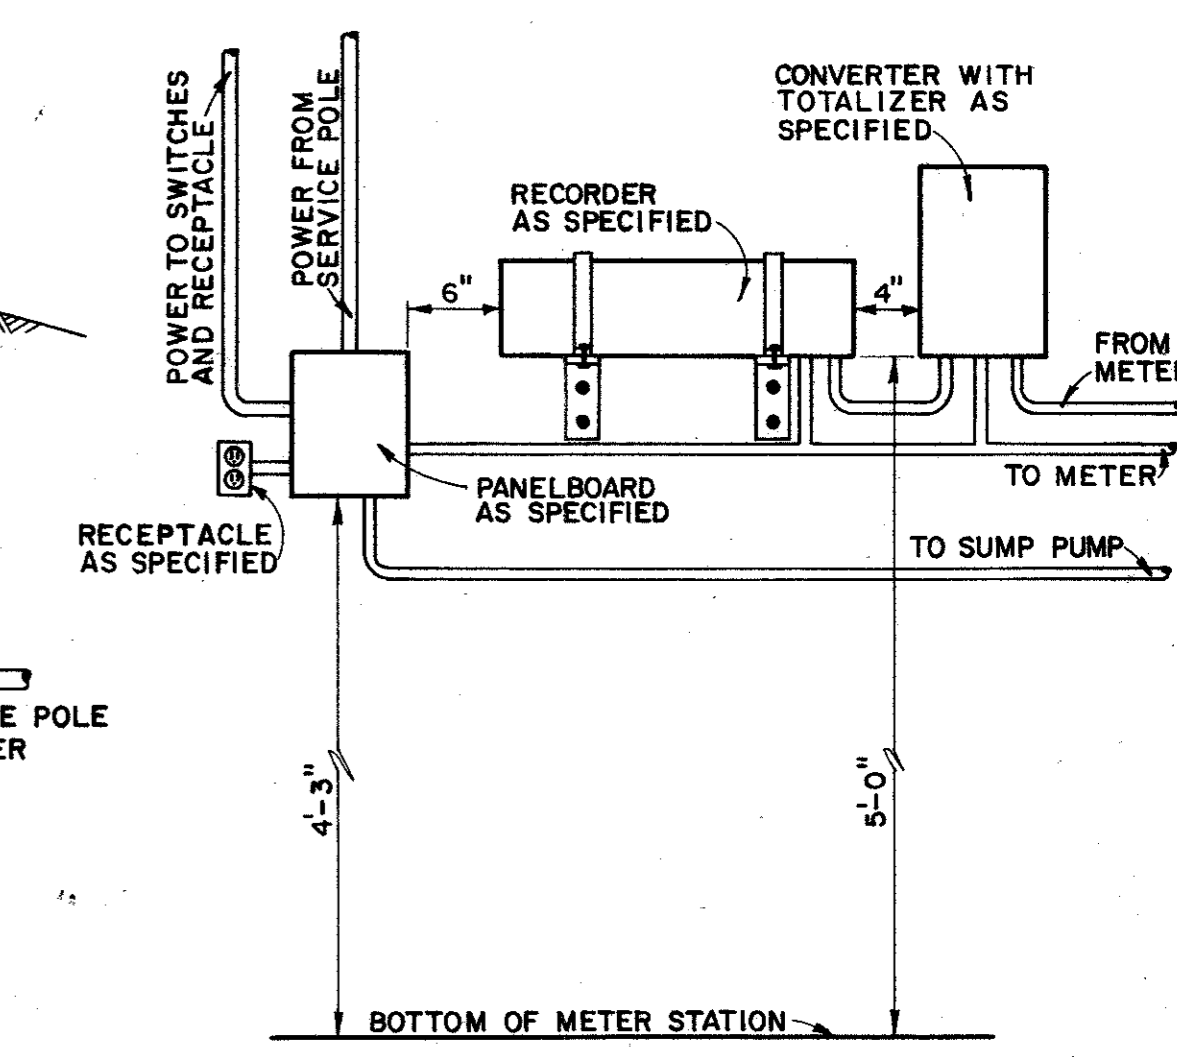

EQUIPMENT LAYOUT
NO SCALE

- NOTES:
1. SLOPE TOP SLAB OF METER STATION FROM CENTER TO OUTSIDE 1/4" PER FOOT.
 2. SLOPE FLOOR SLAB OF METER STATION 1/4" PER FOOT TO SUMP.
 3. ALL JOINTS AND PENETRATIONS SHALL BE SEALED WATER TIGHT.
 4. LIFTING INSERTS SHALL BE GALV. MALLEABLE IRON WITH 1/2" Ø EYEBOLTS LOCATED IN ROOF ABOVE FLOWMETER AND 12" APART AS SHOWN ON PLAN.



CITY OF DALLAS FILE NO. 681Q-21-S.1

CITY OF ADDISON
DALLAS COUNTY, TEXAS


SEWER IMPROVEMENTS

**ACADEMY DRIVE WASTEWATER
METER STATION PLAN
AND DETAILS**


GINN & STACY, INC.
CONSULTING ENGINEERS — DALLAS, TEXAS

Designed By: J.O.S. Scale: As Shown
Drawn By: G.L.H. Date: 1978

Sheet 1 of 2

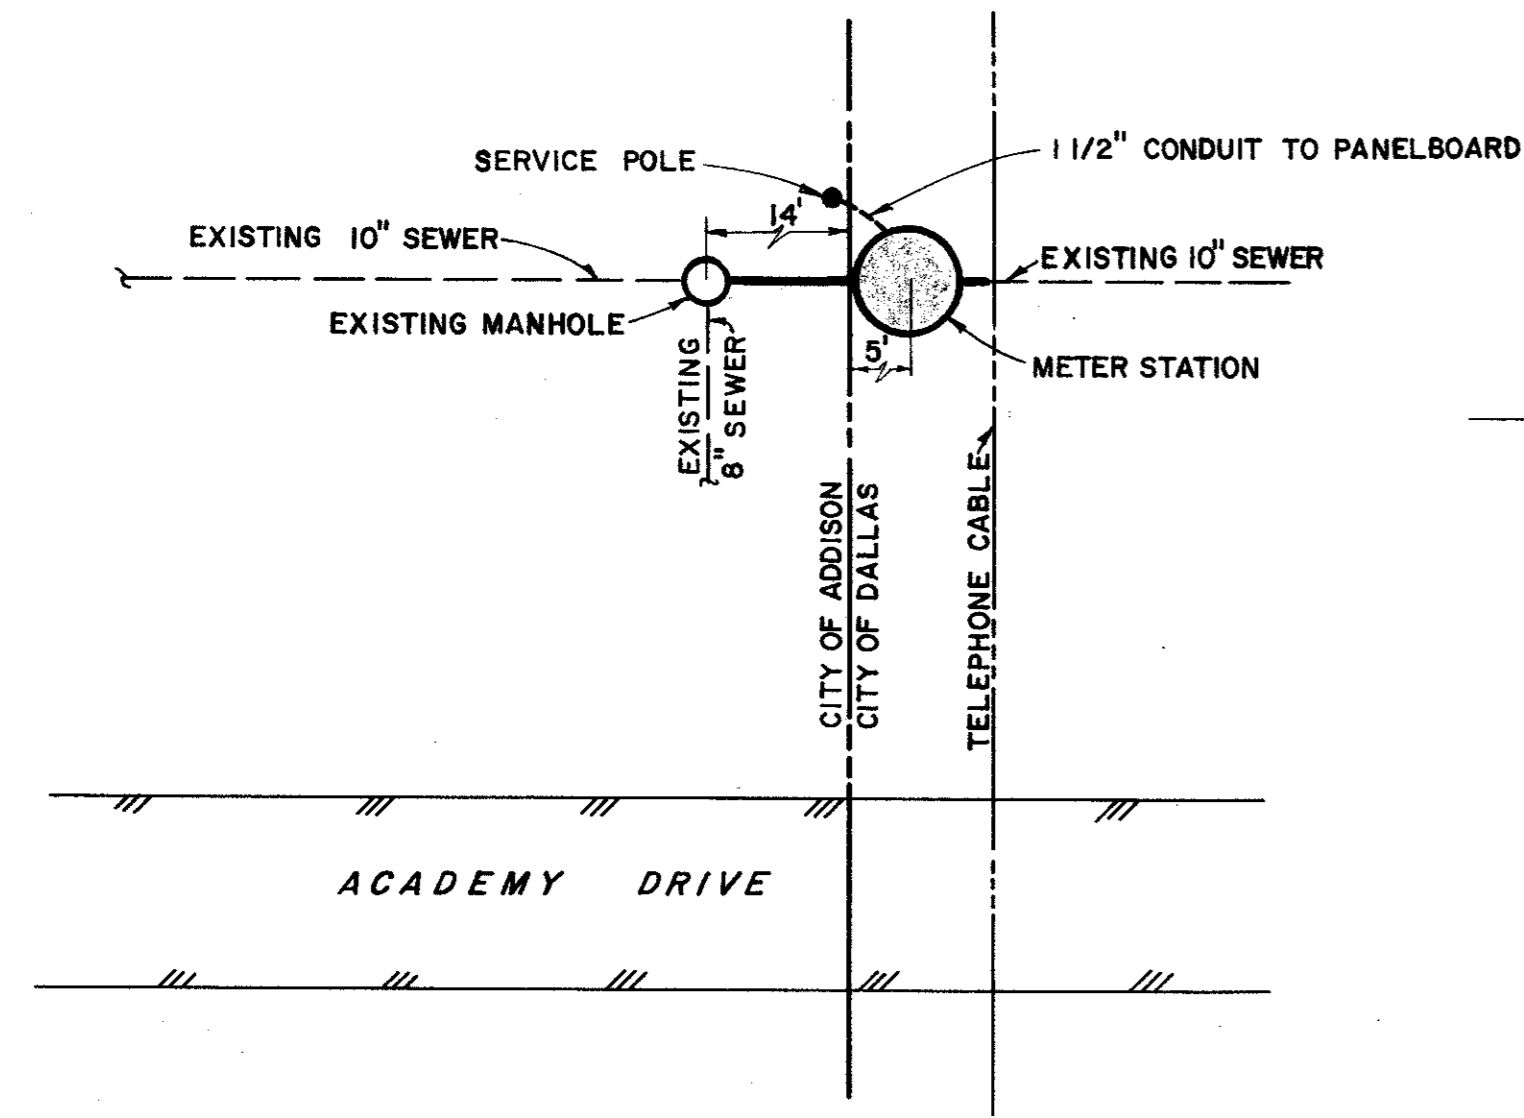


SITE PLAN
SCALE: 1"=20'

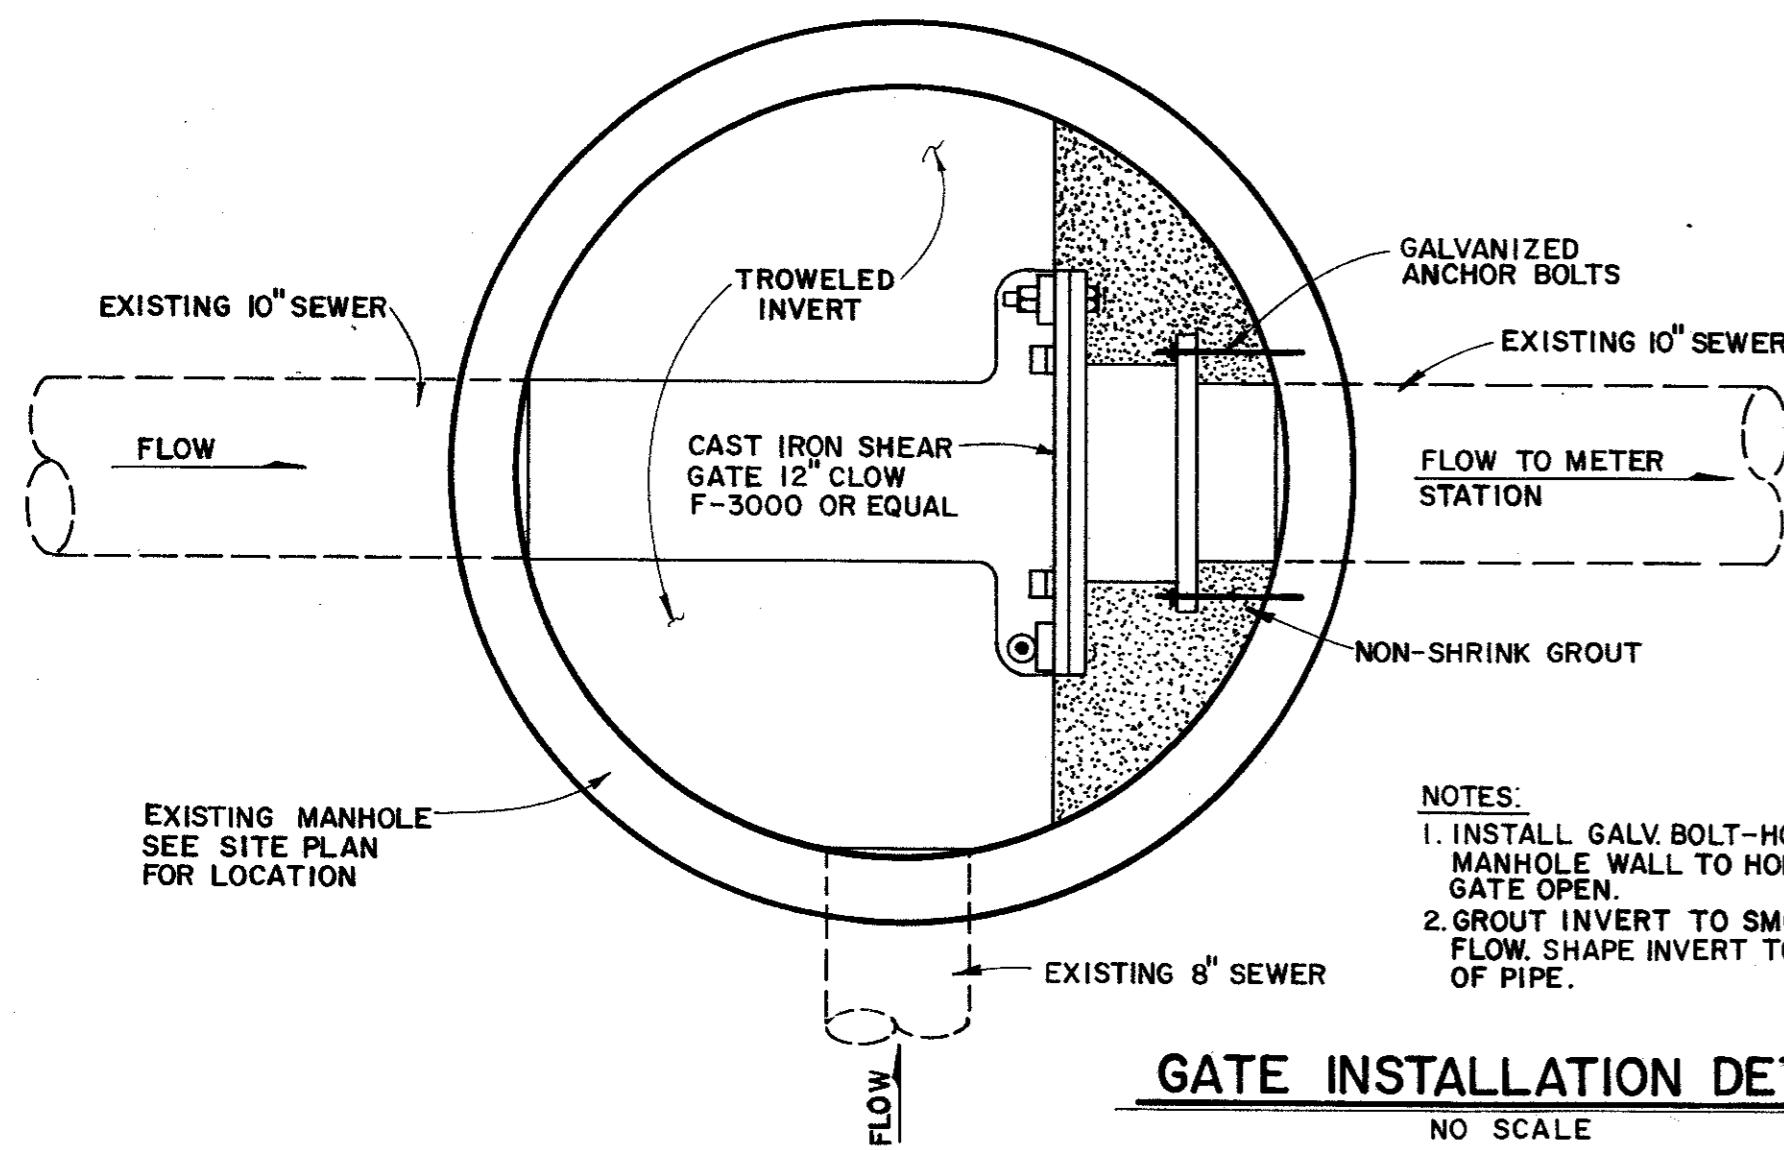


GATE INSTALLATION DETAIL
NO SCALE


- NOTES:
1. INSTALL GALV. BOLT-HOOK IN MANHOLE WALL TO HOLD GATE OPEN.
2. GROUT INVERT TO SMOOTH FLOW SHAPE INVERT TO TOP OF PIPE.

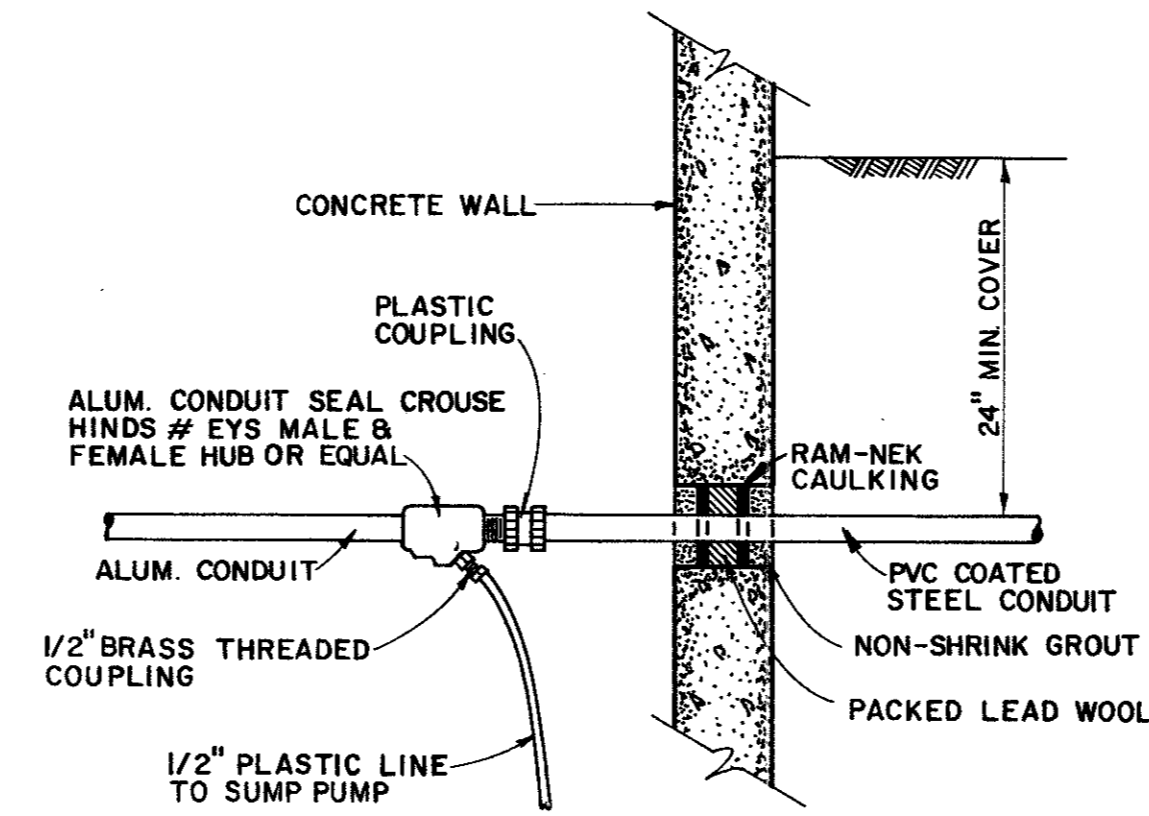


CONDUIT ENTRANCE AND DRAIN DETAIL
NO SCALE

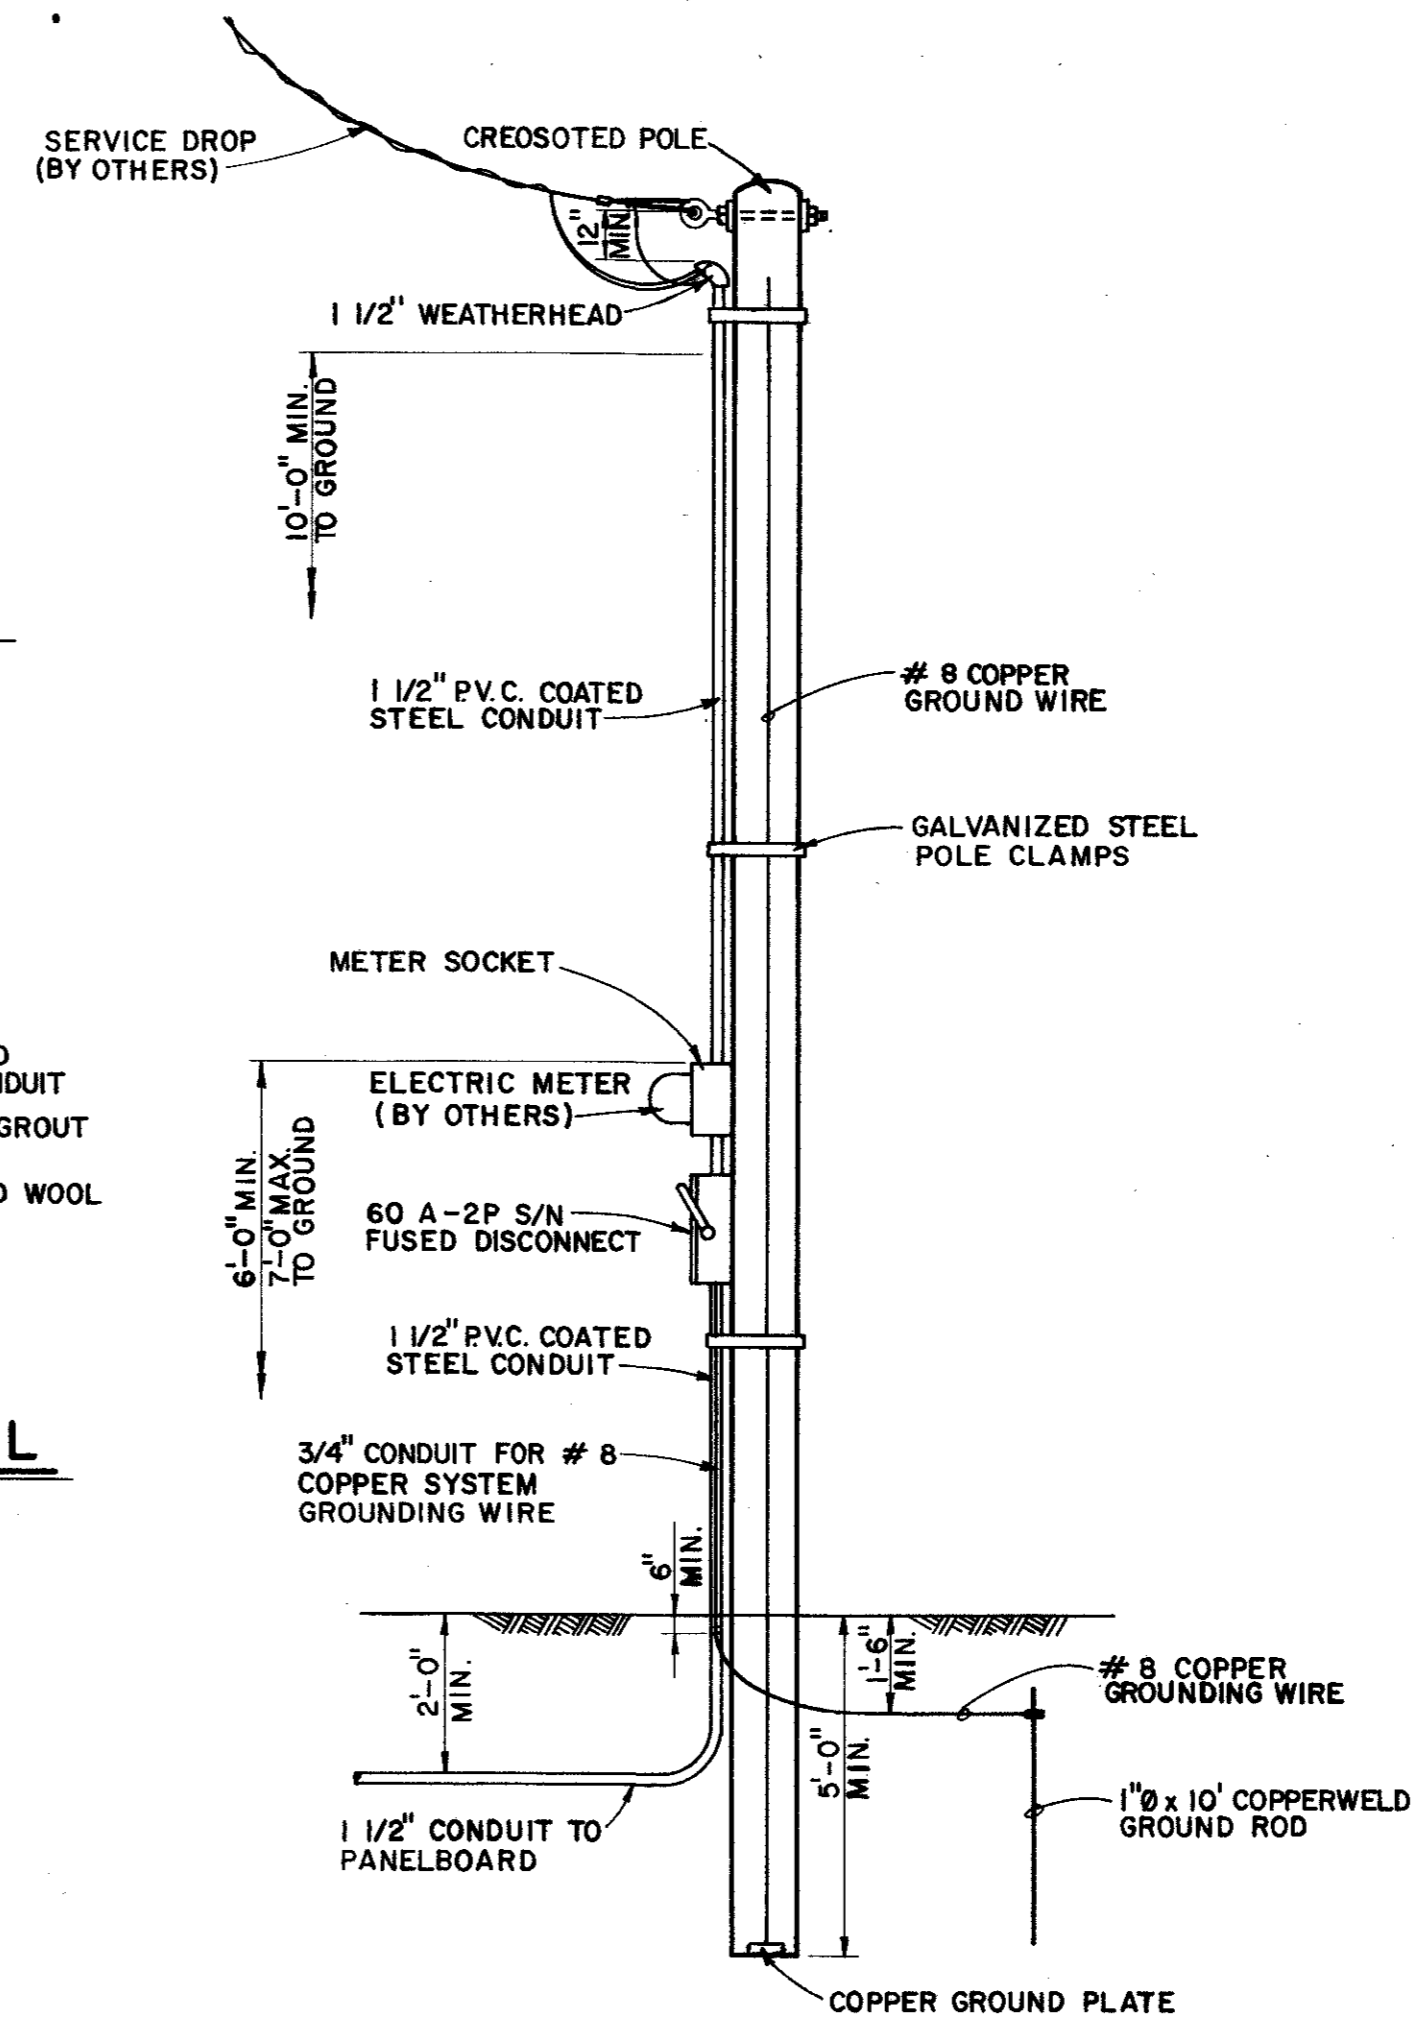


SERVICE POLE DETAIL
NO SCALE

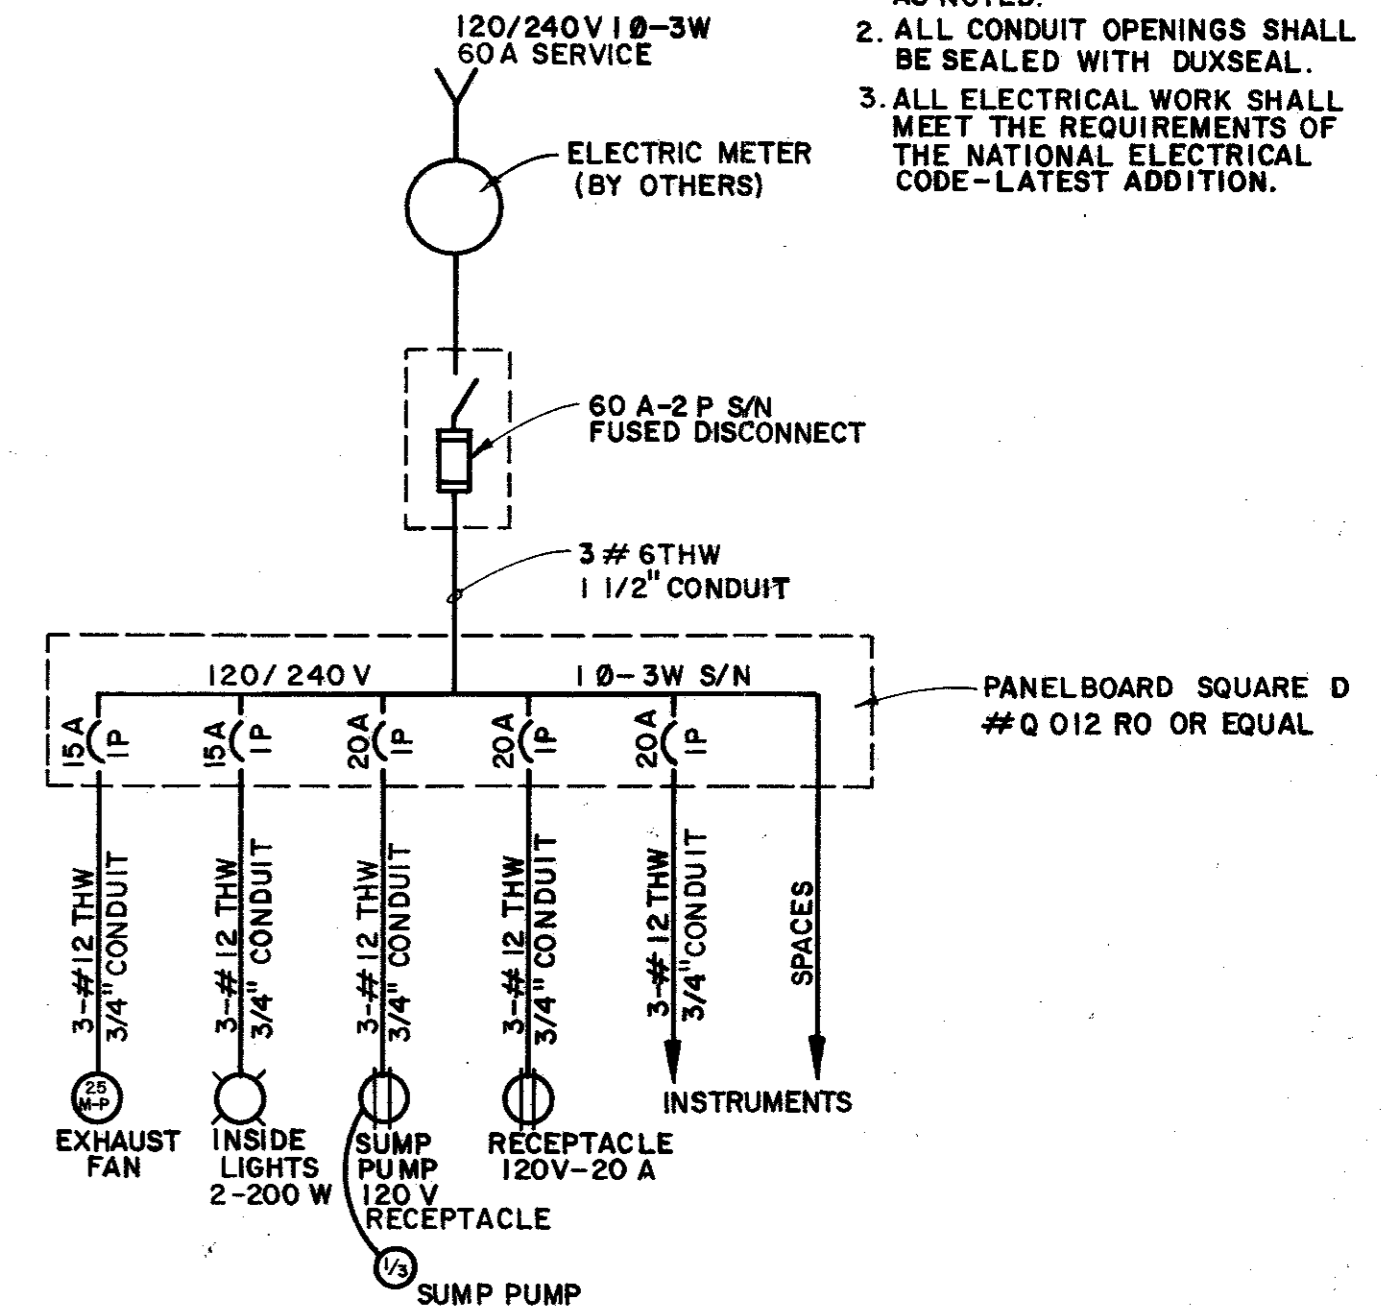


ELECTRICAL DIAGRAM
NO SCALE

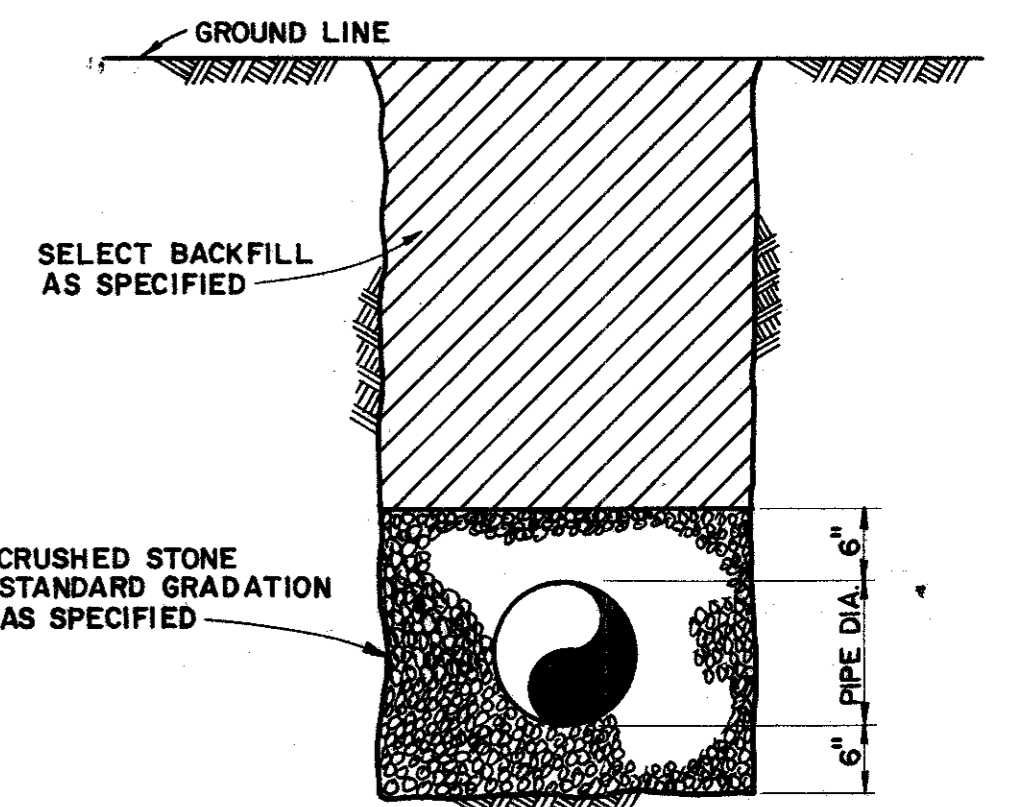

TYPICAL BEDDING DETAIL
NO SCALE

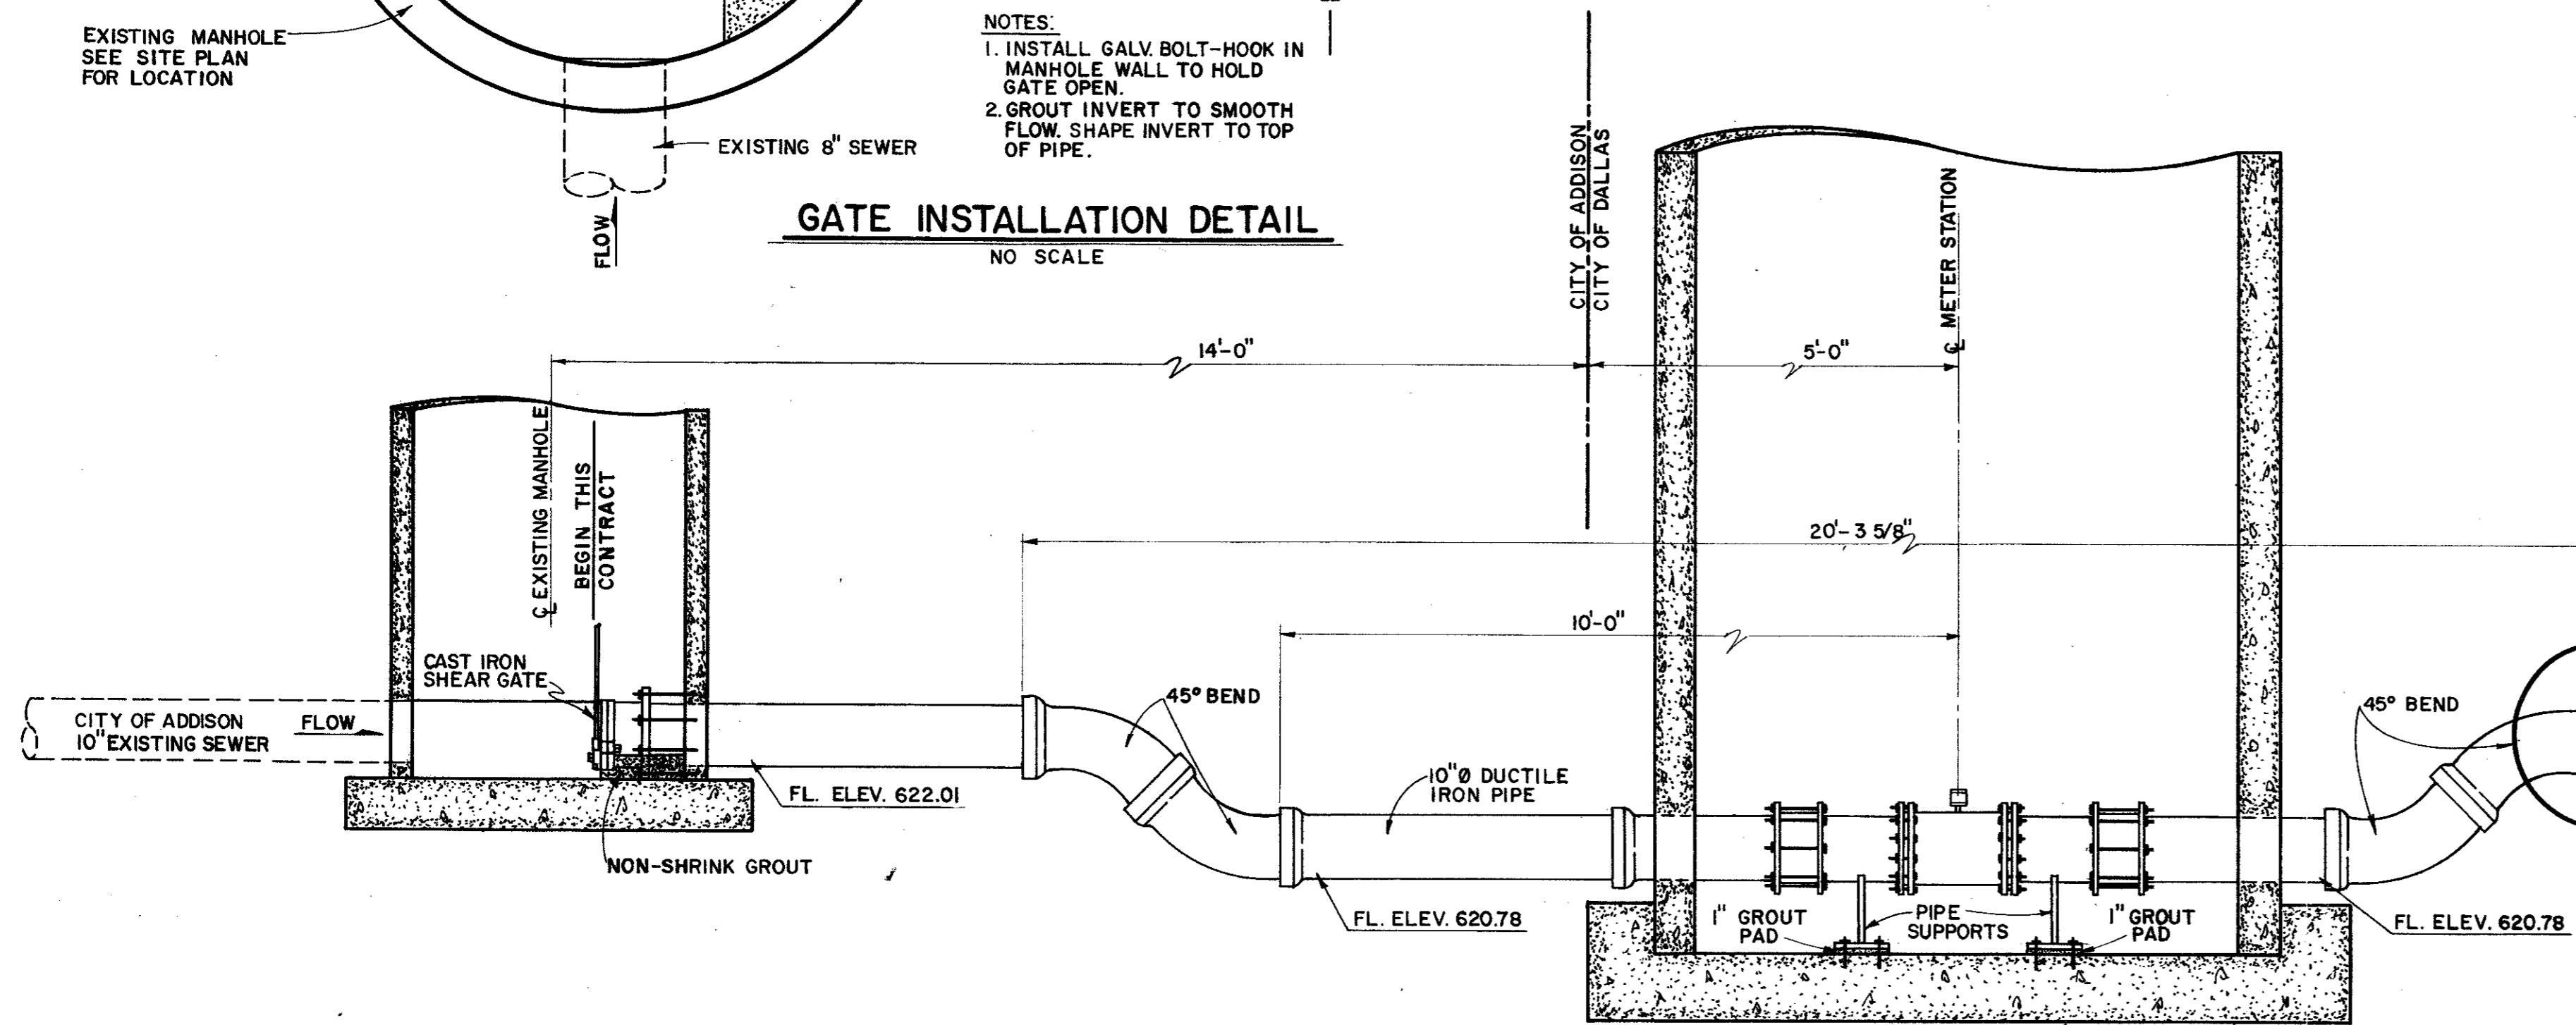

PROFILE
SCALE: 1/2"=1'-0"

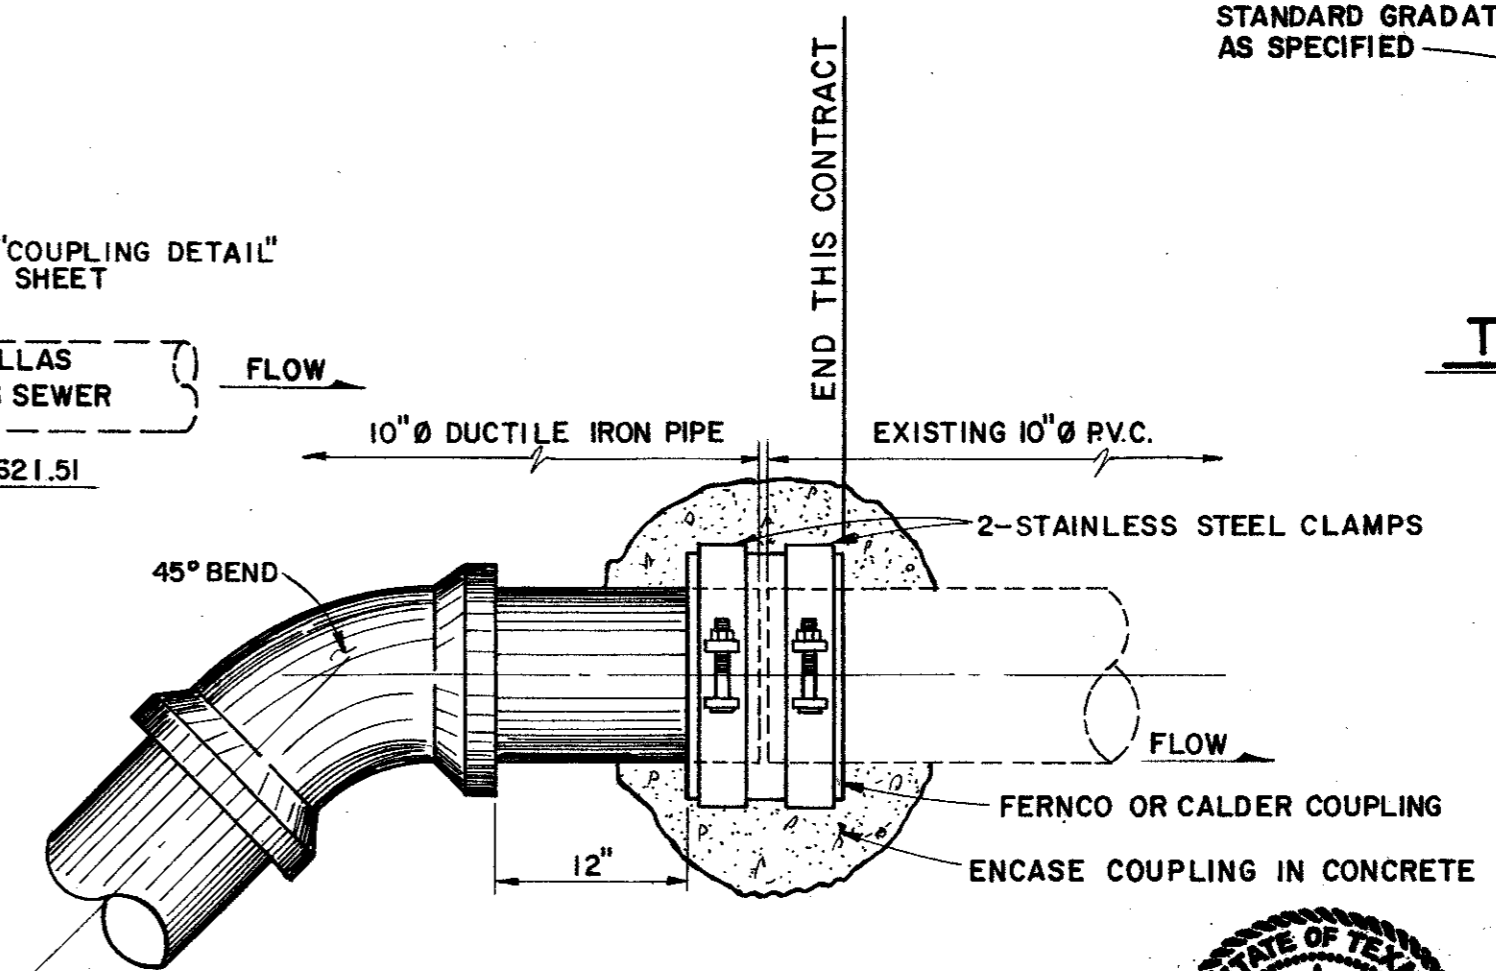

COUPLING DETAIL
SCALE: 1"=1'-0"

- NOTES:
1. ALL CONDUIT AND FITTINGS SHALL BE P.V.C. COATED STEEL EXCEPT AS NOTED.
2. ALL CONDUIT OPENINGS SHALL BE SEALED WITH DUXSEAL.
3. ALL ELECTRICAL WORK SHALL MEET THE REQUIREMENTS OF THE NATIONAL ELECTRICAL CODE-LATEST ADDITION.

CITY OF DALLAS FILE NO. 681Q-2-S-1


CITY OF ADDISON
DALLAS COUNTY, TEXAS
SEWER IMPROVEMENTS

ACADEMY DRIVE WASTEWATER
METER STATION SITE
PLAN AND DETAILS


GINN & STACY, INC.
CONSULTING ENGINEERS - DALLAS, TEXAS

Designed By: J.O.S. Scale: As Shown
Drawn By: G.L.H. Date: 1978 Sheet 2 of 2




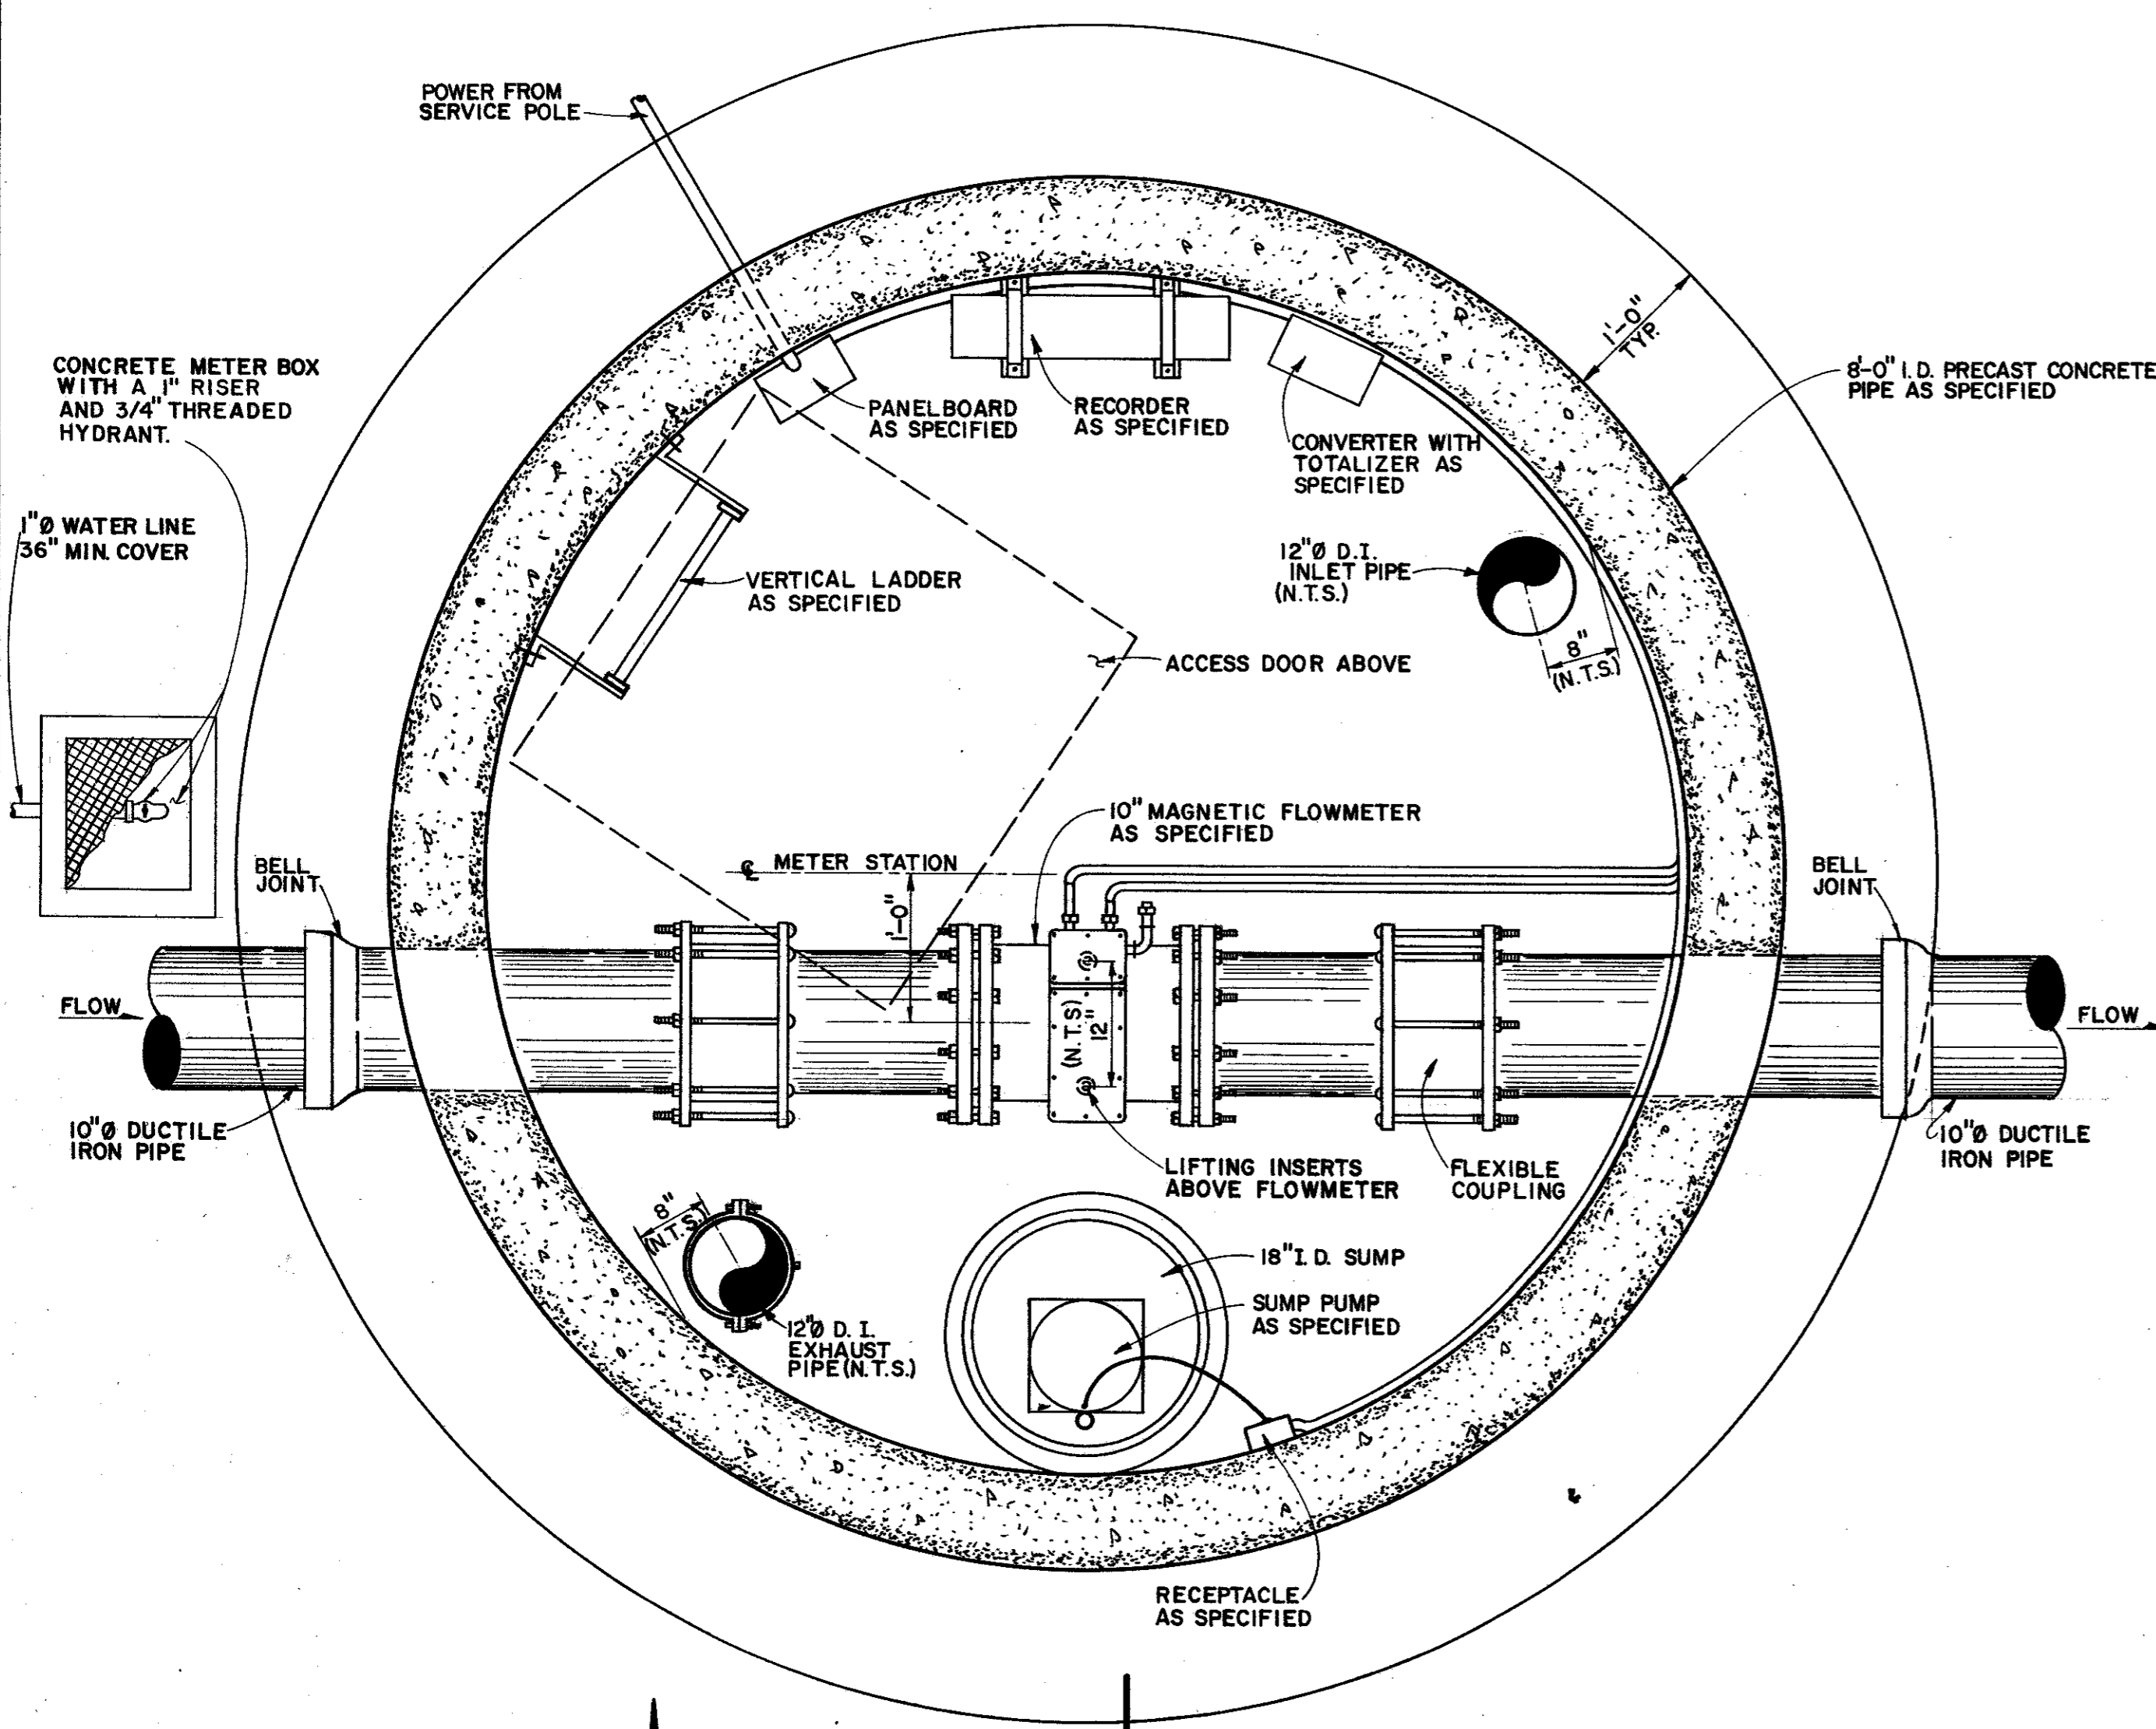

METER STATION PLAN
SCALE: 1"=1'-0"

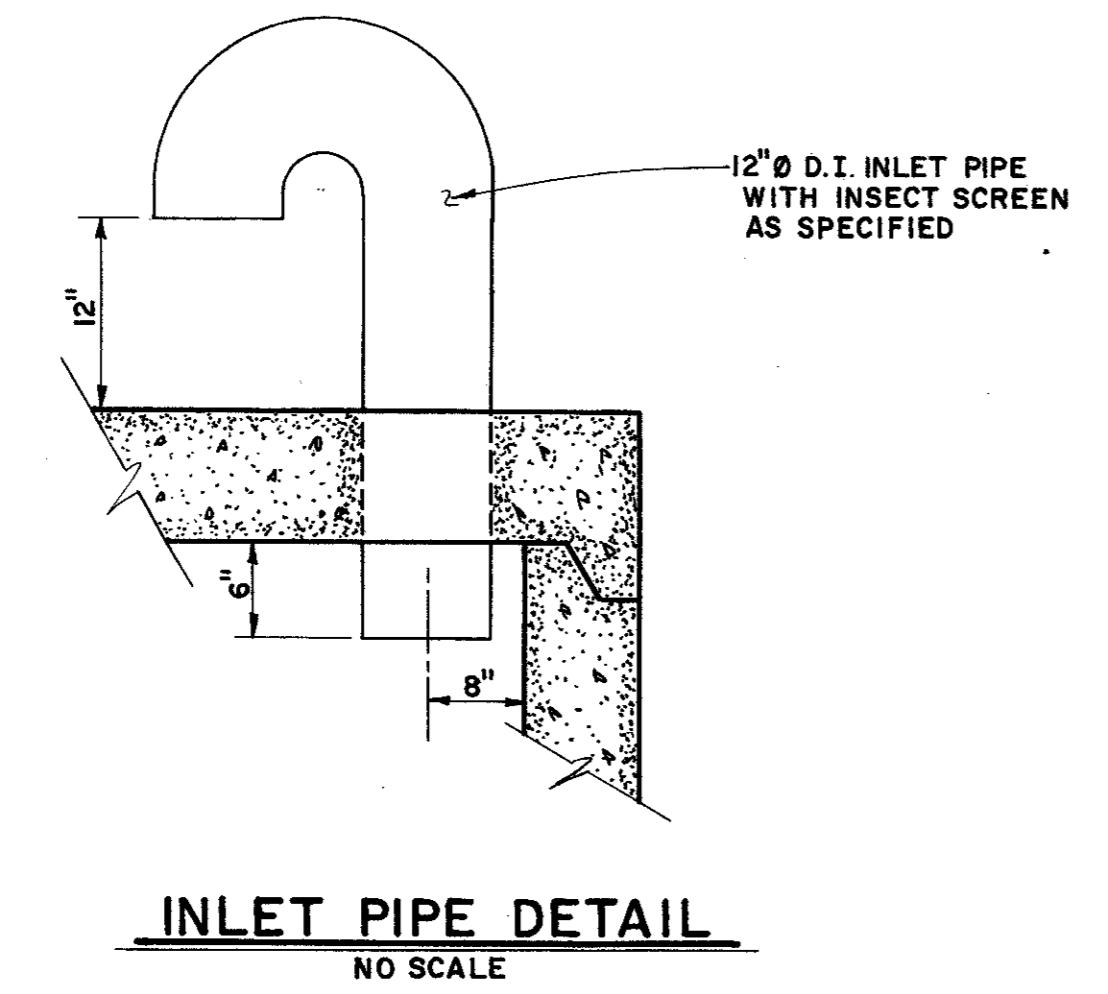


INLET PIPE DETAIL
NO SCALE

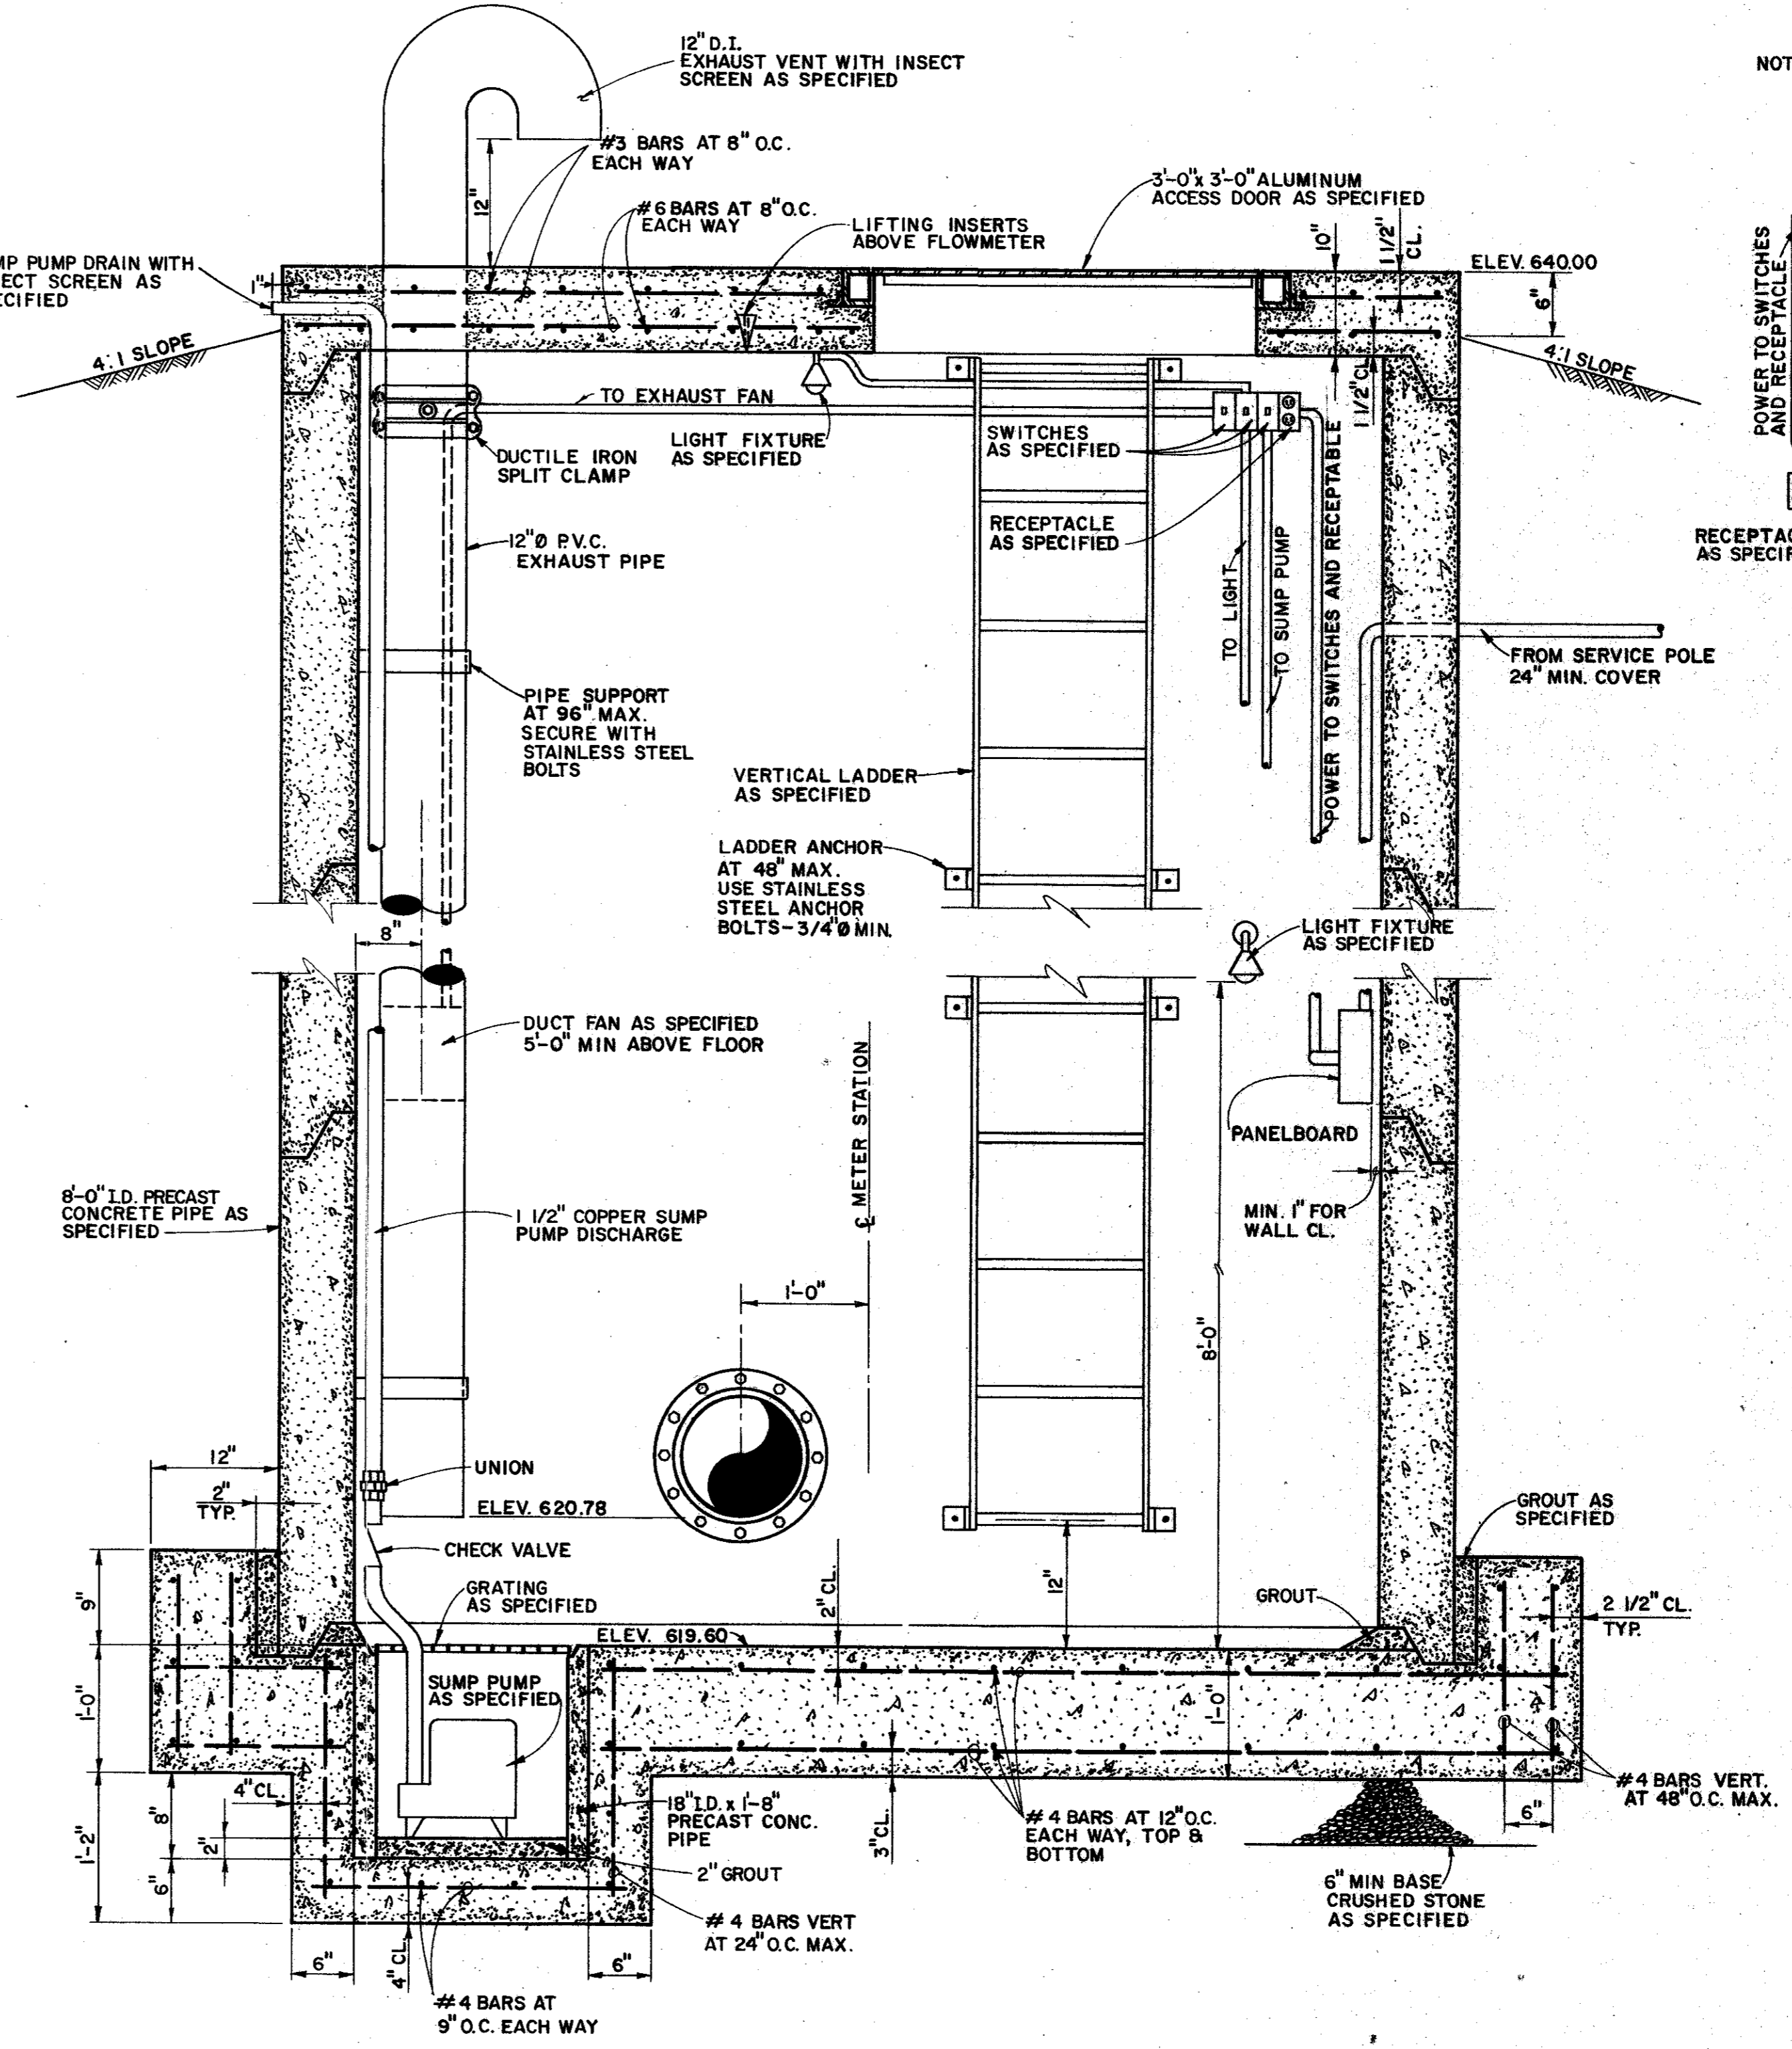

SECTION "A"
NO SCALE

NOTE: ALL ELECTRICAL EQUIPMENT TO BE MOUNTED WITH A MINIMUM OF A ONE INCH (1") STAND-OFF FROM THE WALL.

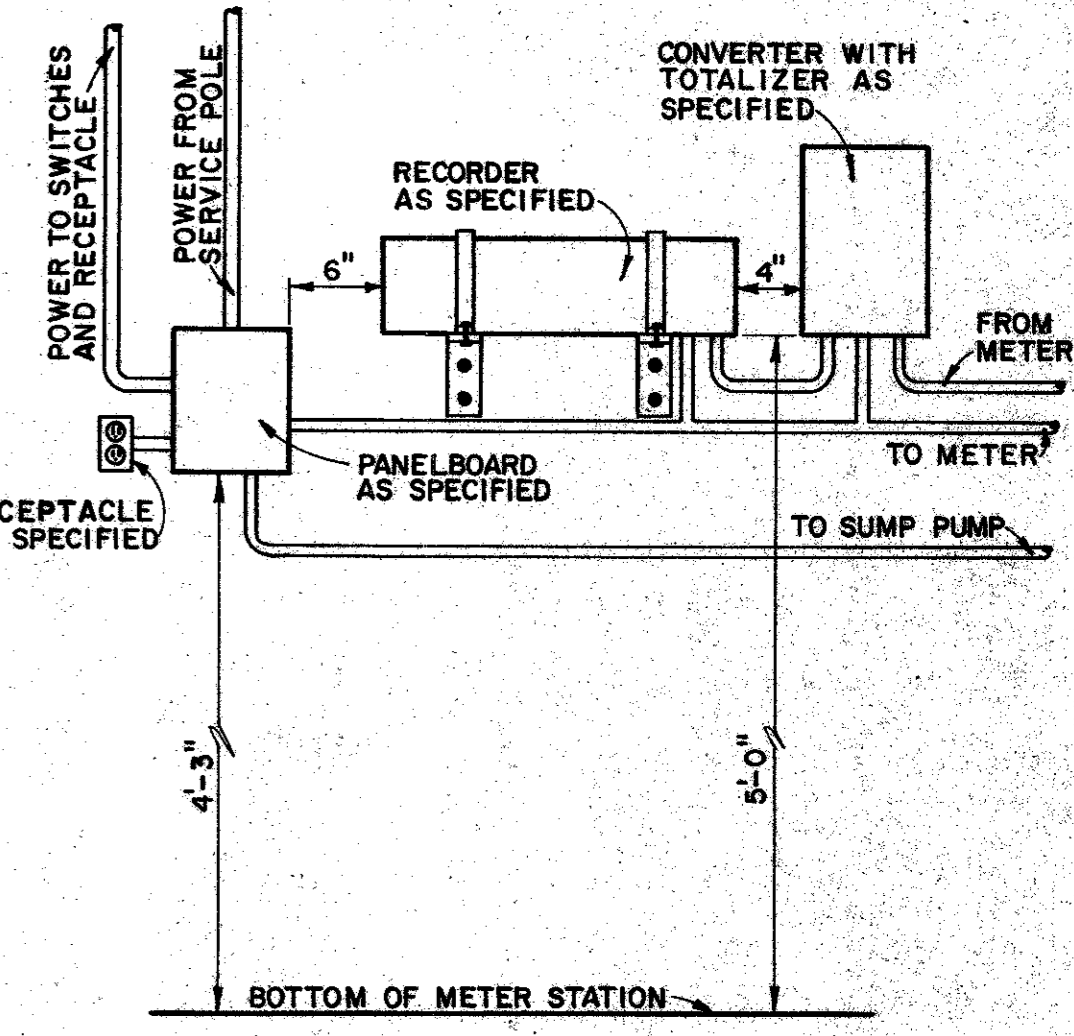

EQUIPMENT LAYOUT
NO SCALE

PRELIMINARY
NOT FOR CONSTRUCTION

- NOTES:
1. SLOPE TOP SLAB OF METER STATION FROM CENTER TO OUTSIDE 1/4" PER FOOT.
 2. SLOPE FLOOR SLAB OF METER STATION 1/4" PER FOOT TO SUMP.
 3. ALL JOINTS AND PENETRATIONS SHALL BE SEALED WATER TIGHT.
 4. LIFTING INSERTS SHALL BE GALV. MALLEABLE IRON WITH 1/2" Ø EYEBOLTS LOCATED IN ROOF ABOVE FLOWMETER AND 12" APART AS SHOWN ON PLAN.



CITY OF DALLAS FILE NO. 681Q-21-S-1

CITY OF ADDISON
DALLAS COUNTY, TEXAS


SEWER IMPROVEMENTS

**ACADEMY DRIVE WASTEWATER
METER STATION PLAN
AND DETAILS**


GINN & STACY, INC.
CONSULTING ENGINEERS — DALLAS, TEXAS

Designed By: J.O.S. Scale: As Shown
Drawn By: G.L.H. Date: 1978

Sheet 2 of 3

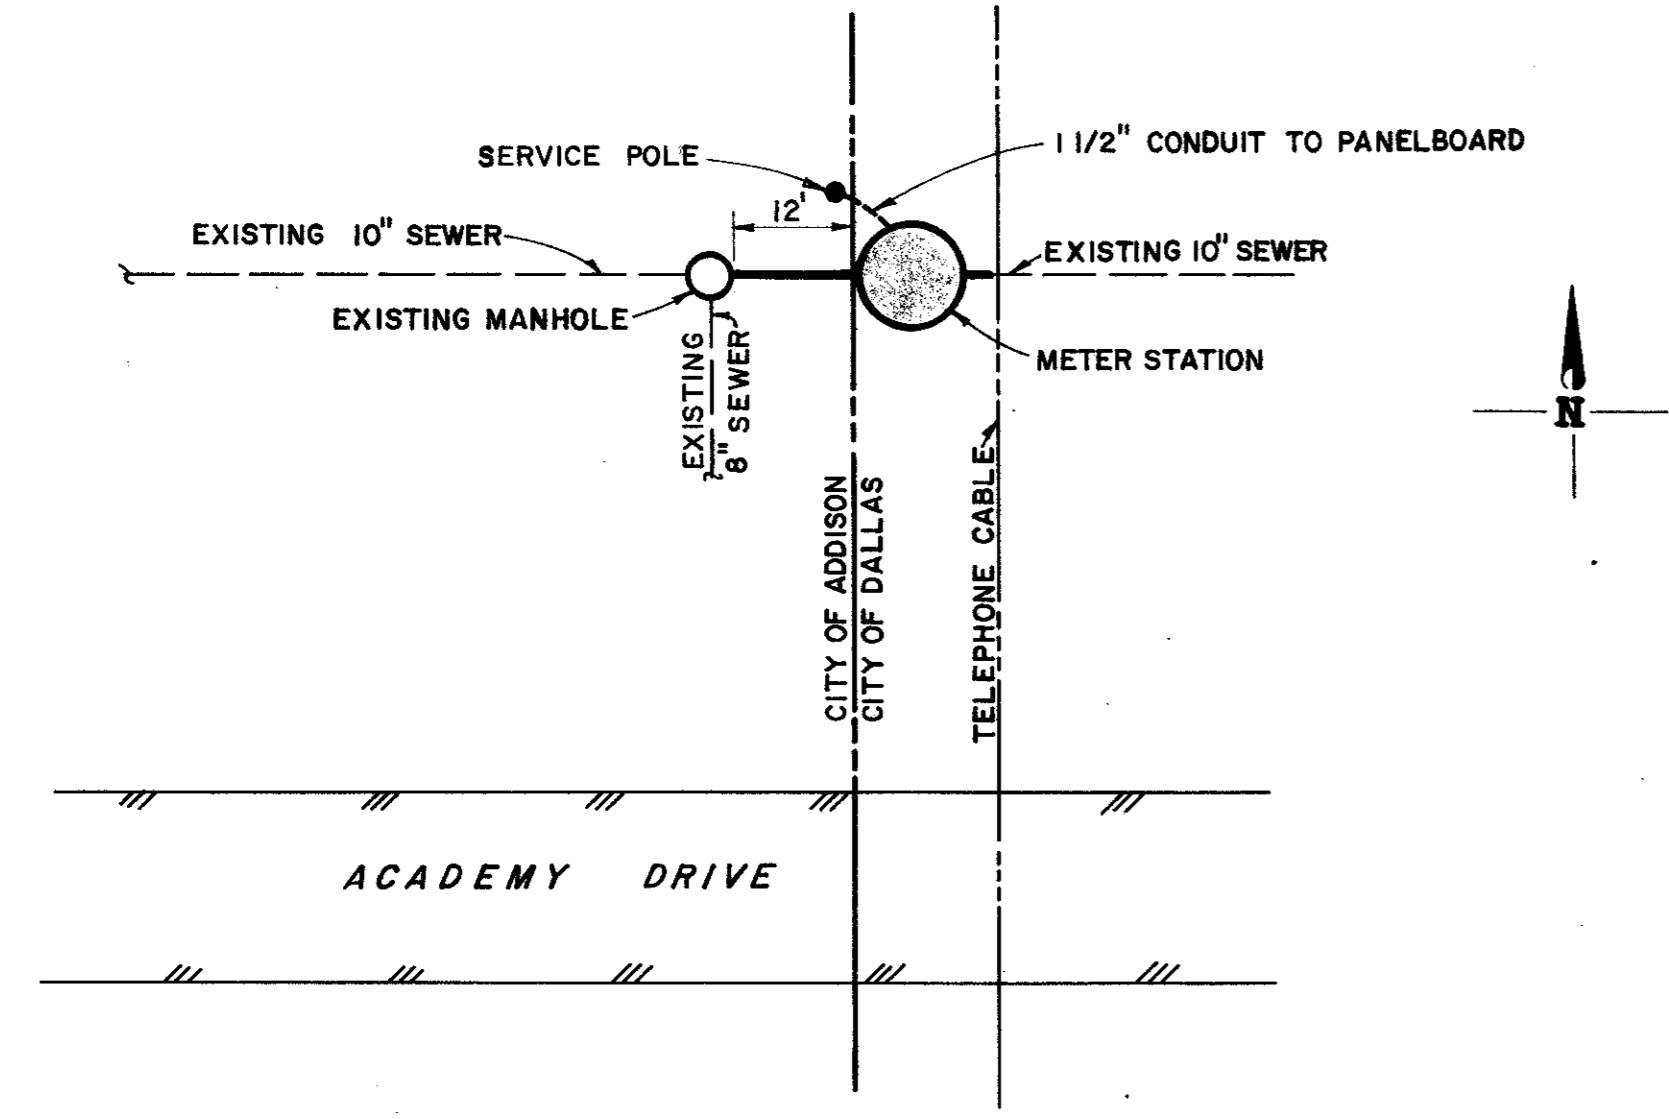


SITE PLAN
SCALE: 1"=20'

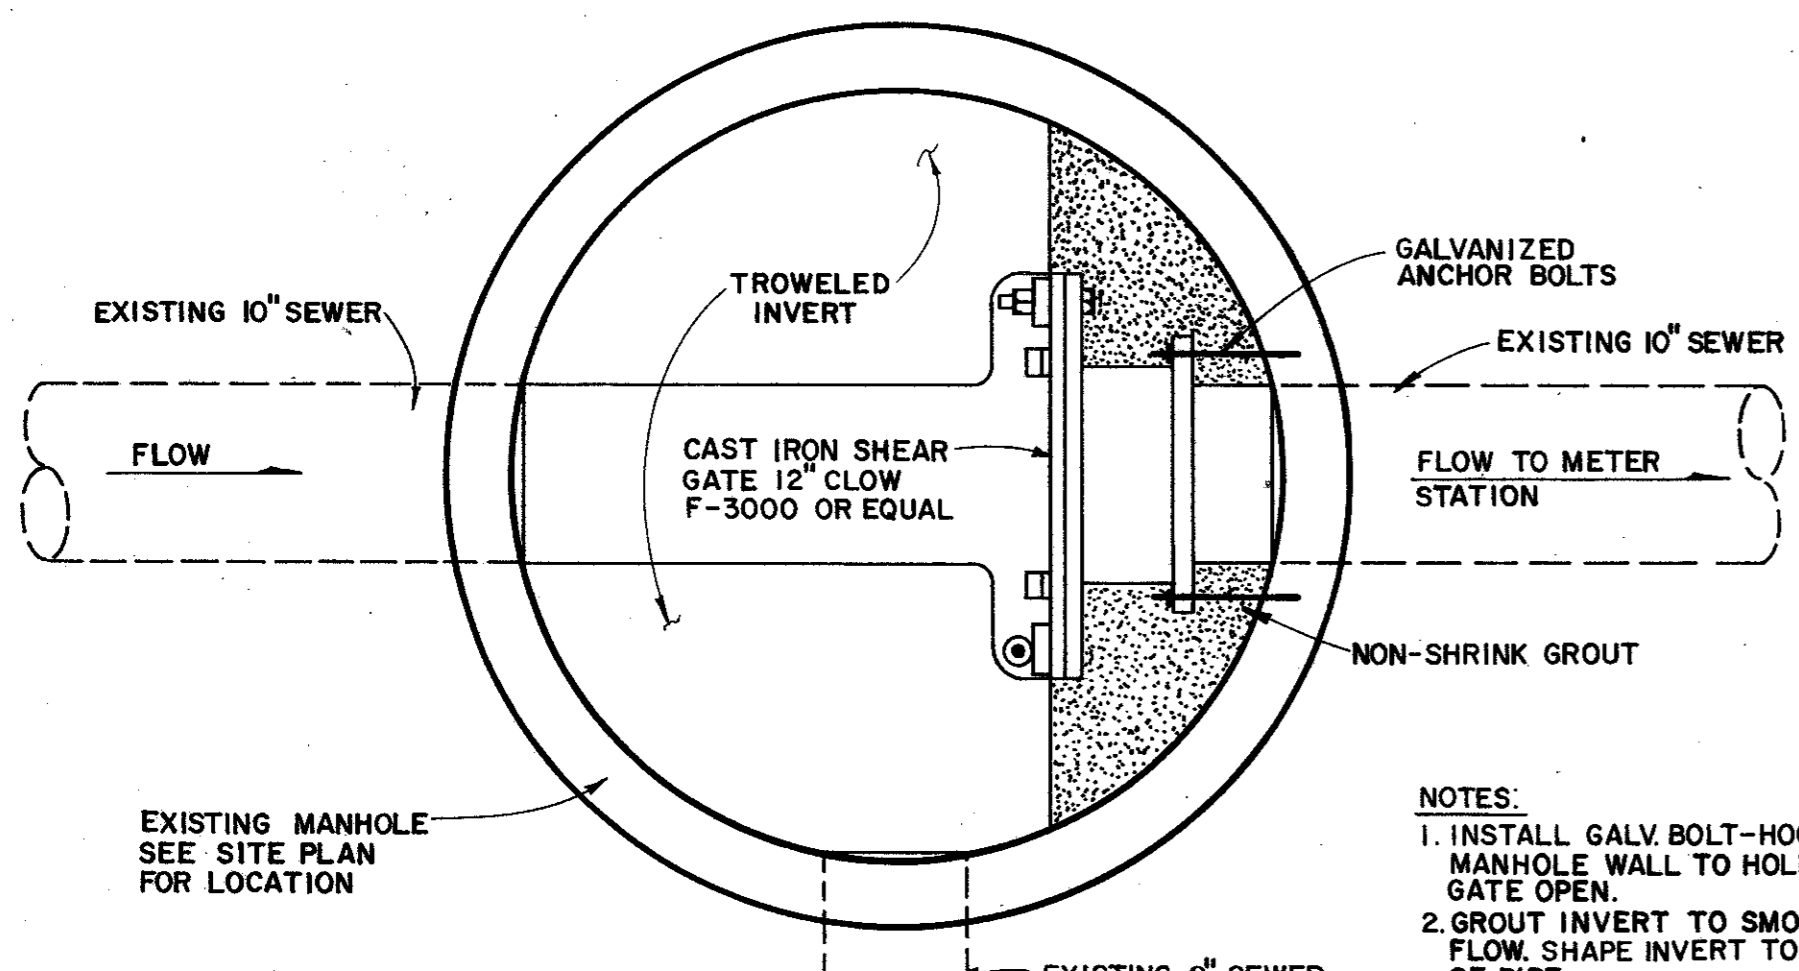


GATE INSTALLATION DETAIL
NO SCALE


NOTES:
1. INSTALL GALV. BOLT-HOOK IN MANHOLE WALL TO HOLD GATE OPEN.
2. GROUT INVERT TO SMOOTH FLOW. SHAPE INVERT TO TOP OF PIPE.

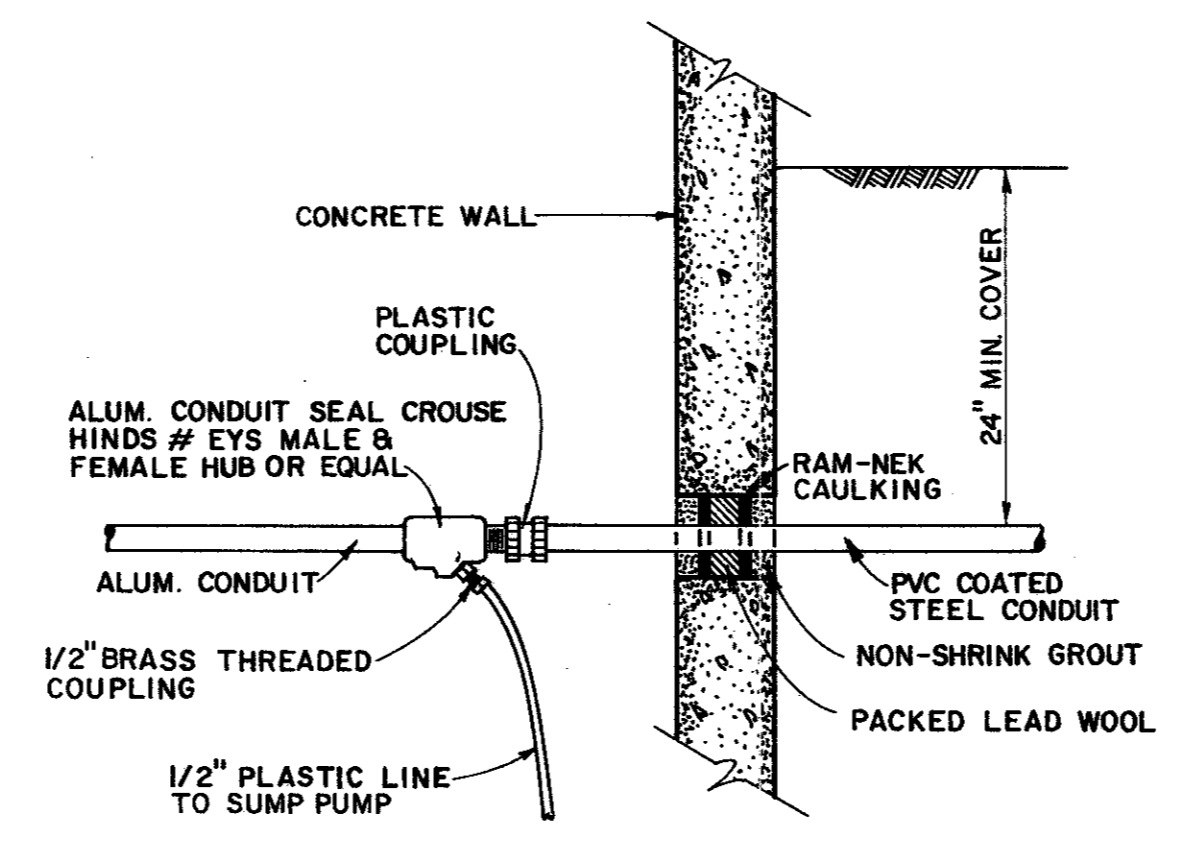

CONDUIT ENTRANCE AND DRAIN DETAIL
NO SCALE

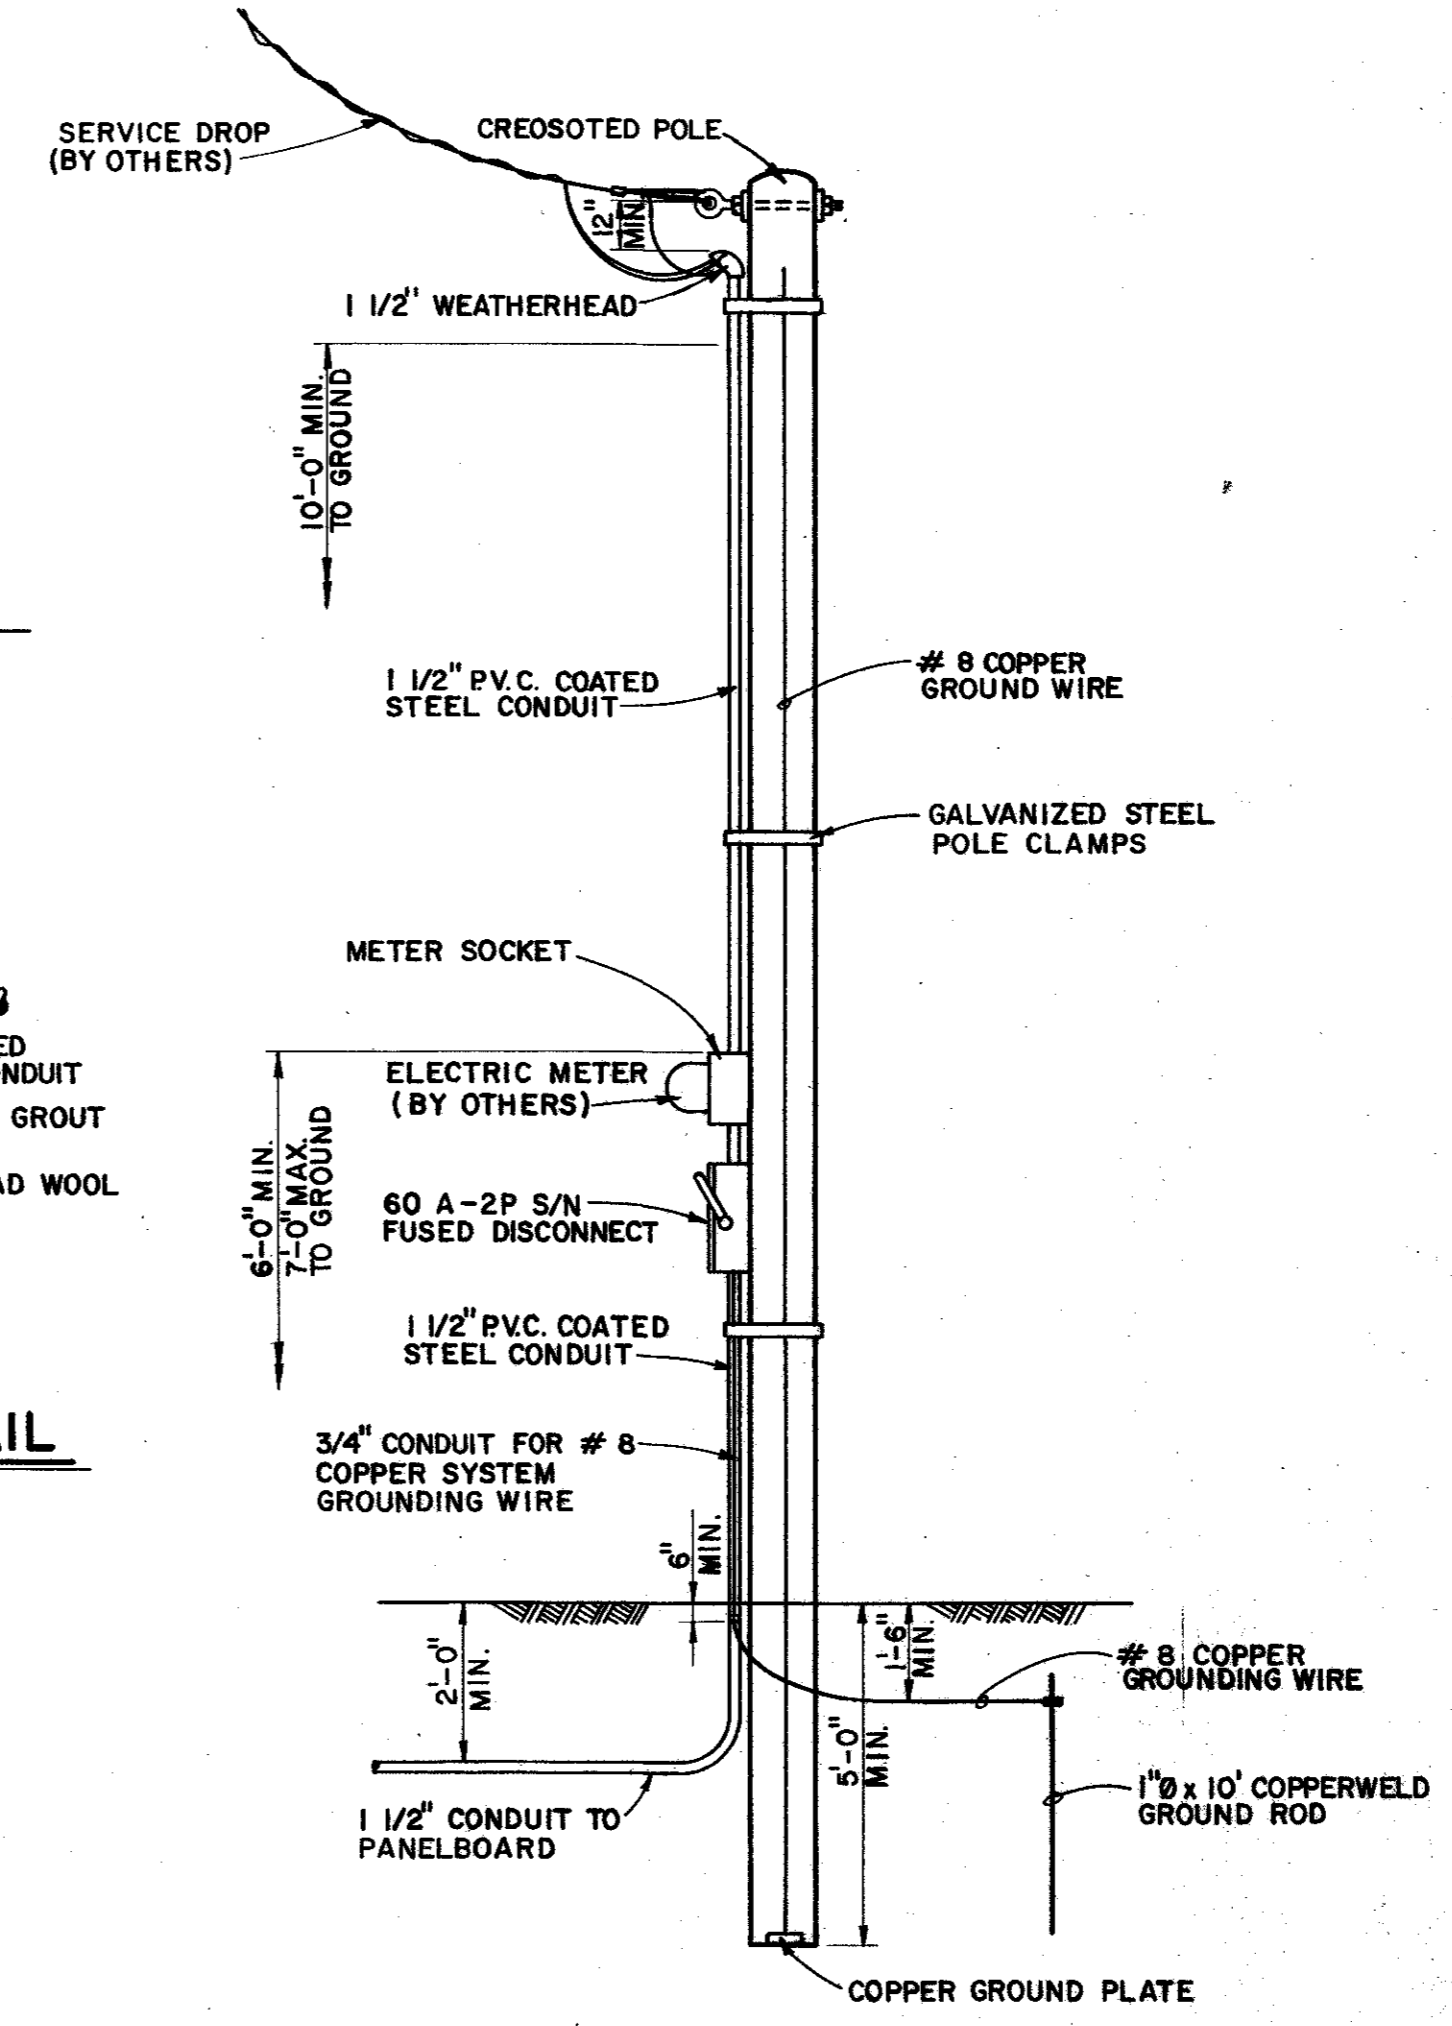


SERVICE POLE DETAIL
NO SCALE

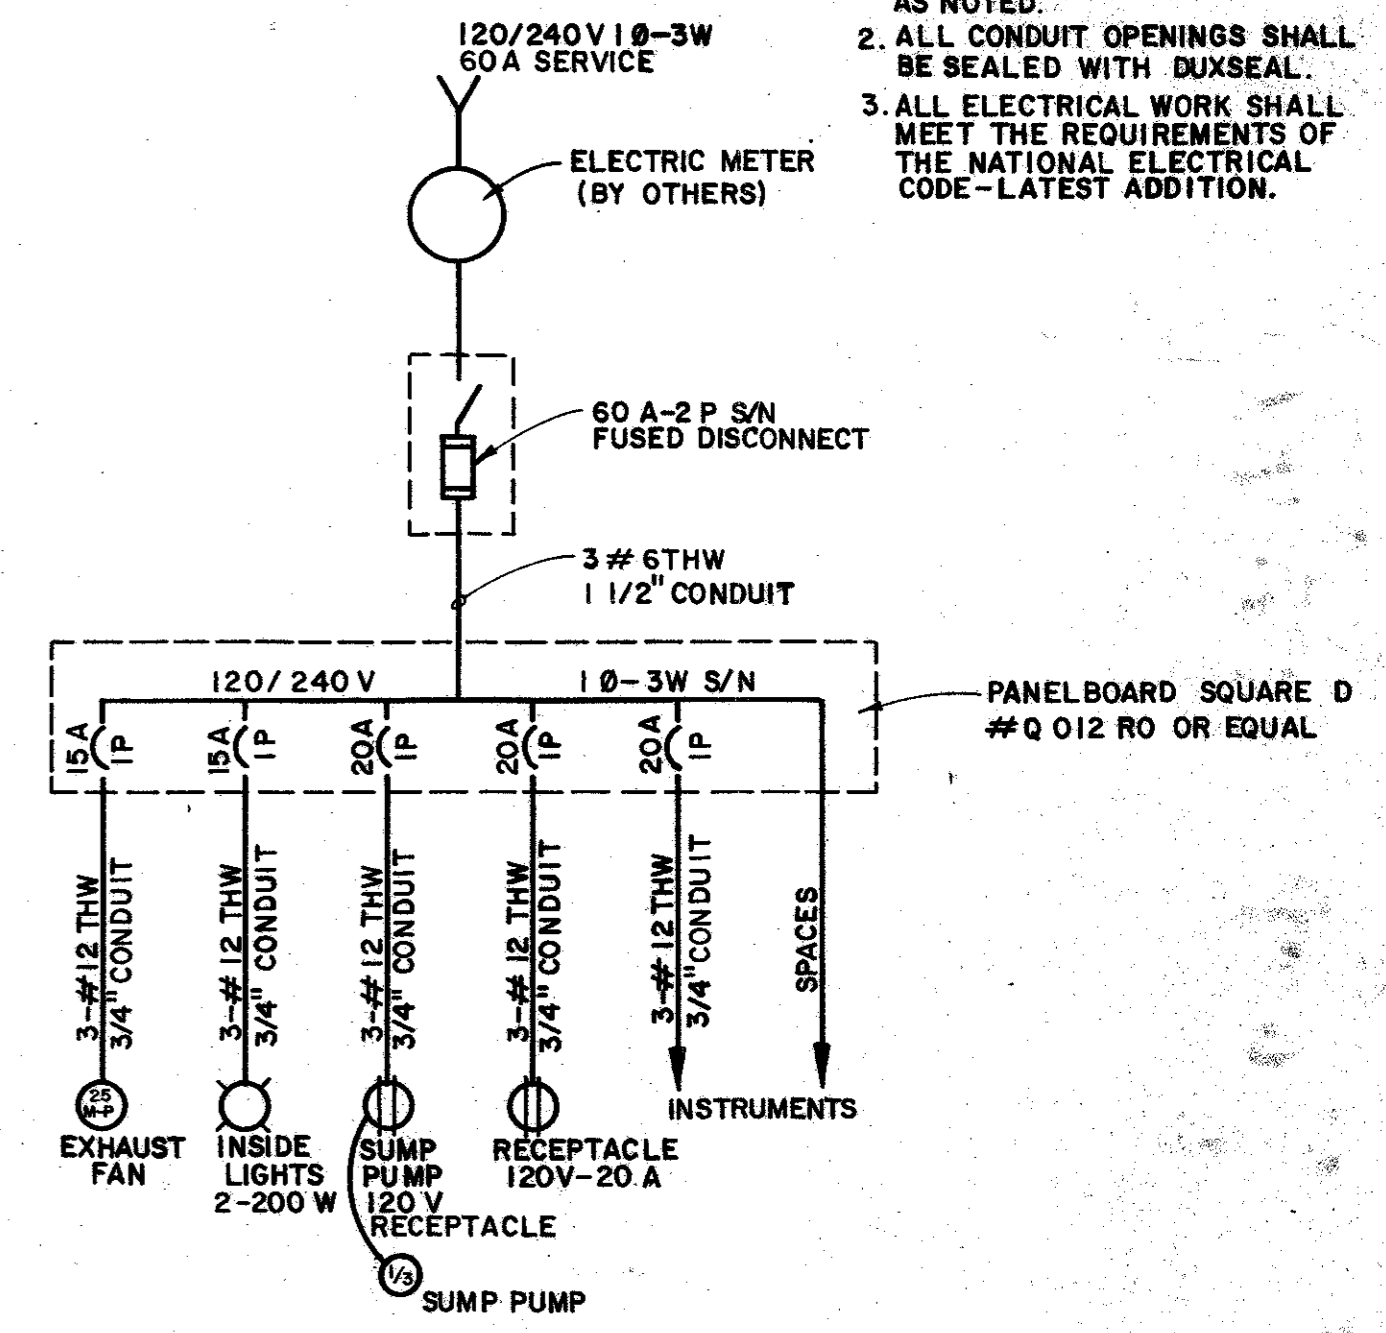


ELECTRICAL DIAGRAM
NO SCALE

NOTES:
1. ALL CONDUIT AND FITTINGS SHALL BE P.V.C. COATED STEEL EXCEPT AS NOTED.
2. ALL CONDUIT OPENINGS SHALL BE SEALED WITH DUXSEAL.
3. ALL ELECTRICAL WORK SHALL MEET THE REQUIREMENTS OF THE NATIONAL ELECTRICAL CODE-LATEST ADDITION.


PRELIMINARY
NOT FOR CONSTRUCTION

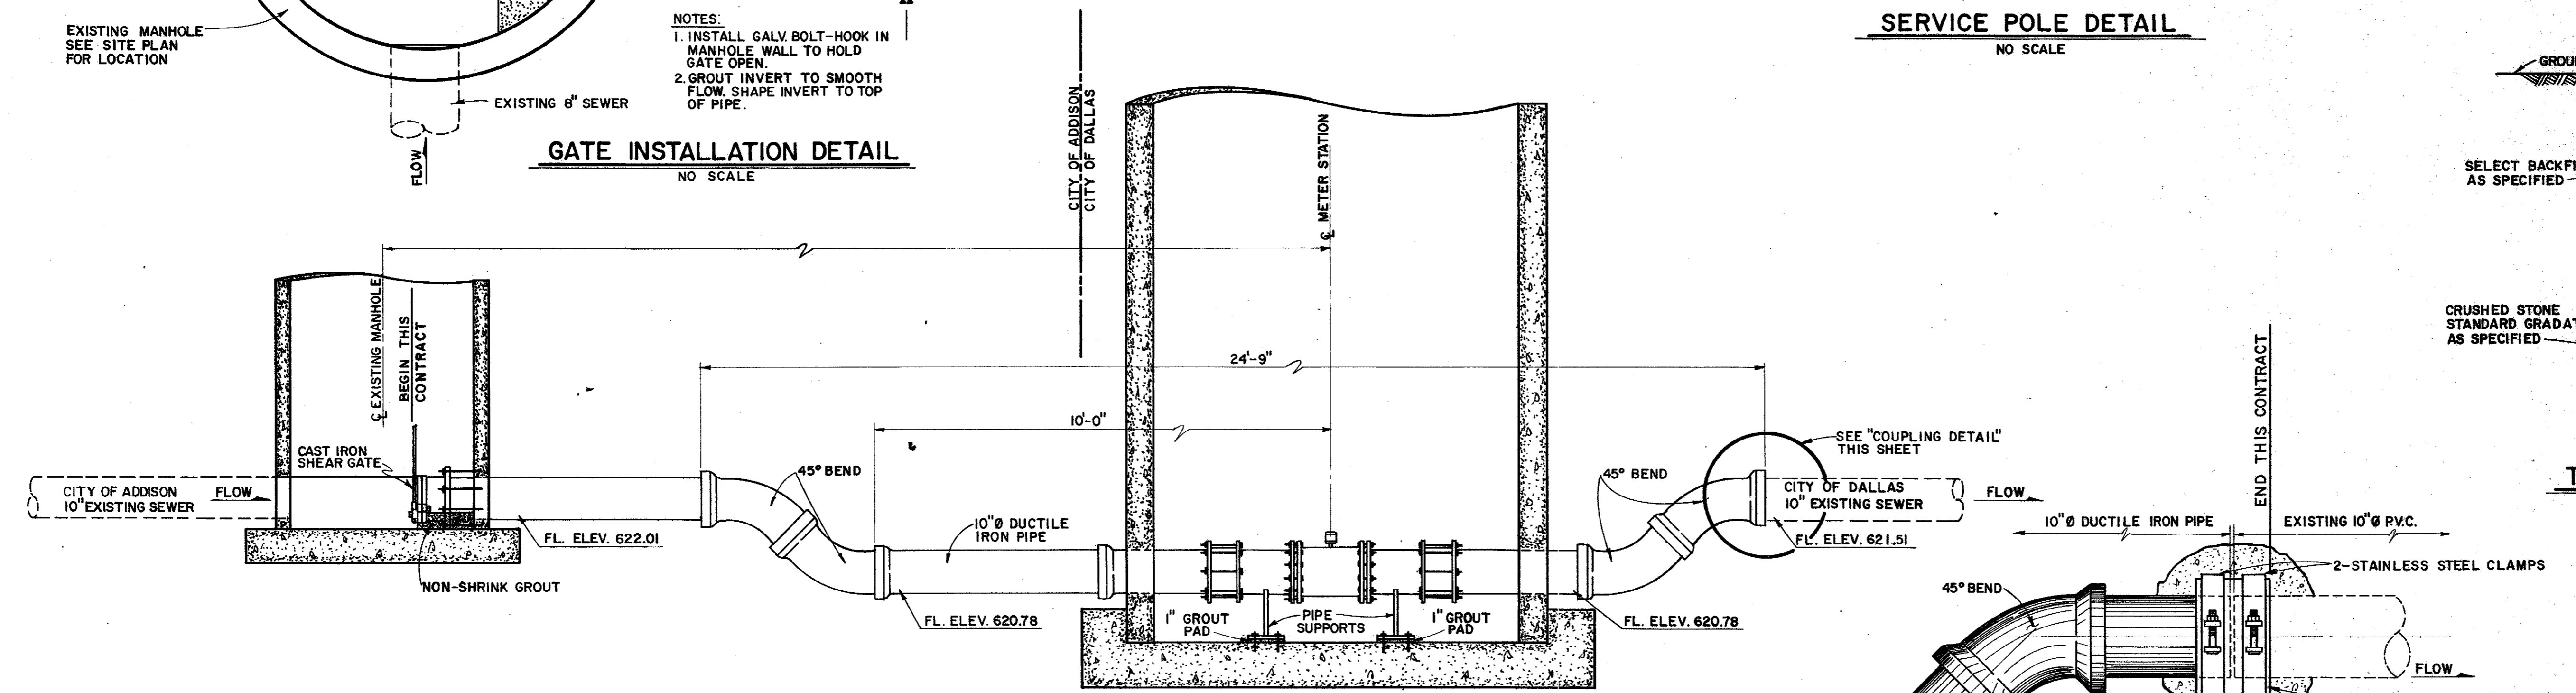

PROFILE
SCALE: 1/2"=1'-0"

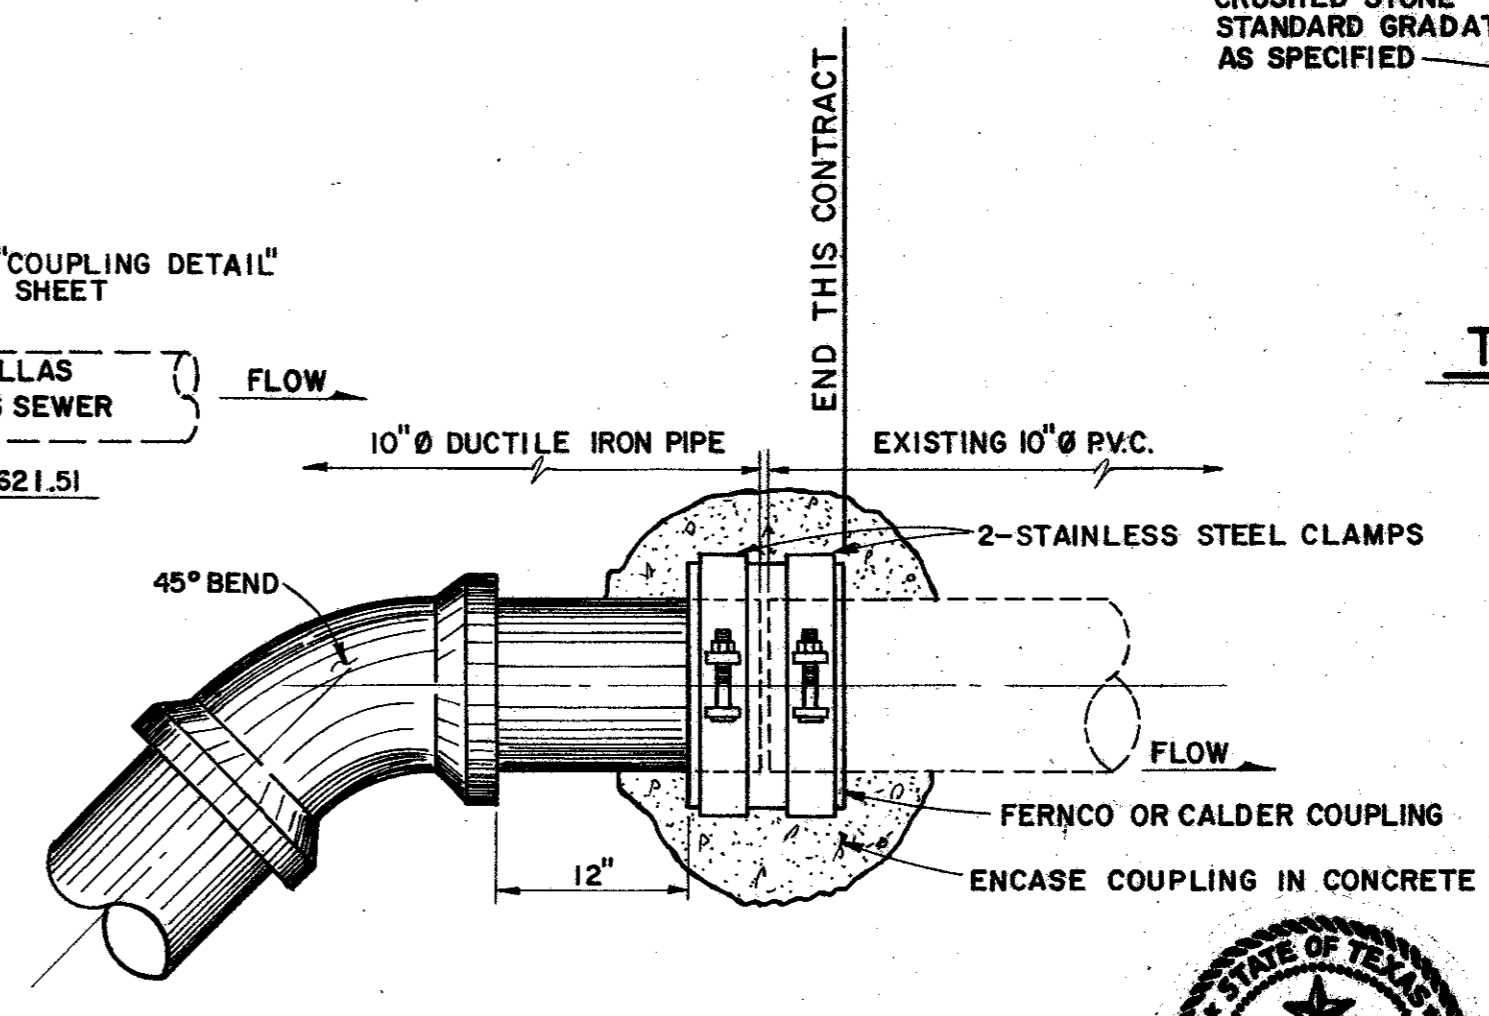

COUPLING DETAIL
SCALE: 1"=1'-0"

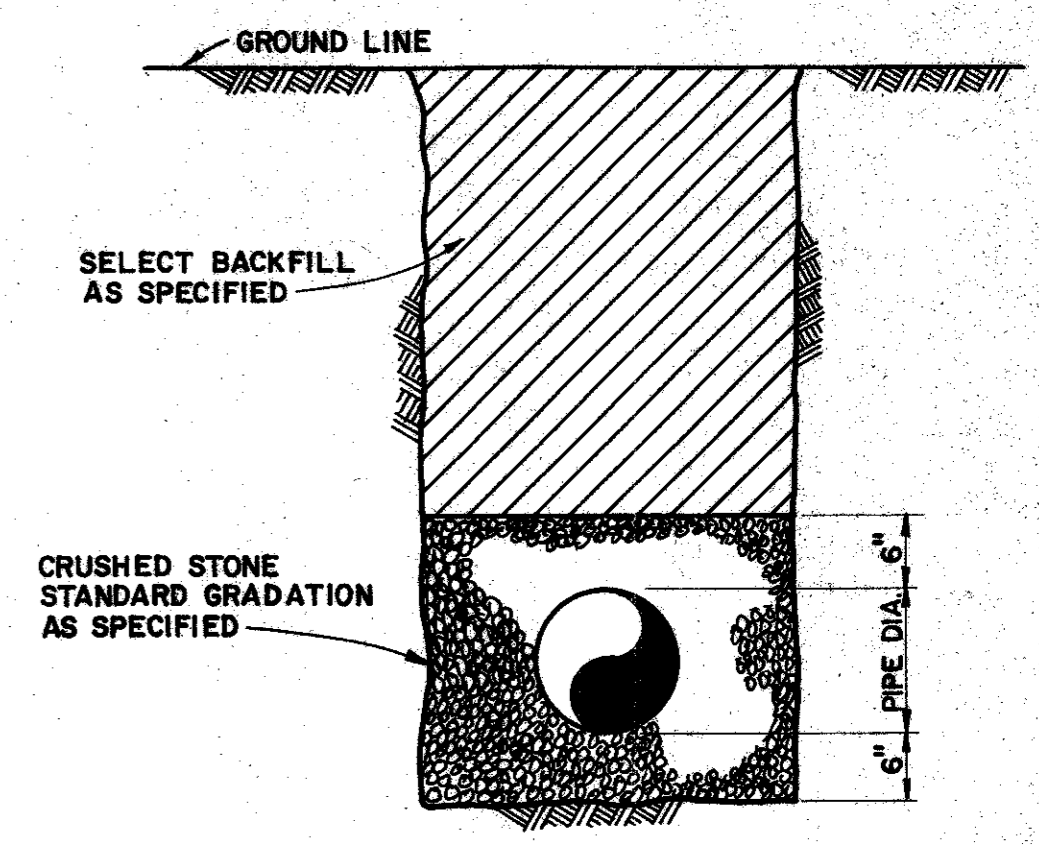

TYPICAL BEDDING DETAIL
NO SCALE

CITY OF DALLAS FILE NO. 681Q-21-S.1

CITY OF ADDISON
DALLAS COUNTY, TEXAS

SEWER IMPROVEMENTS

ACADEMY DRIVE WASTEWATER
METER STATION SITE
PLAN AND DETAILS

GINN & STACY, INC.
CONSULTING ENGINEERS - DALLAS, TEXAS

Designed By: J.O.S. Scale: As Shown
Drawn By: G.L.H. Date: 1978 Sheet 3 of 3

