


2 upper floor — lighting
SCALE: 1/8" = 1' - 0"

LIGHT FIXTURE SCHEDULE

TYPE	MANUFACTURER	LAMP TYPE	WATTS	VOLTS	DESCRIPTION	MOUNTING
A	LOUIS POULSEN HYPERSPECT-XLT	100MH	130	277	SITE LIGHTING	POLE
B	INPT-471-WHITE/FR-NPT-12-2-WHT	175MH	175	277	CAST IN CONCRETE UP COLLAR - WHITE	GROUND
C	LOUIS POULSEN	100MH	100	277	BELLAD	BELLAD
D	INPT-471-WHITE/FR-NPT-12-2-WHT	1377/AS	130	277	RECESSED	RECESSED
E	BEITER 4343-WH-257-13	100W	100	277	ADJUNCT LIGHT	RECESSED
F	HP-TR-7-82P-12-11-CPC-SE	4277/AS	50	277	DOWNLIGHT	RECESSED
G	EDISON PRICE TR-4278-120-201-WF-EM	4277/AS	80	277	CONCRETE POOR DOWNLIGHT	RECESSED
H	EDISON PRICE TR-4278-120-201-WF-EM	4277/AS	80	277	CONCRETE POOR DOWNLIGHT	RECESSED
I	EDISON PRICE LUMINAIRE	4277/AS	80	277	CONCRETE POOR DOWNLIGHT	RECESSED
J	LVP-524-232-011-A-EMB-277	4277/AS	70	277	EMERGENCY LIGHT	RECESSED

K	SS-XX-278-SC-91W-277-AKOCIE	F3209/AS	70	277	PENDANT	INDIRECT/DIRECT FLUORESCENT
L	SS-XX-278-SC-91W-277-AKOCIE	F3209/AS	70	277	PENDANT	WITH BATTERY BACK-UP
M	HE WILLIAM 76-4-232-E277	F3209/AS	70	277	SURFACE	FLUORESCENT STRIP
N	NYP-LVP-450-DOMINAL	100MH	130	277	PENDANT	PALLADON (AT #)
P	ARP-PP-19-250MH-3-MT-BK-HS	250WPS	310	277	POLE	SITE LIGHTING POLE FIXTURE (AT #)
Q	RR88929-45-FT	3277/AS	80	277	RECESSED	SHOWER (IN CONCRETE)
R	HUBELL ER-3-100MH-1/2(PH)18128	1000MH	130	277	POLE	TENNIS COURT POLES/FIXTURES (AT #)
S	HUBELL 818-382-9485	PH 56	500	120	RECESSED	UNDER WATER
X	HUBELL X30 SERIES (LED)					EXIT SIGN (POWERLESS)

NOTE: CROSS HATCHED FIXTURES DENOTE EMERGENCY LIGHTS. PROVIDE FIXTURE WITH 90-MINUTE BATTERY BACK-UP.

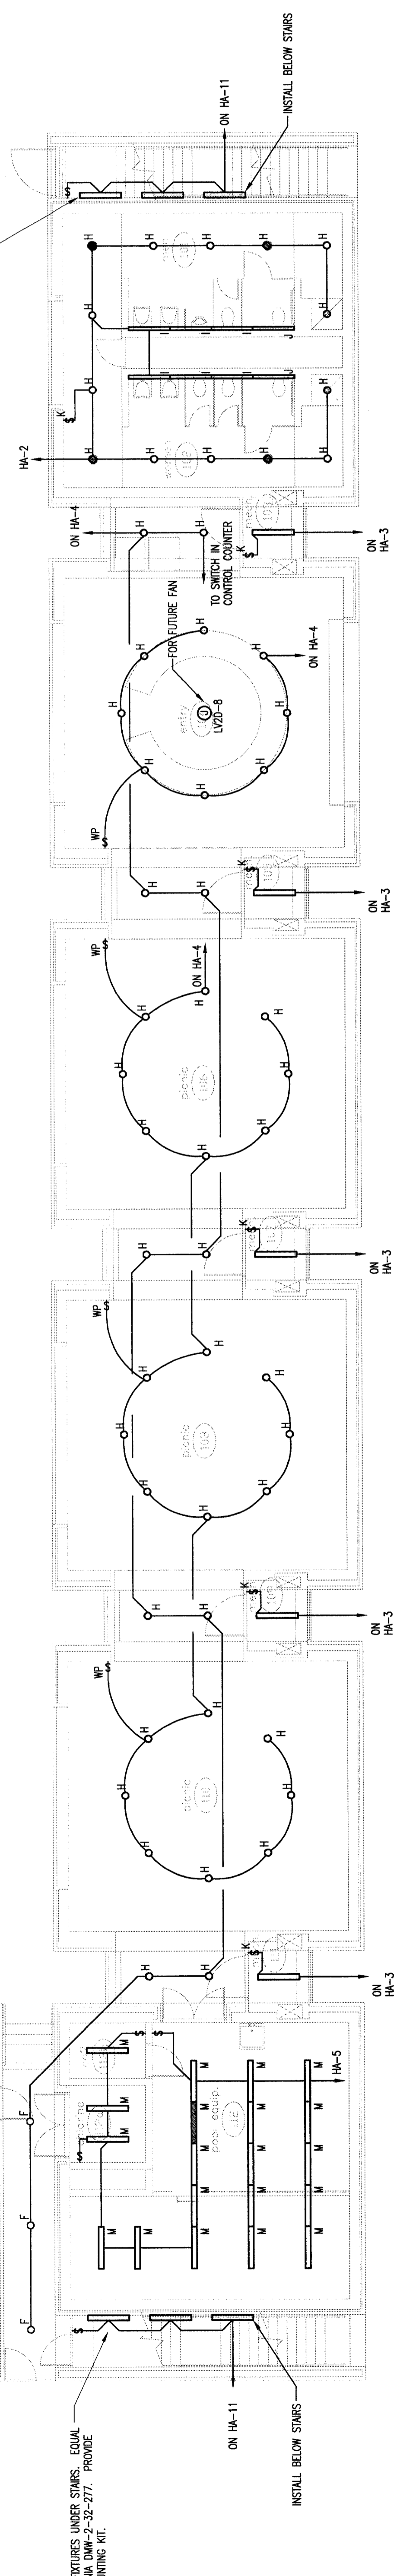

1 lower floor — lighting
SCALE: 1/8" = 1' - 0"