



- LEGEND**
- ⊙ DRAINAGE MANHOLE
 - ⊕ STORM DRAIN MANHOLE
 - ⊖ CATCH BASIN
 - ⊗ AREA DRAIN
 - CURB INLET
 - D — STORM DRAIN PIPE
 - UD — SOLID UNDERDRAIN PIPE (4" PVC)
 - UD — PERFORATED UNDERDRAIN PIPE (4" PVC)
 - 6.35 — PROPOSED CONTOUR (5)
 - x6.35 SPOT GRADE
 - HP HIGH POINT
 - LP LOW POINT
 - TR TOP OF RAMP
 - BR BOTTOM OF RAMP
 - TS TOP OF STEPS
 - BS BOTTOM OF STEPS
 - TC TOP OF CURB
 - BC BOTTOM OF CURB
 - TW TOP OF WALL
 - BW BOTTOM OF WALL
 - WE WATER ELEVATION
 - FL FLOW LINE
 - I INVERT ELEVATION
 - ⊠ KIOSK UTILITY BOX
 - 100001 xxxxxxxx POINT FOR COORDINATE SYSTEM

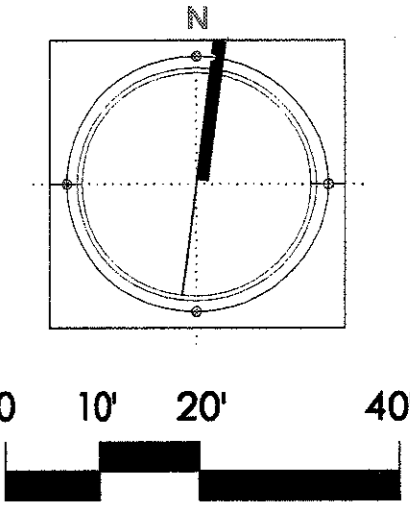

2	BULLETIN #1	12-30-02
	ISSUED FOR CONSTRUCTION	11-26-02
1	ADDENDUM #2	10-21-02
	ISSUED FOR CONSTRUCTION	09-30-02
No.	Description	Date

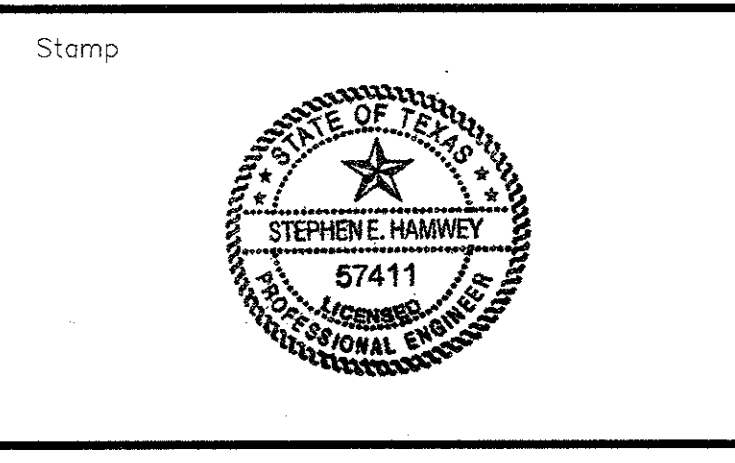

Project Title:
ADDISON ARTS & EVENTS DISTRICT
 ADDISON, TEXAS

Drawing Title:
GRADING & DRAINAGE PLAN

Project No. 14516.00 Scale: 1"=20'-0"
 Drawn By: SM
 Checked By: TC
 Approved By: SEH
 Date: September 30, 2002

Drawing No. **C3-2**