



NOTES:
 1. ALTERNATE COLUMNS TO HAVE GFCI DUPLEX OUTLETS ON BACK SIDE (LAWN SIDE) OF COLUMNS, MOUNTED AT 18" HEIGHT FROM FINISH GRADE (SEE ELECTRICAL PLANS). LIMESTONE BLOCKS TO BE CORED FOR OUTLETS, OR CONCRETE BASE TO HAVE RECEPTACLE CAST IN, DEPENDING ON COLUMN BASE CONDITION. HINGED COVER PLATES TO BE MOUNTED FLUSH WITH FACE OF COLUMN.

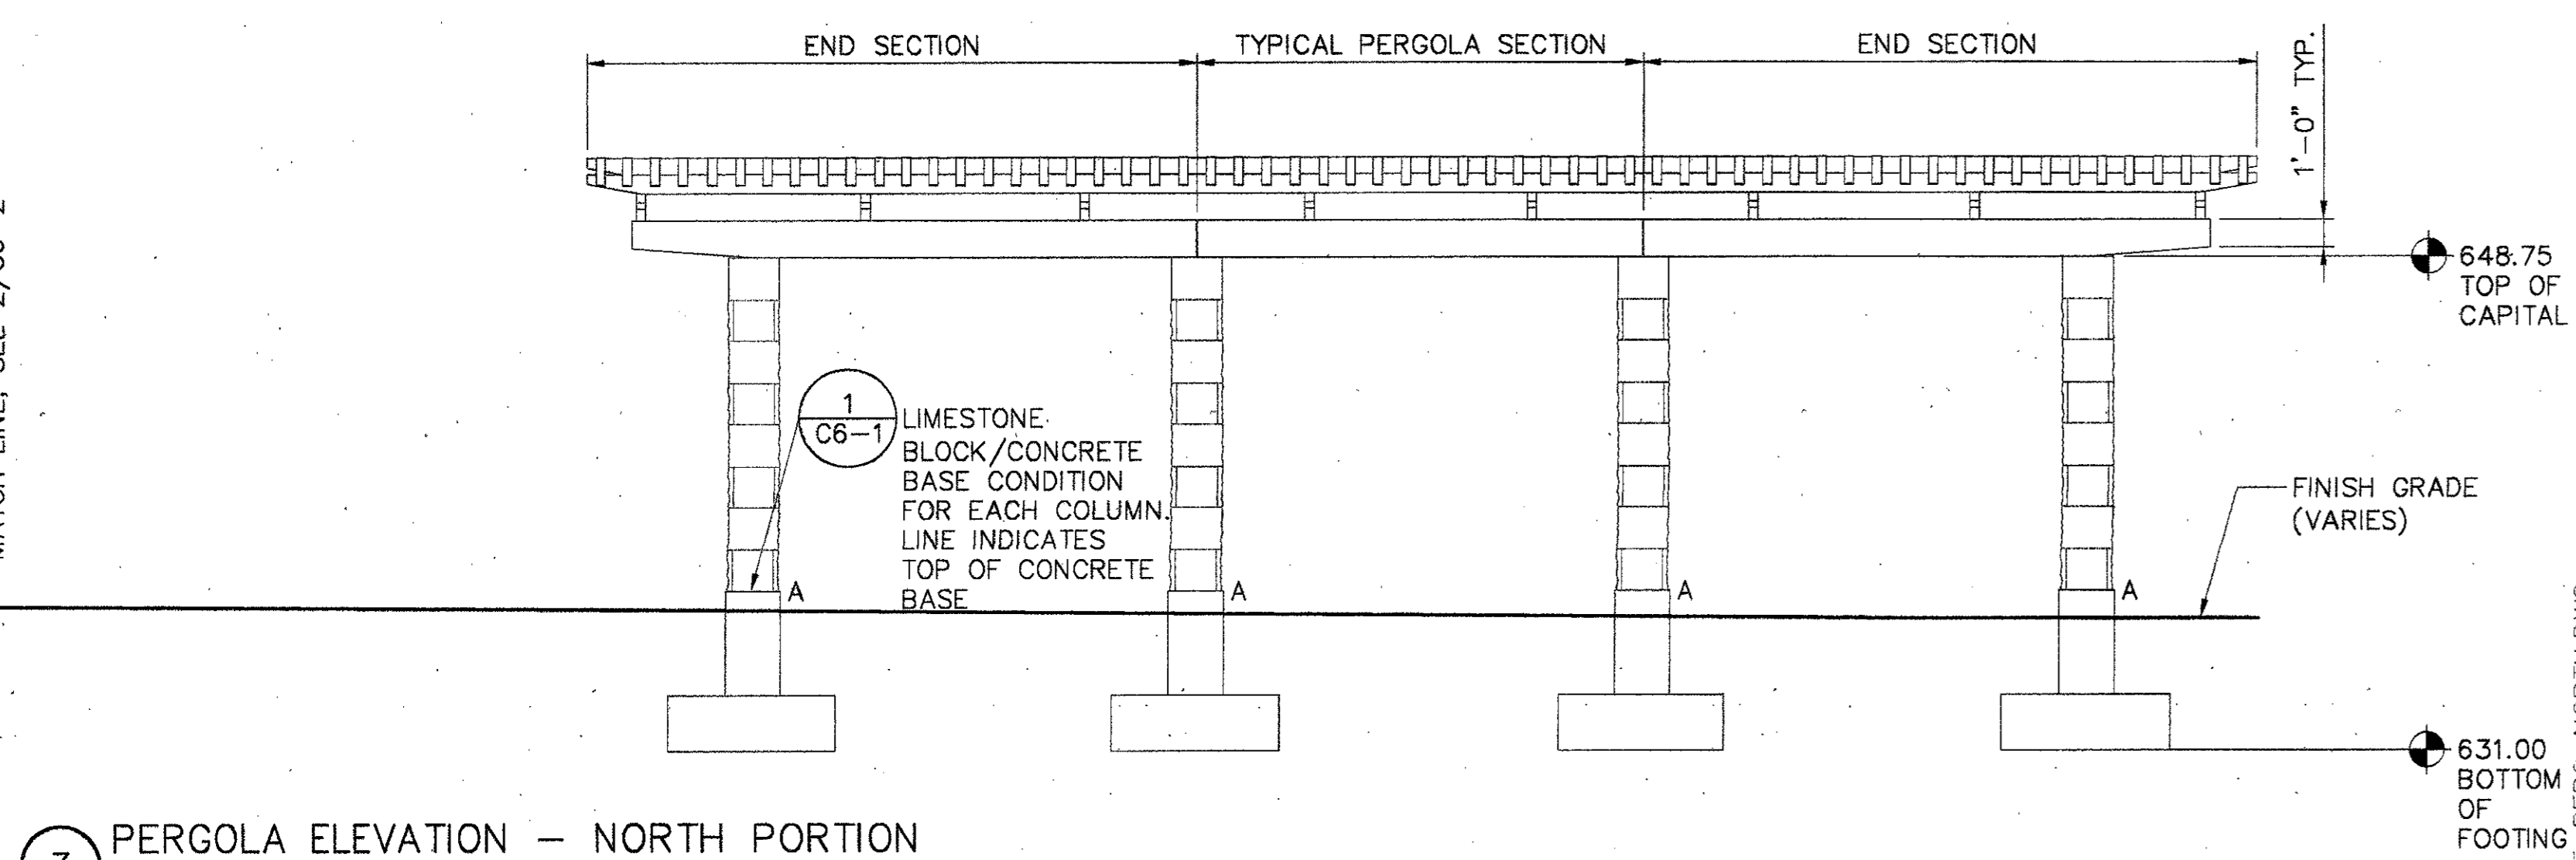


3 PERGOLA ELEVATION - NORTH PORTION

SCALE: 3/16" = 1'-0"

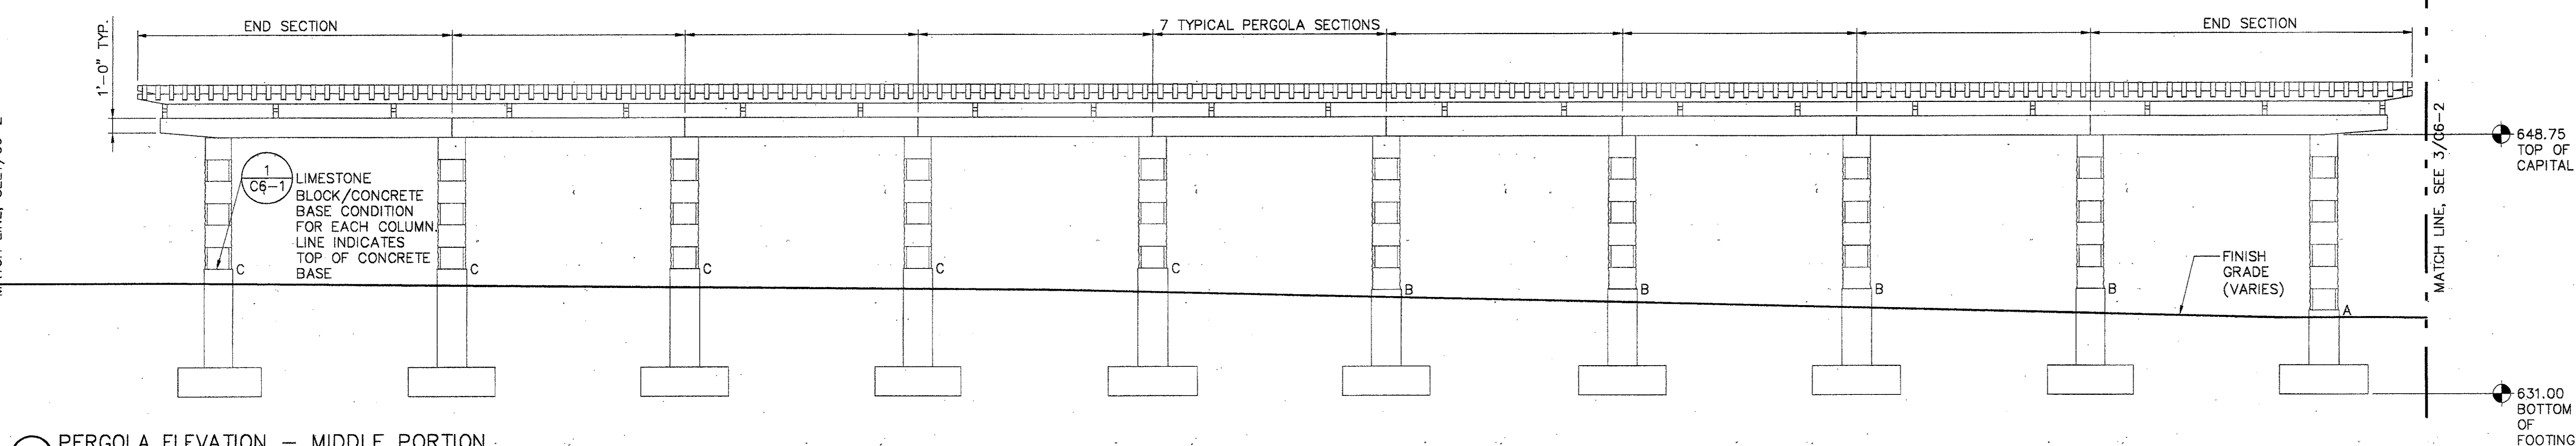

2 PERGOLA ELEVATION - MIDDLE PORTION

SCALE: 3/16" = 1'-0"

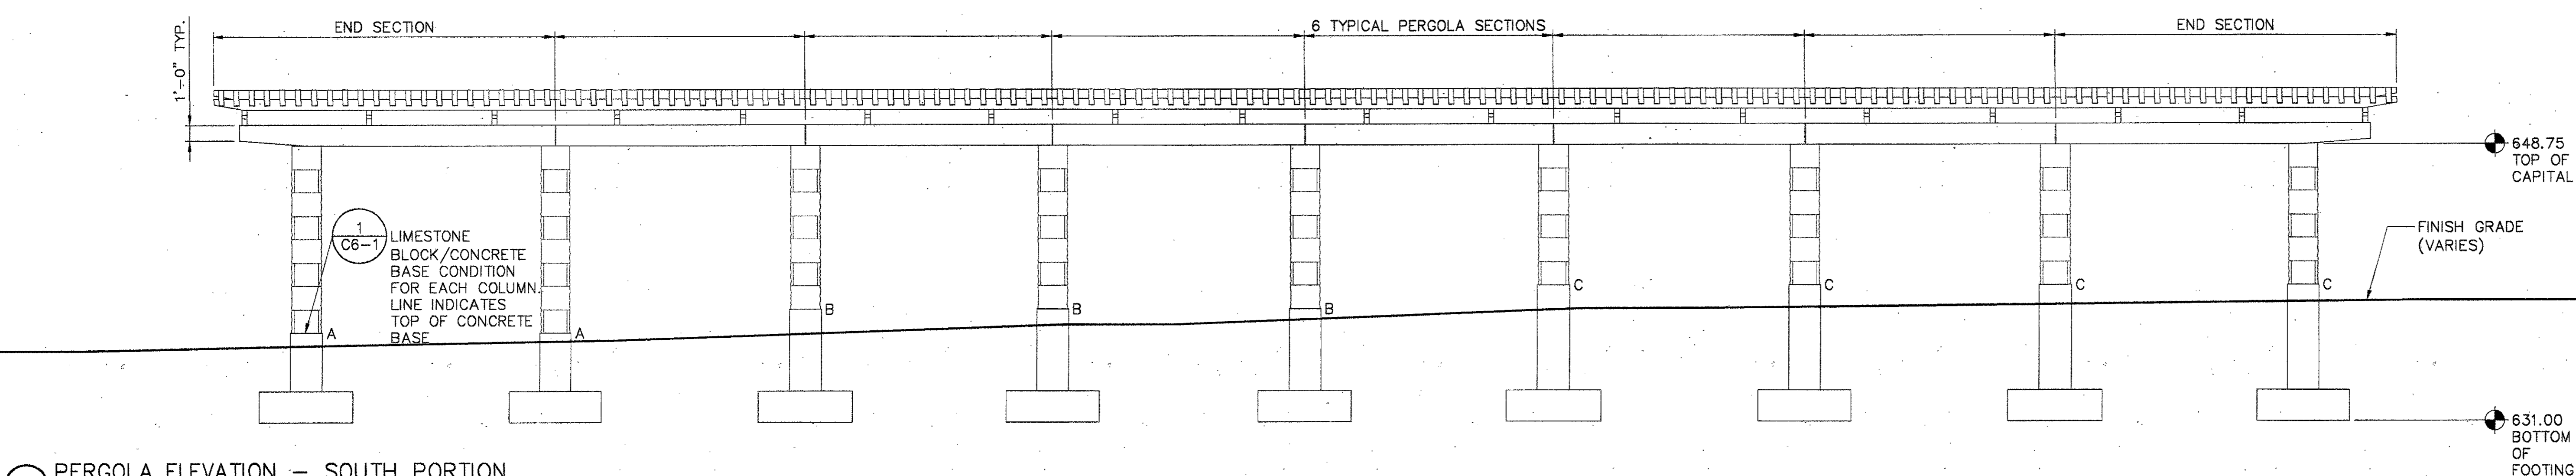


1 PERGOLA ELEVATION - SOUTH PORTION

SCALE: 3/16" = 1'-0"

ADDENDUM #2	10-21-02
ISSUED FOR CONSTRUCTION	09-30-02
No. Description	Date

DWG ISSUE & REVISION HISTORY

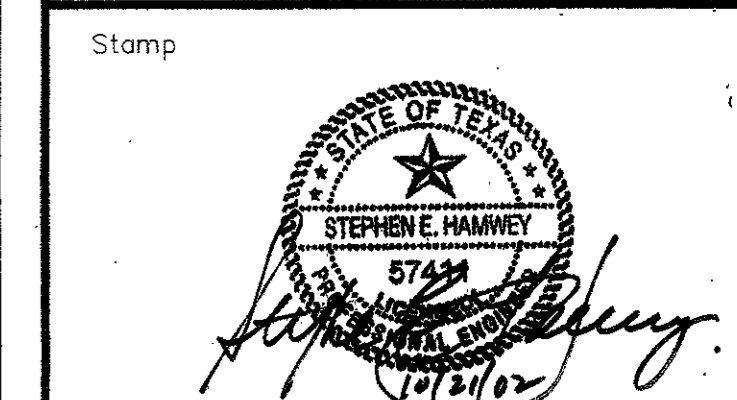

Project Title:
ADDISON ARTS & EVENTS DISTRICT
 ADDISON, TEXAS

Drawing Title:
PERGOLA ELEVATIONS

Project No. 14516.00 Scale: AS NOTED
 Drawn By: CB
 Checked By: DC
 Approved By: SEH
 Date: September 30, 2002

Drawing No. **C6-2**