

CIVIL PLANS FOR CONSTRUCTION OF
PAVING, STREETScape AND UTILITY IMPROVEMENTS

ADDISON CIRCLE

PUBLIC INFRASTRUCTURE

PHASE II



T O W N O F
ADDISON

OWNER:


TOWN OF ADDISON
DEPARTMENT OF PUBLIC WORKS
16801 WESTGROVE
P.O. BOX 144
ADDISON, TEXAS 75001
(972) 450-2871 FAX (972) 450-2837

ENGINEER & LANDSCAPE ARCHITECT:

HUITT-ZOLLARS, INC.
3131 MCKINNEY AVE., SUITE 600
DALLAS, TEXAS 75204
(214) 871-3311 FAX (214) 871-0757
DAVID E. MEYERS, P.E.
TX. REG. NO. 81512
KAREN W. KOERTH, L.A.
TX. REG. NO. 1594

**RECORD
DRAWING**

THE SEAL APPEARING ON THIS
DOCUMENT WAS AUTHORIZED BY
DAVID E. MEYERS, P.E. 81512
ON OCTOBER 3, 1997.

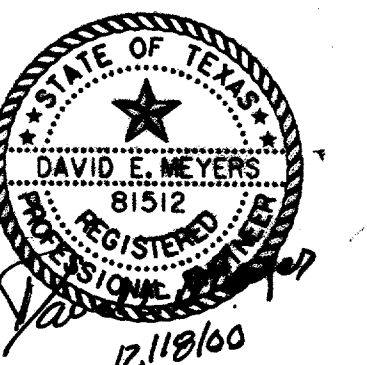


RECORD DRAWINGS

11/17/00

THIS SET OF DRAWINGS HAS BEEN MODIFIED FROM THE ORIGINAL DESIGN DRAWINGS TO REFLECT THE FIELD CHANGES THAT OCCURRED DURING CONSTRUCTION WHICH WERE DOCUMENTED AND FINISHED TO THE ENGINEER BY THE CONTRACTOR. BASED ON THIS INFORMATION AND THE ENGINEER'S OBSERVATION OF CERTAIN CONSTRUCTION ACTIVITIES, TO THE BEST OF THE ENGINEER'S KNOWLEDGE AND BELIEF, THE PROJECT IS CONSTRUCTED IN CONFORMANCE WITH THE PLANS AND SPECIFICATIONS AND WILL FUNCTION AS DESIGNED.

SHEET NO.	INDEX OF DRAWINGS
	COVER SHEET
HC1	HORIZONTAL CONTROL PLAN
P1-P2	PAVING TYPICAL SECTIONS
P3-P4	RECOMMENDED UTILITY LOCATIONS
P5	SIGNAGE AND STRIPING PLAN
P6	TRAFFIC SIGN DETAILS
P7	PAVING SITE PLAN
P8-P20	PAVING PLANS & PROFILES
P21-P23	PAVING DETAILS
P24	SLEEVING PLAN
SP1-SP8	SURFACE PATTERNING PLANS
SP9	SURFACE PATTERNING DETAILS
ST1	STREETSCAPE SITE PLAN
ST2-ST9	STREETSCAPE PLANS
ST10-ST14	STREETSCAPE, LIGHT & SUBDRAIN DETAILS
SW1-SW2	DRAINAGE AREA MAP
SW3-SW9	STORM WATER CALCULATIONS
SW10	STORM WATER SITE PLAN
SW11-SW25	STORM WATER PLANS & PROFILES
SW26-SW28	STORM WATER DETAILS
W1	WATER & WASTEWATER SITE MAP
W2-W13	WATER PLANS & PROFILES
W14-W15	WATER DETAILS
WW1-WW5	WASTEWATER PLANS & PROFILES
WW6-WW7	WASTEWATER DETAILS
PC1	POLLUTION CONTROL PLAN
PC2	POLLUTION CONTROL DETAILS
E1	ELECTRICAL DUCT BANK SITE PLAN
E2-E11	ELECTRICAL DUCT BANK PLANS & PROFILES
E12-E20	ELECTRICAL DUCT BANK DETAILS
E21-E23	TREE LIGHT & STREET LIGHT POWER PLANS & DETAILS
PF1-PF8	PLANTING & FURNITURE PLANS
PF9	PLANTING DETAILS
IR1-IR8	IRRIGATION PLANS
IR9	IRRIGATION DETAILS

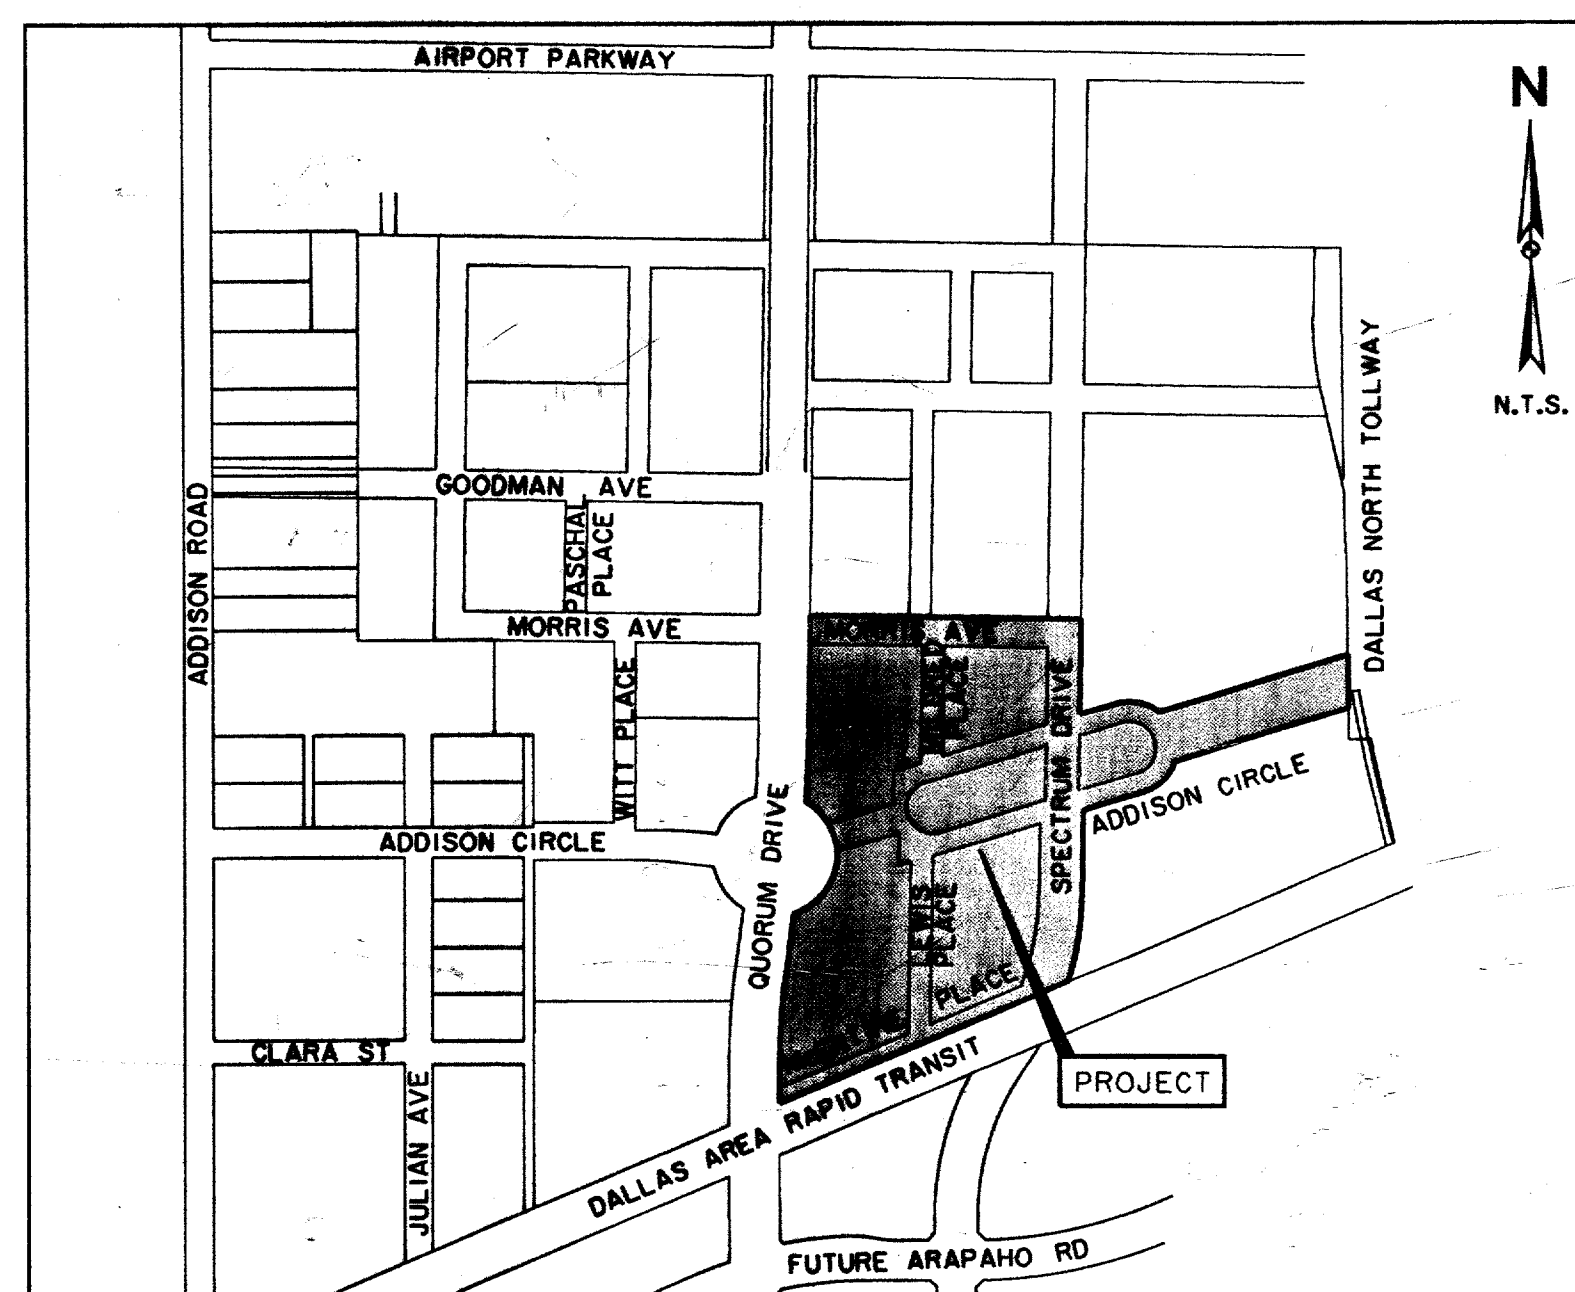

LOCATION MAP