



CIVIL AND LANDSCAPE PLANS FOR CONSTRUCTION OF
PAVING, STREETScape AND UTILITY IMPROVEMENTS

ADDISON CIRCLE PUBLIC INFRASTRUCTURE PHASE II-B

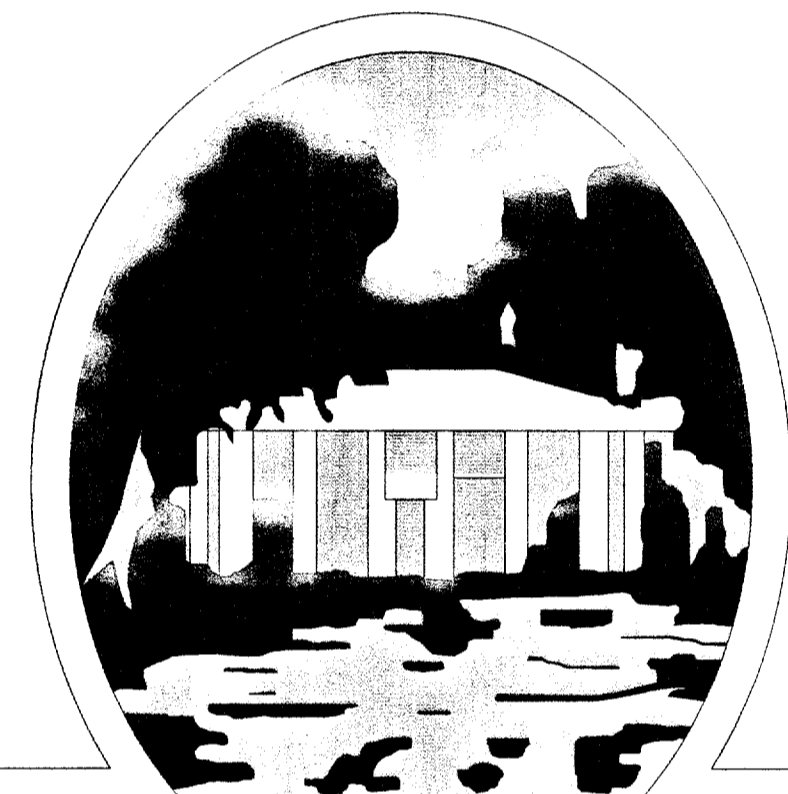

T O W N O F
ADDISON

SHEET NO.	INDEX OF DRAWINGS
	COVER SHEET
P1	LEGEND & ABBREVIATIONS
P2	HORIZONTAL CONTROL PLAN
P3	PAVING TYPICAL SECTIONS & RECOMMENDED UTILITY LOCATIONS
P4	DEMOLITION PLAN
P5	PAVING & STREETScape SITE PLAN
P6	SIGNAGE & STRIPING PLAN
P7-P11	PAVING PLANS & PROFILES
GRI-GR2	SIDEWALK GRADING PLANS
PI2	SLEEVING PLAN
PI3-PI4	PAVING DETAILS
ST1-ST2	STREETScape PLANS
ST3-ST6	STREETScape, LIGHT & SUBDRAIN DETAILS
SW1	DRAINAGE AREA MAP
SW2-SW3	STORM WATER CALCULATIONS
SW4	STORM WATER SITE PLAN
SW5-SW7	STORM WATER PLANS & PROFILES
SW8-SW9	STORM WATER DETAILS
W1	WATER & WASTEWATER SITE PLAN
W2-W5	WATER PLANS & PROFILES
W6-W7	WATER DETAILS
WW1	WASTEWATER PLAN & PROFILE
WW2-WW3	WASTEWATER DETAILS
PC1	POLLUTION CONTROL PLAN
PC2	POLLUTION CONTROL DETAILS
E1	ELECTRICAL DUCT BANK SITE PLAN
E2-E4	ELECTRICAL DUCT BANK PLANS & PROFILES
E5-E13	ELECTRICAL DUCT BANK DETAILS
E14-E15	STREET LIGHT POWER PLANS & DETAILS
PF1-PF2	PLANTING & FURNITURE PLANS
PF3	PLANTING DETAILS
IR1-IR2	IRRIGATION PLANS
IR3	IRRIGATION DETAILS

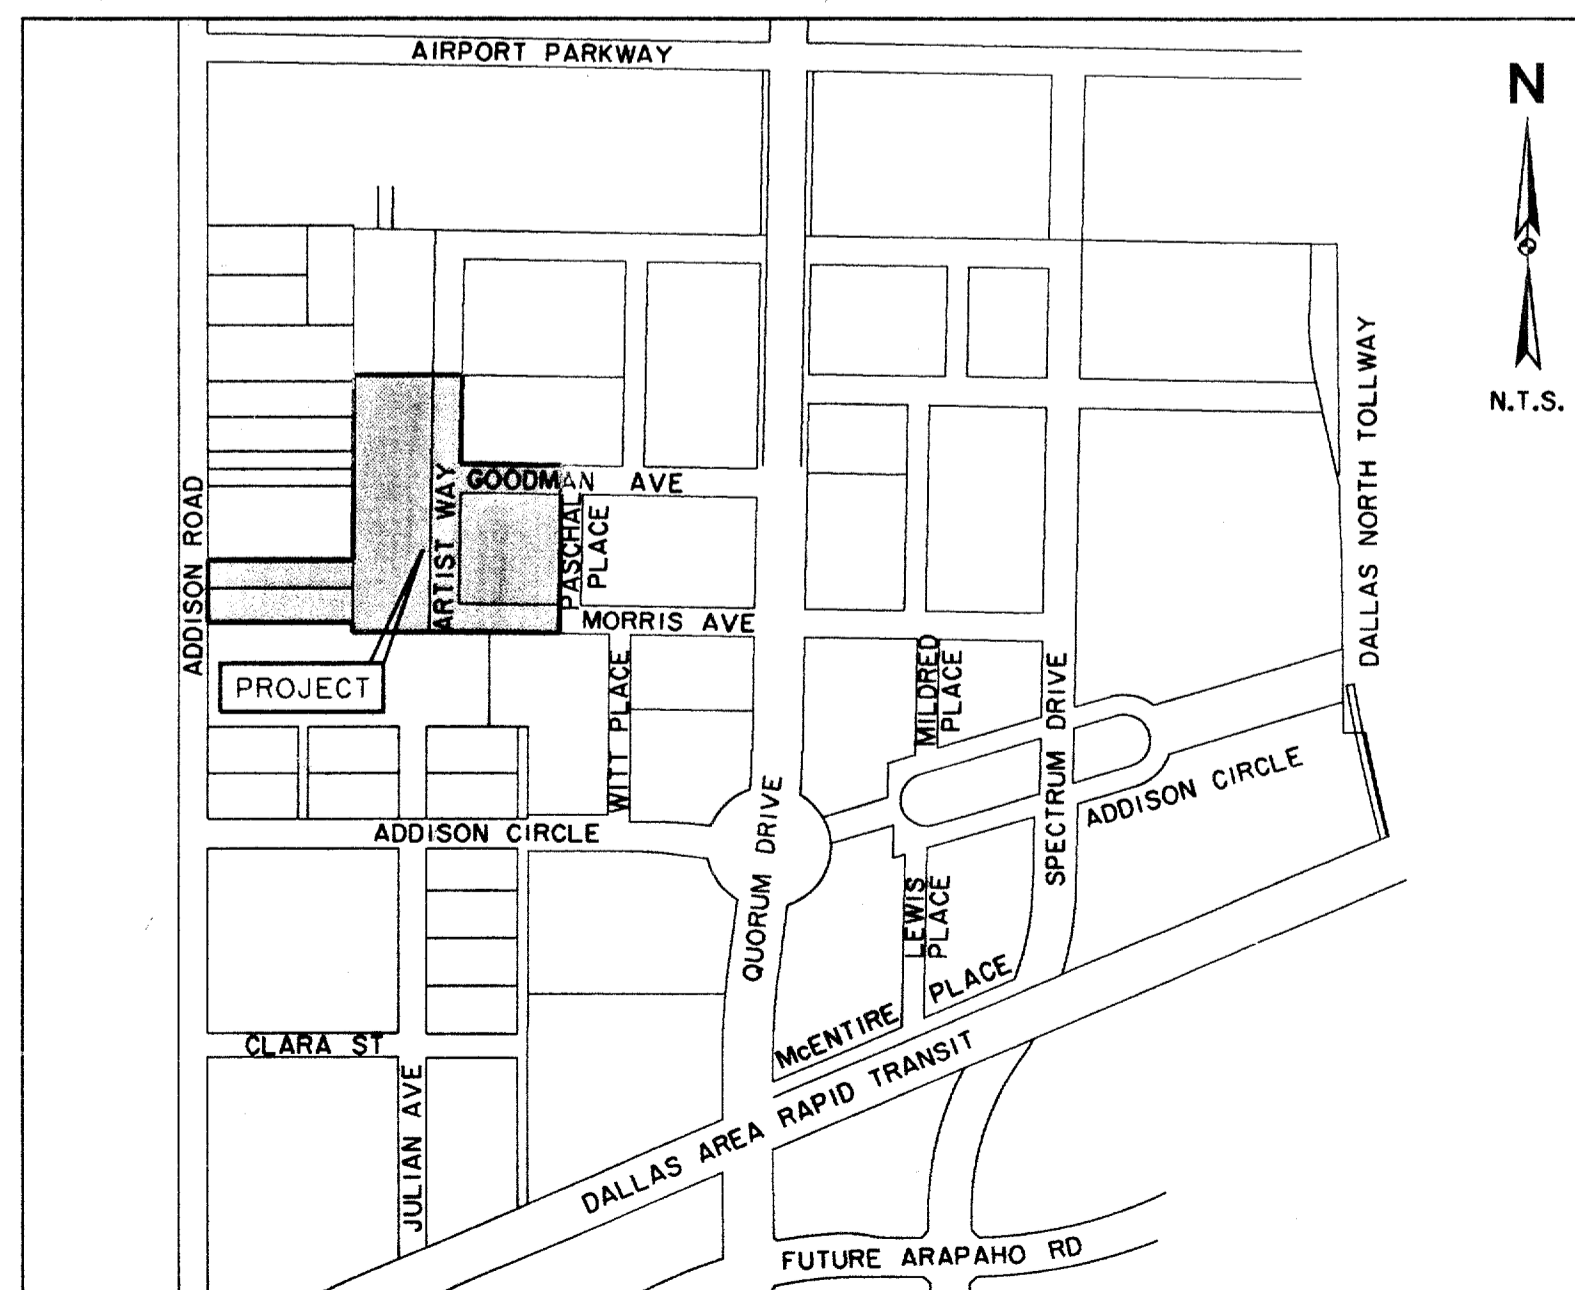

LOCATION MAP

RECORD DRAWINGS 11/17/00

THIS SET OF DRAWINGS HAS BEEN MODIFIED FROM THE ORIGINAL DESIGN DRAWINGS TO REFLECT THE FIELD CHANGES THAT OCCURRED DURING CONSTRUCTION WHICH WERE DOCUMENTED AND FINISHED TO THE ENGINEER BY THE CONTRACTOR. BASED ON THIS INFORMATION AND THE ENGINEER'S OBSERVATION OF CERTAIN CONSTRUCTION ACTIVITIES, TO THE BEST OF THE ENGINEER'S KNOWLEDGE AND BELIEF, THE PROJECT IS CONSTRUCTED IN CONFORMANCE WITH THE PLANS AND SPECIFICATIONS AND WILL FUNCTION AS DESIGNED.

OWNER:


TOWN OF ADDISON
DEPARTMENT OF PUBLIC WORKS
16801 WESTGROVE
P.O. BOX 9010
ADDISON, TEXAS 75001
(972) 450-2871 FAX (972) 450-2837

ENGINEER & LANDSCAPE ARCHITECT:

HUITT-ZOLLARS, INC.
3131 MCKINNEY AVE., SUITE 600
DALLAS, TEXAS 75204
(214) 871-3311 FAX (214) 871-0757
DAVID E. MEYERS, P.E.
TX. REG. NO. 81512
KAREN W. KOERTH, L.A.
TX. REG. NO. 1594

RECORD
DRAWING

THE SEAL APPEARING ON THIS DOCUMENT WAS AUTHORIZED BY DAVID E. MEYERS, P.E. 81512

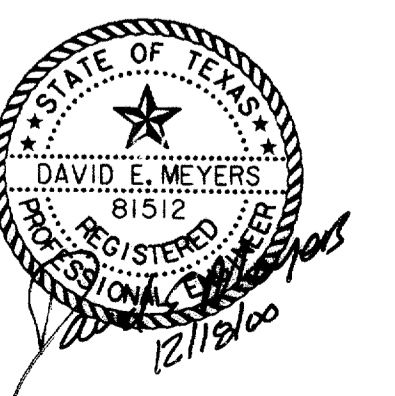

ISSUED FOR CONSTRUCTION 6/23/99