

**Taloy Associates**

Landscape Architecture  
Planning  
Urban Design

1925 San Jacinto, Suite 400  
Dallas, Texas 75201  
Tel. 214-871-7900  
Fax. 214-871-7985

**ZINSER / GROSSMAN STRUCTURAL LLC**


Structural Engineering  
1701 N. Market St. Suite #310  
Dallas, Texas 75202  
Tel. 469-227-3983  
Fax. 646-227-3981

**MEP SYSTEMS DESIGN AND ENGINEERING, INC.**

918 Dragon Street  
Dallas, Texas 75207  
Tel. 214-815-0829  
Fax. 214-815-0818

**JAMES POLE LANDSCAPE IRRIGATION SPECIALIST**

Landscape Irrigation Consulting, Design, Specification  
2615 Woodhaven  
Denton, Texas 76201  
Tel. 840-243-2384

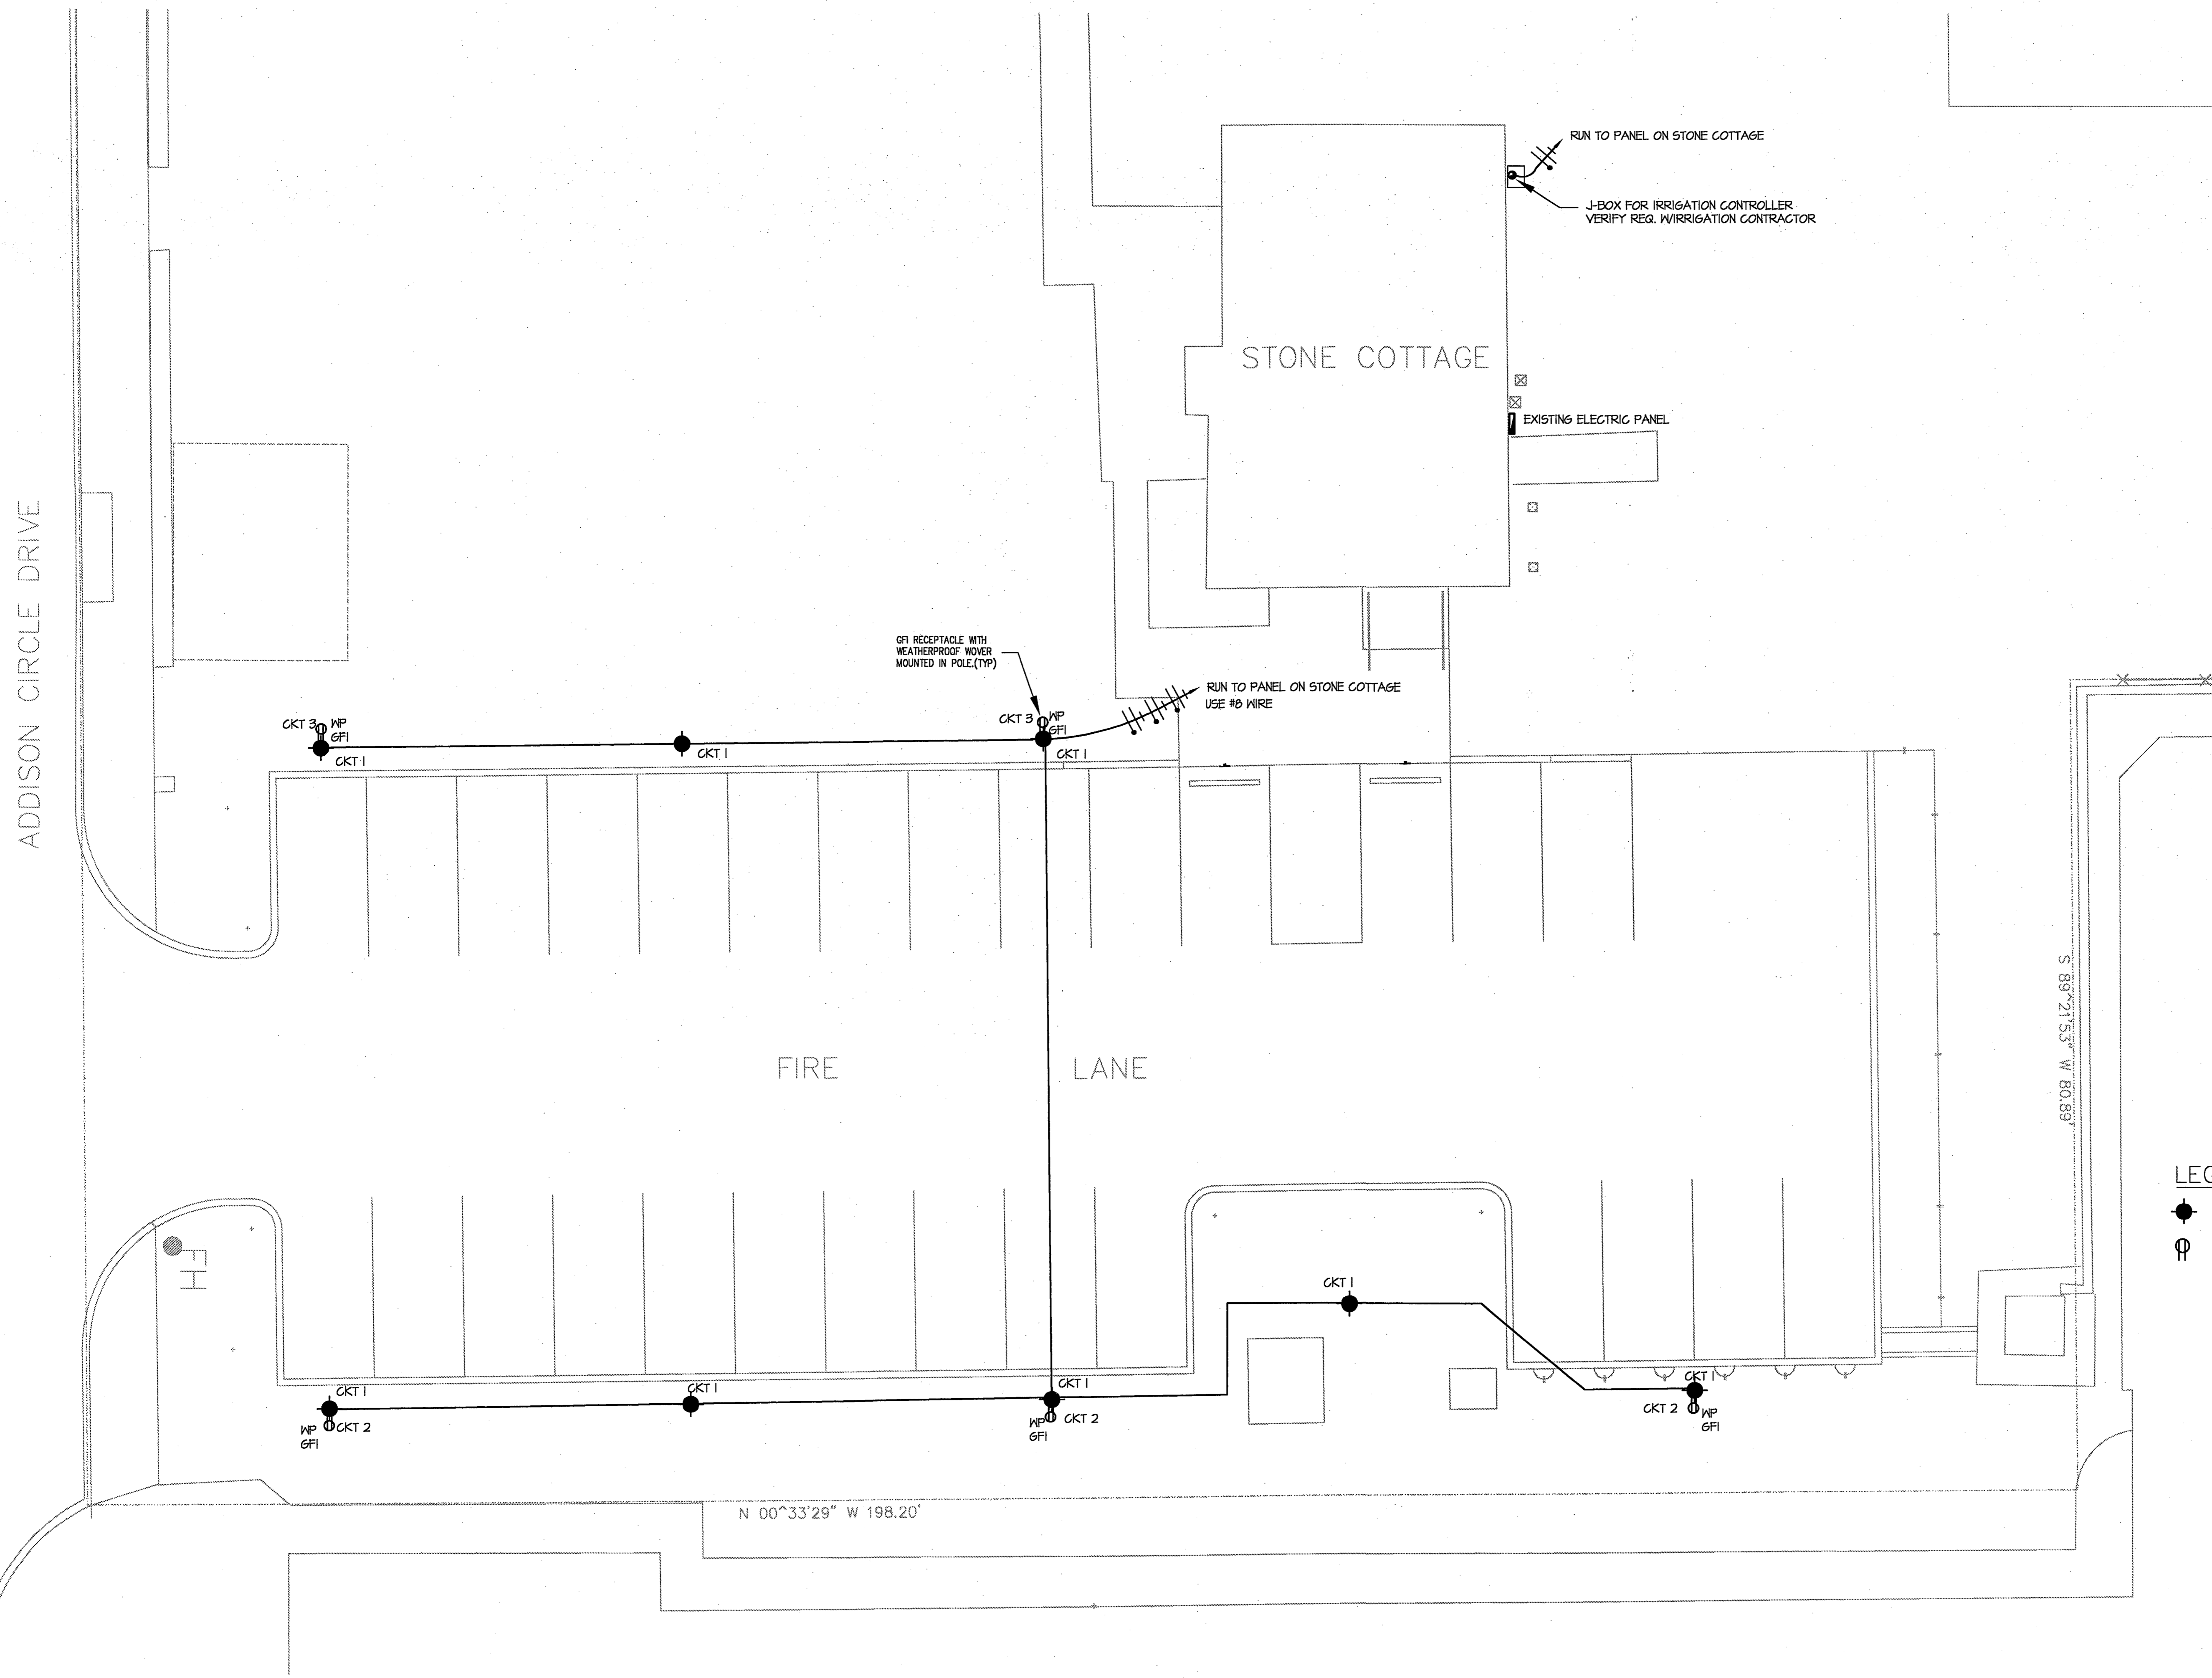

**LEGEND**  
 ● LIGHT FIXTURE - RE: #7, L5.01  
 ⊕ RECEPTACLE

Project No. 4030  
 Drawn By: MP  
 Checked By: MP  
 Date: SEPTEMBER 22, 2004

Revisions:


Sheet Title:

E1.01

Sheet No.:

POWER PLAN

