


JOB: 811
DRAWN: FEC
DATE: 8/12/98
REVISIONS:

SHEET NO.
M2.2
OF:

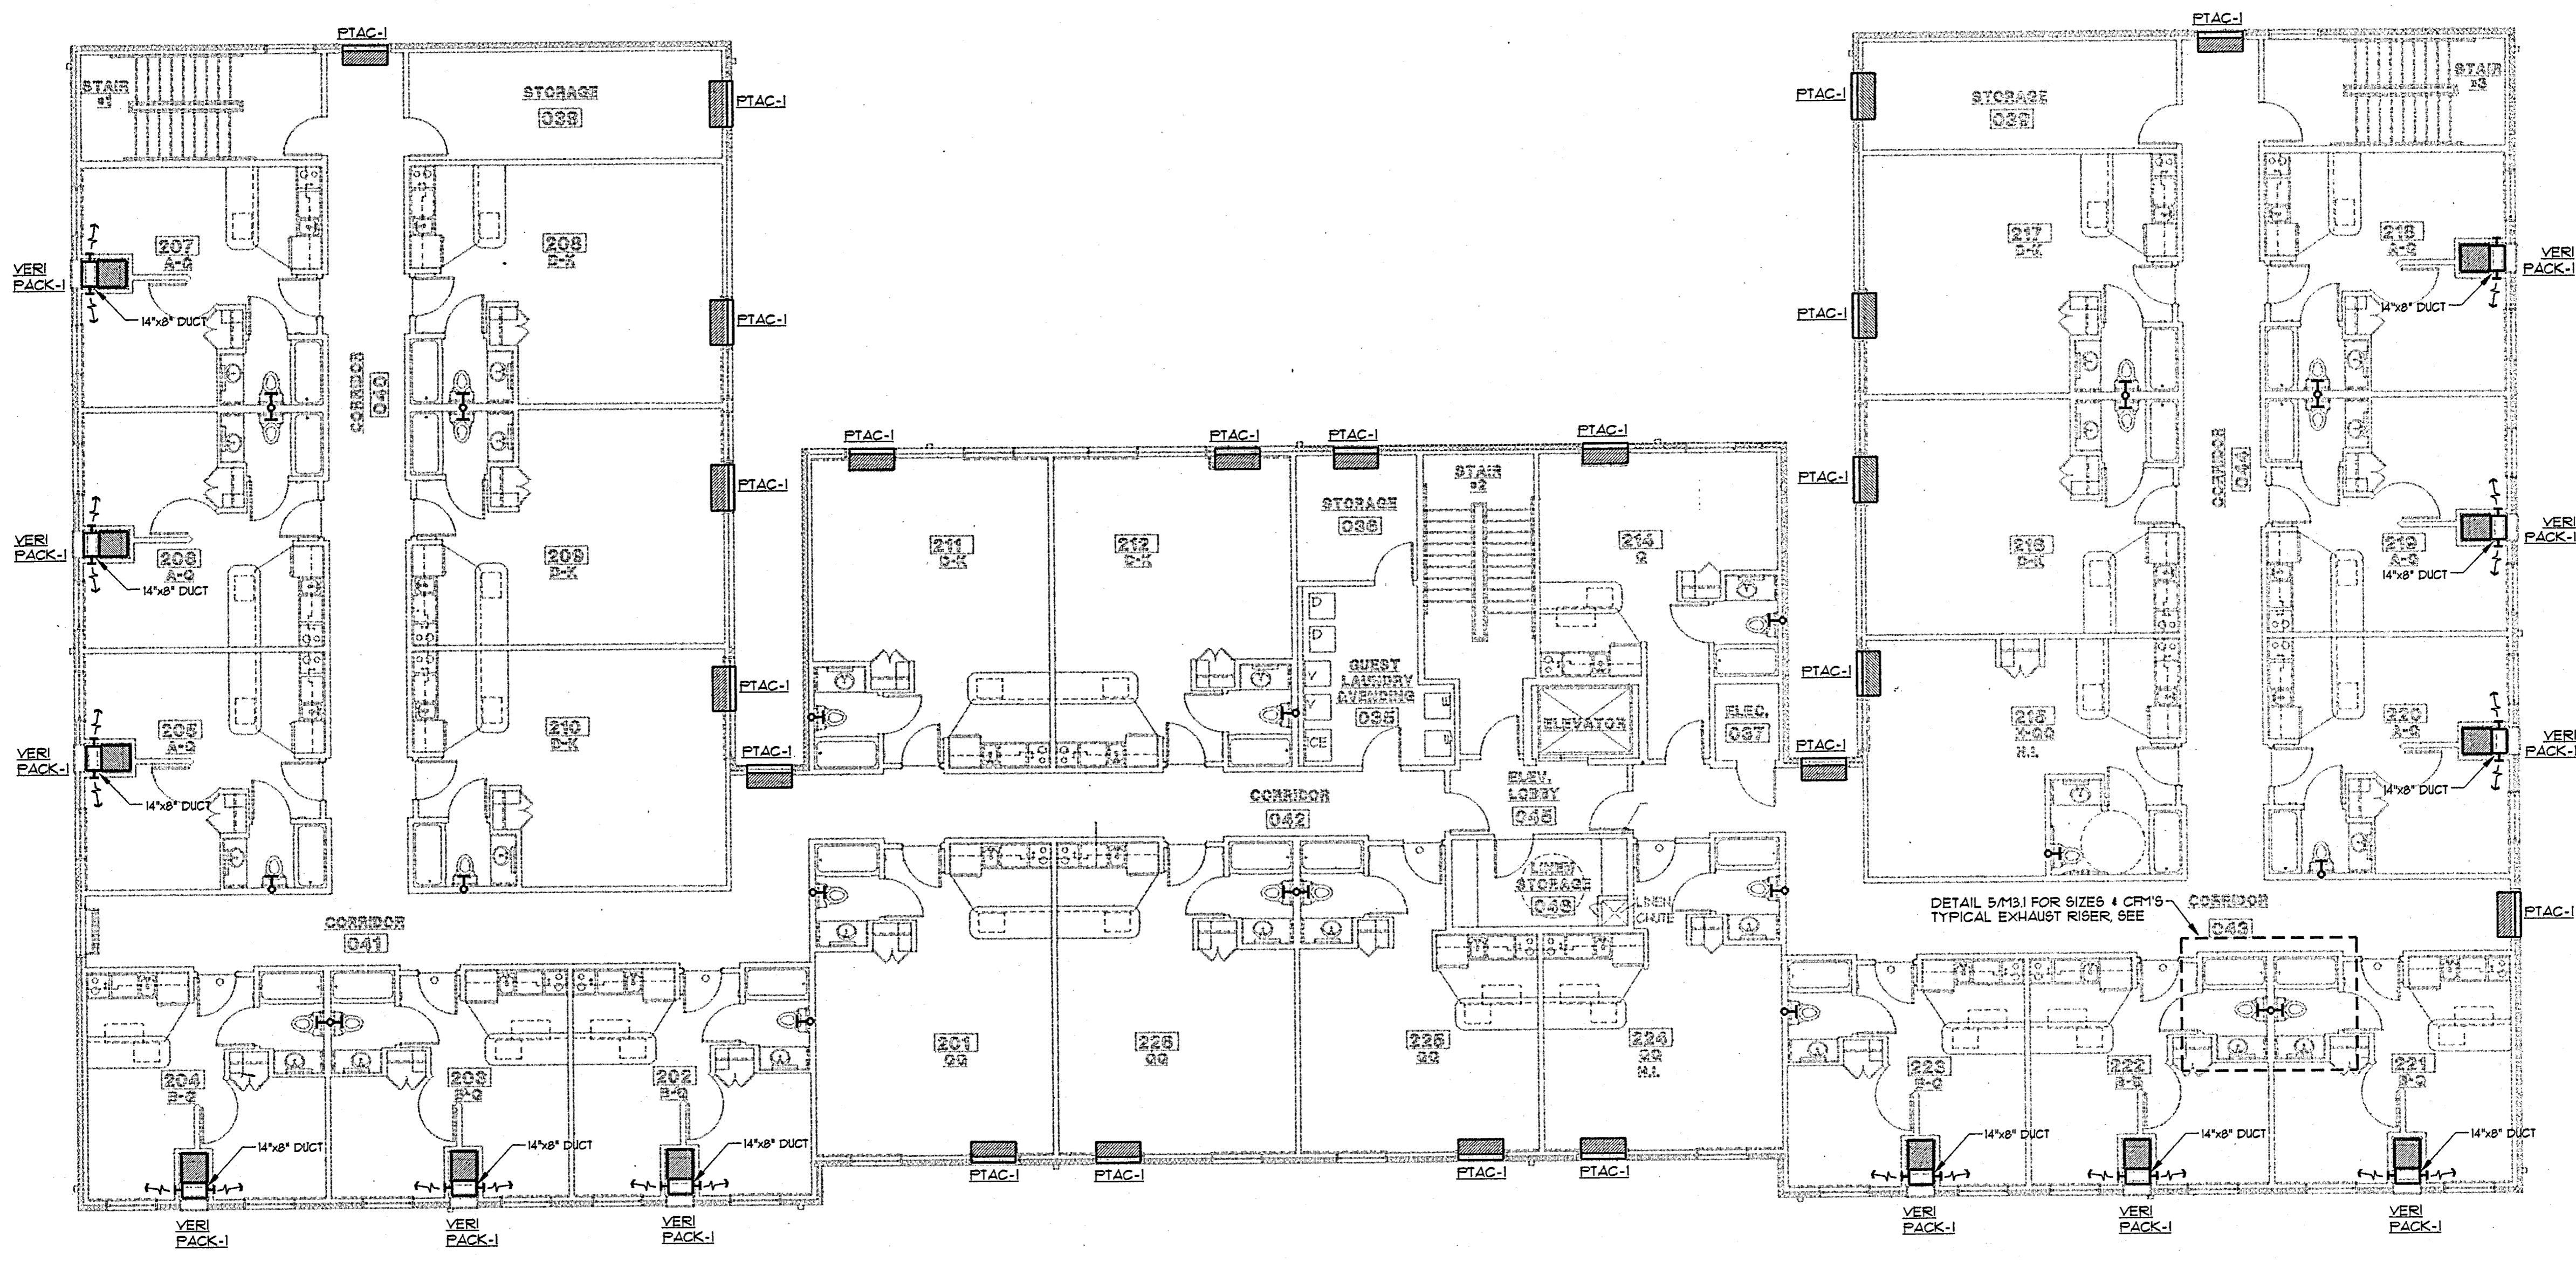

1 SECOND FLOOR PLAN - HVAC
SCALE: 1/8" = 1'-0"

