


| REF. | Identification |
|-------|---|
| 3.06 | Concrete Transformer Pad 6'-2" x 6'-2" |
| 15.14 | Gas Meter |

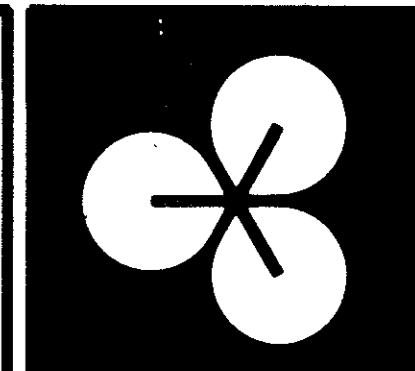


EDI ARCHITECTS, INC.
 ARCHITECTURE PLANNING ENGINEERING INTERIOR DESIGN
 AMERICAN BANK TOWER
 SUITE 300
 AUSTIN, TEXAS 78701
 512 / 485-8308


Old Town 7-11/Strip Center
 Addison, Texas
 Ben Pinnell

| | |
|-------|-----------|
| DATE: | 14 MAR 85 |
| | 22 MAR 85 |
| | 24 APR 85 |
| | 13 MAY 85 |


SHEET NO:
A1.7
 8 OF 89 SHEETS
 JOB NO: 8431.00

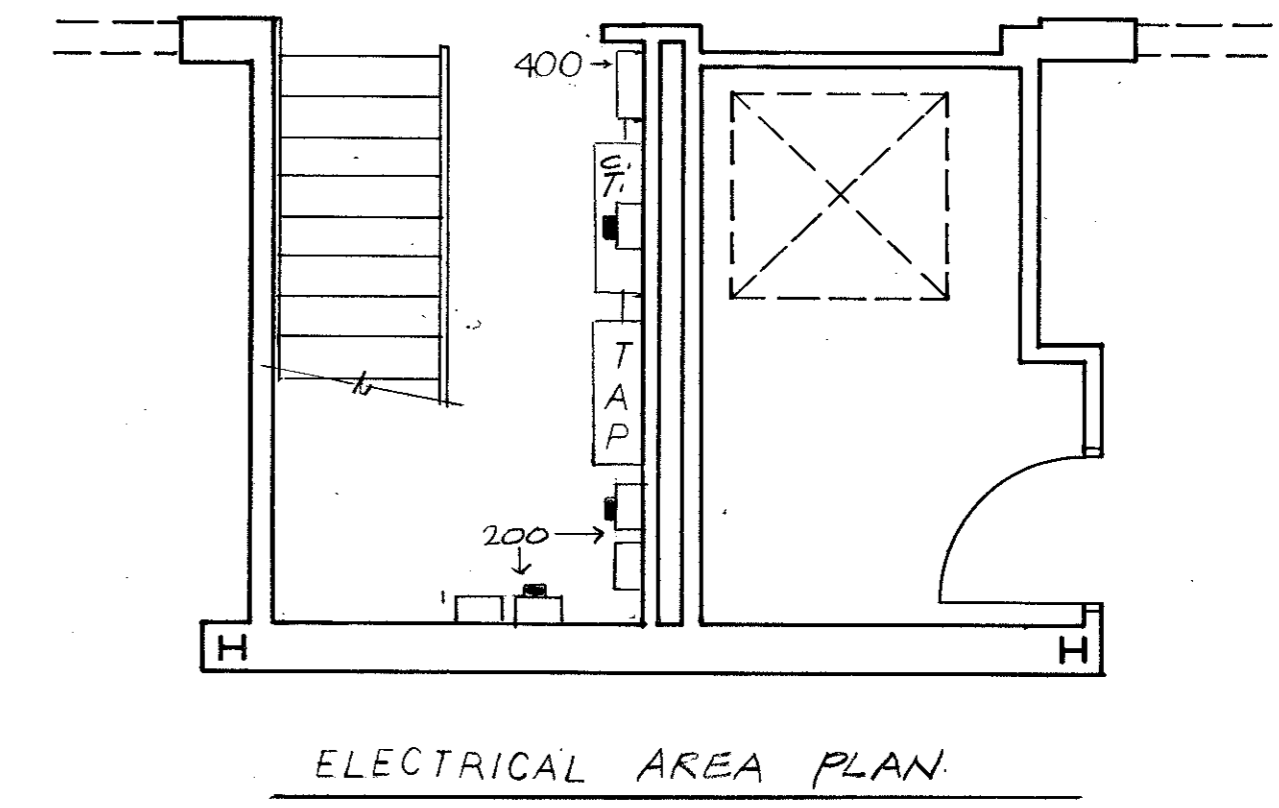

ELECTRICAL AREA PLAN

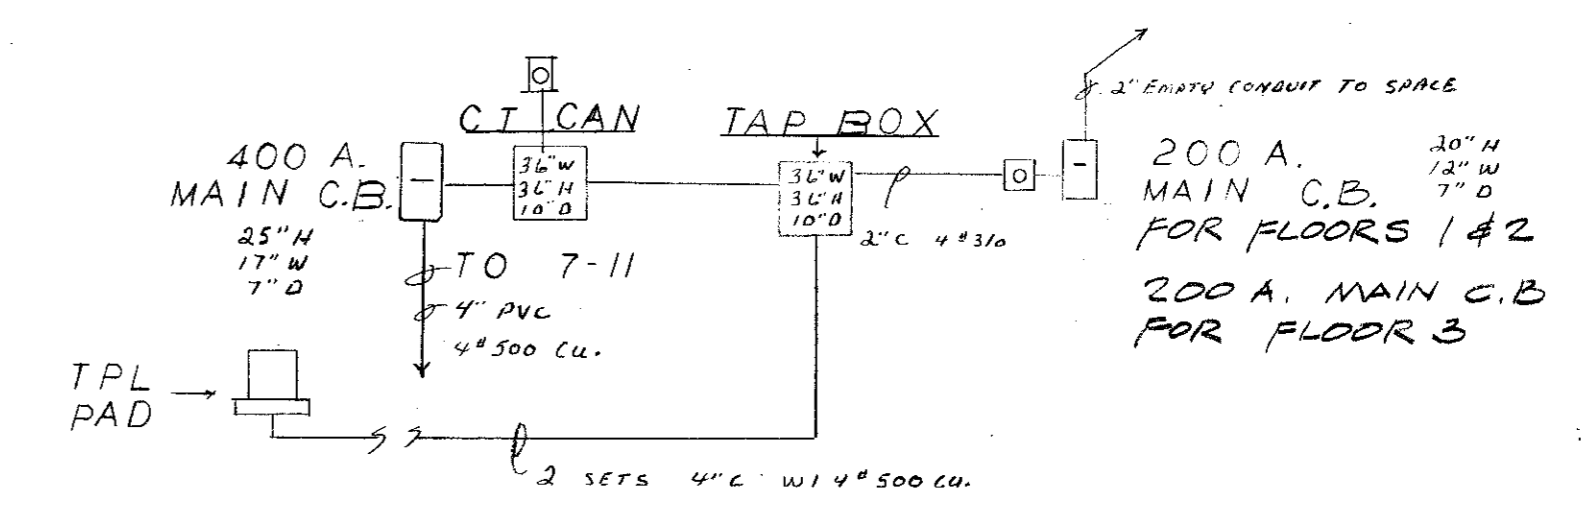


ONE-LINE DIAGRAM

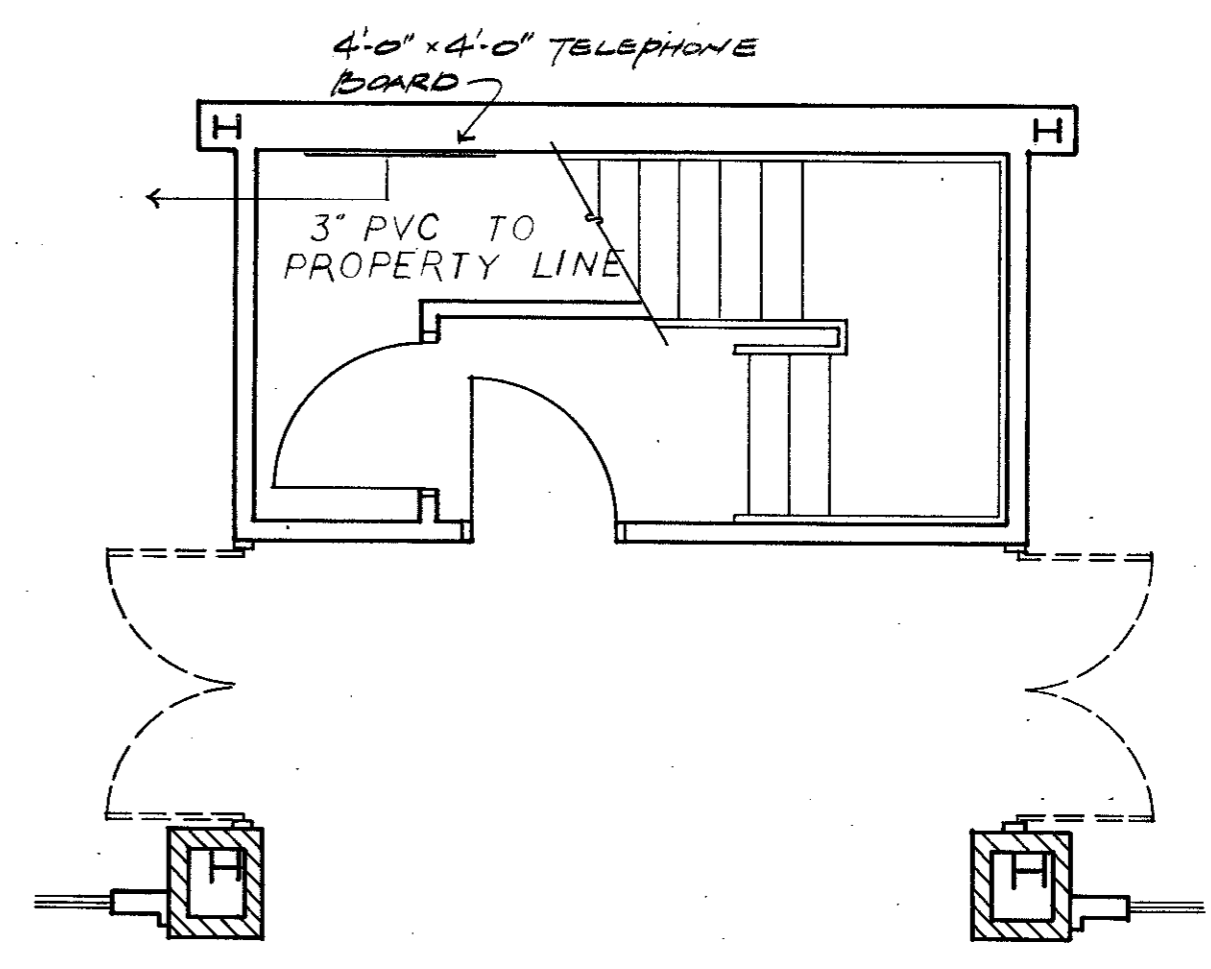


02 PARTIAL PLAN
 1/4" = 1'-0"

TELEPHONE EQUIPMENT ROOM

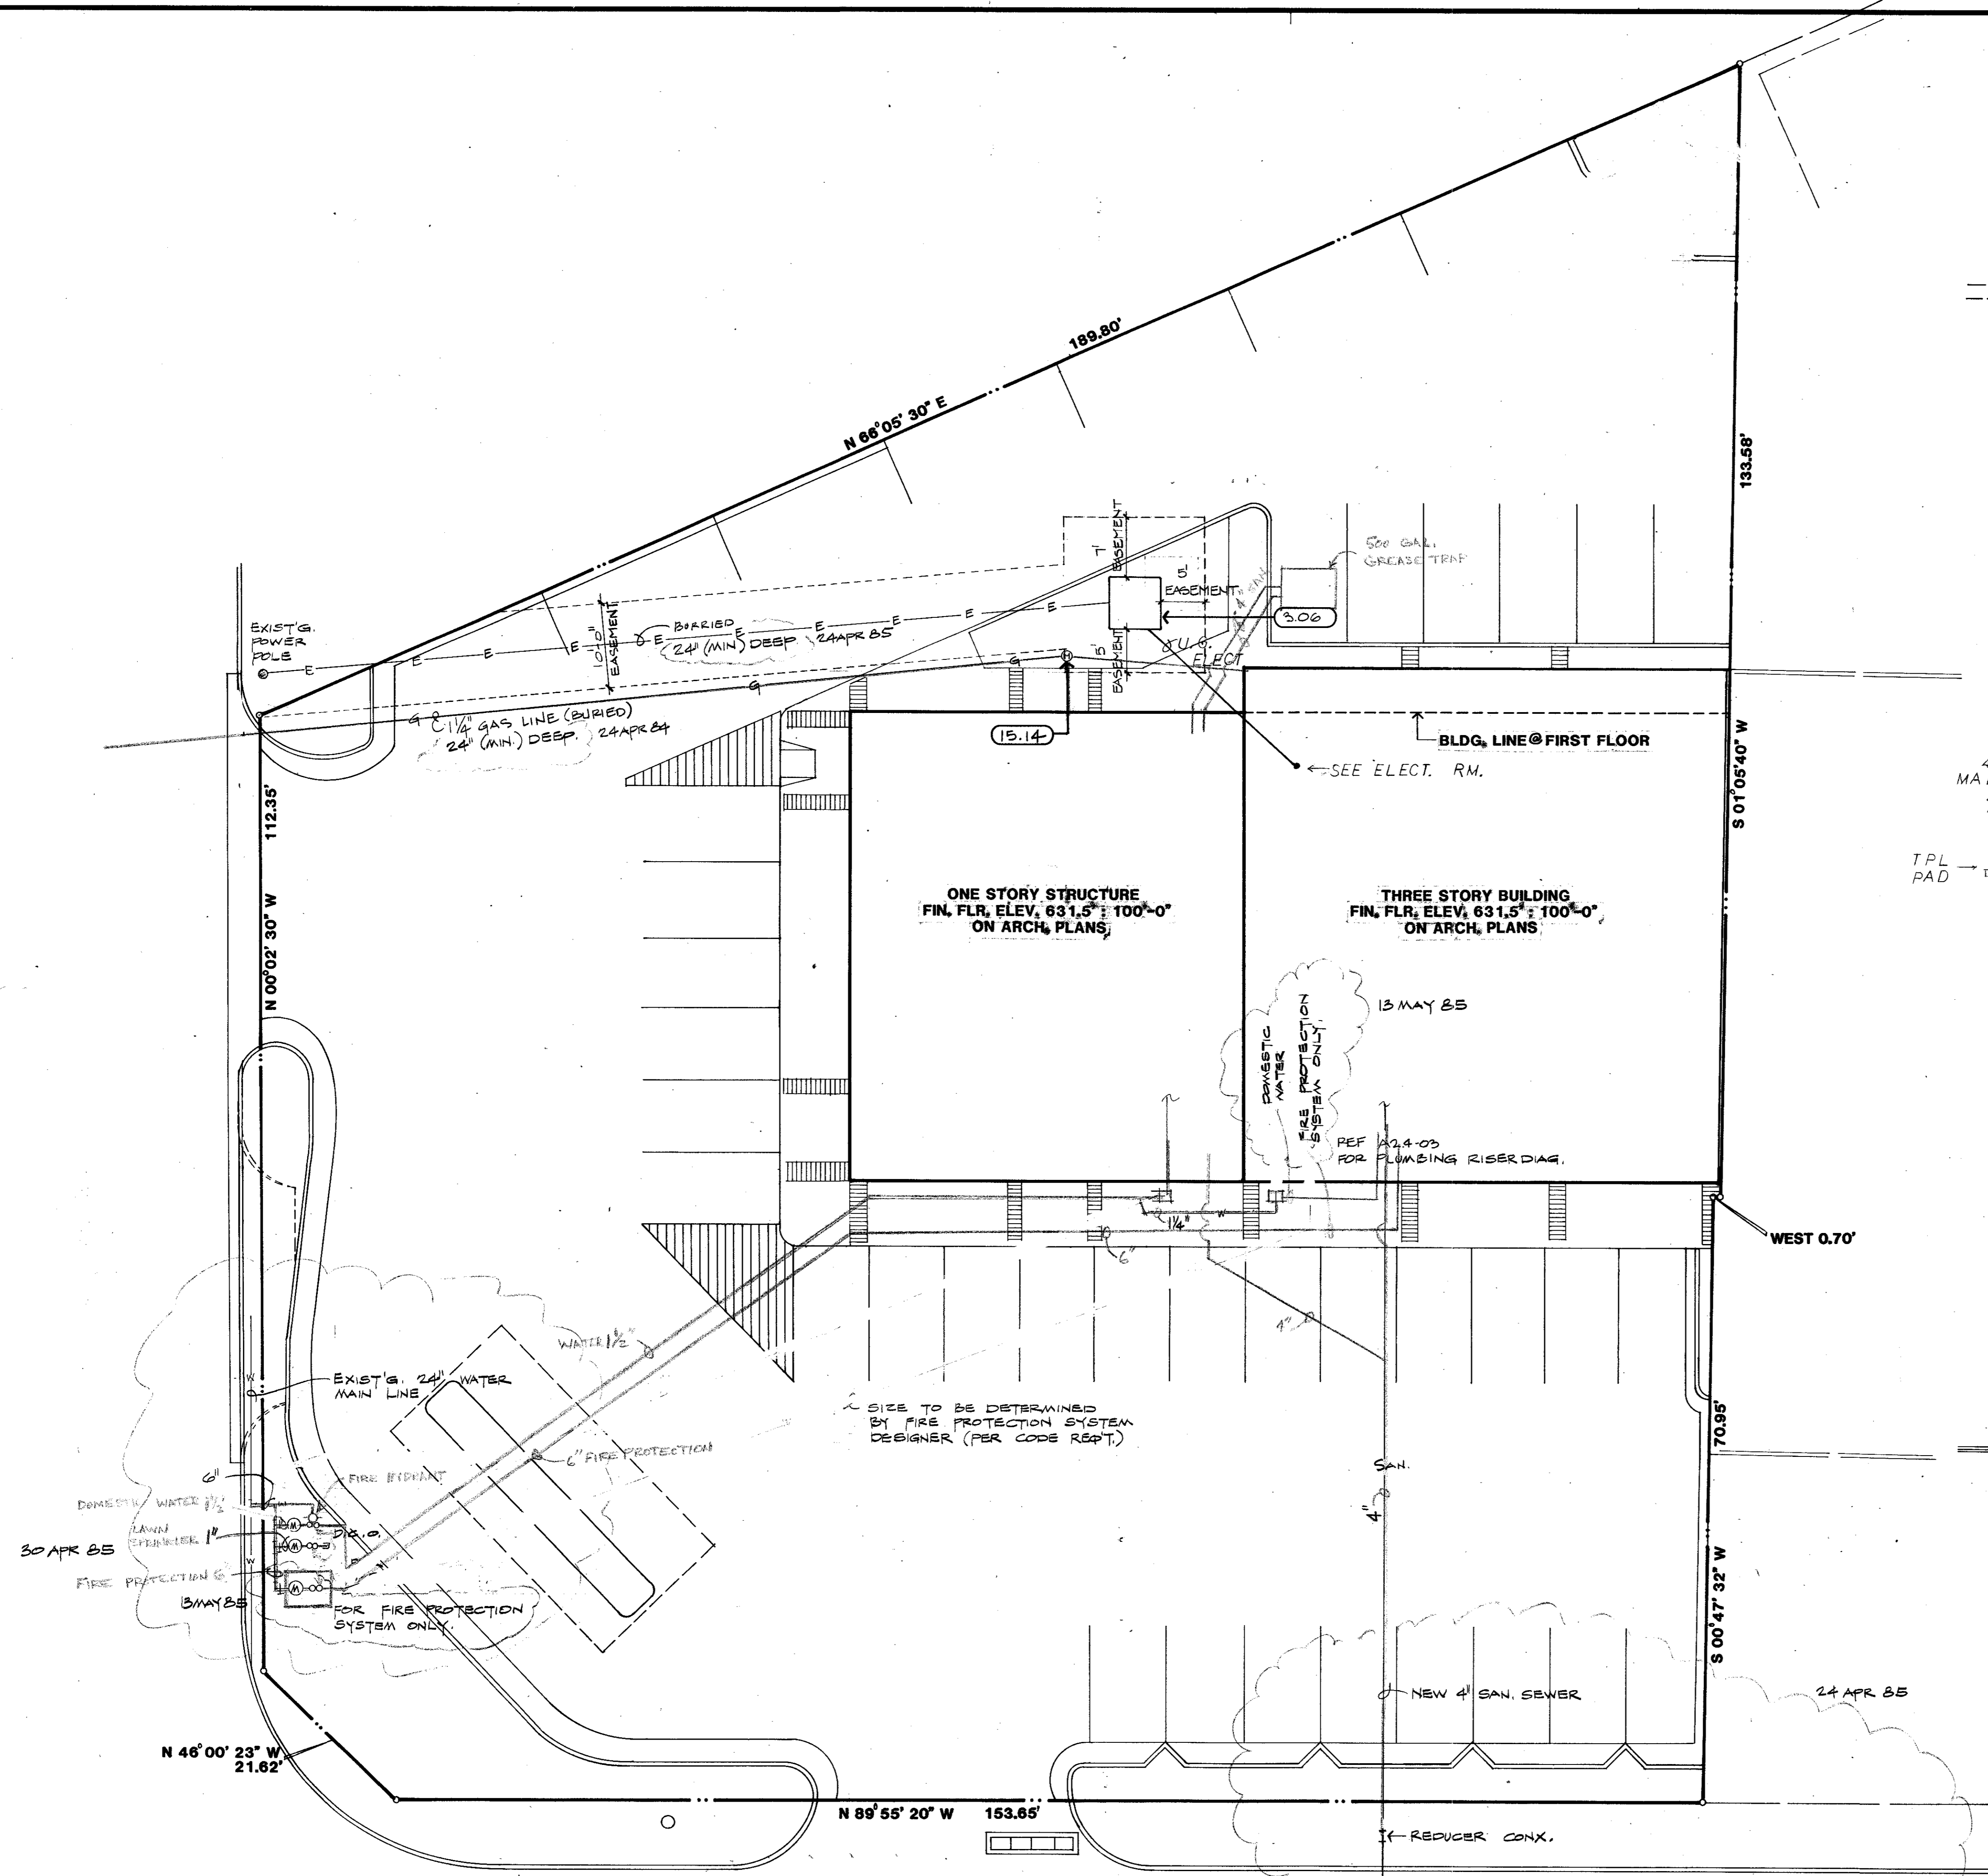

01 UTILITIES SITE PLAN
 1/4" = 10'-0"

AS BUILT
 2-19-86

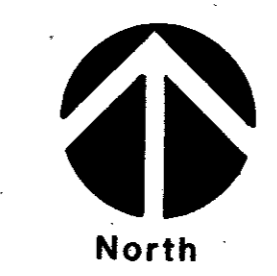

JOB NO SHEET
 JOB NO SHEET
 JOB NO SHEET
 JOB NO SHEET