



Strip Lt. W/2-F96 T12 R5 CW Lamp
Typ For 24 Fixt's. Mfg. By Rangaire Corp.
Cat. No. S-296, Ea. W/O Ballast - Mnt On Bottom Of 30° Laterals, 25"± Up - See Elev. To Left

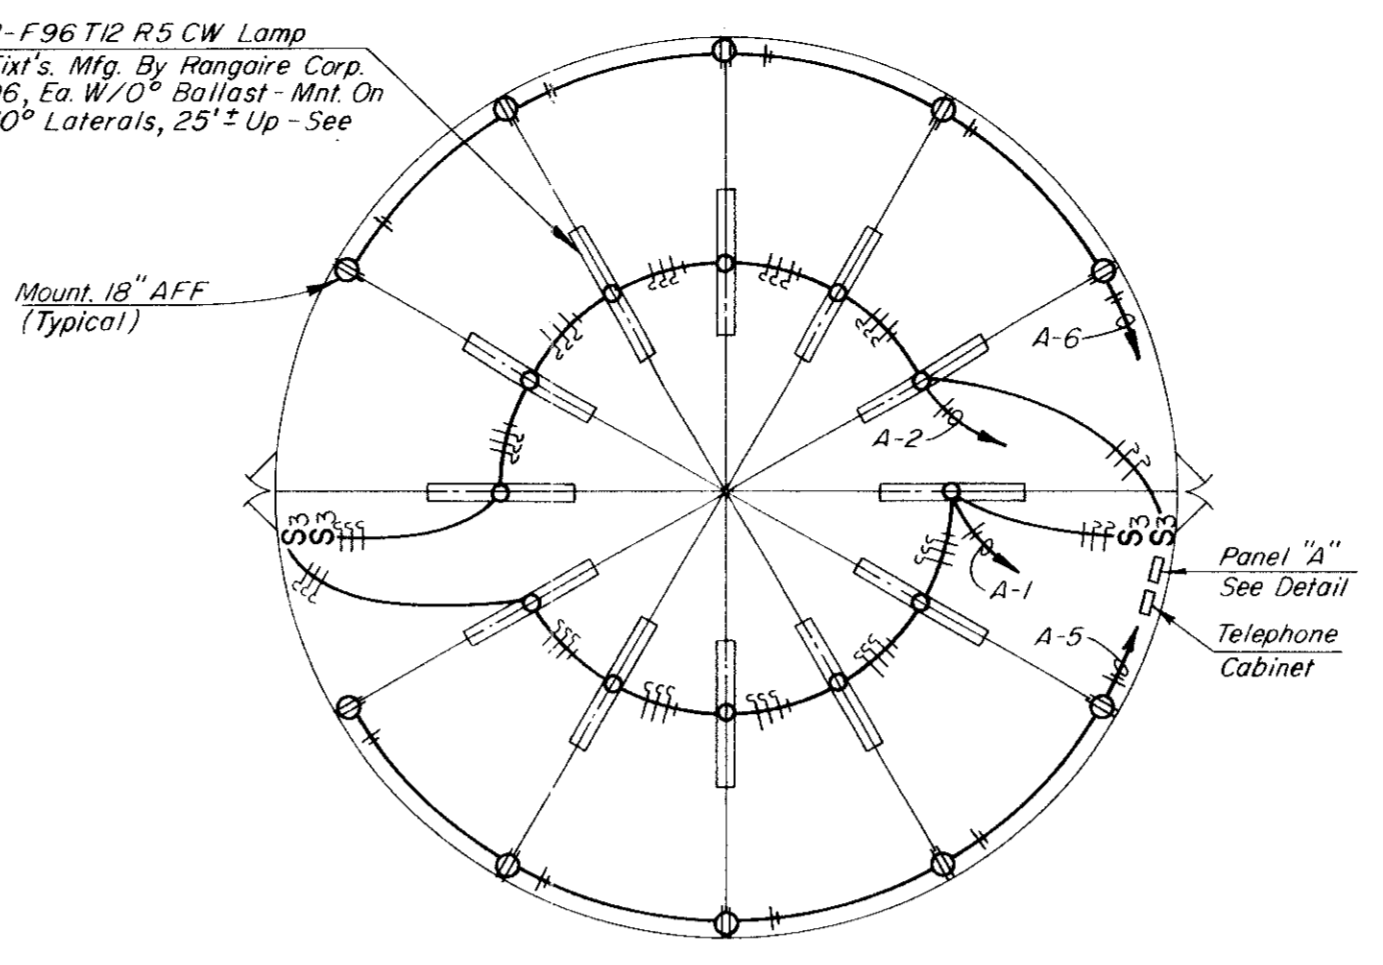


SECTION "A-A"
No Scale

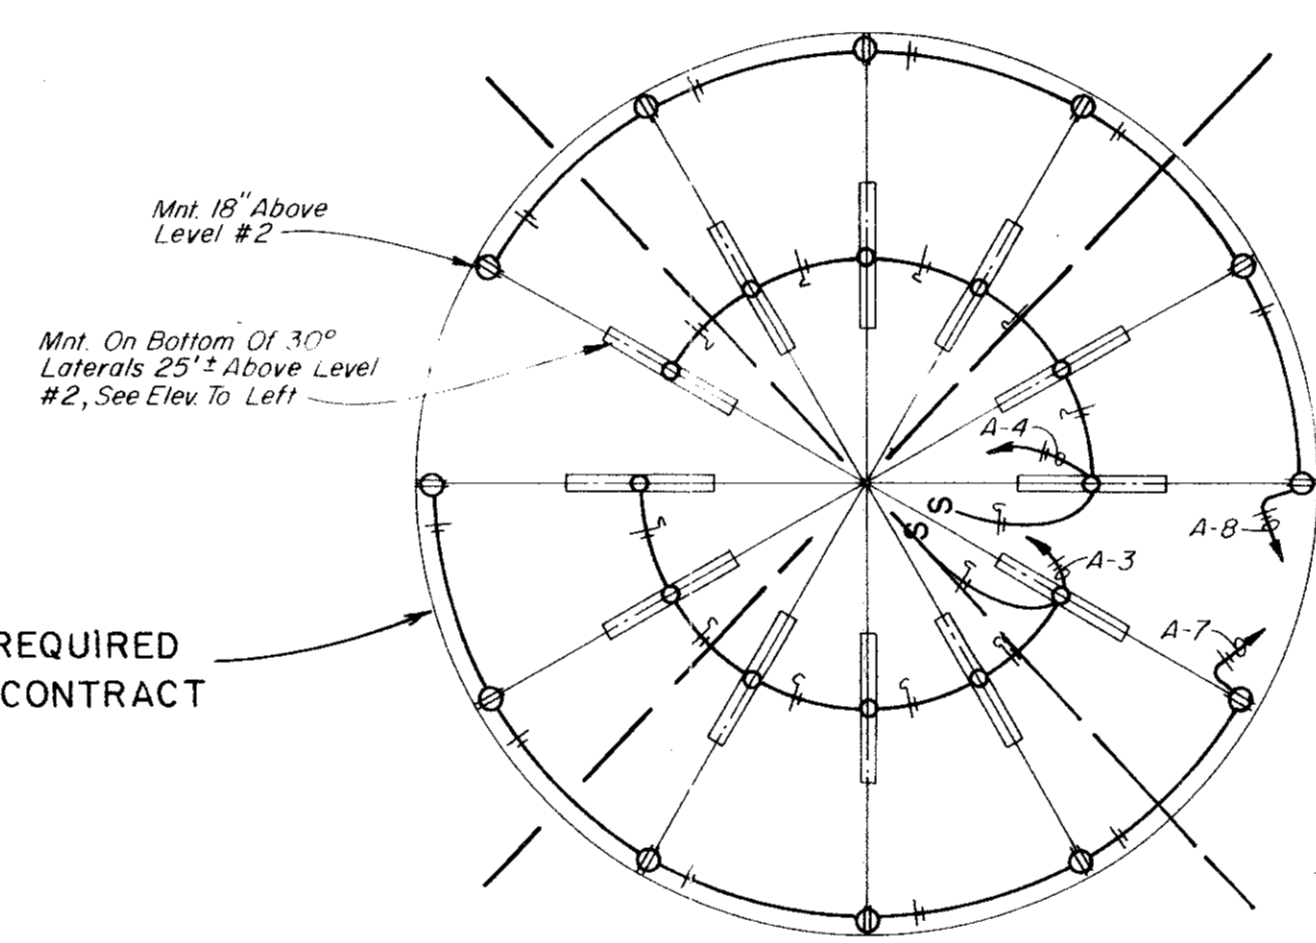


SECTION "B-B"
No Scale



NOT REQUIRED THIS CONTRACT

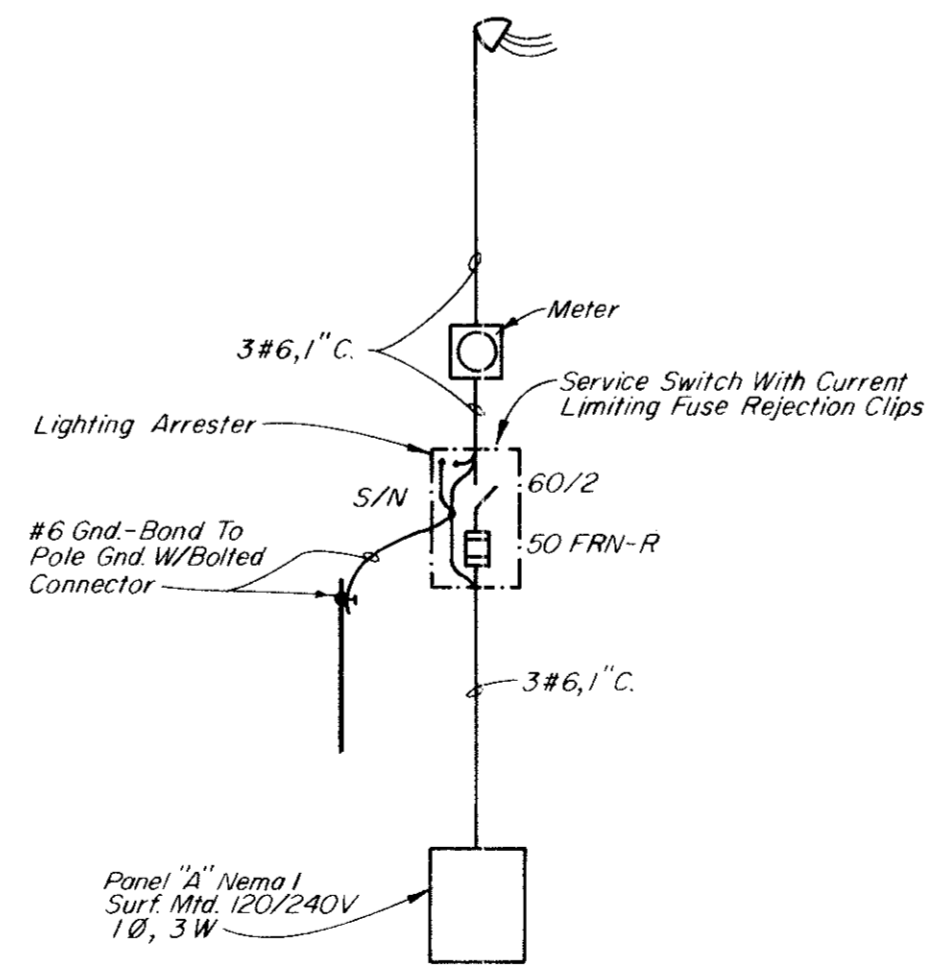

POWER RISER DIAGRAM
No Scale

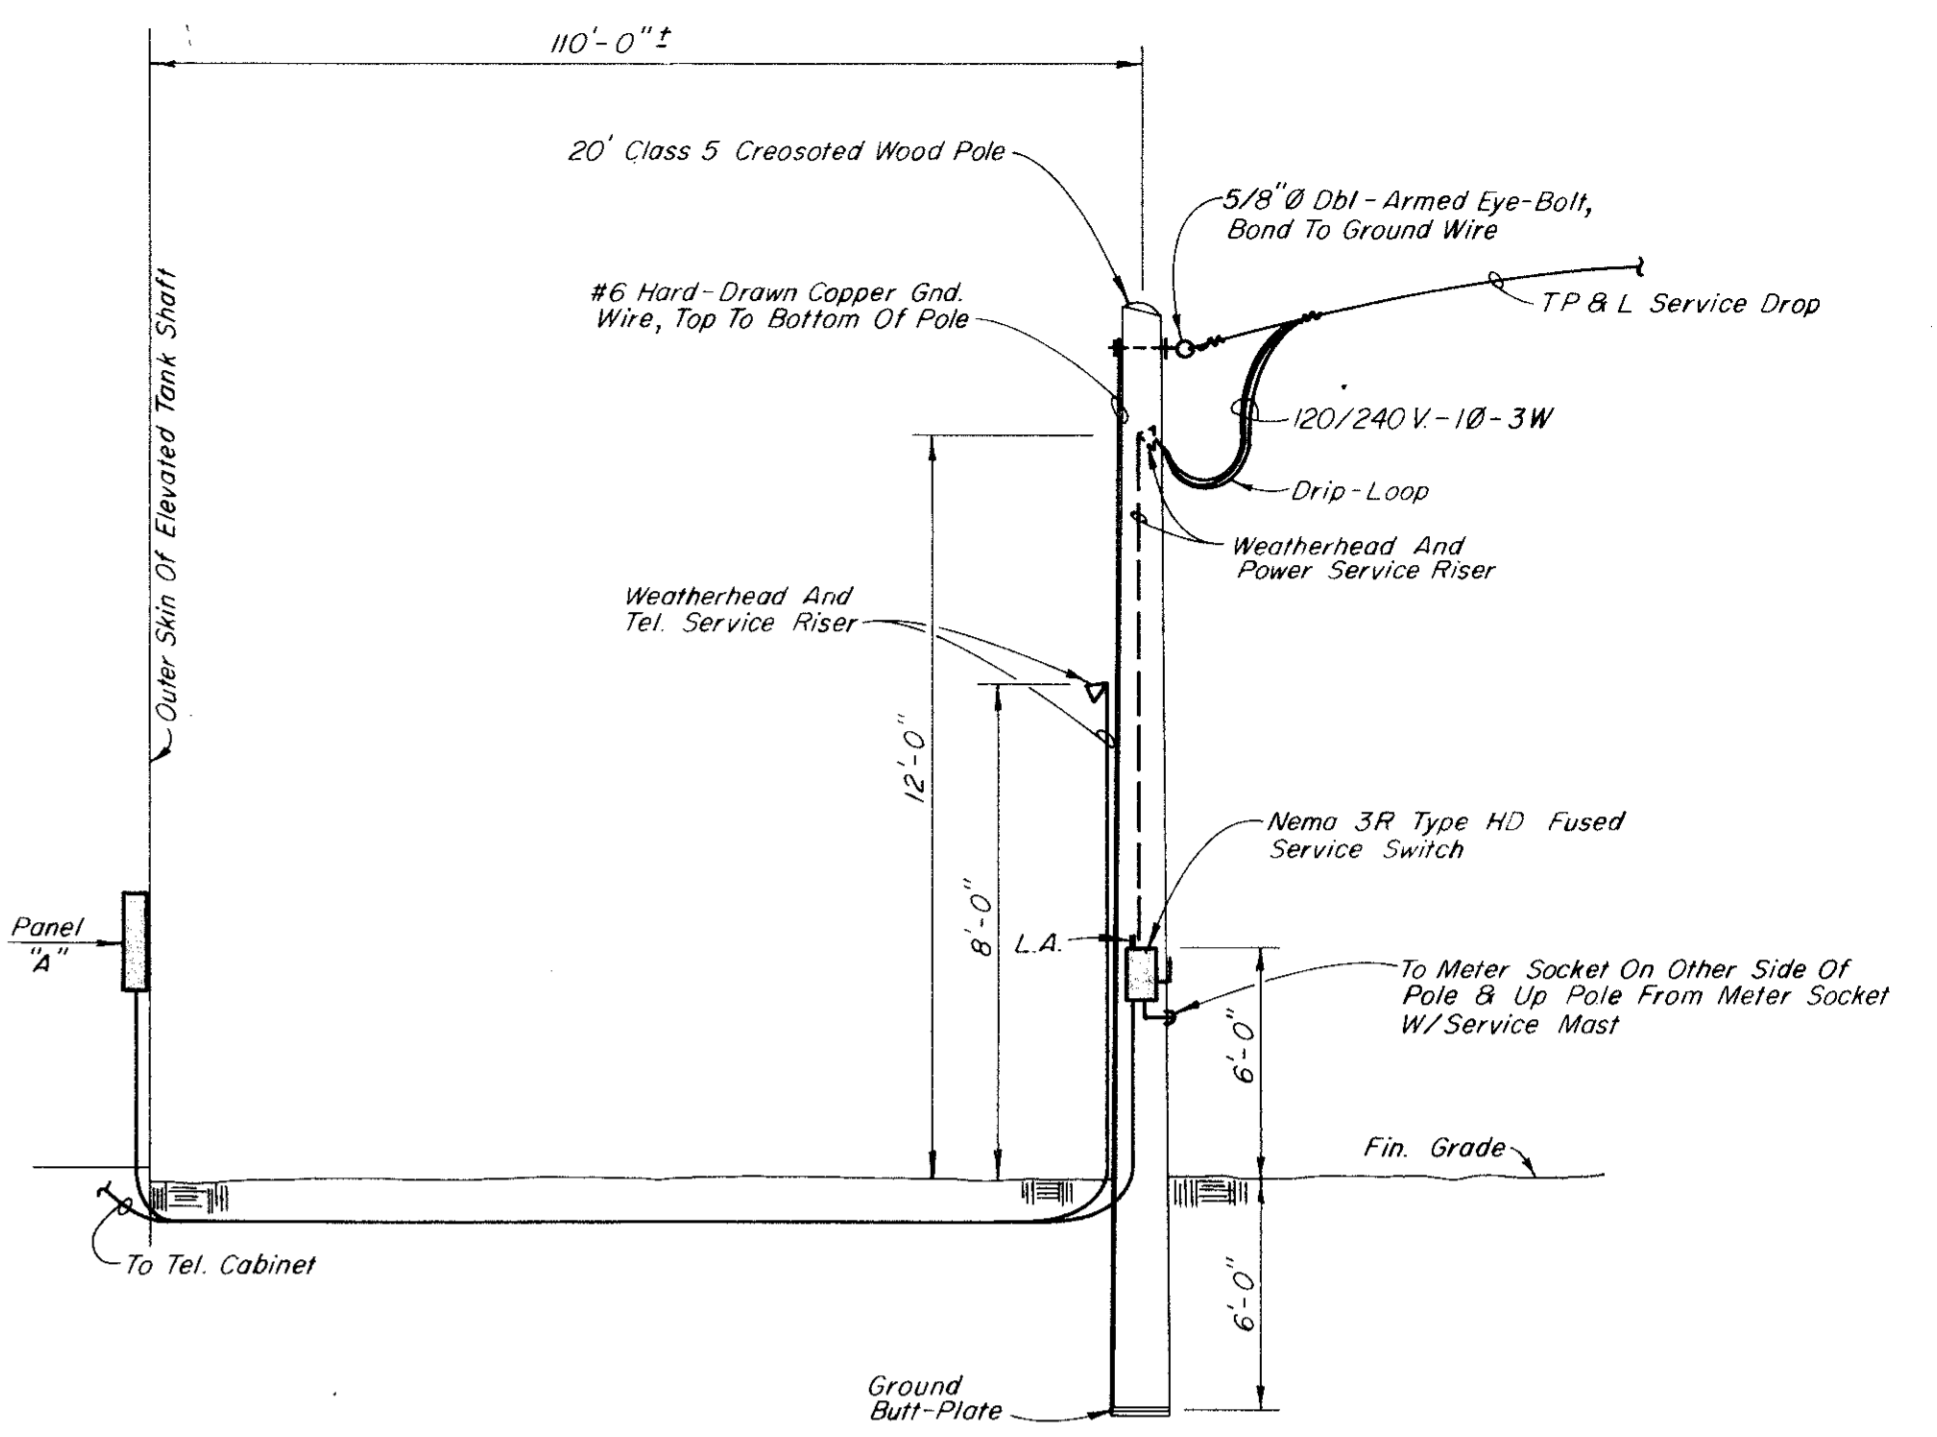


SERVICE ENTRANCE DETAIL
No Scale

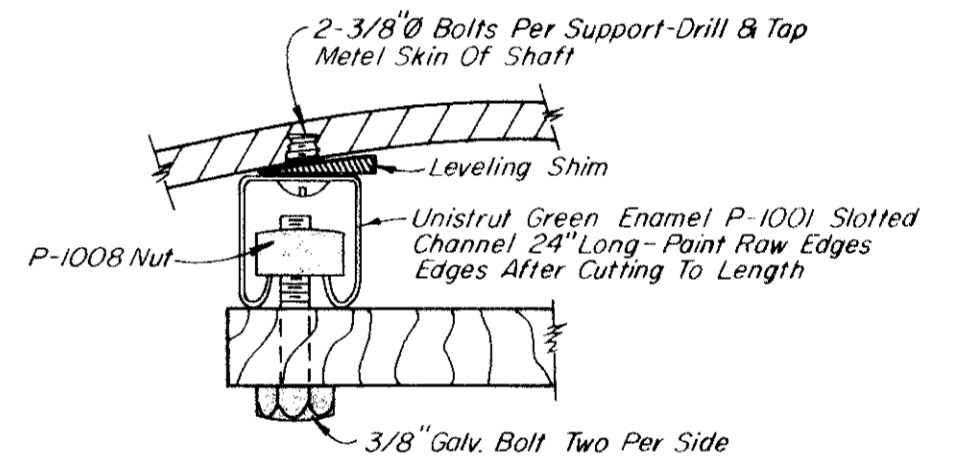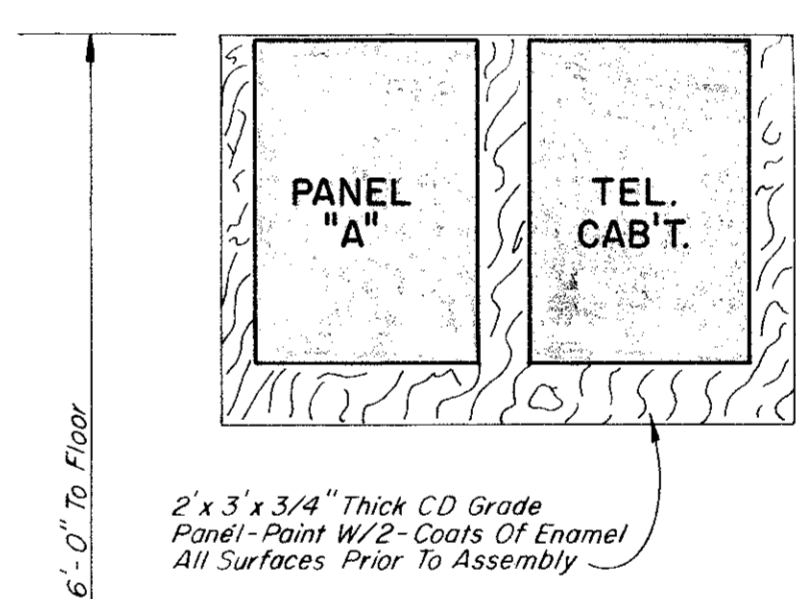

PANEL & CABINET MOUNTING DETAILS
No Scale

- LEGEND**
- Fluorescent Lt. Fixt.
 - ⊕ Duplex Receptacle - 15 A, 125V.
 - S Switch, SPST
 - S₃ Switch, 3-Way
 - ⊕ Junction Box
 - Circuit Feeder, Neut., Hot & Switch Leg
 - Home Run To Panel

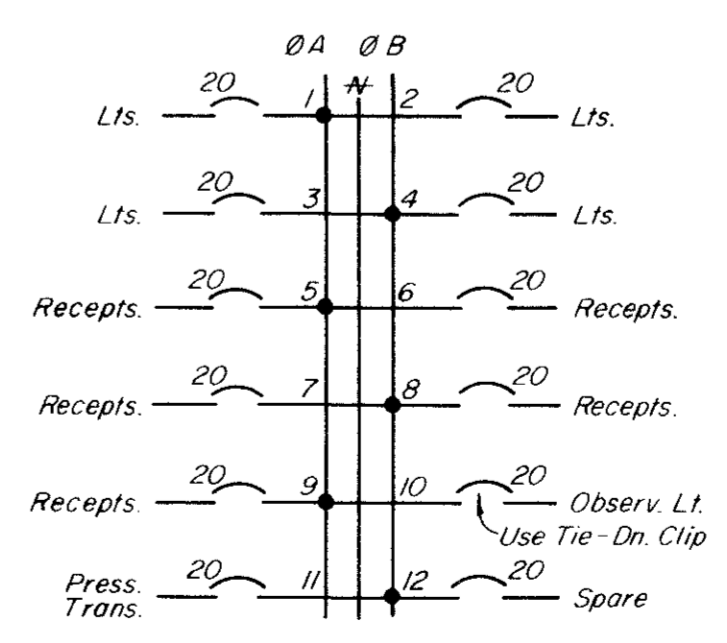

PANEL "A" - ONE LINE
No Scale



CITY OF ADDISON
DALLAS COUNTY, TEXAS
WATER IMPROVEMENTS
ELECTRICAL PLAN & DETAILS

GINN & STACY, INC.
CONSULTING ENGINEERS DALLAS, TEXAS
Designed By: C.R.M. Scale: None
Drawn By: W.G.A. Date: 4-26-77 Sheet 4 of 4