


**APPROVED FOR CONSTRUCTION**  
Town of Addison  
Public Works Department  
APPROVED BY: *LAY GARNETT*  
DATE: 10-23-08

All responsibility for the adequacy of these plans remains with the Engineer who prepared them. In approving these plans, the Town of Addison makes no representation of adequacy of the work of the Design Engineer.

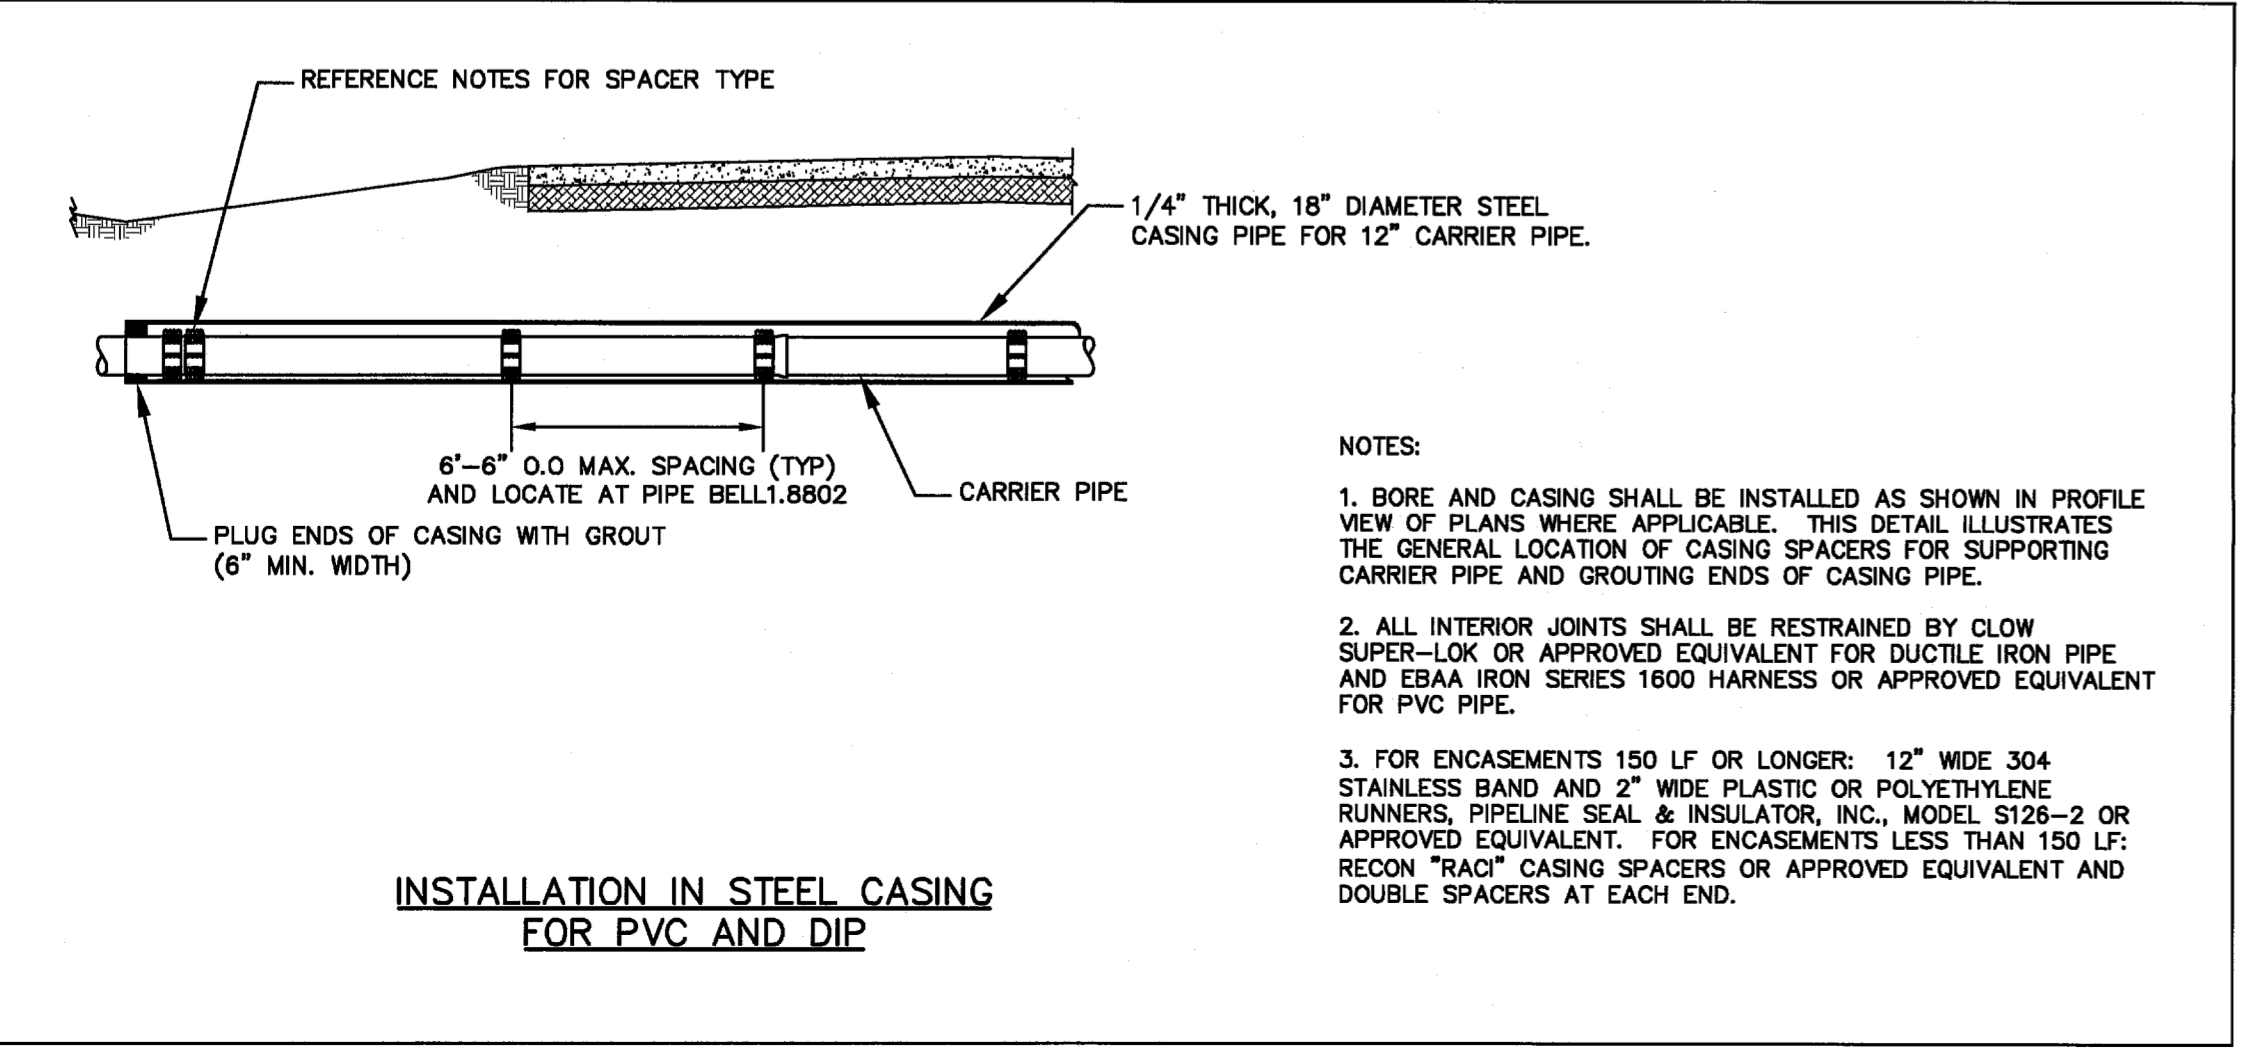

- NOTES:**
1. BORE AND CASING SHALL BE INSTALLED AS SHOWN IN PROFILE VIEW OF PLANS WHERE APPLICABLE. THIS DETAIL ILLUSTRATES THE GENERAL LOCATION OF CASING SPACERS FOR SUPPORTING CARRIER PIPE AND GROUTING ENDS OF CASING PIPE.
  2. ALL INTERIOR JOINTS SHALL BE RESTRAINED BY CLOW SUPER-LOK OR APPROVED EQUIVALENT FOR DUCTILE IRON PIPE AND EBAA IRON SERIES 1600 HARNESS OR APPROVED EQUIVALENT FOR PVC PIPE.
  3. FOR ENCASUREMENTS 150 LF OR LONGER: 12" WIDE 304 STAINLESS BAND AND 2" WIDE PLASTIC OR POLYETHYLENE RUNNERS, PIPELINE SEAL & INSULATOR, INC., MODEL S128-2 OR APPROVED EQUIVALENT. FOR ENCASEMENTS LESS THAN 150 LF: RECON "RAC" CASING SPACERS OR APPROVED EQUIVALENT AND DOUBLE SPACERS AT EACH END.


- EXISTING UTILITIES NOTES:**
1. THE LOCATION OF ALL UNDERGROUND FACILITIES AS INDICATED ON THE PLANS ARE TAKEN FROM PUBLIC RECORDS. JDJR ENGINEERS & CONSULTANTS ASSUMES NO RESPONSIBILITY FOR THE ACCURACY OF SUCH RECORDS AND DOES NOT GUARANTEE THAT ALL UNDERGROUND UTILITIES ARE SHOWN OR ARE LOCATED PRECISELY AS INDICATED.
  2. IT IS THE RESPONSIBILITY OF THE CONTRACTOR TO MAKE ARRANGEMENTS WITH THE OWNERS OF SUCH UNDERGROUND FACILITIES PRIOR TO WORKING IN THE AREA TO CONFIRM THEIR EXACT LOCATION AND TO DETERMINE WHETHER ANY ADDITIONAL FACILITIES OTHER THAN THOSE SHOWN ON THE PLANS MAY BE PRESENT.
  3. THE CONTRACTOR SHALL PRESERVE AND PROTECT ALL UNDERGROUND FACILITIES FOUND.
  4. NOTIFY JDJR ENGINEERS & CONSULTANTS IF ANY UNDERGROUND UTILITIES ARE NOT IN THE LOCATIONS INDICATED ON THESE PLANS (HORIZONTALLY AND VERTICALLY) OR CONFLICT WITH ANY PROPOSED IMPROVEMENTS ASSOCIATED WITH THESE PLANS.
  5. ANY EXISTING UTILITY APPURTENANCES (MH, VALVES, METER BOXES, ETC.) TO BE ADJUSTED TO MATCH THE PROPOSED FINISHED GRADES AS INDICATED ON THESE PLANS. NOTIFY JDJR ENGINEERS & CONSULTANTS, INC. IF THERE IS A PROBLEM MAKING SAID ADJUSTMENTS.

- GENERAL NOTES:**
1. ALL CONSTRUCTION SHALL BE DONE IN STRICT CONFORMANCE TO THESE PLANS AND ALL APPLICABLE MUNICIPAL CODES AND STANDARDS.
  2. THE CONTRACTOR SHALL MAKE APPLICATION FOR SERVICES, OBTAIN ALL PERMITS, AND PAY ALL CHARGES, FEES, AND CONNECTION COSTS REQUIRED FOR EACH UTILITY SERVICE. (THESE COSTS AND FEES SHALL NOT BE INCLUDED IN THE BASE BID).
  3. SEE PLUMBING AND ELECTRICAL PLANS FOR EXACT LOCATIONS AND DETAILS OF SERVICES INTO BUILDING.
  4. CONTRACTOR TO VERIFY THE LOCATION AND DEPTH OF ALL EXISTING UTILITIES PRIOR TO CONSTRUCTION.

BENCH MARK: SQUARE CUT FOUND C.L. OF CURB INLET, WEST SIDE OF ADDISON ROAD, 75' SOUTH OF THE C.L. OF AIRPORT PKWY.  
ELEVATION 642.51

SITE TBM: X-CUT SET IN CONCRETE WALK ±38' NORTH OF THE NORTHEAST CORNER OF THIS TRACT.  
ELEVATION 642.86

REVISIONS:	
6/04/08	CITY COMMENTS
7/25/08	CITY COMMENTS
8/01/08	CITY COMMENTS
8/05/08	CITY COMMENTS
9/09/08	REV. WATER SERV.
9/23/08	REV. WATER SERV.
10/21/08	REV. FIRE SERV.

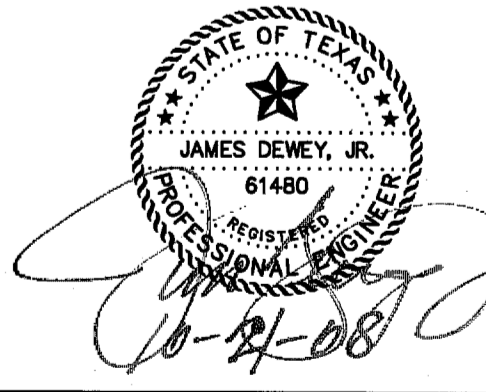

SHEET TITLE:  
**UTILITY SERVICES PLAN**  
HANGER ADDITION PLANS FOR EXECUTIVE HANGER OWNERS ASSOCIATION OF ADDISON AIRPORT ADDISON, TEXAS

PREPARED BY:  
**JDJR ENGINEERS AND CONSULTANTS**  
ENGINEERS • SURVEYORS • LAND PLANNERS  
2500 Texas Drive Suite 100 Irving, Texas 75062  
Tel 972-262-5357 Fax 972-262-6956

DATE: APR. 8, 2008 DRAWN BY: SAS SHEET NO.  
SCALE: 1" = 30' CHECKED BY: JDJR **C10** OF 10