
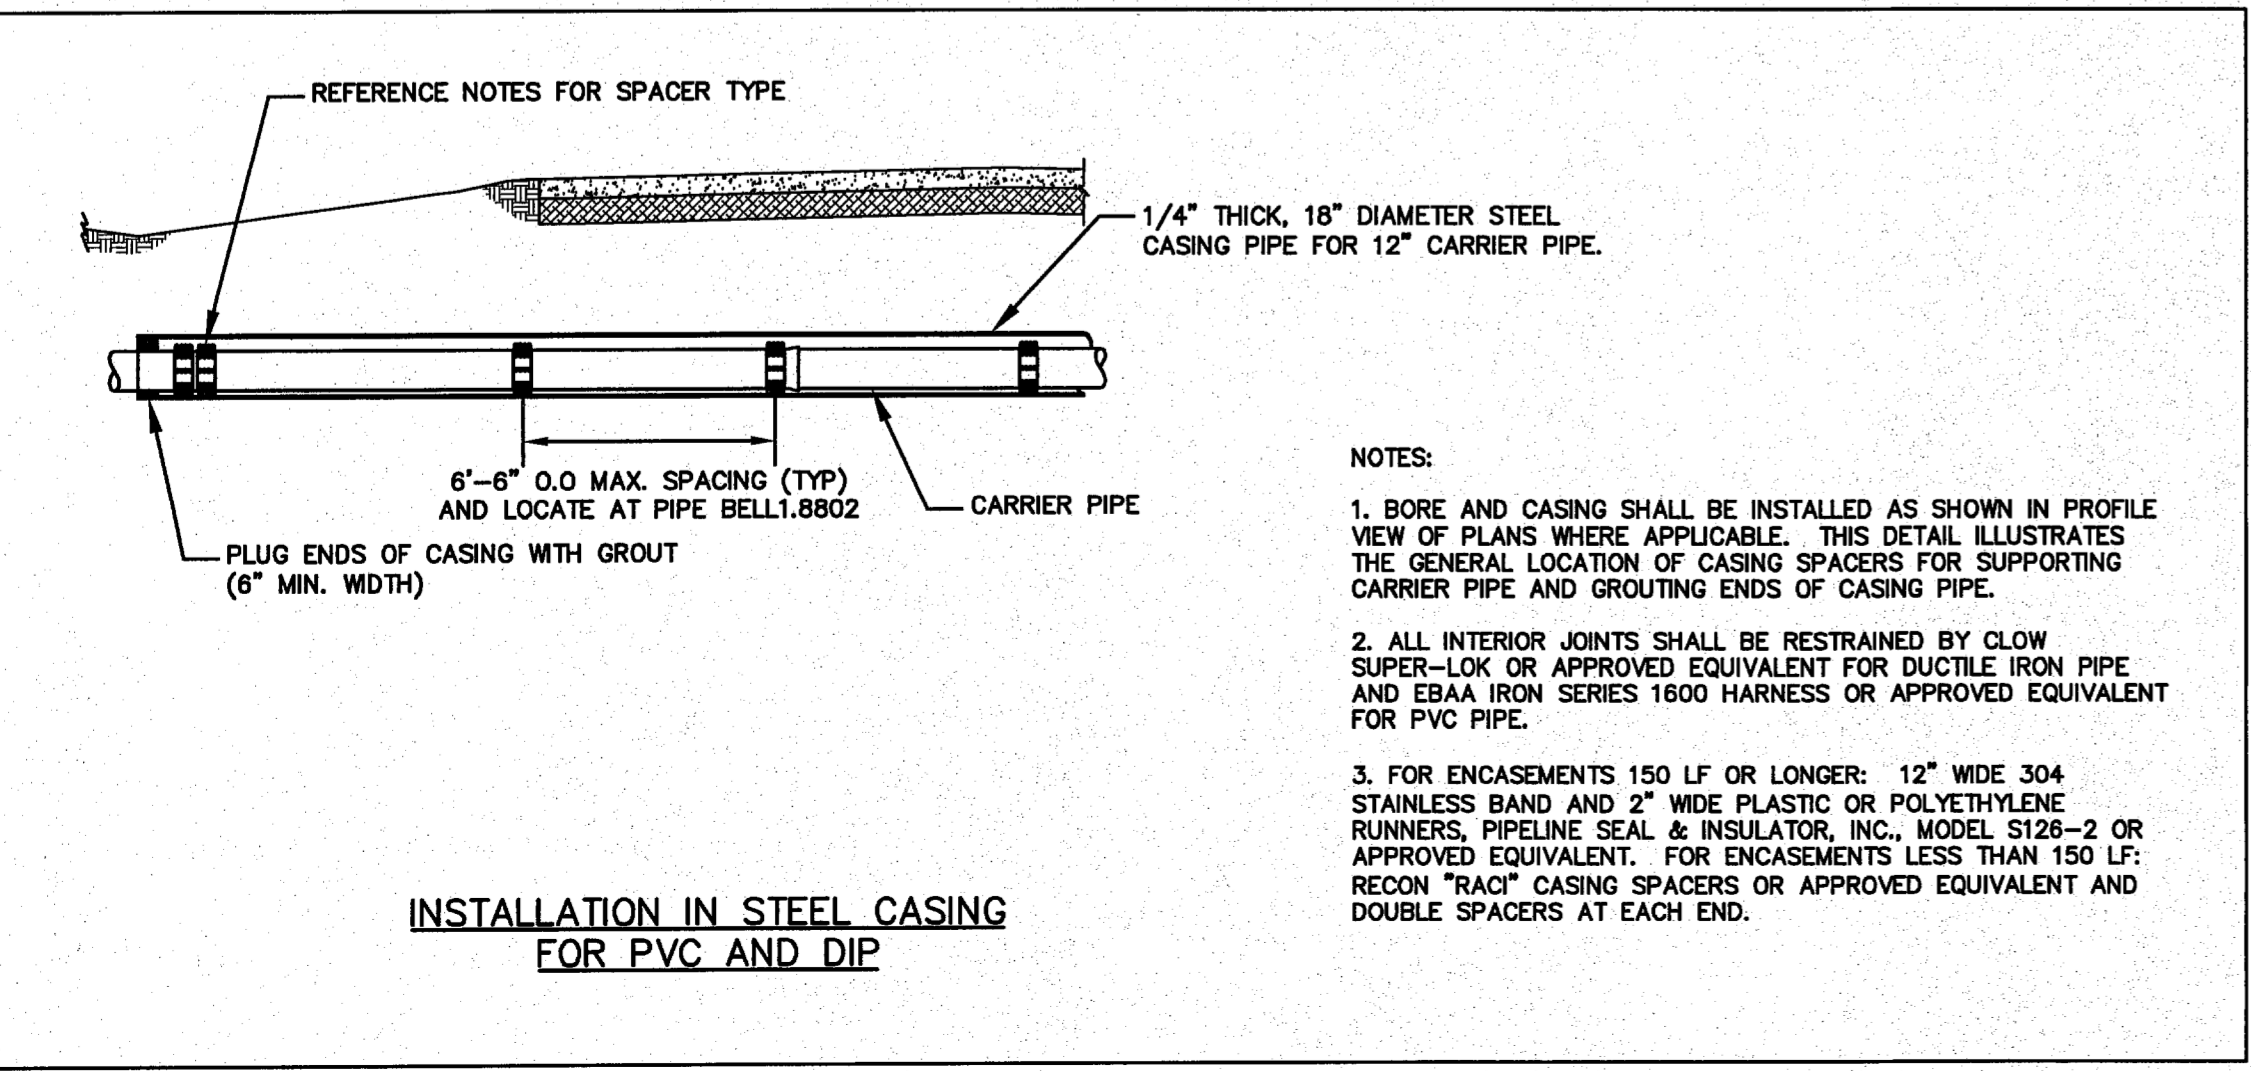


APPROVED FOR CONSTRUCTION
 Town of Addison
 Public Works Department
 APPROVED BY: *CLAY BARRETT*
 DATE: 9-24-08

All responsibility for the adequacy of these plans remains with the Engineer who prepared them. In approving these plans, the Town of Addison makes no representation of adequacy of the work of the Design Engineer.

REVISIONS:	
6/04/08	CITY COMMENTS
7/25/08	CITY COMMENTS
8/01/08	CITY COMMENTS
8/05/08	CITY COMMENTS
9/09/08	REV. WATER SERV.
9/23/08	REV. WATER SERV.

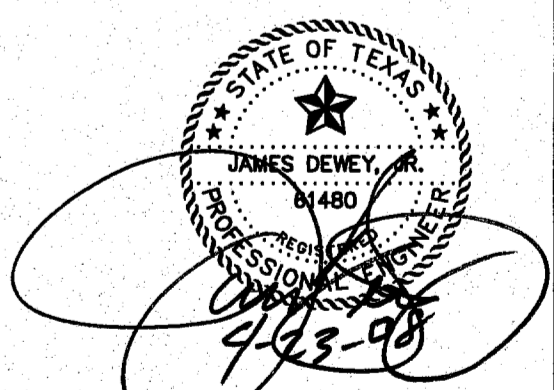

EXISTING UTILITIES NOTES:

- THE LOCATION OF ALL UNDERGROUND FACILITIES AS INDICATED ON THE PLANS ARE TAKEN FROM PUBLIC RECORDS. JDJR ENGINEERS & CONSULTANTS ASSUMES NO RESPONSIBILITY FOR THE ACCURACY OF SUCH RECORDS AND DOES NOT GUARANTEE THAT ALL UNDERGROUND UTILITIES ARE SHOWN OR ARE LOCATED PRECISELY AS INDICATED.
- IT IS THE RESPONSIBILITY OF THE CONTRACTOR TO MAKE ARRANGEMENTS WITH THE OWNERS OF SUCH UNDERGROUND FACILITIES PRIOR TO WORKING IN THE AREA TO CONFIRM THEIR EXACT LOCATION AND TO DETERMINE WHETHER ANY ADDITIONAL FACILITIES OTHER THAN THOSE SHOWN ON THE PLANS MAY BE PRESENT.
- THE CONTRACTOR SHALL PRESERVE AND PROTECT ALL UNDERGROUND FACILITIES FOUND.
- NOTIFY JDJR ENGINEERS & CONSULTANTS IF ANY UNDERGROUND UTILITIES ARE NOT IN THE LOCATIONS INDICATED ON THESE PLANS (HORIZONTALLY AND VERTICALLY) OR CONFLICT WITH ANY PROPOSED IMPROVEMENTS ASSOCIATED WITH THESE PLANS.
- ANY EXISTING UTILITY APPURTENANCES (MH, VALVES, METER BOXES, ETC.) TO BE ADJUSTED TO MATCH THE PROPOSED FINISHED GRADES AS INDICATED ON THESE PLANS. NOTIFY JDJR ENGINEERS & CONSULTANTS, INC. IF THERE IS A PROBLEM MAKING SAID ADJUSTMENTS.

GENERAL NOTES:

- ALL CONSTRUCTION SHALL BE DONE IN STRICT CONFORMANCE TO THESE PLANS AND ALL APPLICABLE MUNICIPAL CODES AND STANDARDS.
- THE CONTRACTOR SHALL MAKE APPLICATION FOR SERVICES, OBTAIN ALL PERMITS, AND PAY ALL CHARGES, FEES, AND CONNECTION COSTS REQUIRED FOR EACH UTILITY SERVICE. (THESE COSTS AND FEES SHALL NOT BE INCLUDED IN THE BASE BID).
- SEE PLUMBING AND ELECTRICAL PLANS FOR EXACT LOCATIONS AND DETAILS OF SERVICES INTO BUILDING.
- CONTRACTOR TO VERIFY THE LOCATION AND DEPTH OF ALL EXISTING UTILITIES PRIOR TO CONSTRUCTION.

BENCH MARK: SQUARE CUT FOUND C.L. OF CURB INLET, WEST SIDE OF ADDISON ROAD, 75' SOUTH OF THE C.L. OF AIRPORT PKWY.
 ELEVATION 642.51
 SITE TBM: X-CUT SET IN CONCRETE WALK ±38' NORTH OF THE NORTHEAST CORNER OF THIS TRACT.
 ELEVATION 642.86

SHEET TITLE:
UTILITY SERVICES PLAN
 HANGER ADDITION PLANS FOR
 EXECUTIVE HANGER OWNERS ASSOCIATION OF ADDISON
 AIRPORT
 ADDISON, TEXAS

PREPARED BY:
JDJR ENGINEERS AND CONSULTANTS

ENGINEERS • SURVEYORS • LAND PLANNERS
 2500 Texas Drive Suite 100 Irving, Texas, 75062
 Tel 972-252-5367 Fax 972-252-9858

DATE: APR. 8, 2008 DRAWN BY: SAS
 SCALE: 1" = 30' CHECKED BY: JDJR

SHEET NO. **C10** OF **10**