


DRAINAGE AREA MAP
1"=400'

D.A.	AREA	C	I	Q
A-1	0.6	0.85	8.74	4.5
A-2	1.9	0.85	8.74	14.1
A-3	1.6	0.85	8.74	11.9
A-4	1.9	0.85	8.74	14.1

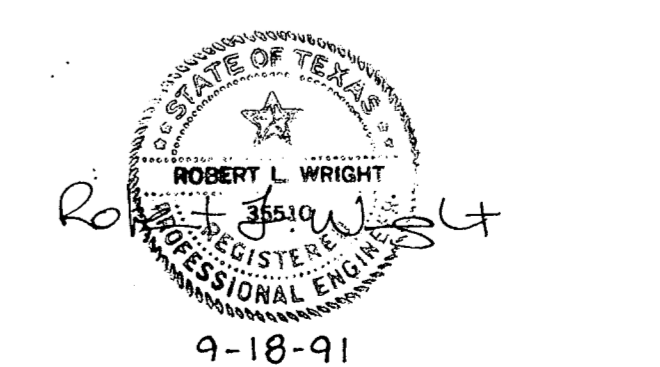

NEEDHAM WRIGHT LASKEY
ENGINEERS INC.
10290 MONROE DRIVE
SUITE 305
DALLAS, TEXAS 75229
PH. 214 357 2981 SHEET NO. 3

REVISED 9-26-91

GRADING PLAN						
PERSONAL WAY AVIATION						
TOWN OF ADDISON, TEXAS						
DRAWN	DESIGN	DATE	SCALE	NOTES	FILE	NUMBER
N.W.L.	N.W.L.	9-18-91	1"=40'			