



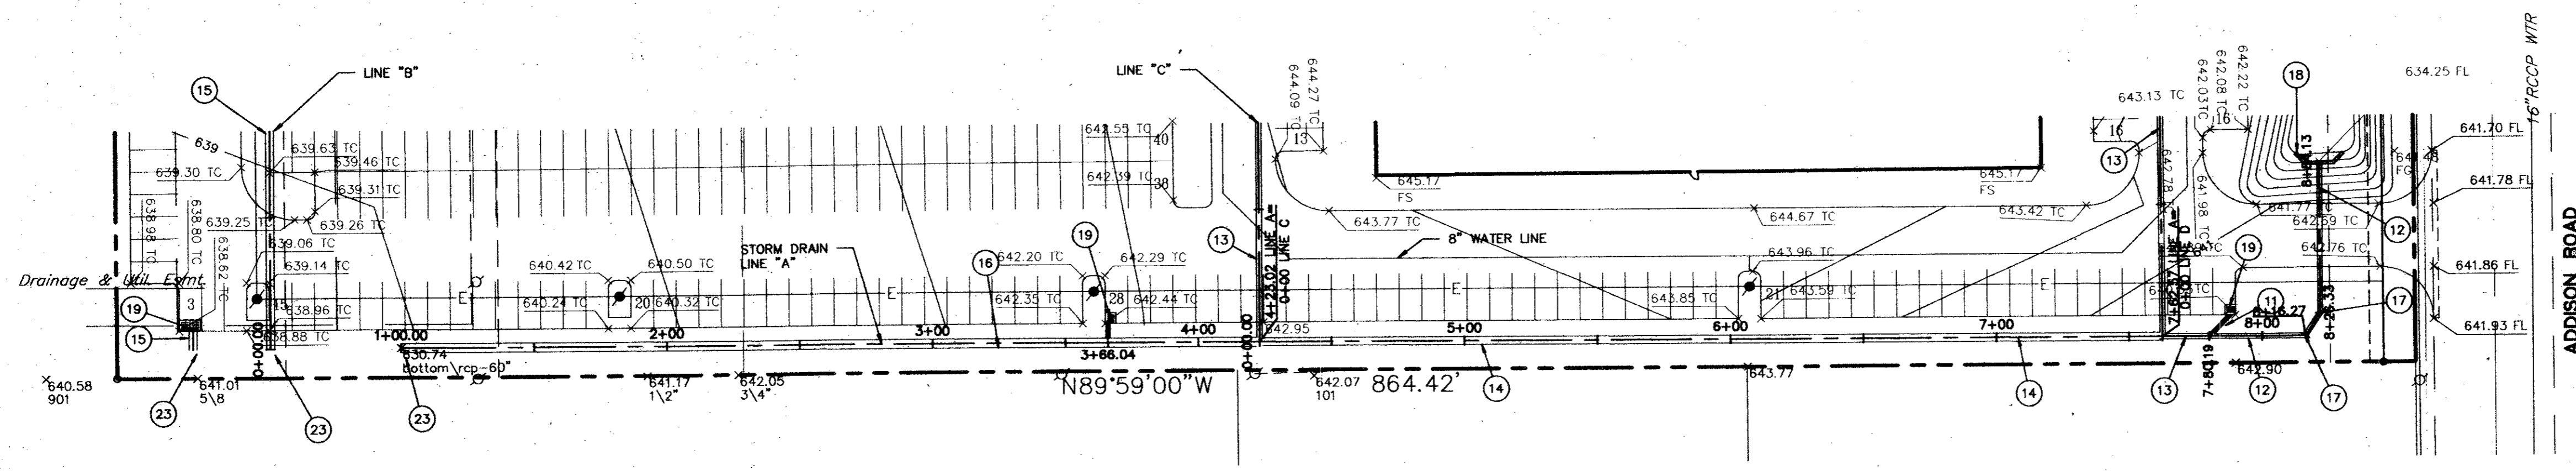

**STORM DRAIN LINE "A"
 PLAN AND PROFILE**

**EXCEL COMMUNICATIONS
 SERVICE CENTER
 A DEVELOPMENT OF
 WILCOX /CMC ADDISON, INC.**

Scale: 1" = 40' Date: 11-28-95
 Type: Drawn by: P.M.L.
 Xref: PBLINEA
 File: 02701JPC.dwg
 Approved by: O.L.V.
 Project No.: 3027-01

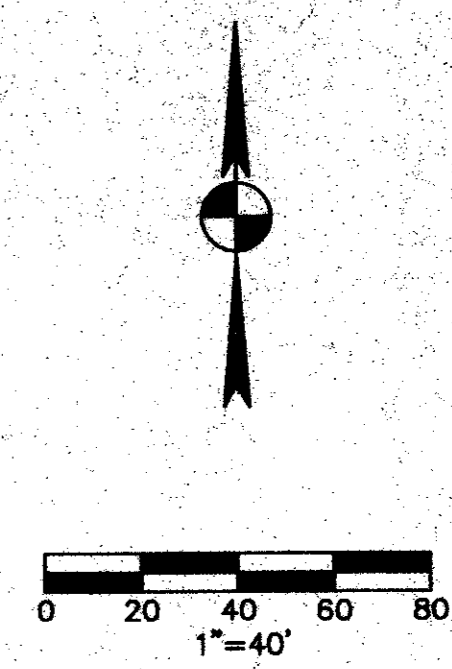

STORM DRAIN LINE "A"

- STORM DRAIN CONSTRUCTION NOTES**
- (11) 18" RCP STORM DRAIN
 - (12) 21" RCP STORM DRAIN
 - (13) 24" RCP STORM DRAIN
 - (14) 27" RCP STORM DRAIN
 - (15) 36" RCP STORM DRAIN
 - (16) 42" RCP STORM DRAIN
 - (17) CONSTRUCT CONCRETE COLLAR
 - (18) TYPE "A" HEAD WALL PER DETAIL
 - (19) 3'x3' GRATE INLET PER ___ OR APPROVED EQUAL
 - (20) 2'-4"x4' GRATE INLETS PER ___ OR APPROVED EQUAL
 - (21) TRENCH DRAIN PER ___ OR APPROVED EQUAL
 - (22) CONNECT TO ROOF DRAIN PER MECH. PLANS
 - (23) JOIN EXIST 60" RCP

