



STORM DRAIN CONSTRUCTION NOTES


- (11) 18" RCP STORM DRAIN
- (12) 21" RCP STORM DRAIN
- (13) 24" RCP STORM DRAIN
- (14) 27" RCP STORM DRAIN
- (15) 36" RCP STORM DRAIN
- (16) 42" RCP STORM DRAIN
- (17) CONSTRUCT CONCRETE COLLAR
- (18) TYPE "A" HEAD WALL PER DETAIL
- (19) 3'-3" GRATE INLET PER OR APPROVED EQUAL
- (20) 2'-4"x4" GRATE INLETS PER OR APPROVED EQUAL
- (21) TRENCH DRAIN PER OR APPROVED EQUAL
- (22) CONNECT TO ROOF DRAIN PER MECH. PLANS
- (23) JOIN EXIST 60" RCP

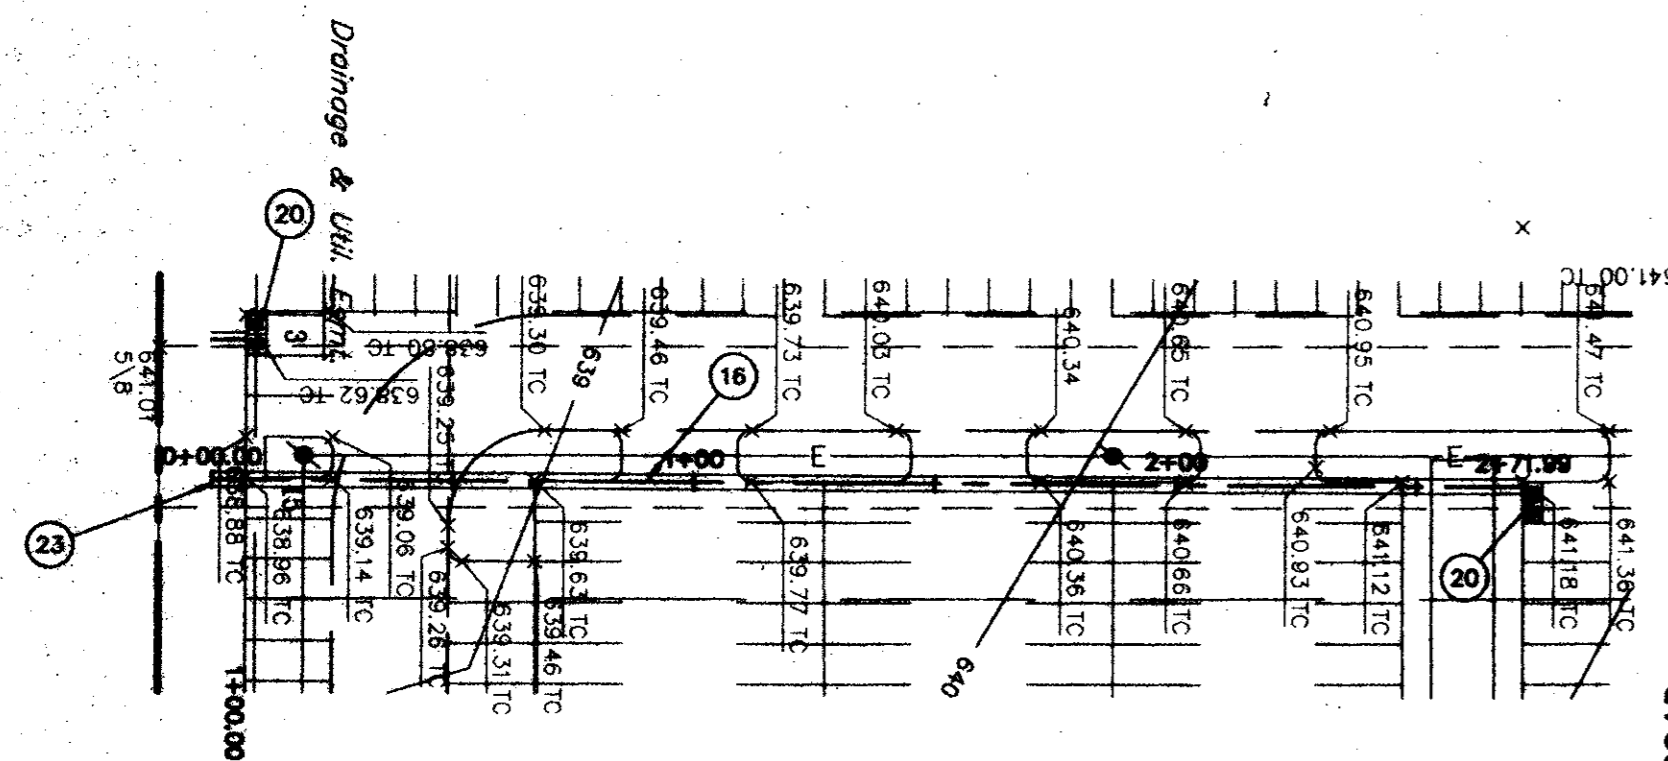


STORM DRAIN LINE "B"

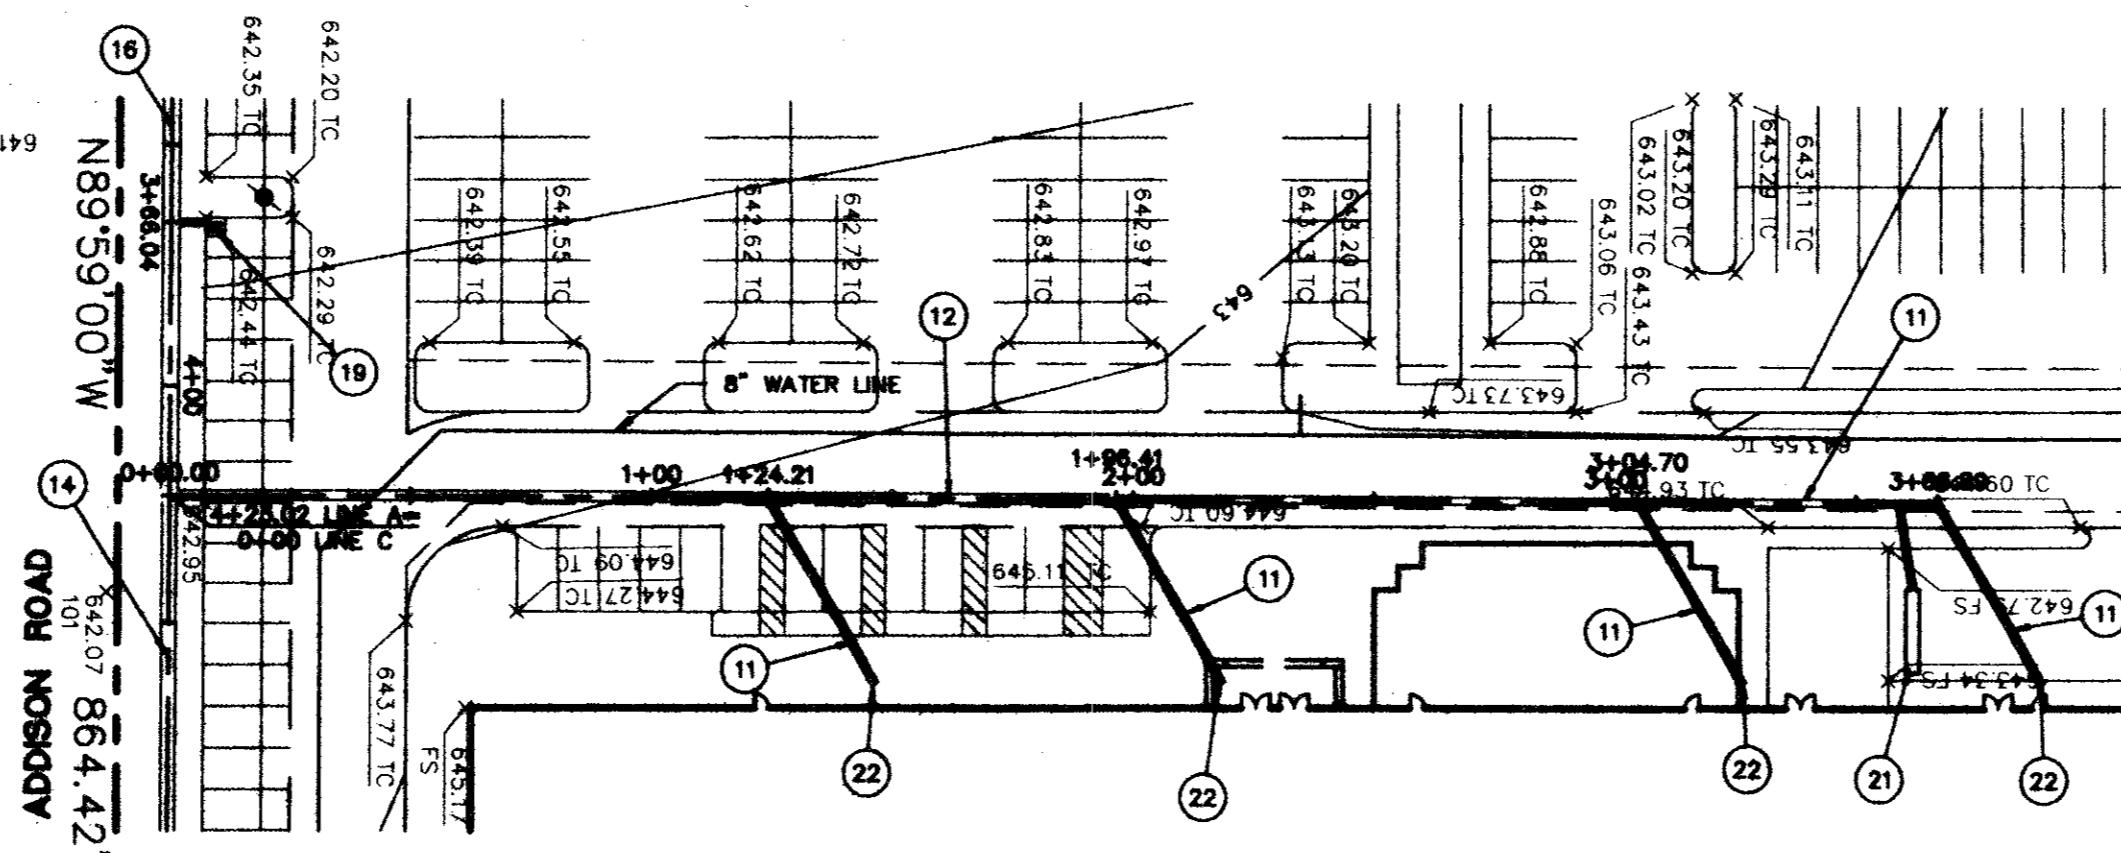

STORM DRAIN LINE "C"

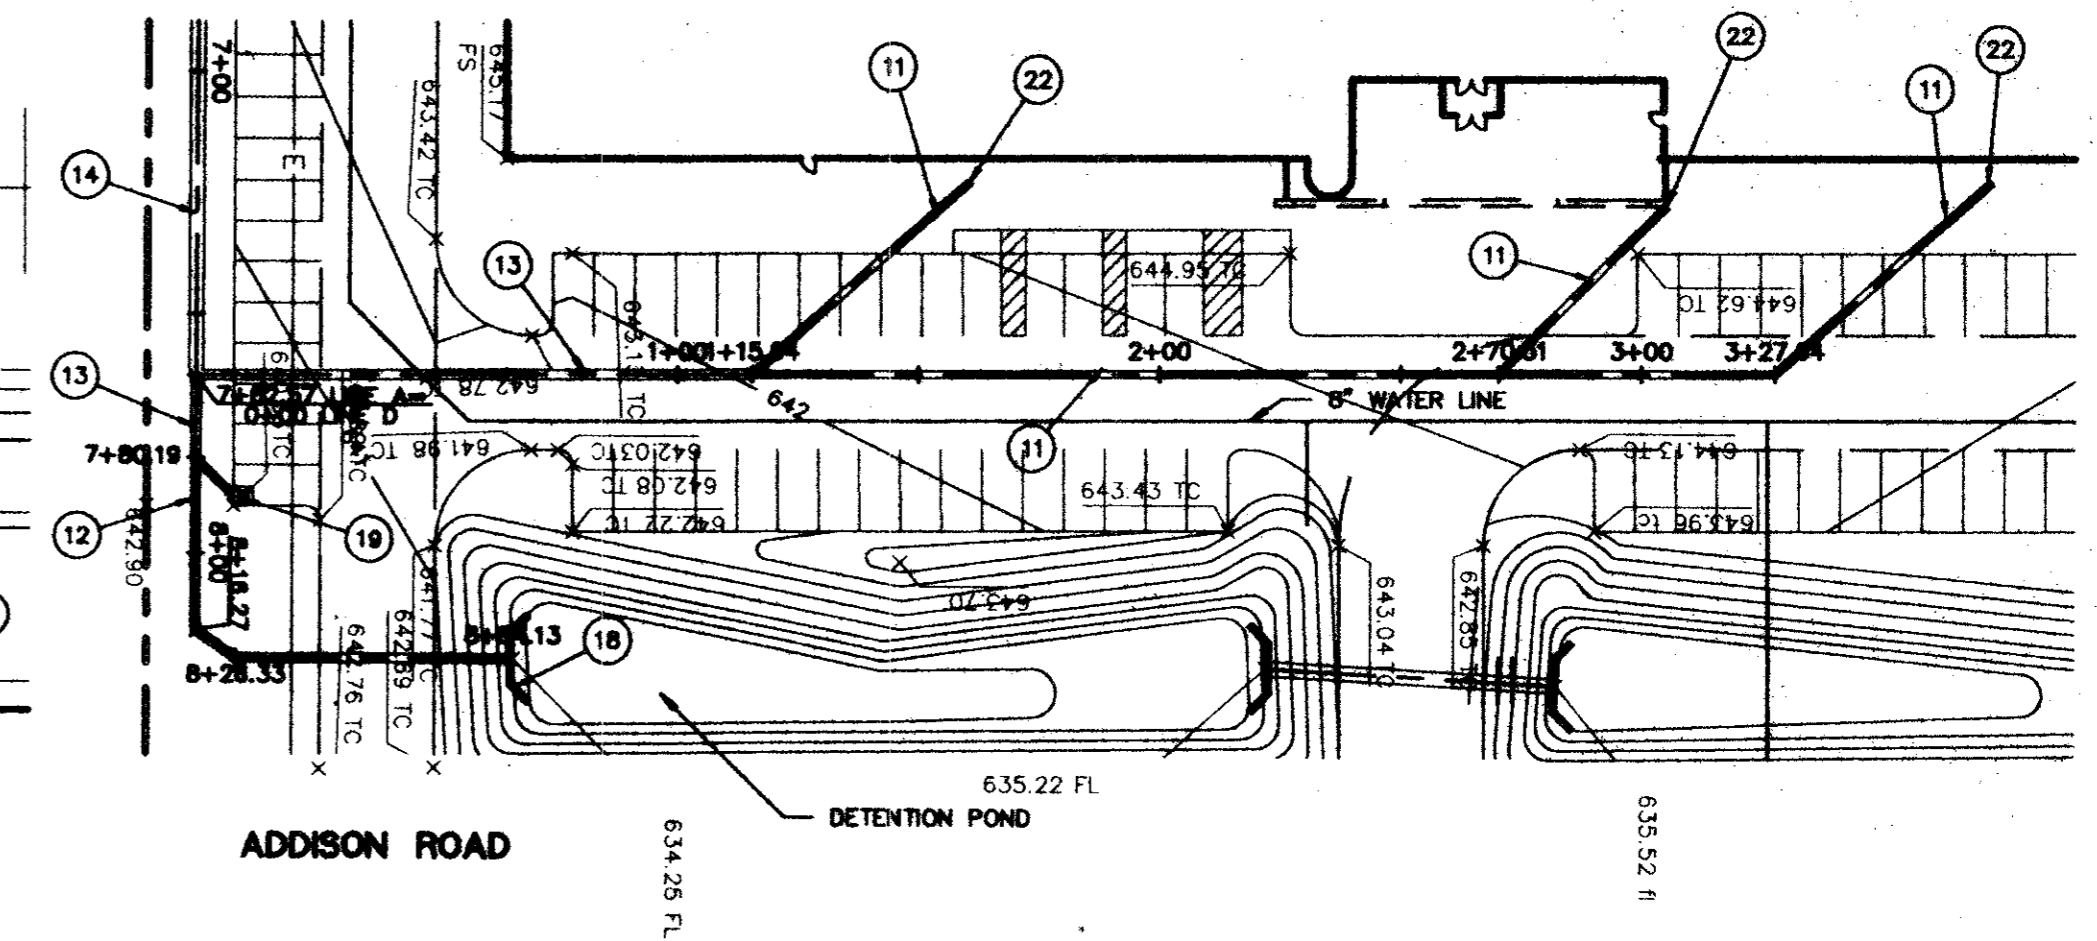

STORM DRAIN LINE "D"

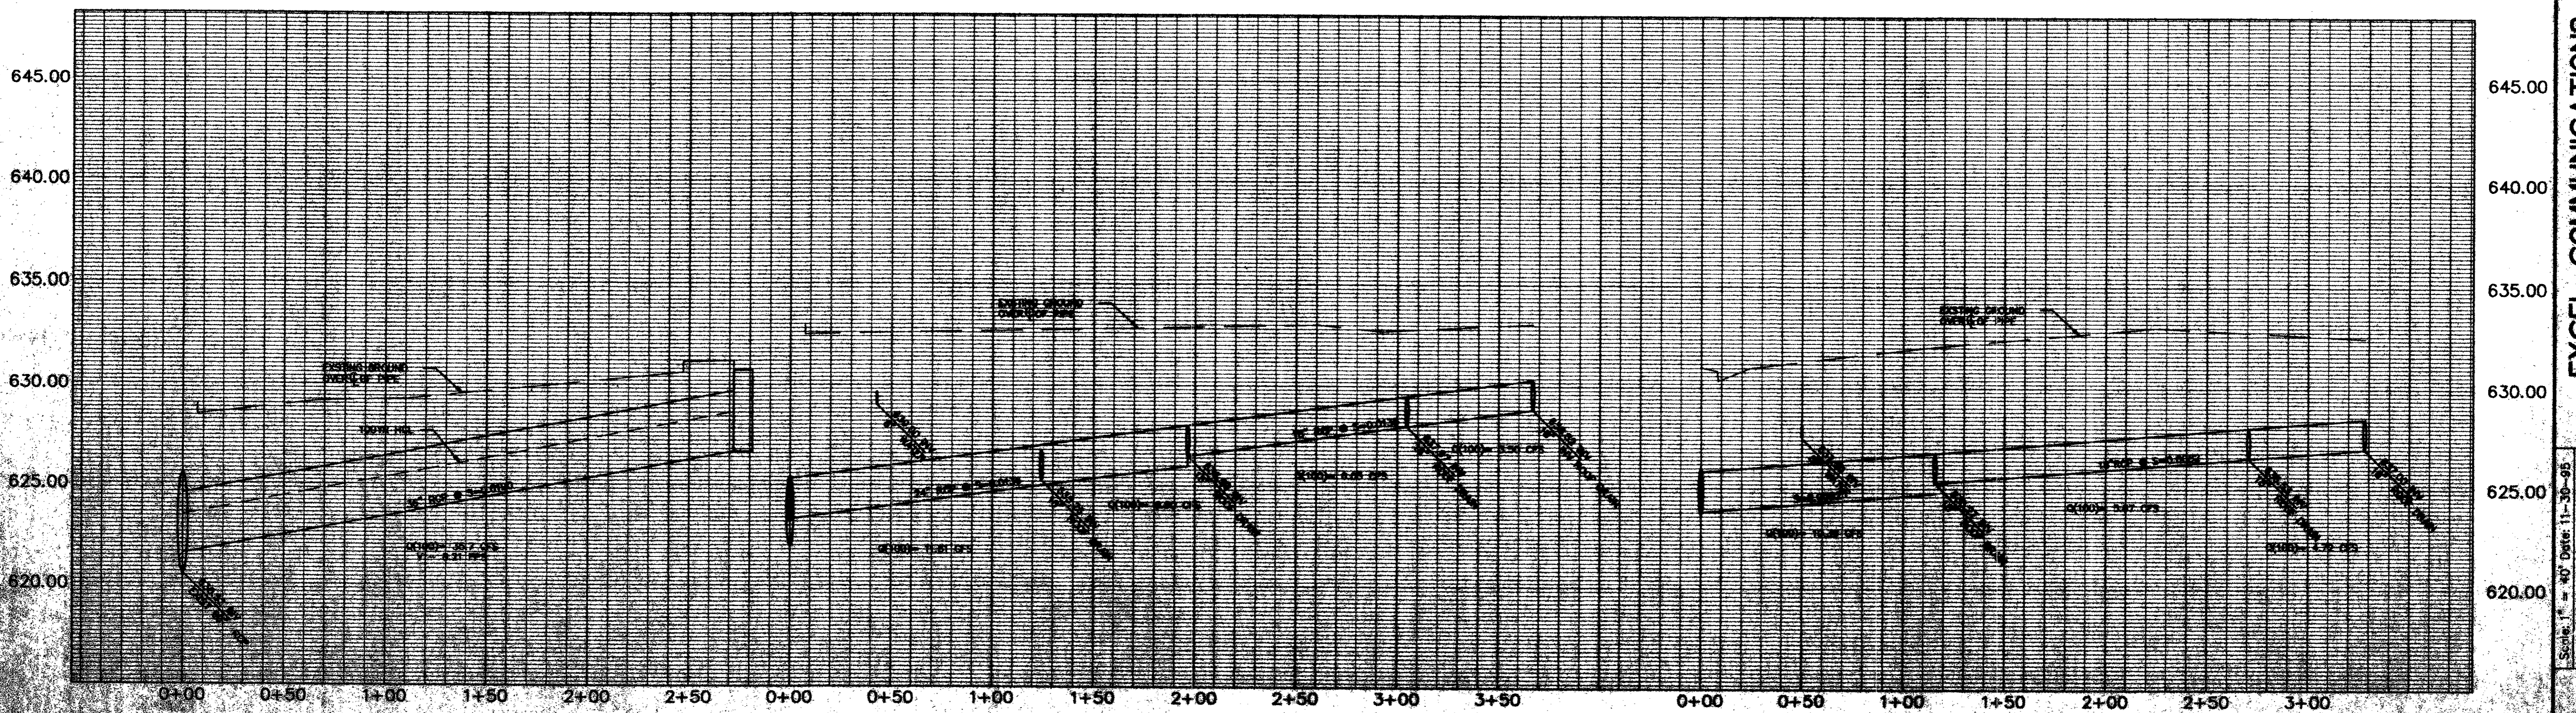

Bury + Pittman
 Consulting Engineers and Surveyors
 Dallas, Texas Tel. 817/961-4611 Fax 817/961-4678
 © Copyright 1995 Bury + Pittman - D.R.T., Inc.



STORM DRAIN LINES "B", "C" AND "D" PLAN AND PROFILE

EXCEL COMMUNICATIONS
 SERVICE CENTER
 A DEVELOPMENT OF
 WILCOX/CMC ADDISON, INC.

Scale: 1" = 40' Date: 11-30-95
 Drawn by: P.M.L.
 Checked by: P.M.L.
 Project No. 3027-B