



WTR. METER DETAIL SCALE: 1"=1'-0" P202

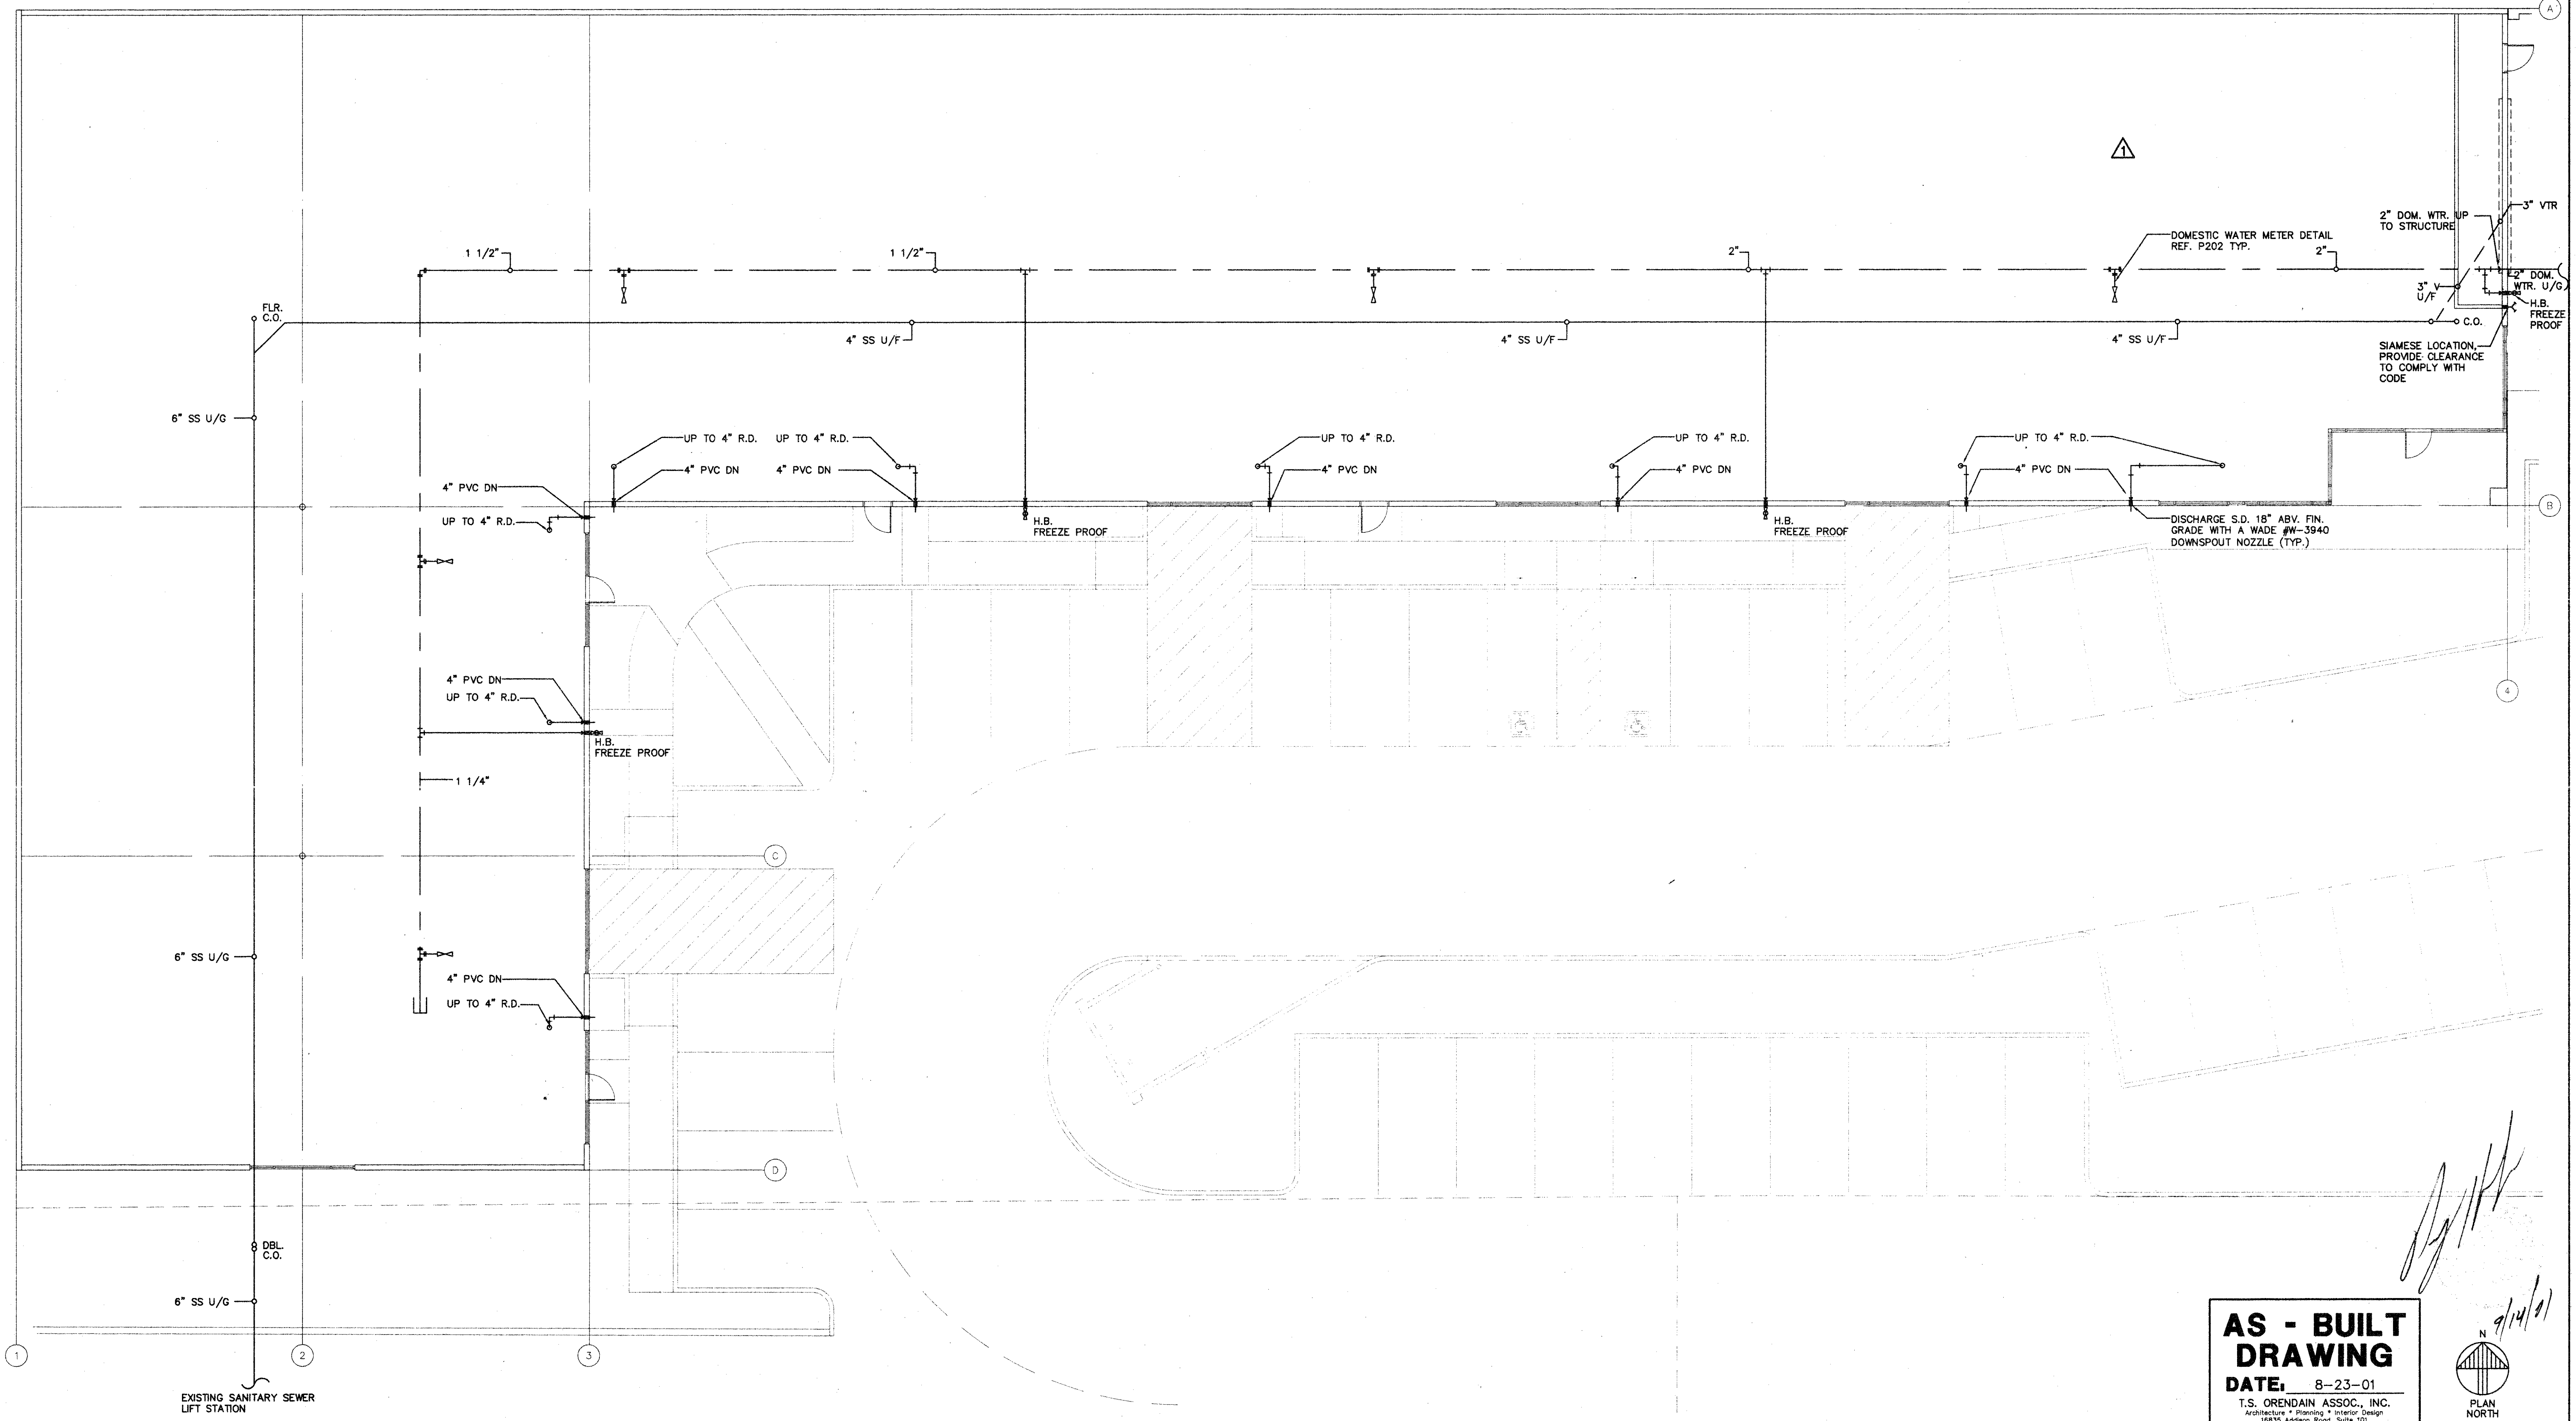

**AS - BUILT DRAWING**  
 DATE: 8-23-01  
 T.S. ORENDAIN ASSOC., INC.  
 Architecture • Planning • Interior Design  
 16835 Addison Road, Suite 101  
 Addison, Texas 75001  
 972-250-0119

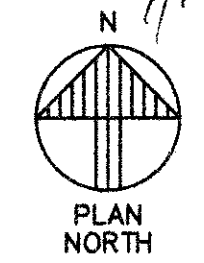

PLUMBING PLAN SCALE: 1/8"=1'-0" P201

**AMO**  
 16835 ADDISON ROAD  
 ADDISON, TX 75001  
 TEL: 972-250-0119  
 FAX: 972-250-3157

**ADDISON PARK CENTRE  
 OFFICE/TECH./FLEX.  
 PHASE 1**  
 16835 ADDISON ROAD ADDISON, TEXAS

**to**  
 T.S. Orendain Associates Inc.  
 Architecture • Planning • Interior Design

16835 Addison Road  
 Suite 101  
 Addison, Texas 75001  
 (972) 250-0119

JOB: 8396 DATE: 2/25/2000  
 DRAWN: CHECKED:

Date	By	Issued For / Description	PERMIT / ISSUE
8-17-98			
11-1-99			T.D.L.R.
2-25-00		100% ISSUED FOR CONSTRUCTION	
8-9-2000		GENERAL REVISION	

PLUMBING PLAN