



AMO
 16835 ADDISON ROAD
 SUITE 101
 ADDISON, TX 75001
 FAX: 972-250-3157

**ADDISON PARK CENTRE
 OFFICE/TECH./FLEX.
 PHASE 1**
 16835 ADDISON ROAD ADDISON, TEXAS


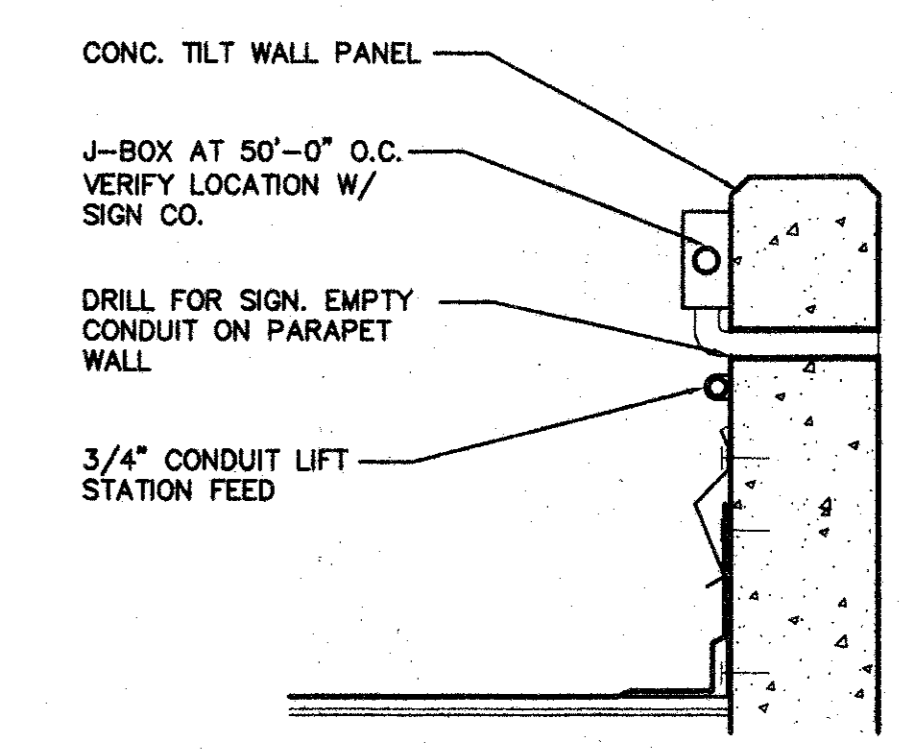


ELECT. DETAIL SCALE: 1 1/2"=1'-0" E102

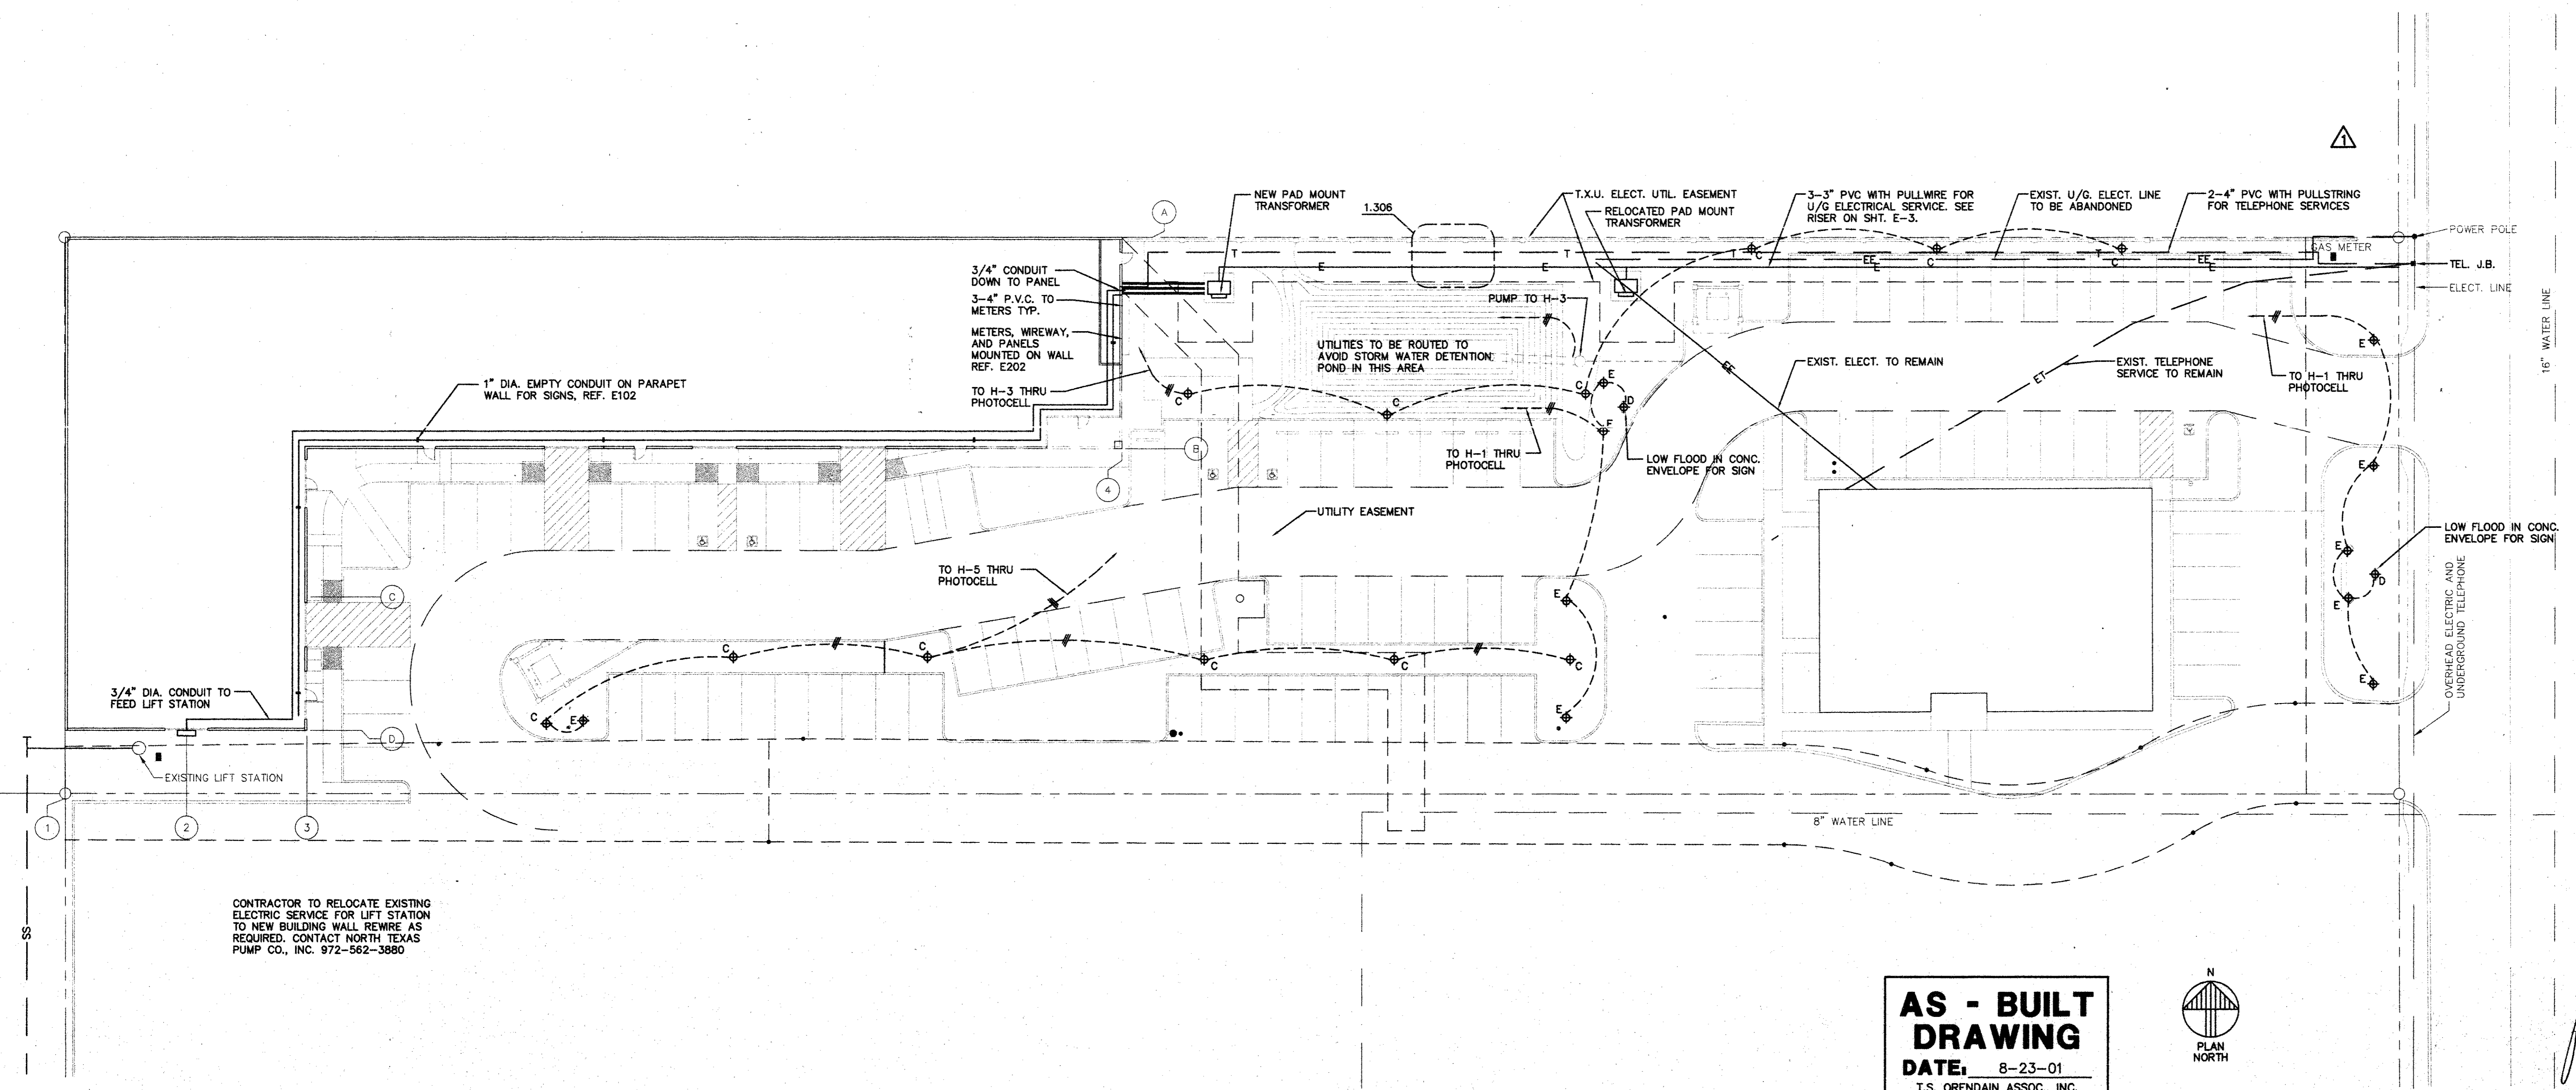


CONTRACTOR TO RELOCATE EXISTING ELECTRIC SERVICE FOR LIFT STATION TO NEW BUILDING WALL REMIRE AS REQUIRED. CONTACT NORTH TEXAS PUMP CO., INC. 972-562-3880

**AS - BUILT
 DRAWING**
 DATE: 8-23-01
 T.S. OREDAIN ASSOC., INC.
 Architecture • Planning • Interior Design
 16835 Addison Road, Suite 101
 Addison, Texas 75001 972-250-0119

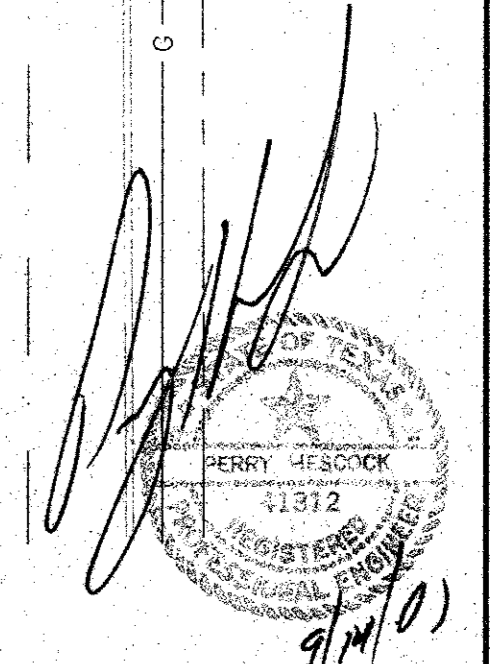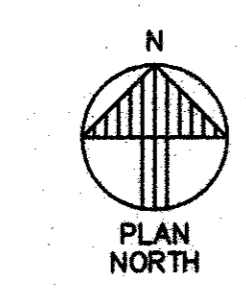

ELECTRICAL SITE PLAN SCALE: 1"=20'-0" E101

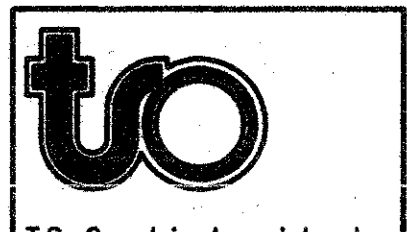

T.S. Orendain Associates Inc.
 Architecture • Planning • Interior Design

16835 Addison Road
 Suite 101
 Addison, Texas 75001
 (972) 250-0119

JOB: 6396 DATE: 2/25/2000
 DRAWN: CHECKED:

| Date | By | Issued For / Description |
|-----------|----|------------------------------|
| 8-17-98 | | PERMIT ISSUE |
| 11-1-99 | | T.O.L.R. |
| 2-25-2000 | | 100% ISSUED FOR CONSTRUCTION |
| 6-9-2000 | | GENERAL REVISION |

ELECTRICAL SITE PLAN