

CHANEY & HOPE, INC.

General Contractor



MAIL: P. O. BOX 427, ADDISON, TEXAS 75001
TELEPHONE: DALLAS - A.C. 214 - 239-1324

24 December 1975

City of Addison
P. O. Box 144
Addison, Texas 75001

Attn: C. J. Webster
City Administrator

Gentlemen:

This is to advise you that I have been personally in charge of the installation of the temporary water and sewer facilities for the Trinity Christian Academy at 16700 Addison Road.

All facilities were installed as shown on the enclosed drawings by qualified personnel and in accordance with the latest manufacturer's recommendations for all materials used.


Sincerely,

CHANEY & HOPE, INC.


T. L. Loeb
Professional Engineer

jj

Enclosures

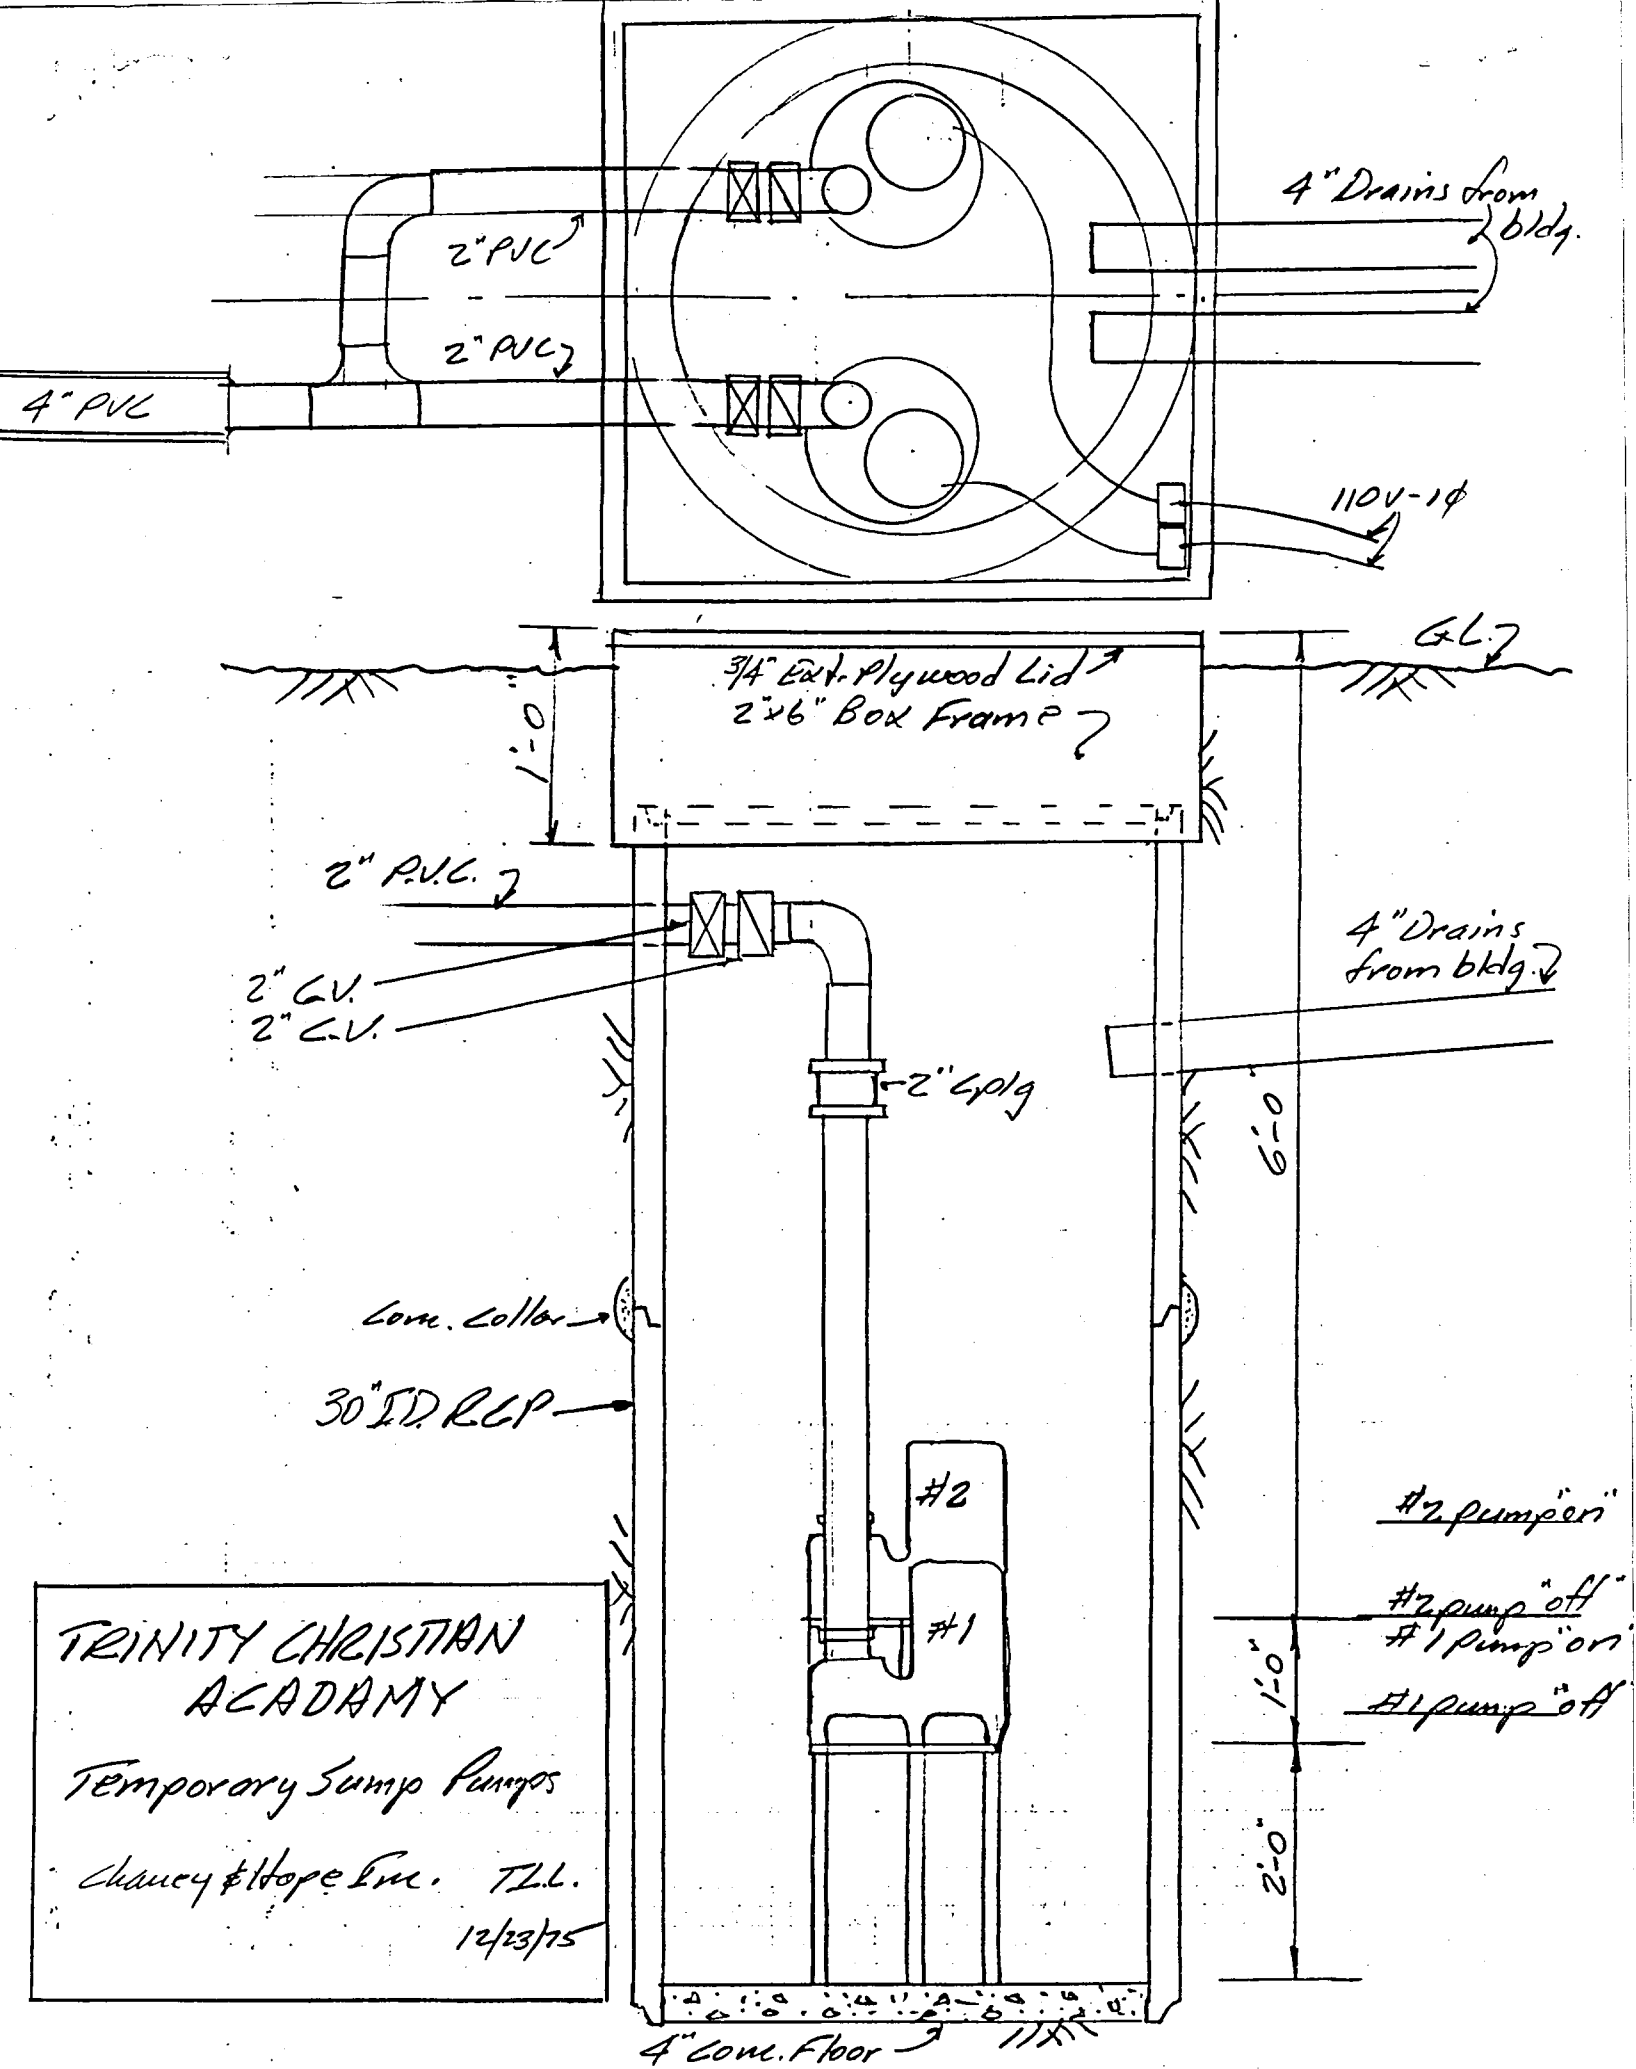

TRINITY CHRISTIAN
 ACADEMY
 Temporary Sump Pumps
 Chaucy & Hope Inc. T.L.L.
 12/23/75

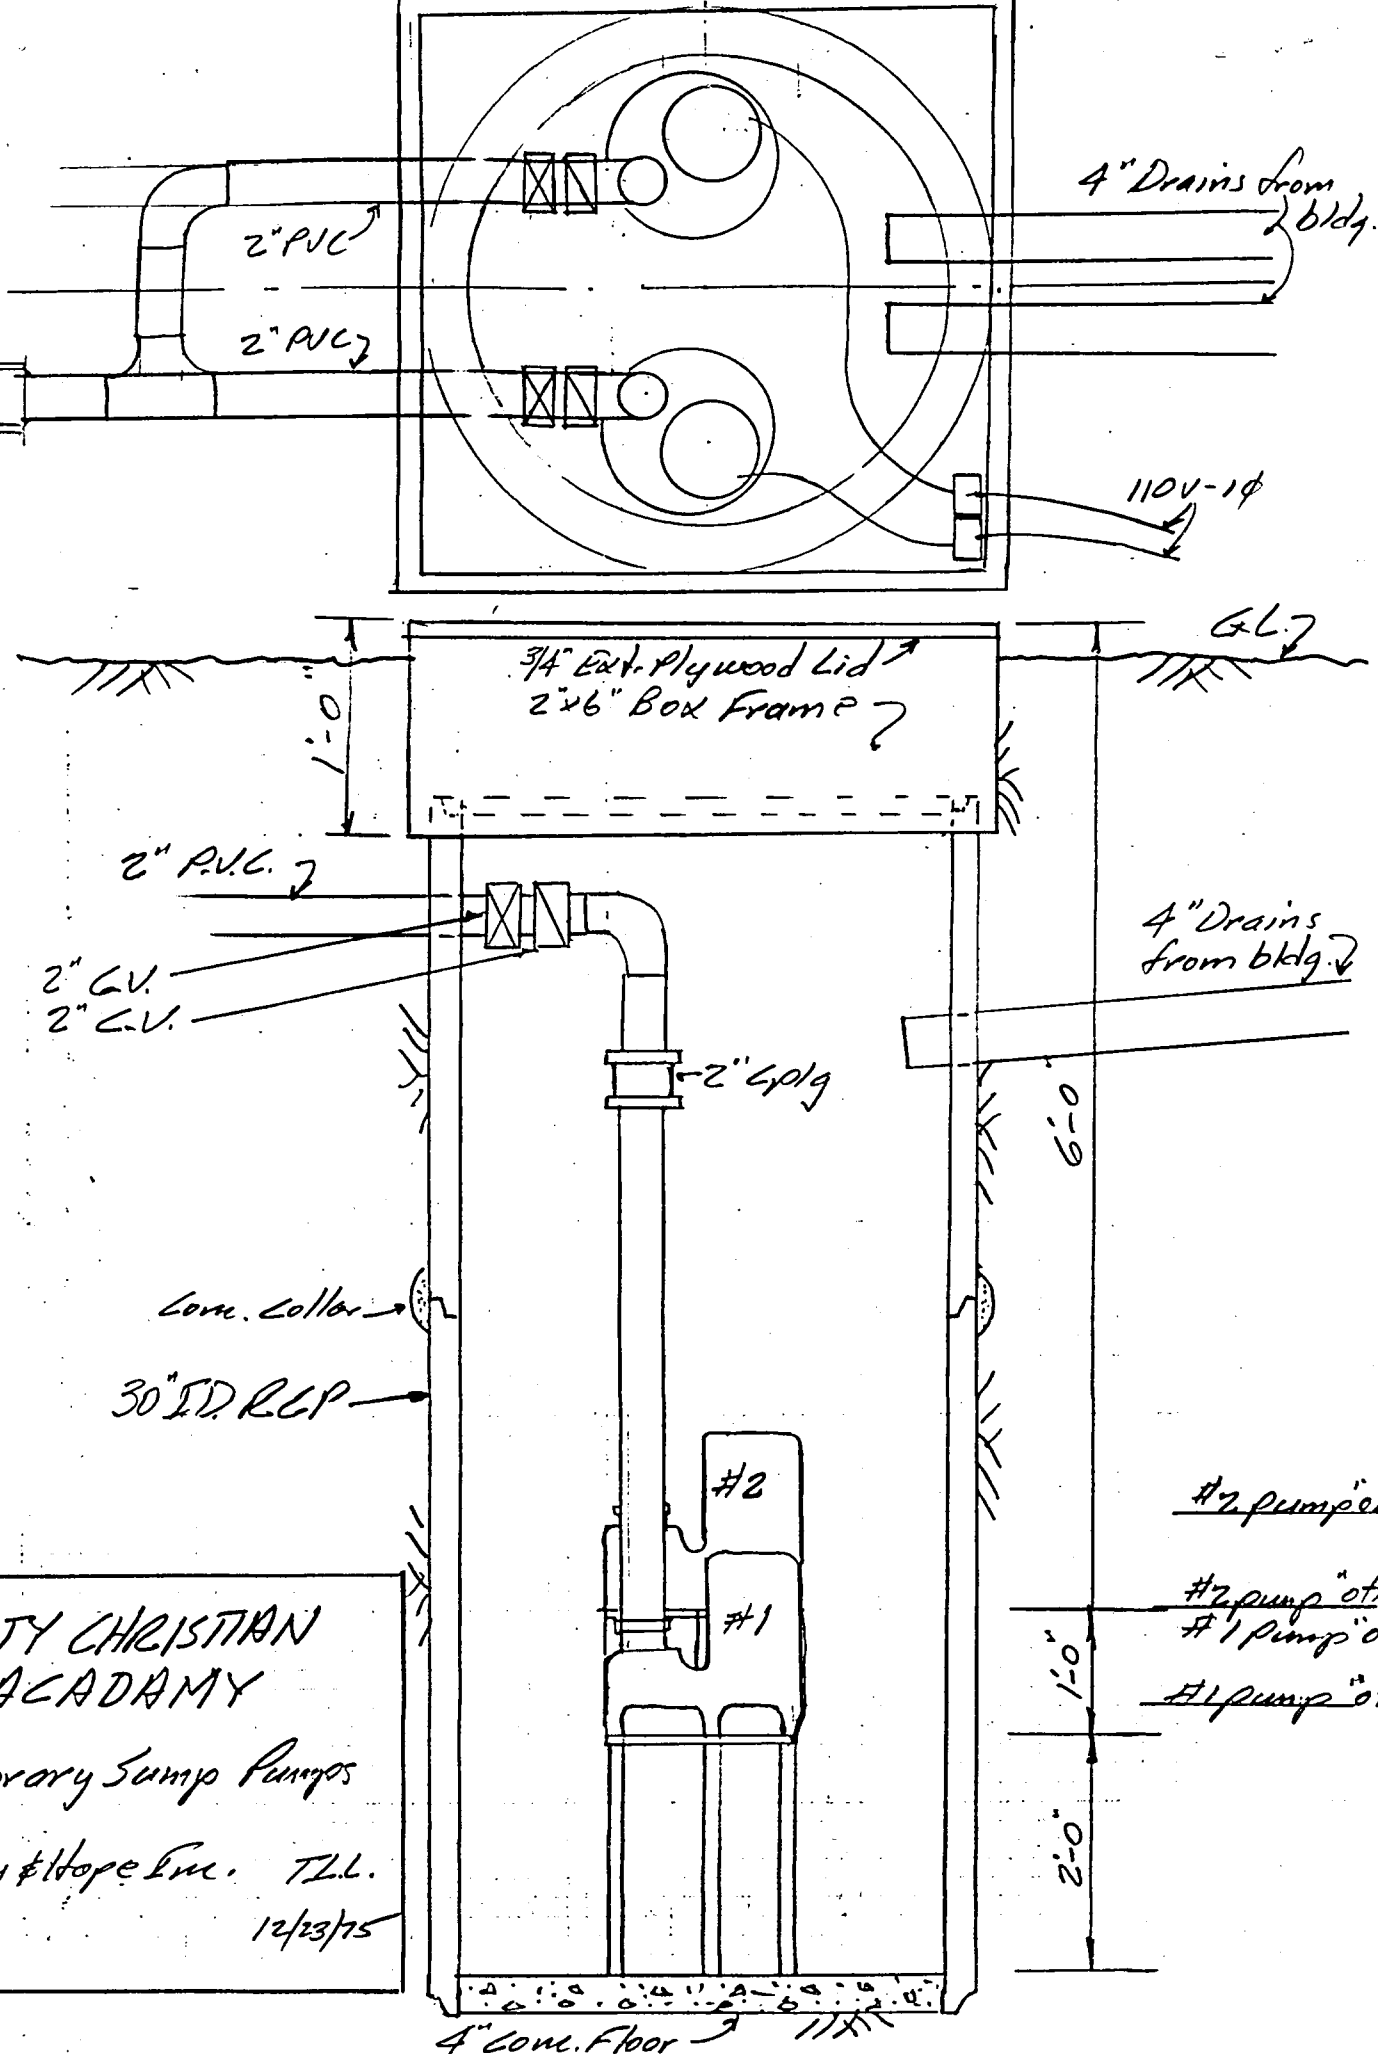

4" PVC
 2" PVC
 2" PVC

4" Drains from bldg.

110V-1φ

3/4" Ext. Plywood Lid
 2x6" Box Frame

GL.7

2" P.V.C.
 2" C.V.
 2" C.V.

4" Drains from bldg.

2" Galv

6'-0"

Conc. collar

30" ID RCP

#2 pump 'on'

#2 pump 'off'



#1 pump 'on'

#1 pump 'off'

1'-0"

2'-0"

4" Conc. Floor

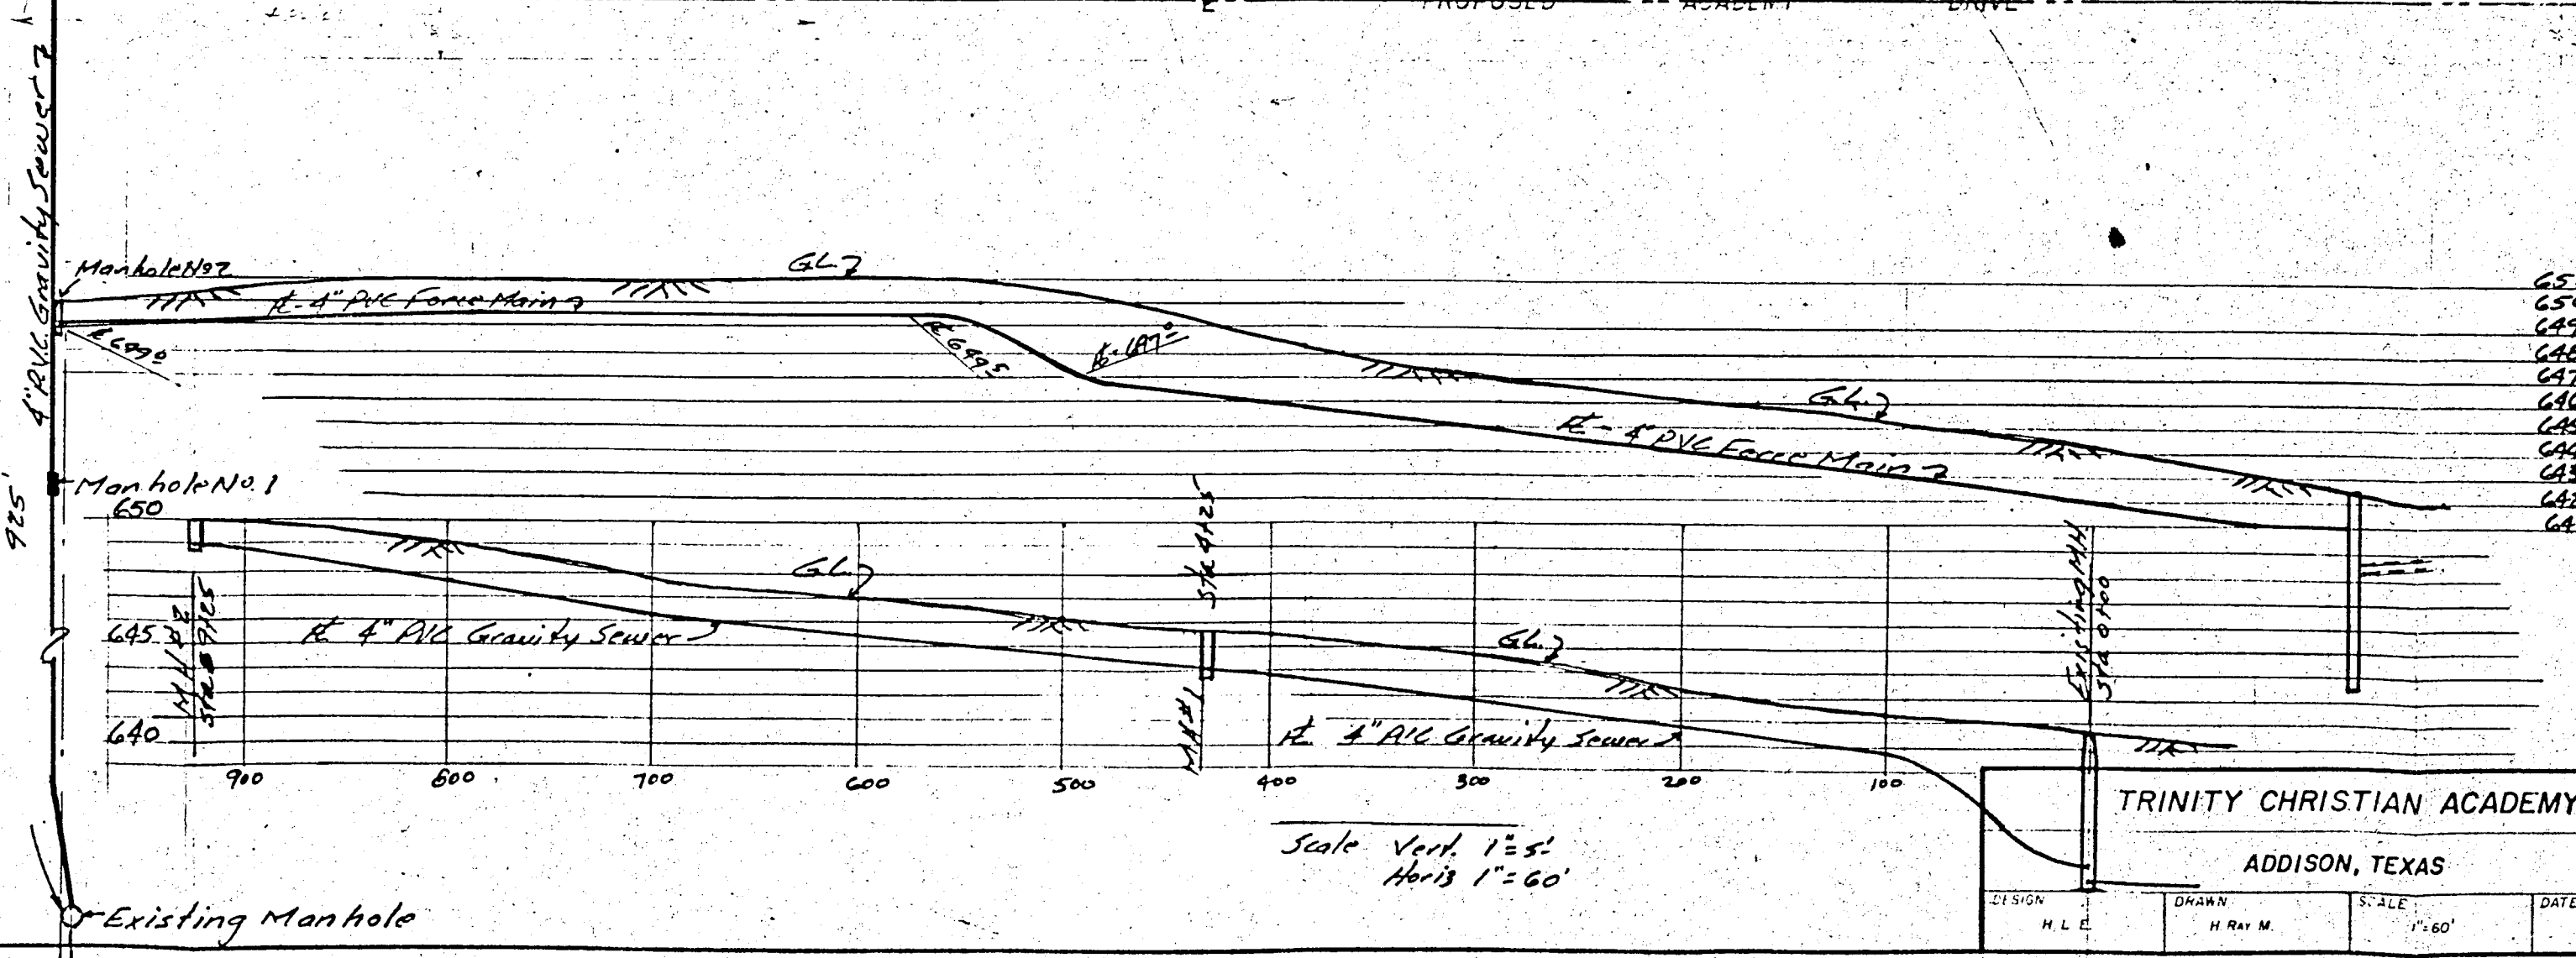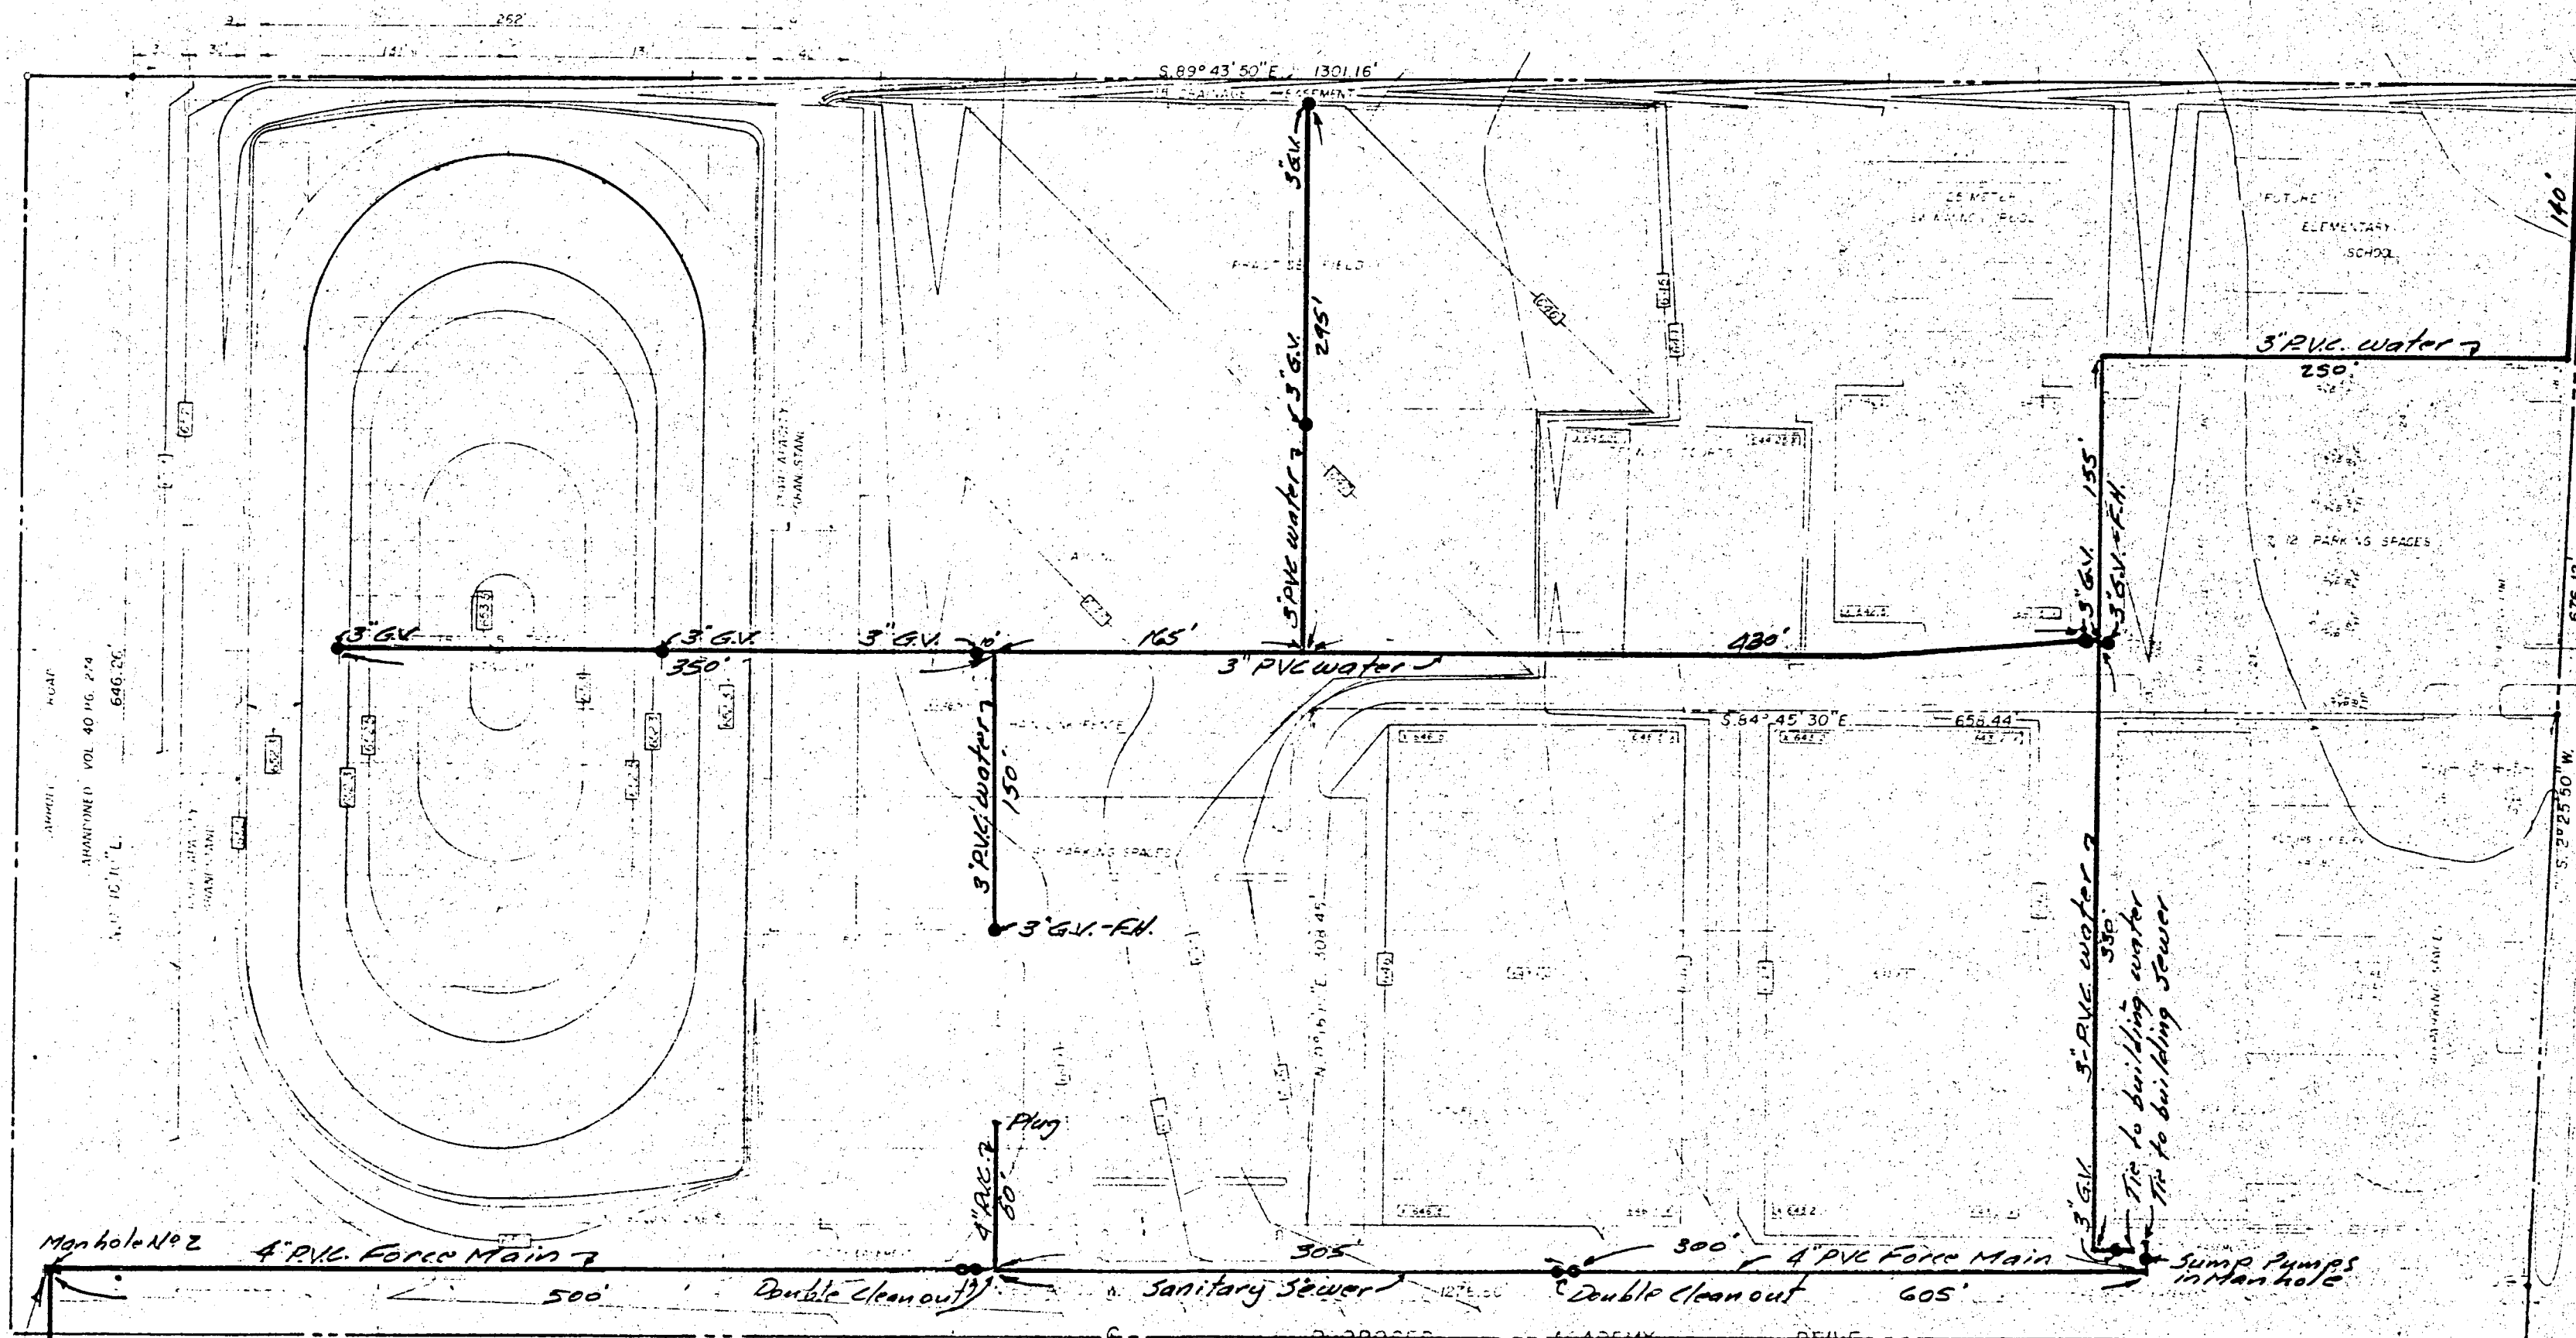

**CITY OF ADDISON
APPROVED**

FOR CONSTRUCTION
24-75



NOTE: CONTRACTOR IS HEREBY INSTRUCTED TO EXERCISE CARE IN READING OR EXCEEDING ALL REQUIREMENTS OF BOTH NATIONAL AND LOCAL CODES AND/OR ORDINANCES APPLICABLE TO HIS WORK. APPROVAL OF THESE DRAWINGS SHALL NOT BE CONSTRUED TO RELIEVE RESPONSIBILITY OR IMPLY VARIANCE TO SUCH CODES.

**TEMPORARY
WATER & SEWER FACILITIES
GRADING PLAN**

TRINITY CHRISTIAN ACADEMY

ADDISON, TEXAS

DESIGN H. L. E.	DRAWN H. RAY M.	SCALE 1"=60'	DATE 9-75
--------------------	--------------------	-----------------	--------------

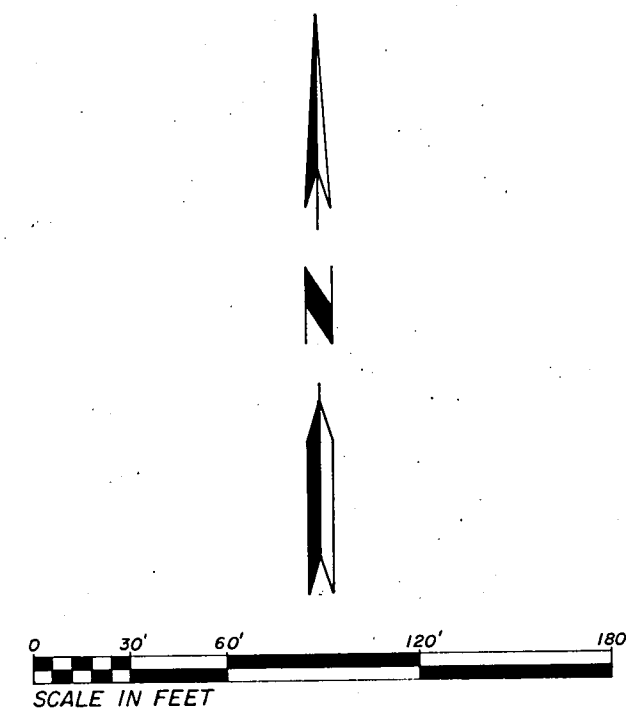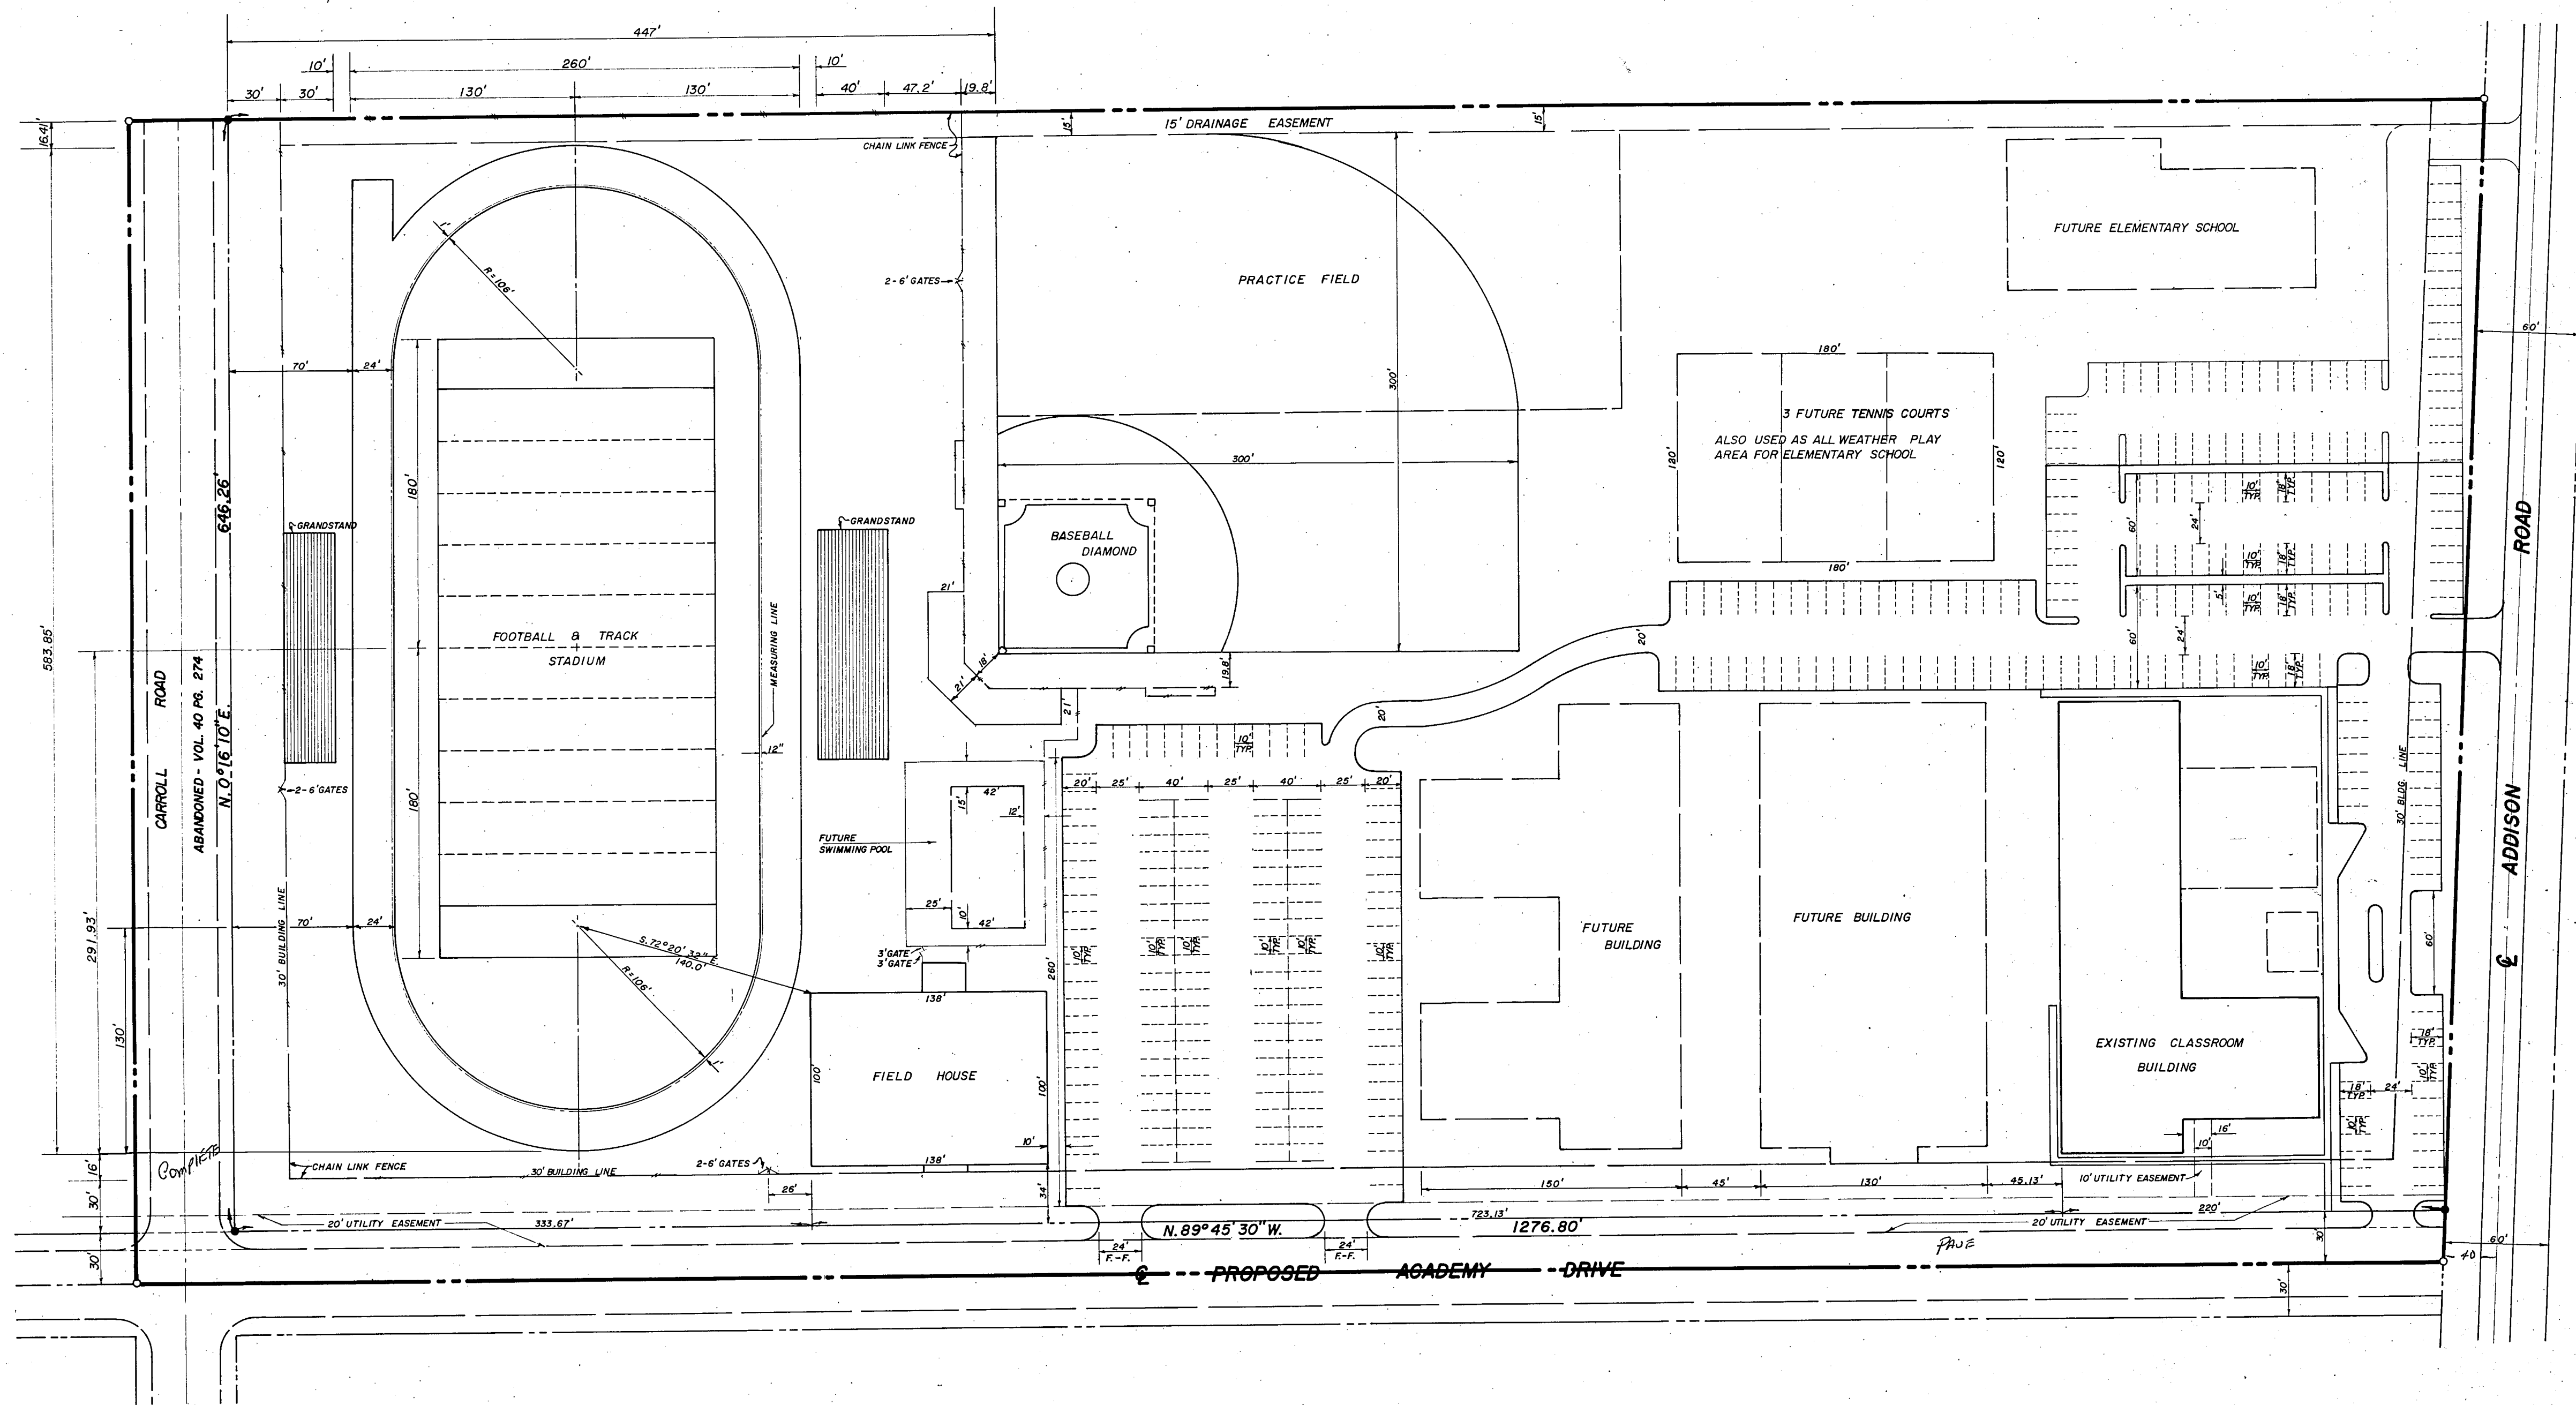

TRINITY CHRISTIAN ACADEMY				SITE PLAN
ADDISON, TEXAS				
DESIGN: H. L. E.	DRAWN: H. RAY M.	SCALE: 1" = 60'	DATE: 1-76	328-8/33 HAROLD L. EVANS CONSULTING ENGINEER