

REFER TO SHEET 16.13 FOR PLUMBING SYMBOL LEGEND.  
 REFER TO SHEETS 16.11 & 16.12 FOR PLUMBING RISER DIAGRAM.  
 REFER TO SHEET 16.13 FOR PLUMBING CONNECTION SCHEDULES.  
 REFER TO SHEET 16.14 FOR PLUMBING DETAILS.




**S·B**

SCOTT·BALLEW·INC

ARCHITECTURE·DESIGN·PLANNING

214-252-0883  
 FAX 214-252-0889

3511 CEDAR SPRINGS - SUITE THREE  
 DALLAS - TX 75219

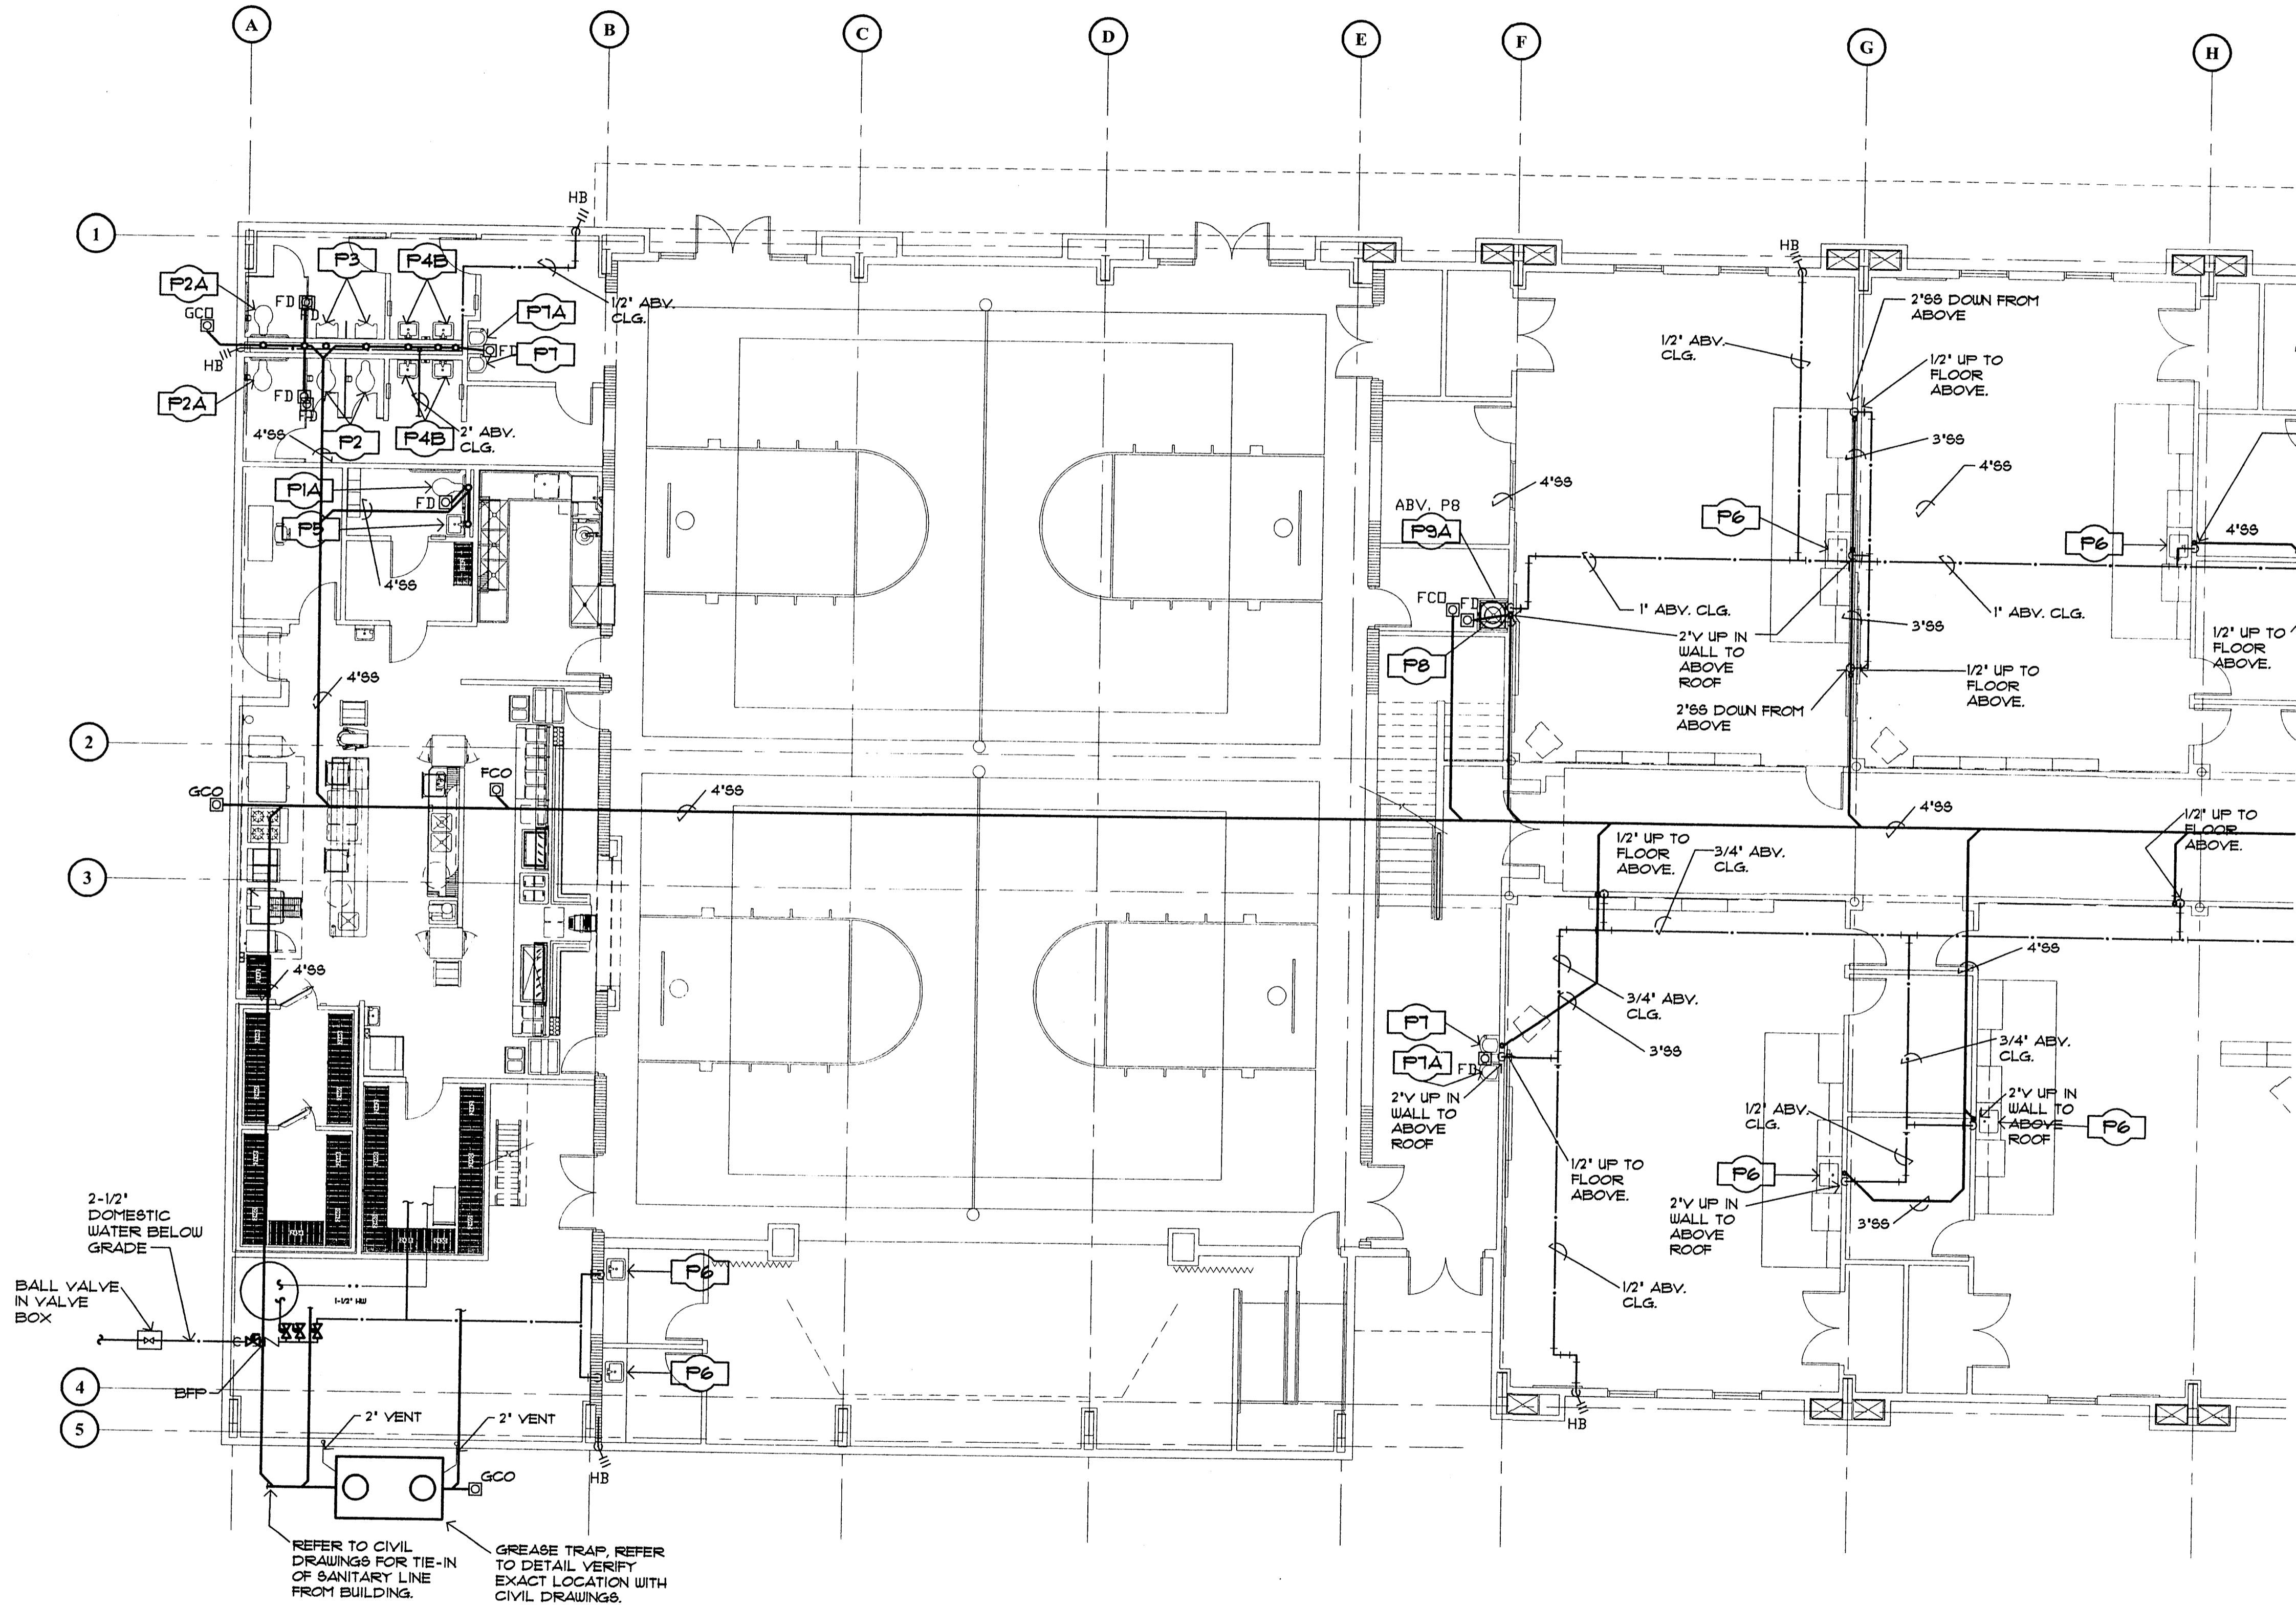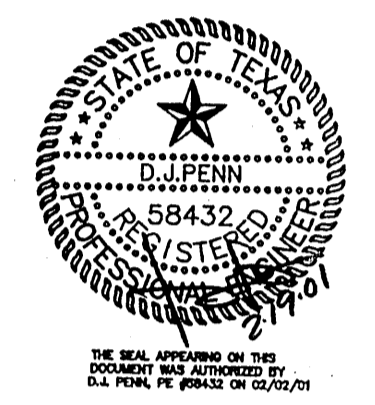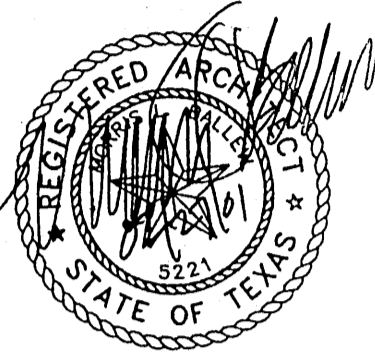

2-1/2\"/>

REFER TO CIVIL DRAWINGS FOR TIE-IN OF SANITARY LINE FROM BUILDING.  
 GREASE TRAP, REFER TO DETAIL VERIFY EXACT LOCATION WITH CIVIL DRAWINGS.



**01 1ST FLR PLUMBING PLAN - AREA 'C'**

1/8" = 1'-0"

A NEW  
**TRINITY LOWER SCHOOL**  
 TRINITY CHRISTIAN ACADEMY  
 ADDISON, TEXAS  
 1ST FLR PLUMBING PLAN - AREA 'C'

SBI Project No.:	9924
Date:	09-19-2000
Issue:	S.D. Prebid Set
Drawn By:	B.F. SW5
Checked By:	D.P.
Revisions:	02/19/01

SHEET

**16.03**

**dp** DON PENN CONSULTING ENGINEERS  
 3950 HIGHWAY 360, SUITE 101  
 GRAPEVINE, TEXAS 76051  
 817-410-2855 FAX 817-251-8444