


Addison![®]

5430 LBJ Freeway
Suite 400
Dallas TX 75240
Telephone 214.273.1500
Facsimile 214.273.1505

Gensler

Issue	Date & Issue Description	By	Check
-------	--------------------------	----	-------

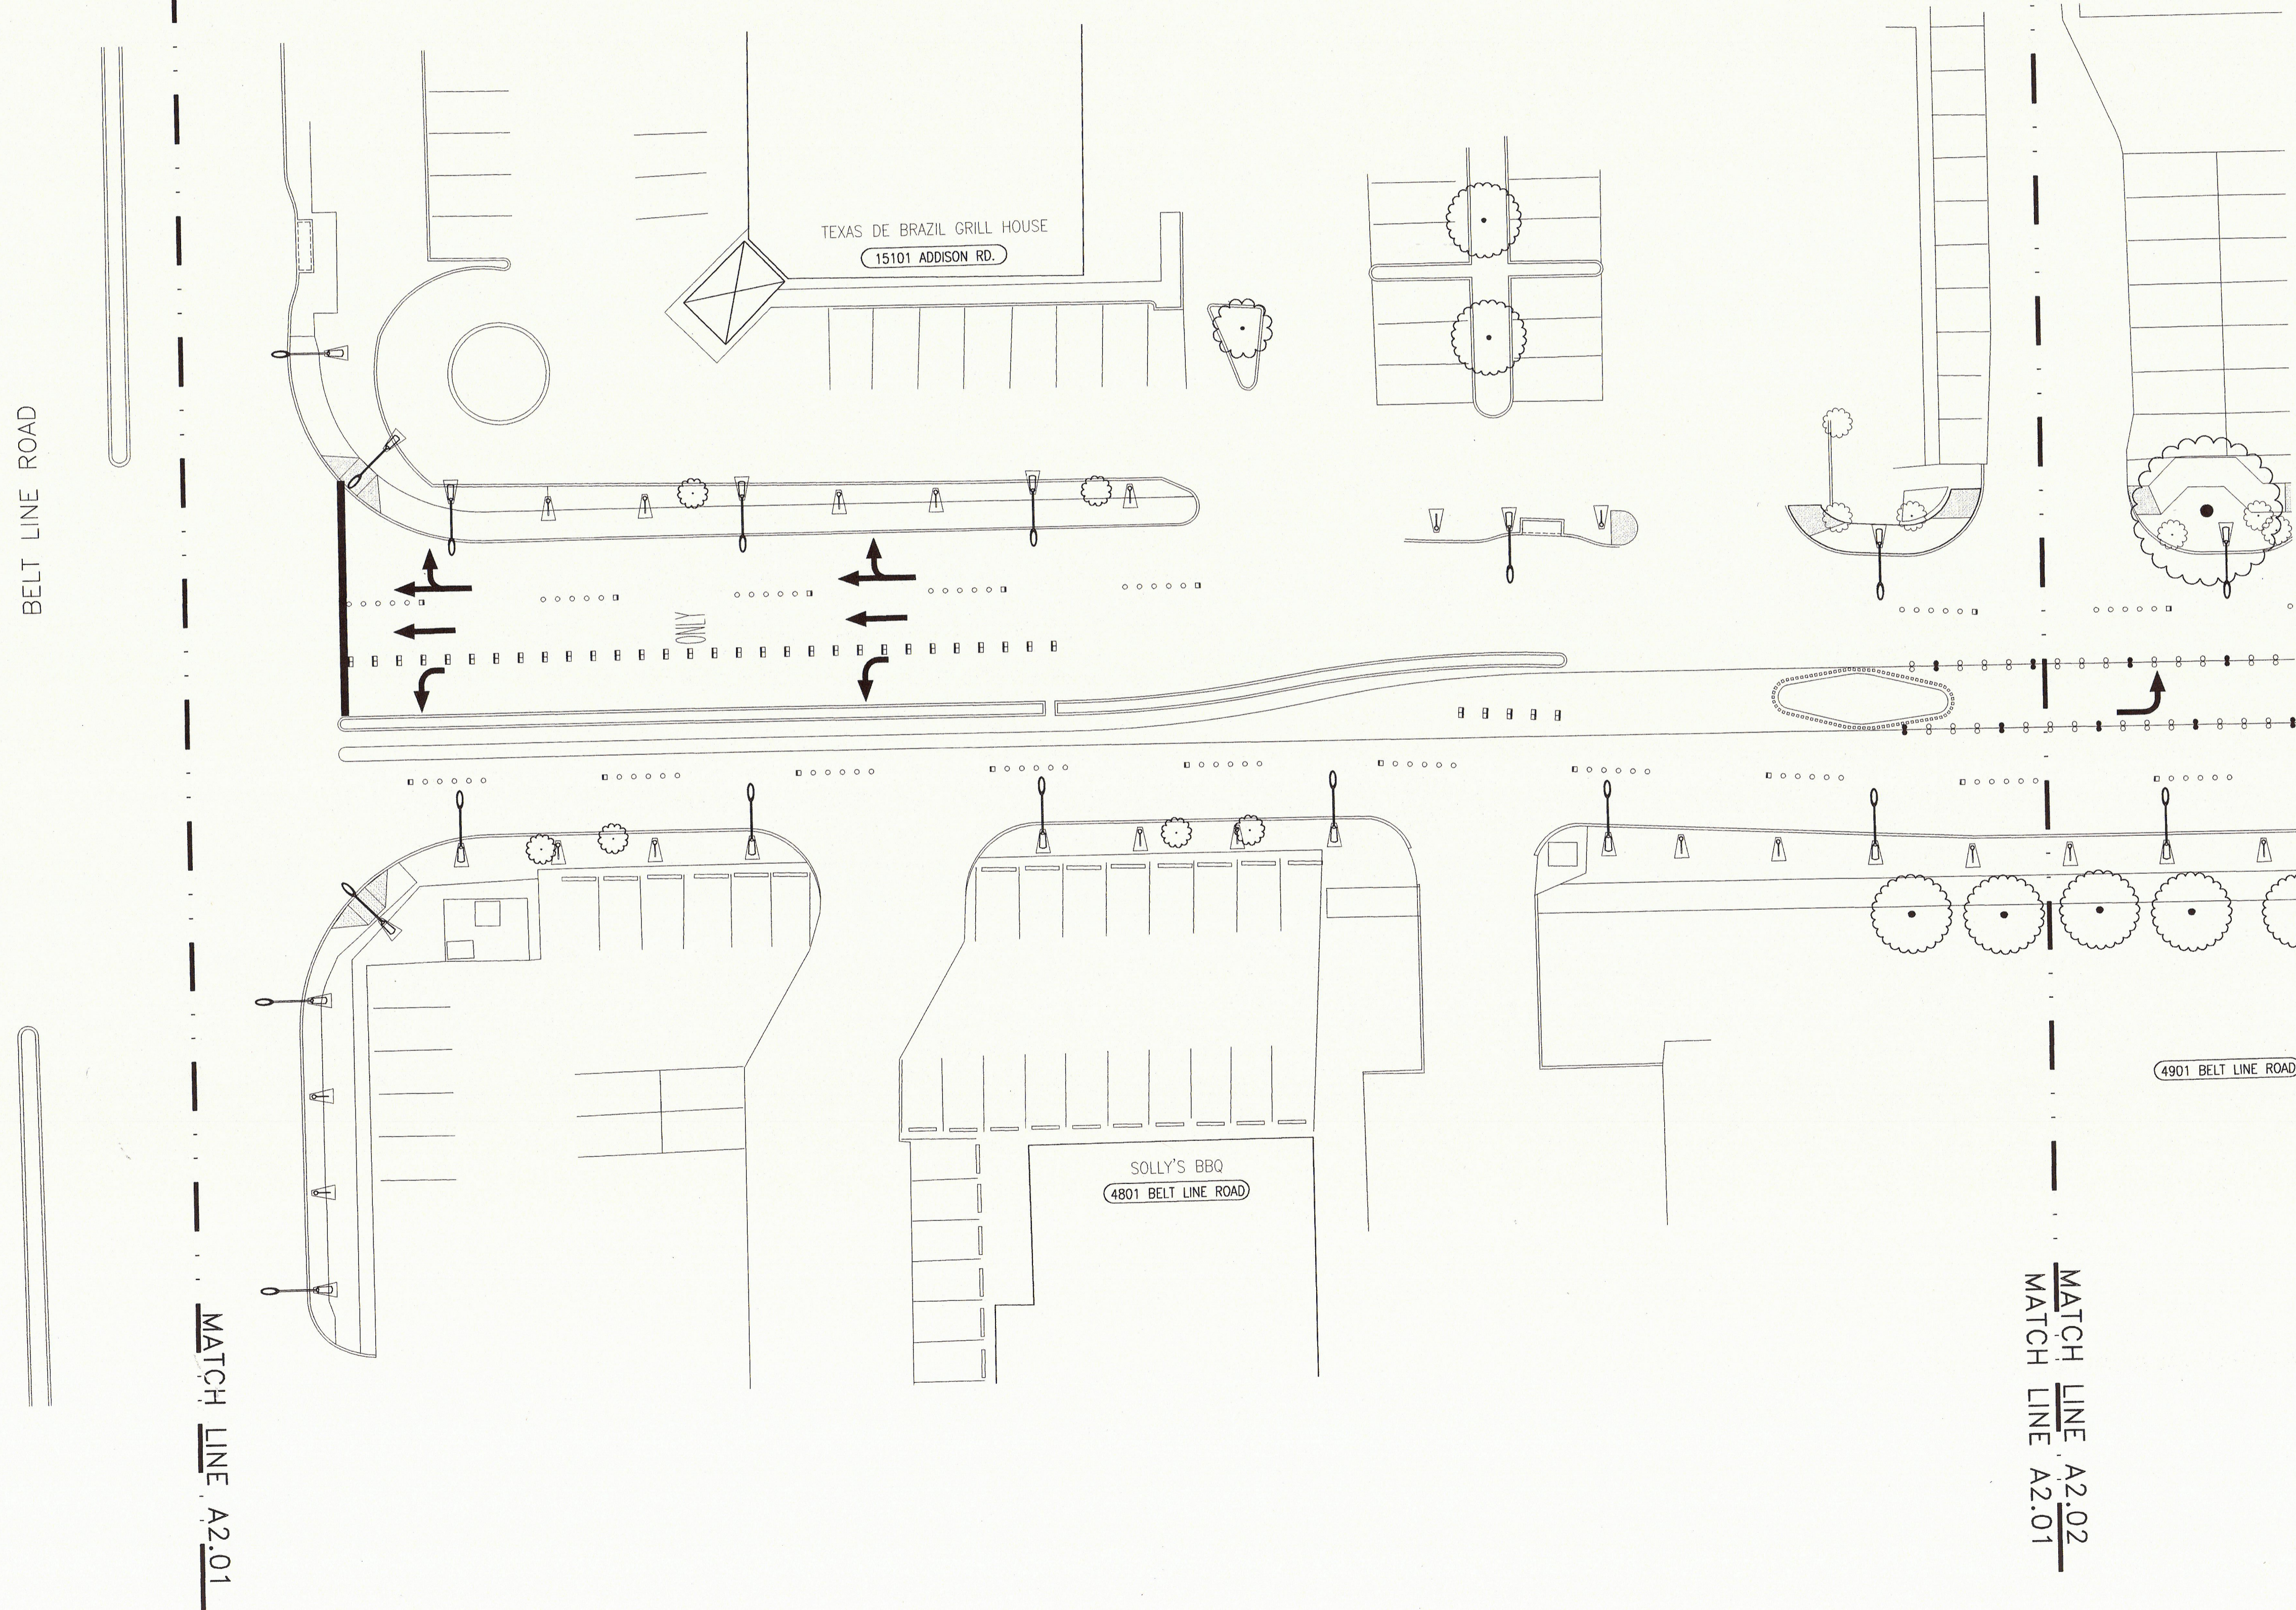

Seal/Signature

PRELIMINARY

 
Project Name
**TOWN OF ADDISON
LIGHTING MASTER PLAN**

Project Number
00.9627.000

CAD File Name

Description
LIGHTING PLAN
PART ONE

Scale



A2.01

©2003 Gensler

ENLARGED PLAN - PART 1
SCALE: 1" = 20'-0"

01