




5430 LBJ Freeway
Suite 400
Dallas TX 75240
Telephone 214.273.1500
Facsimile 214.273.1505

Gensler

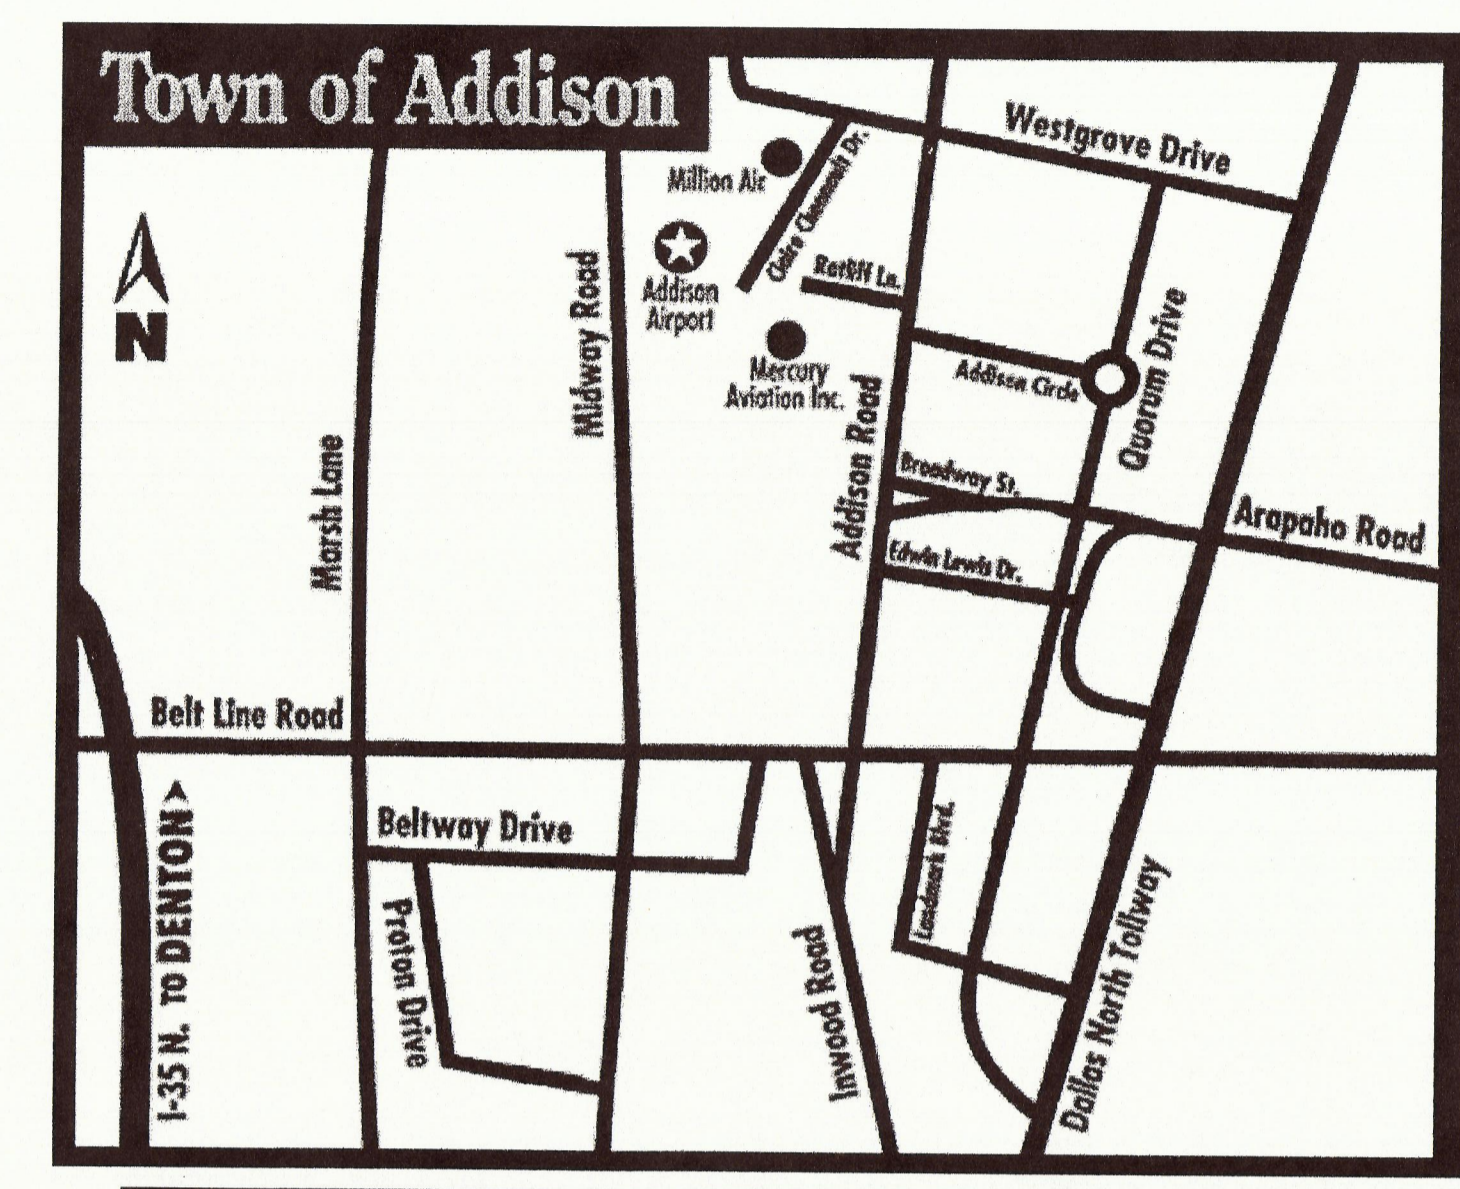

TOWN PLAN
SCALE: N.T.S.

Issue	Date & Issue Description	By	Check

Seal/Signature


PRELIMINARY

Project Name
TOWN OF ADDISON
LIGHTING MASTER PLAN

Project Number
00.9627.000

CAD File Name

Description
LIGHTING PLAN
OVERALL MASTER PLAN

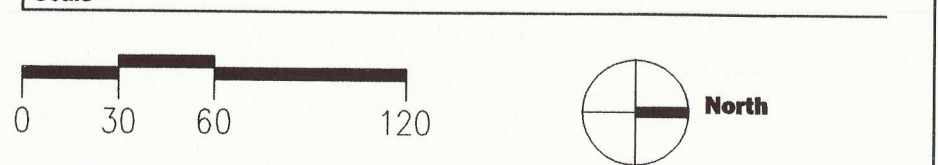

A1.00

