


| ESTIMATED QUANTITIES |                           |      |          |
|----------------------|---------------------------|------|----------|
| ITEM                 | DESCRIPTION               | UNIT | QUANTITY |
| 17                   | Y-Type Inlet              | EA   | 2        |
| 30                   | 30" R.C.P.                | L.F. | 110      |
| 38                   | 42" R.C.P.                | L.F. | 245      |
| 27                   | 48" R.C.P.                | L.F. | 175      |
| 31                   | 24" R.C.P.                | L.F. | 30       |
| 19                   | INLETS (8' Std. Recessed) | EA   | 2        |
| 1                    | Remove Old Conc.          | EA   | 6        |
| 33                   | Relocate San. Sewer (6')  | L.F. | 600      |
| 35                   | Adjust Water Lines        | EA   | 5        |
| 36                   | Adjust Valve Boxes        | EA   | 2        |
| 39                   | Relocate F.H.             | EA   | 1        |

- LEGEND**
- ⊙ Bench Mark
  - ⊕ Hub and Tee
  - ⊖ Manhole
  - ⊗ Monument
  - ⊘ Gas Meter
  - ⊙ Gas Valve
  - ⊙ Gas Line
  - ⊙ Power Pole (typical pole symbol)
  - ⊙ Power Line
  - ⊙ Guy Wrench Anchor
  - ⊙ Telephone Cable Box or Pole
  - ⊙ Telephone Line
  - ⊙ Water Meter
  - ⊙ Water Valve
  - ⊙ Water Line
  - ⊙ Fire Hydrant
  - ⊙ Water Sprig
  - ⊙ Manhole
  - ⊙ Cleanout
  - ⊙ Storm Sewer
  - ⊙ Sanitary Sewer Line
  - ⊙ Storm Sewer Line
  - ⊙ Fence Line
  - ⊙ Flow Direction Indicated
  - ⊙ Property or Right-of-Way Line
  - ⊙ Easement Line

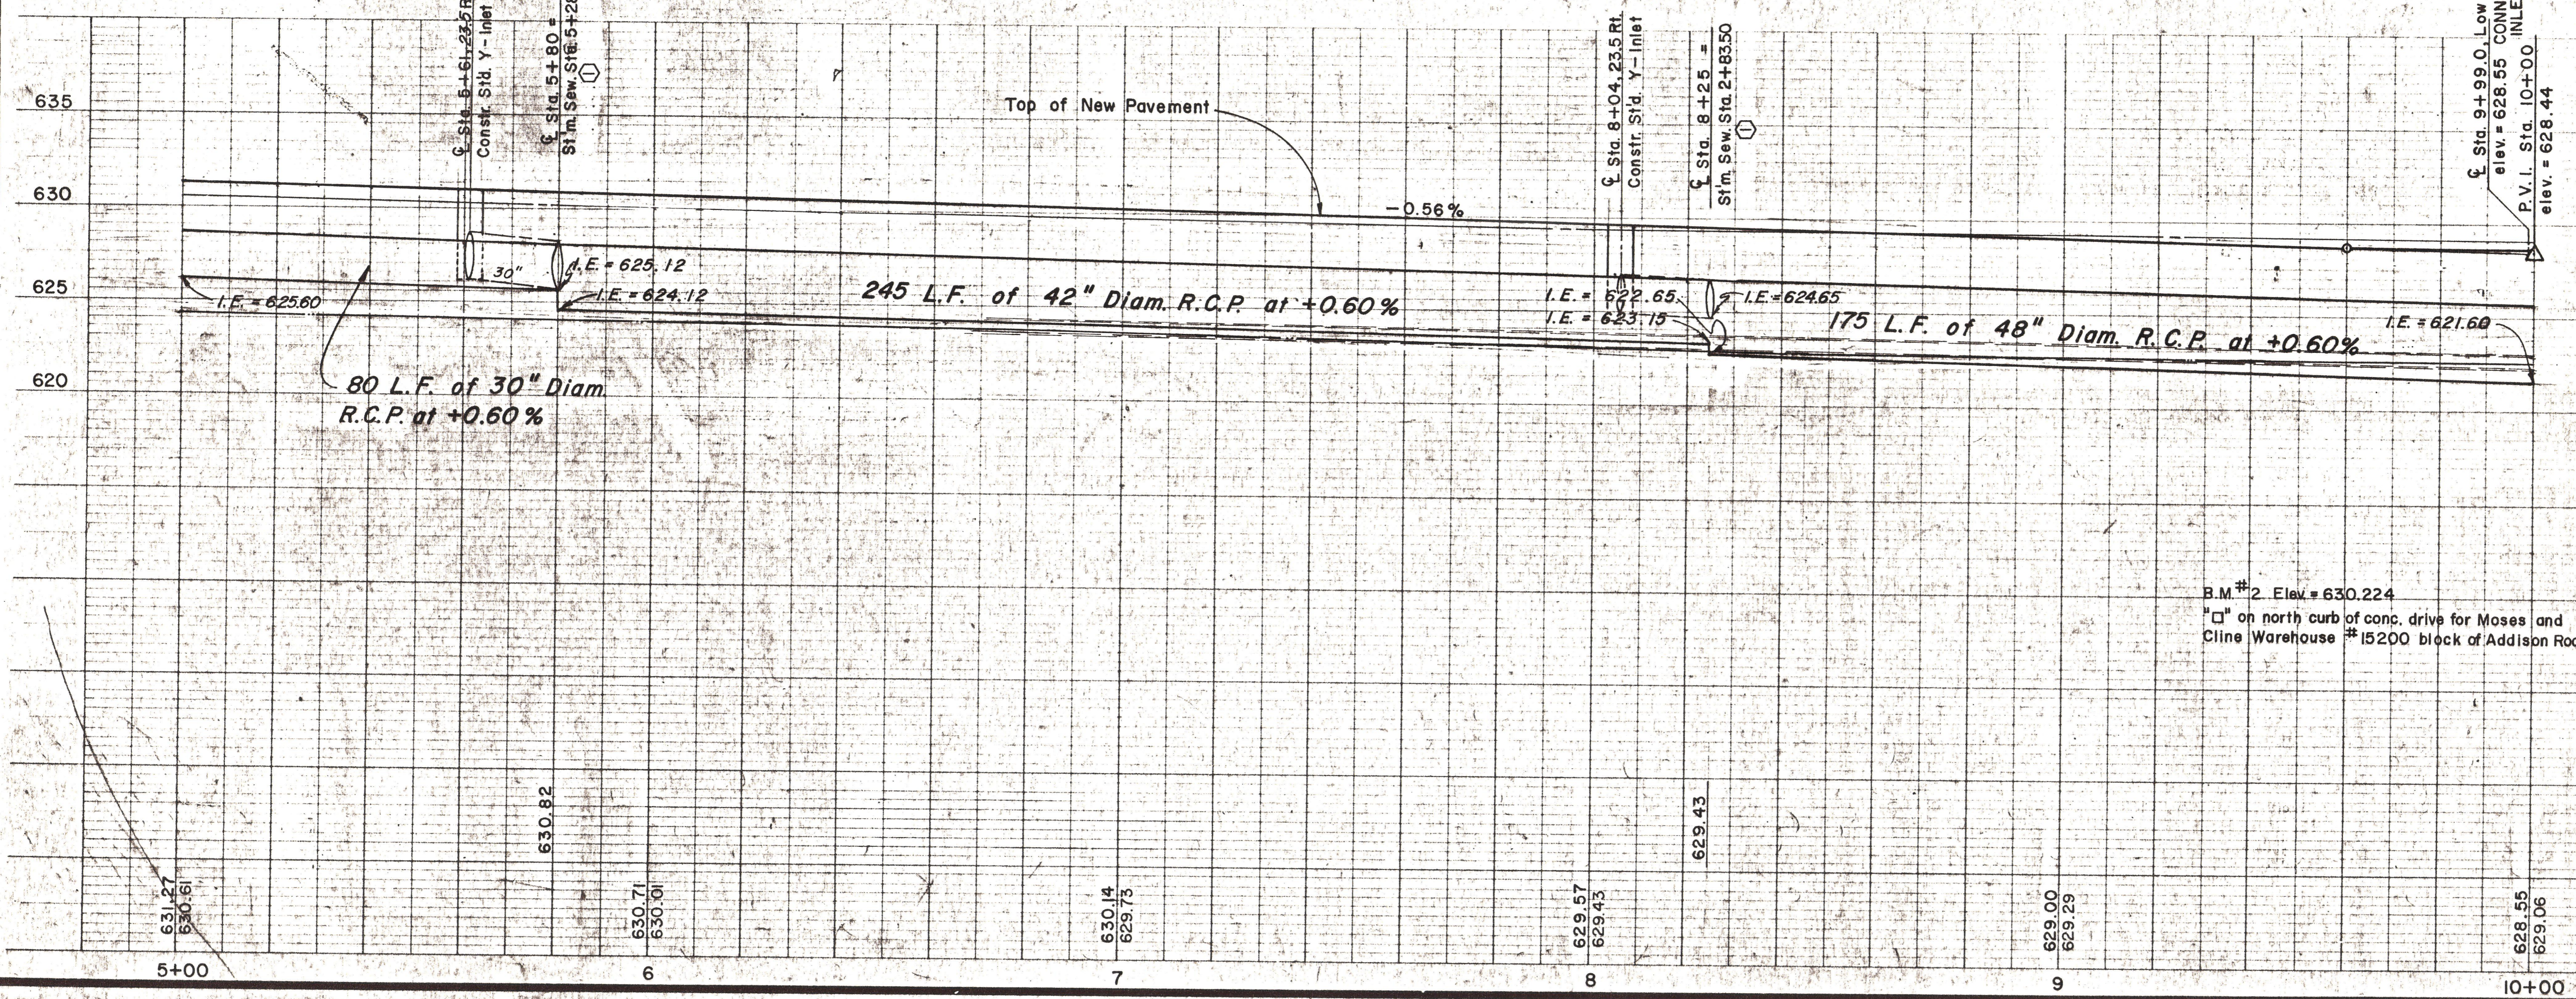

Scales: 1" = 20', Horizontal  
1" = 5', Vertical

B.M. #2 Elev. = 630.224  
 "□" on north curb of conc. drive for Moses and Cline Warehouse #15200 block of Addison Road.

Record Set 5/8/68

|                         |          |              |
|-------------------------|----------|--------------|
| ⊙ Delete Junction Boxes | REVISION | B.S. 2/14/78 |
| NO.                     | BY       | DATE         |

CITY OF ADDISON  
 DALLAS COUNTY, TEXAS

ADDISON ROAD  
 STA. 5+00 TO STA. 10+00

STORM SEWER  
 PLAN AND PROFILE

GINN INC.  
 CONSULTING ENGINEERS DALLAS, TEXAS

DESIGNED BY: H.W.S. SCALE: As Shown  
 DRAWN BY: B.J.S. DATE: Sheet 35 of