



ESTIMATED QUANTITIES			
ITEM	DESCRIPTION	UNIT	QUANTITY
32	18" R.C.P.	L.F.	155
28	42" R.C.P.	L.F.	500
19	Recessed Curb-Type Inlet	EA.	2
17	Std. Y-Type Inlet	EA.	2
	Remove Conc.	EA.	5
38	8" W.L.	EA.	2
36	ADJUST VALVE BOXES	EA.	2
39	RELOCATE F.H.	EA.	1
13	MISC. CONC.	C.Y.	5

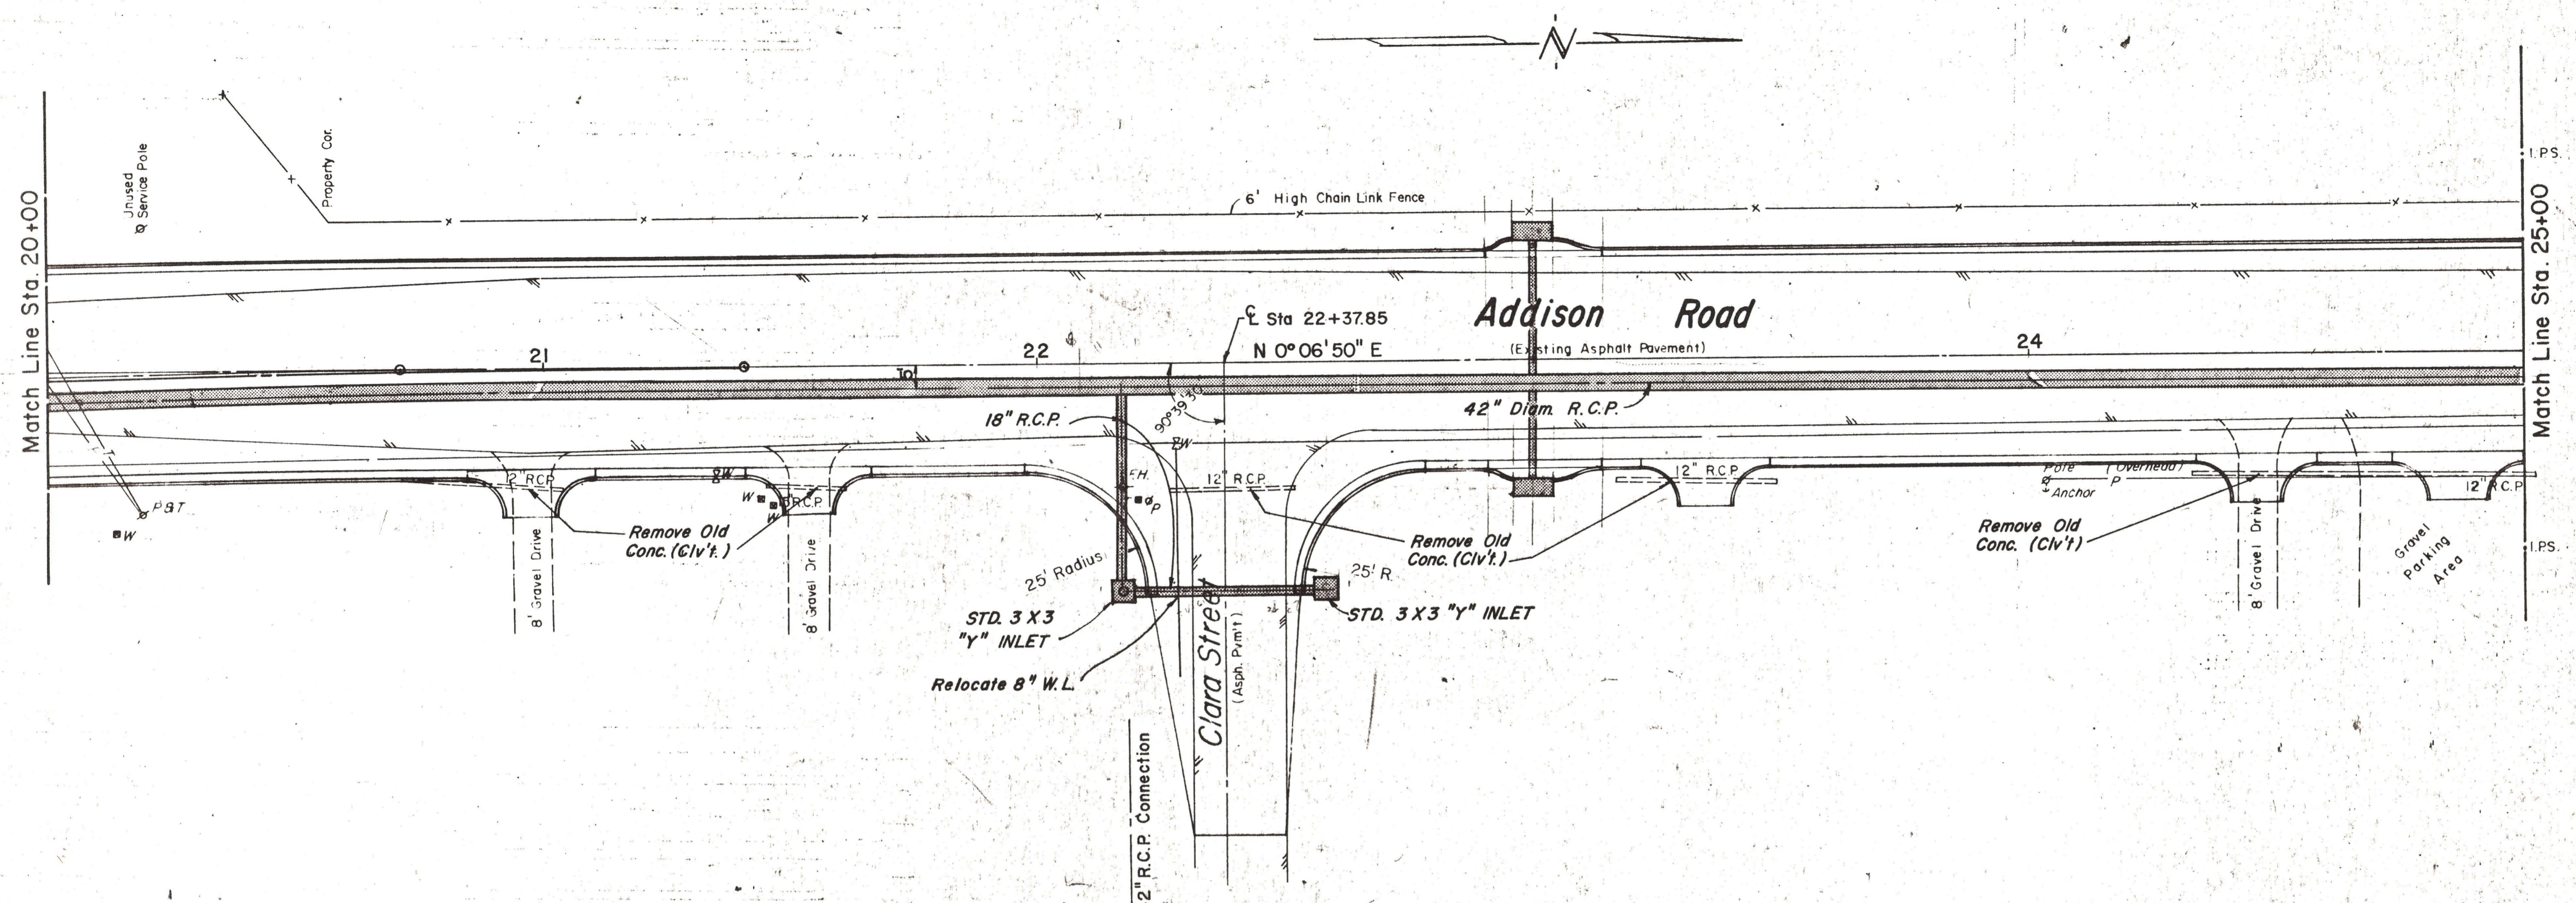

LEGEND

- Bench Mark
- Hub and Tack
- Iron Pin
- Monument
- Gas Meter
- Gas Valve
- Gas Line
- Power Pole (typical pole symbol)
- Power Line
- Guy Wire and Anchor
- Telephone Cable Box, or Riser
- Water Meter
- Water Valve
- Water Line
- Fire Hydrant
- Water Spigot
- Manhole
- Cleanout
- Drainage Inlet
- Sanitary Sewer Line
- Storm Sewer Line
- Fence Line
- Flow Direction Indicator
- Property or Right-of-Way Line
- Easement Line

Scales: 1" = 20', Horizontal
1" = 5', Vertical

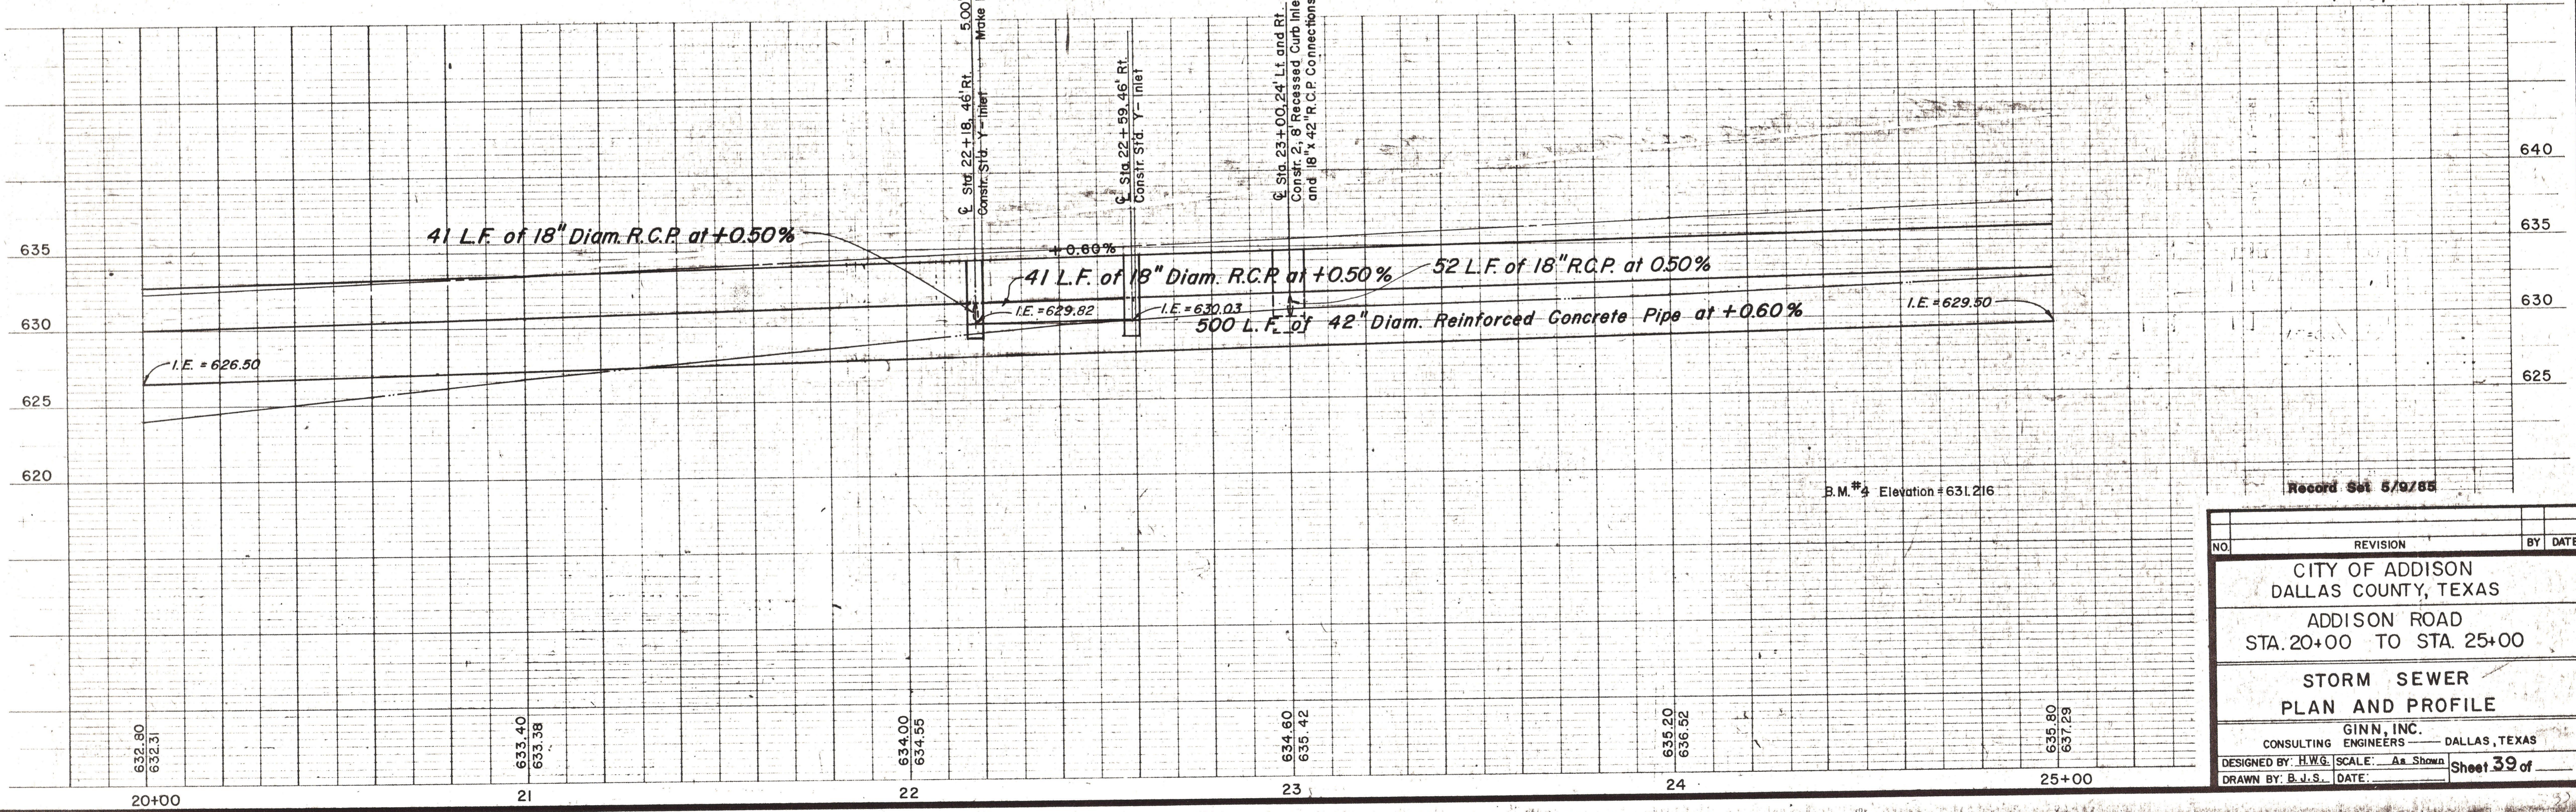

NO.	REVISION	BY	DATE
CITY OF ADDISON DALLAS COUNTY, TEXAS ADDISON ROAD STA. 20+00 TO STA. 25+00 STORM SEWER PLAN AND PROFILE			
GINN, INC. CONSULTING ENGINEERS - DALLAS, TEXAS			
DESIGNED BY: H.W.G.		SCALE: As Shown	
DRAWN BY: B.J.S.		DATE:	
Sheet 39 of			