
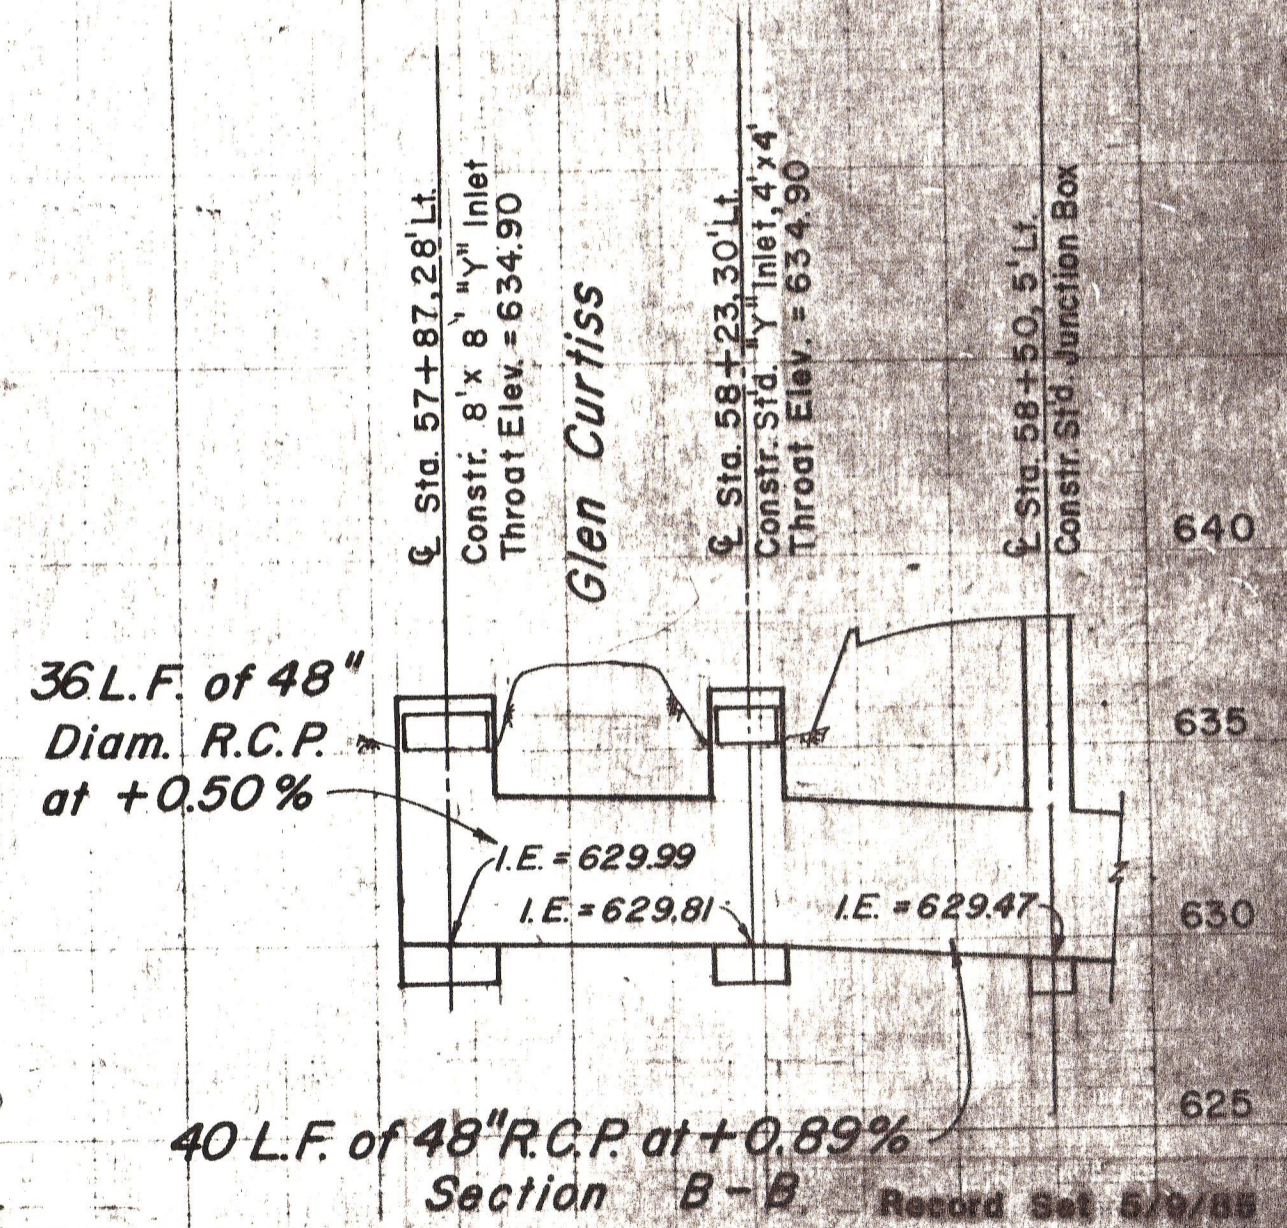


ESTIMATED QUANTITIES			
ITEM	DESCRIPTION	UNIT	QUANTITY
27	48" R.C.P.	L.F.	226
23	84" R.C.P.	L.F.	490
17	Y-Type Inlet	EA	2
1	REMOVE CONC.	EA	1

LEGEND

- Bench Mark
- ⊕ Hub and Tack
- ⊕ Iron Pin
- ⊕ Monument
- ⊕ Gas Meter
- ⊕ Gas Valve
- ⊕ Gas Line
- ⊕ Power Pole (typical pole symbol)
- ⊕ Guy Wire and Anchor
- ⊕ Telephone Cable Box, or Box
- ⊕ Telephone Line
- ⊕ Water Meter
- ⊕ Water Valve
- ⊕ Water Line
- ⊕ Fire Hydrant
- ⊕ Water Spigot
- ⊕ Manhole
- ⊕ Cleanout
- ⊕ Drainage Inlet
- ⊕ Sanitary Sewer Line
- ⊕ Storm Sewer Line
- ⊕ Fence Line
- ⊕ Flow Direction Indicator
- ⊕ Property or Right-of-Way Line
- ⊕ Exemant Line

Scales: 1" = 20' Horizontal
1" = 5' Vertical

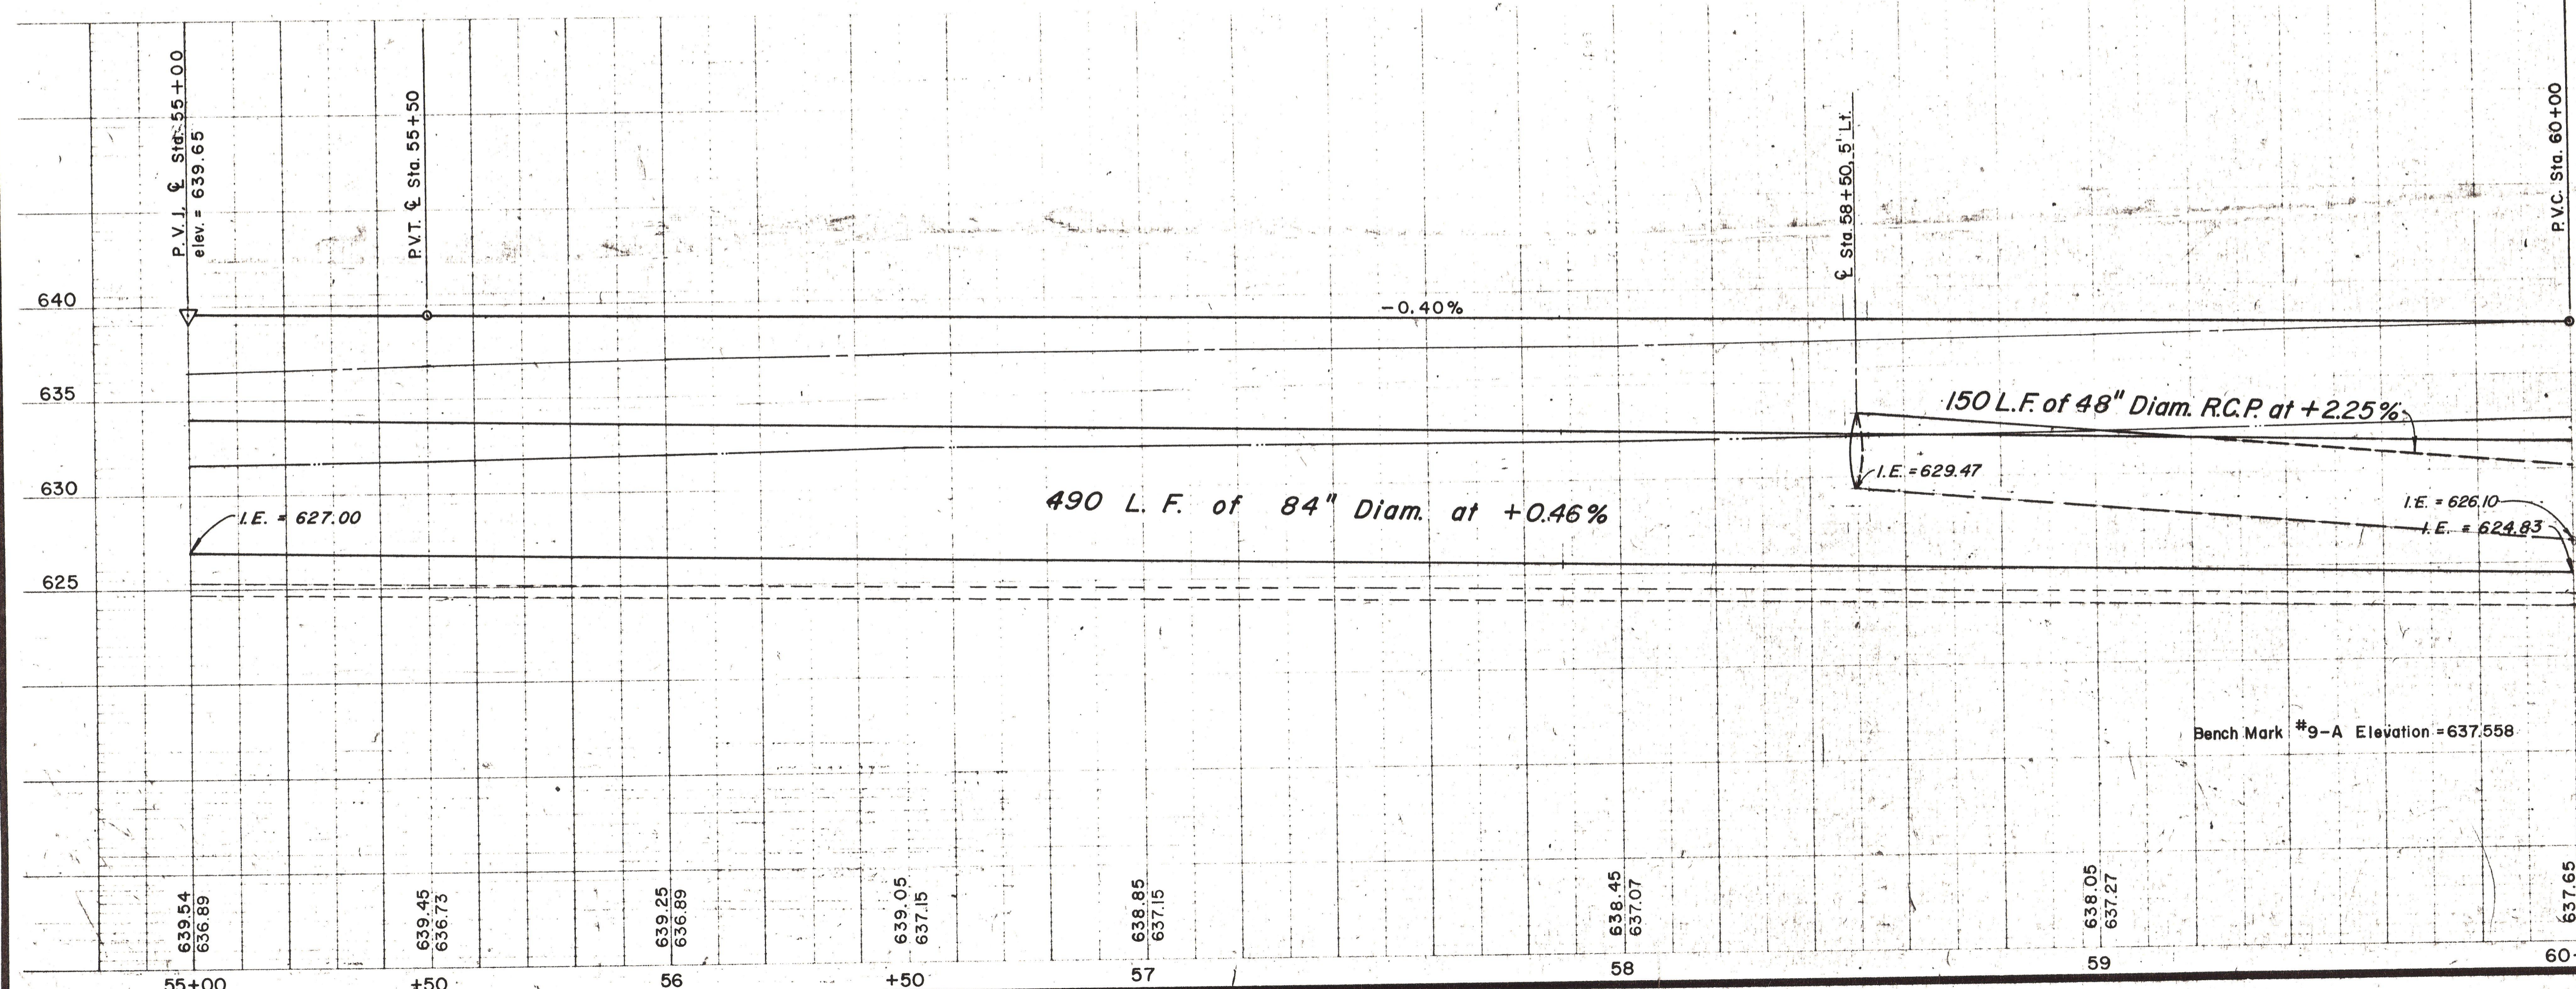

PT. Sta. Change, Delete Junction Box
NO. REVISION BY DATE

CITY OF ADDISON
DALLAS COUNTY, TEXAS

ADDISON ROAD
STA. 55+00 TO STA. 60+00

**STORM SEWER
PLAN AND PROFILE**

GINN, INC.
CONSULTING ENGINEERS JALLAS, TEXAS

DESIGNED BY: H.W.G. SCALE: As Shown
DRAWN BY: B.J.S. DATE: Sheet 16 of