


ESTIMATED QUANTITIES			
ITEM	DESCRIPTION	UNIT	QUANTITY
1	Remove Old Conc.	Ea.	3

- LEGEND**
- Bench Mark
 - Hub and Tank
 - Iron Pin
 - C.C.M. Manhole
 - Gas Meter
 - Gas Valve
 - Gas Line
 - Power Pole (typical pole symbol)
 - Power Line
 - Guy Wire and Anchor
 - Telephone Cabinet Box, or Riser
 - Telephone Line
 - Water Meter
 - Water Valve
 - Water Line
 - Fire Hydrant
 - Water Spigot
 - Manhole
 - Cleanout
 - Drainage Inlet
 - Sanitary Sewer Line
 - Storm Sewer Line
 - Fence Line
 - Flow Direction Indicator
 - Property or Right-of-Way Line
 - Easement Line

Scales : 1" = 20' Horizontal
1" = 5' Vertical

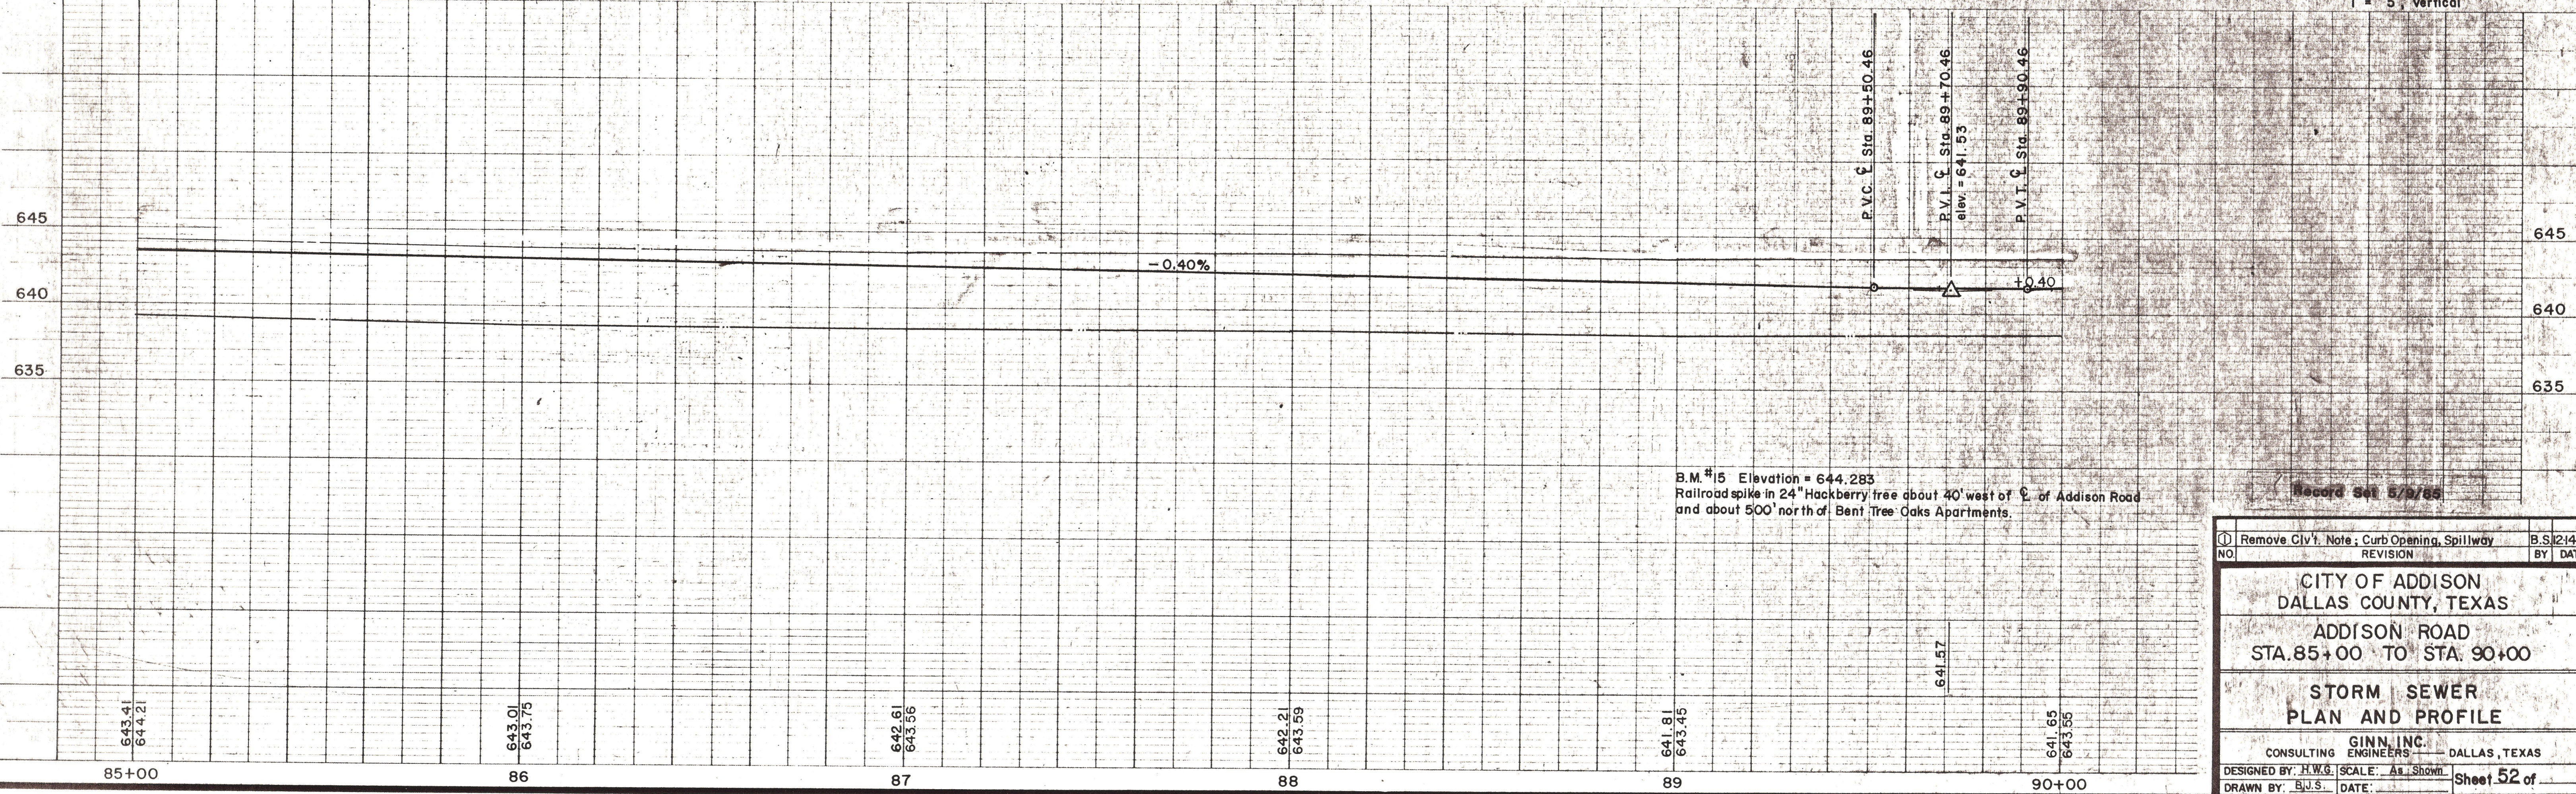

Record Set 5/9/85

NO.	REVISION	BY	DATE
1	Remove Civ't. Note : Curb Opening, Spillway		B.S.121478

**CITY OF ADDISON
DALLAS COUNTY, TEXAS**

**ADDISON ROAD
STA. 85+00 TO STA. 90+00**

**STORM SEWER
PLAN AND PROFILE**

CONSULTING ENGINEERS: GINN, INC. DALLAS, TEXAS
DESIGNED BY: H.W.G. SCALE: As Shown
DRAWN BY: B.J.S. DATE: Sheet 52 of 52