


ITEM	ESTIMATED DESCRIPTION	QUANTITIES	
		UNIT	QUANTITY
	NONE		

- LEGEND**
- Bench Mark
  - ⊕ Hub and Tack
  - ⊕ Iron Pin
  - ⊕ Monument
  - ⊕ Gas Meter
  - ⊕ Gas Valve
  - ⊕ Gas Line
  - ⊕ Power Pole (typical pole symbol)
  - ⊕ Power Line
  - ⊕ Guy Wire and Anchor
  - ⊕ Telephone Cable Box, or Riser
  - ⊕ Telephone Line
  - ⊕ Water Meter
  - ⊕ Water Valve
  - ⊕ Water Line
  - ⊕ Fire Hydrant
  - ⊕ Water Spigot
  - ⊕ Manhole
  - ⊕ Cleanout
  - ⊕ Drainage Inlet
  - ⊕ Sanitary Sewer Line
  - ⊕ Storm Sewer Line
  - ⊕ Fence Line
  - ⊕ Flow Direction Indicator
  - ⊕ Property or Right-of-Way Line
  - ⊕ Easement Line
- Scales: 1" = 20', Horizontal  
1" = 5', Vertical

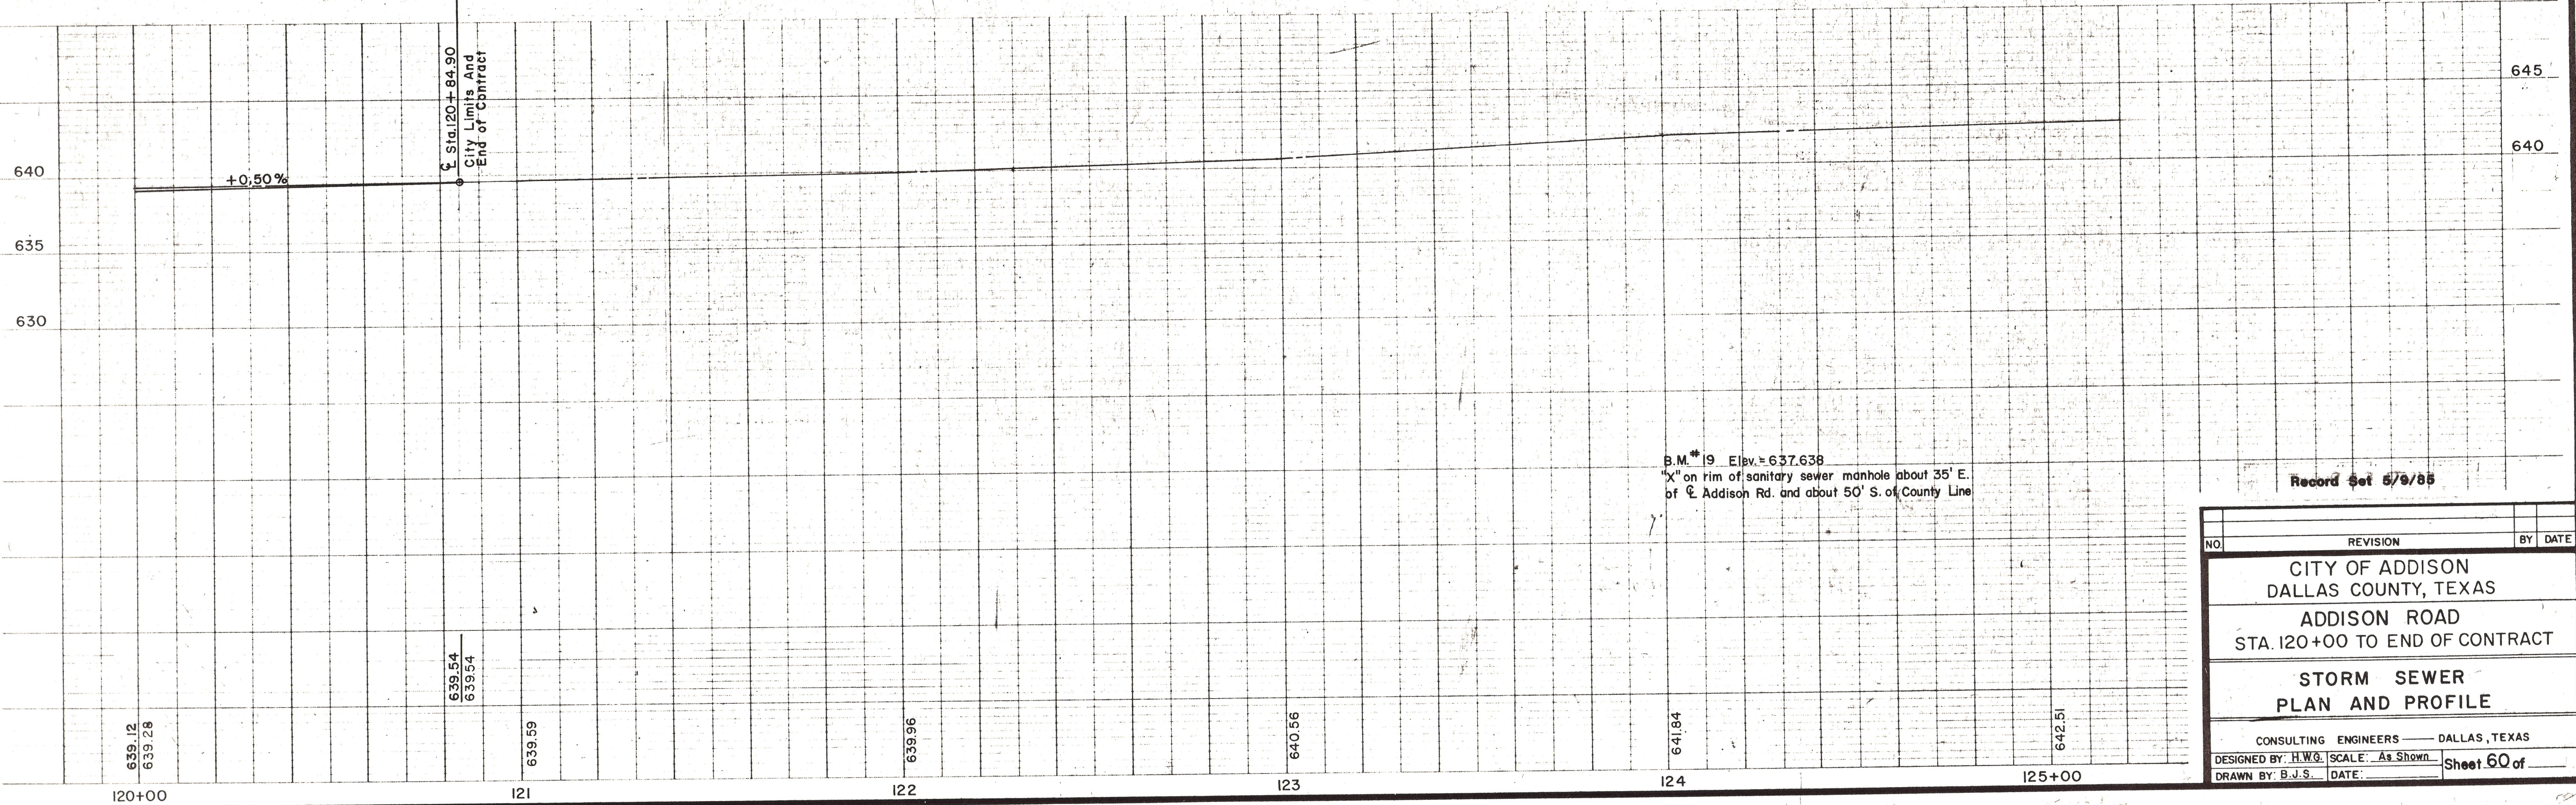

Record Set 6/9/85

NO.	REVISION	BY	DATE

**CITY OF ADDISON  
DALLAS COUNTY, TEXAS  
ADDISON ROAD  
STA. 120+00 TO END OF CONTRACT**

**STORM SEWER  
PLAN AND PROFILE**

CONSULTING ENGINEERS — DALLAS, TEXAS  
DESIGNED BY: H.W.G. SCALE: As Shown Sheet 60 of  
DRAWN BY: B.J.S. DATE: \_\_\_\_\_