
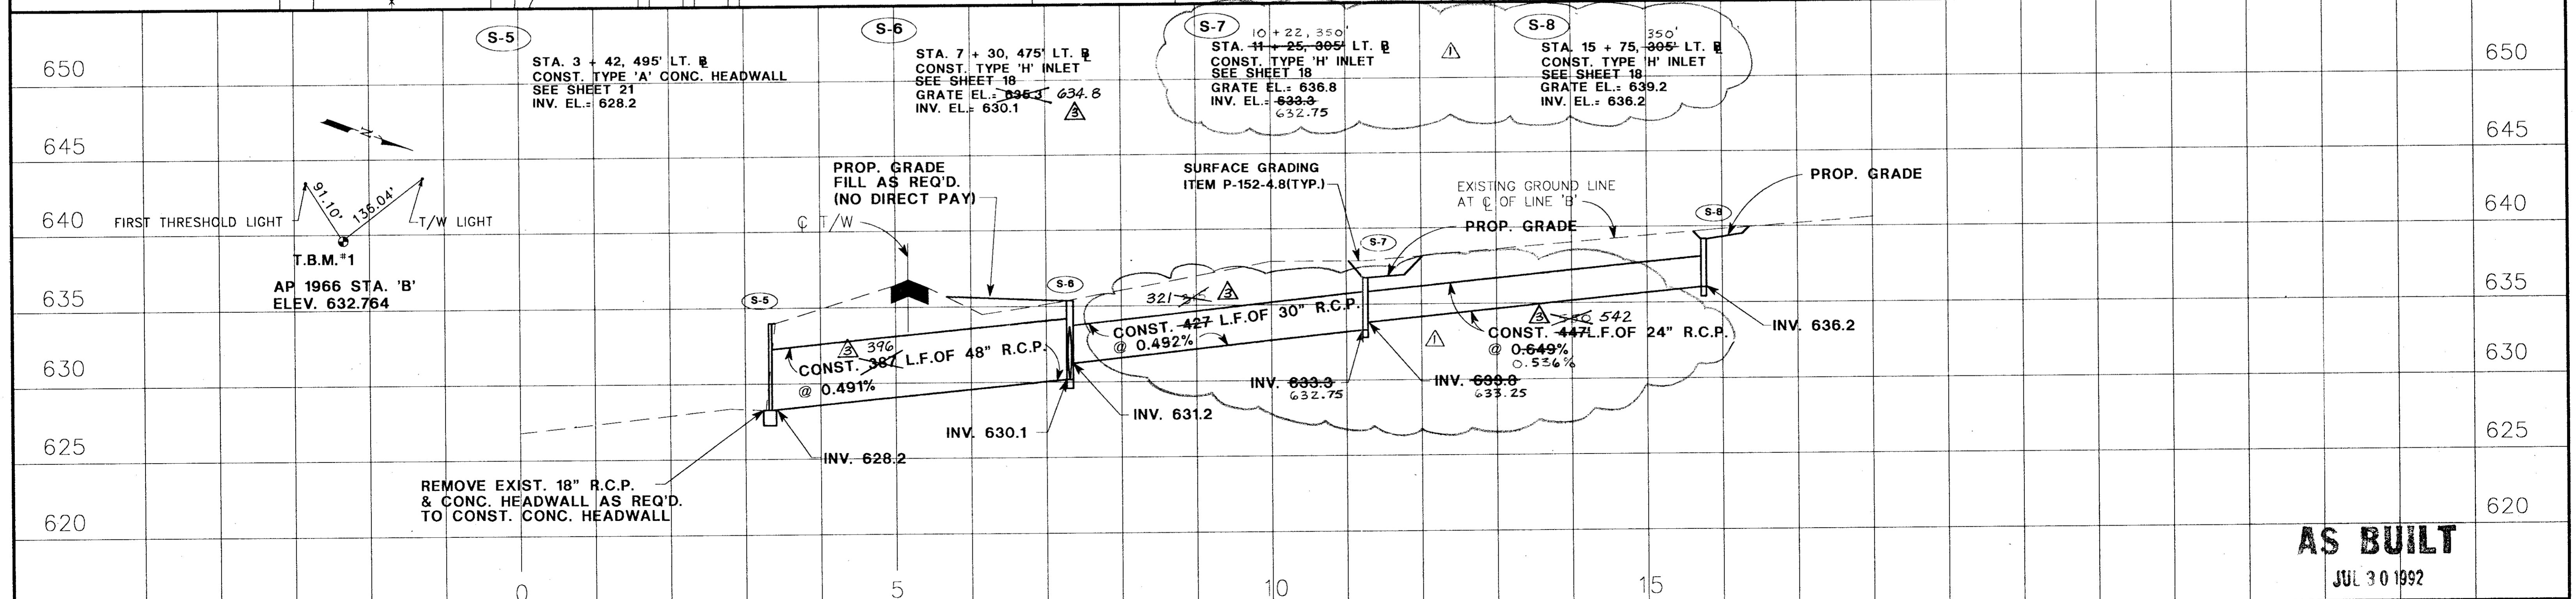
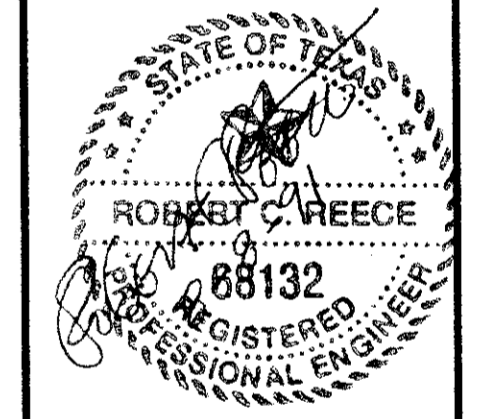


MATCH LINE STA. 25 + 00

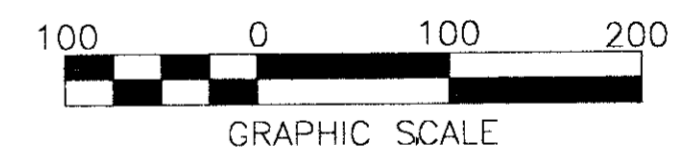

**AS BUILT**  
JUL 30 1992

DESIGN: R.C.R.	A.L.P. NO: 3-48-0063-03-91	2-3-92	MOVE LINE B FROM 70' TO 200' FROM CENTERLINE OF RUNWAY 15-33	J.R.H.
DRAWN: M.J.G.	S.P. NO:	6-30-91	FIELD CHANGE	J.R.H.
CHECKED: D.W.P.	JOB NO: Y8024.22	7-30-92	AS BUILT	J.R.H.
SCALE: 1" = 100' HORIZ. 1" = 5' VERT.	Date	Revisions	By	

**Greiner**  
Greiner, Inc.  
Fort Worth, Texas

Engineers, Architects  
and Planners



# ADDISON AIRPORT

DRAINAGE IMPROVEMENTS  
DRAINAGE LINE "B"  
DRAINAGE PLAN AND PROFILES-STA.7+30 TO STA.15+75

SHEET 6  
DATE: SEPT. 1991