
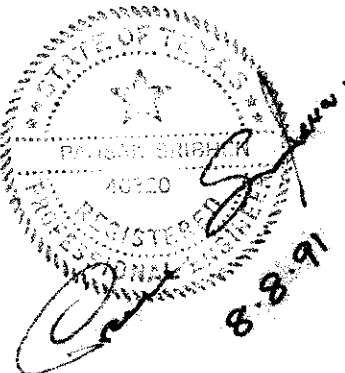
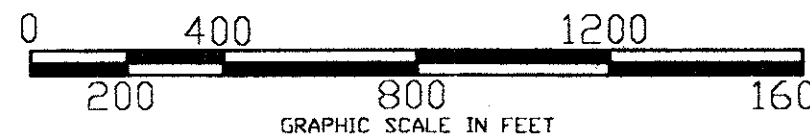


LEGEND

- WATER LINES ————
- SANITARY SEWER LINES - - - - -
- LONE STAR GAS LINES - - - - -
- CABLE TV LINES ······

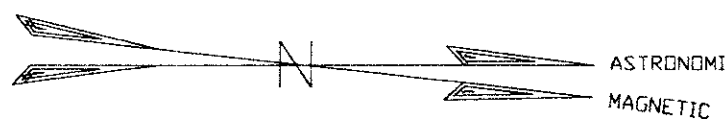

DESIGN: <i>R.C.R.</i>	A.I.P. NO.: 3-48-0063-03-91			
DRAWN: <i>M.J.C.</i>	S.P. NO.:			
CHECKED: <i>D.W.P.</i>	JOB NO.: Y8024.22	Date	Revisions	By
SCALE: AS NOTED				

Greiner
Greiner, Inc.
Fort Worth, Texas

Engineers, Architects
and Planners



ADDISON AIRPORT

**DRAINAGE IMPROVEMENTS
UTILITY PLAN**