

Index of Drawings

Sheet No.	Description of Drawing
VOLUME I	
C1	COVER SHEET
C2-C6D	ESTIMATE & QUANTITY SHEET
C7-C8	GEOMETRIC LAYOUT
C9-C13	TYPICAL SECTIONS
C14-C15	DEMOLITION PLAN
C16-C17	TRAFFIC CONTROL PLAN
C18-C25	ROADWAY - PLAN AND PROFILE
C26	INTERSECTION LAYOUT/GRADING - MIDWAY ROAD
C27	INTERSECTION LAYOUT/GRADING - ADDISON ROAD
C27A-C27B	CONTINUOUS REINFORCED CONCRETE PAVEMENT DETAILS
C28	CONNECTION ROAD - DOOLEY ROAD
C29-C31	RIGHT OF WAY PLAN
C32-C35	UTILITY COMPOSITE
C35A-C38B	UTILITY RELOCATION PLANS
C39	DRAINAGE AREA MAP/DRAINAGE CALCULATIONS
C40-C49	STORM SEWER PLANS
C50-C50A	EAST ENTRANCE JUNCTION BOX DETAILS
C51-C60	CROSS SECTIONS
C61-C63	TEMPORARY EROSION SEDIMENT AND WATER POLLUTION CONTROL PLAN
VOLUME II	
S64	COVER SHEET
S65	ABBREVIATIONS, SYMBOLS AND GENERAL NOTES
S66-S79	STRUCTURAL PLAN AND PROFILE
S80	RETAINING WALL PANEL DIAGRAMS & JOINT SCHEDULE
S81-S92	RETAINING WALL DETAILS
S93	RETAINING WALL BACKFILL AND DRAINAGE DETAILS
S94-S96	RETAINING WALL ARCHITECTURAL ELEVATIONS
S97-S103	PORTAL DRAINAGE SUMPS SECTIONS AND DETAILS
T104	TYPICAL TUNNEL SECTIONS
T105-T108	TEMPORARY TUNNEL SUPPORT
T108A	SUPPLEMENTARY SUPPORT 60" DIA. STORM SEWER
T109-T119	CUT AND COVER SECTIONS AND DETAILS
T120-T124	TUNNEL DRAINAGE SUMP SECTION AND DETAILS
T125	NICHE DETAILS
T126-T127A	WATERPROOFING DRAINAGE
T128	HANDRAIL DETAILS
T129-T131	PORTAL STRUCTURES SECTIONS AND DETAILS
T132-T134	SURFACE AND GEOTECHNICAL INSTRUMENTATION
VOLUME III	
M135	COVER SHEET
M136	ABBREVIATIONS, SYMBOLS AND GENERAL NOTES
M137-M143	TUNNEL VENTILATION PLANS
P144-P146	TUNNEL FIRE PROTECTION AND PLUMBING PLANS
P147-P148	ENLARGED SUMP PIT PLANS
P149	PUMP DISCHARGE PIPING EAST ENTRANCE
P150	TUNNEL FIRE PROTECTION & PLUMBING SECTIONS
P151	TUNNEL GENERATOR & FIRE PROTECTION
P152	TUNNEL FIRE PROTECTION AND PLUMBING SCHEDULE
E153	ABBREVIATIONS, SYMBOLS AND GENERAL NOTES
E154-E156	TUNNEL LIGHTING PLANS
E157-E159	TUNNEL POWER AND COMMUNICATIONS PLANS
E160	PARTIAL PLANS
E161	ONE-LINE DIAGRAM & SCHEDULES
E162-E163	PANELBOARD SCHEDULES
E164-E166A	PARTIAL PLANS/DETAILS

TEXAS TURNPIKE AUTHORITY

CONTRACT No. DNT-260

MECHANICAL, ELECTRICAL AND PLUMBING PLANS


SECTION X III
VOLUME III

ADDISON AIRPORT TUNNEL

Standard Drawings


DNT Dwg. No.	Description of Standard
VOLUME I	
2	CURB AND GUTTER INLET - TYPE I (2 SHEETS)
5	INLET DETAILS - TYPE F
6	INLET DETAILS - TYPE G
8	MANHOLE DETAILS - TYPE I AND TYPE II
10	TOLLWAY PAVEMENT DETAILS (2 SHEETS)
11	MISCELLANEOUS DETAILS - TOLLWAY
12	MISCELLANEOUS PAVING DETAILS (3 SHEETS)
13	MISCELLANEOUS DRAINAGE DETAILS
14	METAL BEAM GUARD FENCE (2 SHEETS)
15	PRECAST CONC. BOX CULVERTS FOR NORMAL FILL SECTIONS
20-26	BARRICADE AND CONSTRUCTION STANDARDS (7 SHEETS)
27	CONCRETE BARRIER RAIL - PORTABLE AND PRECAST
28	BARREL MOUNTED GUARD FENCE
30	CHAIN - LINK BARRIER FENCE 4 AND 6 FOOT GATE DETAILS
30A	STANDARD FENCE DETAILS
31	METAL BEAM GUARD FENCE FIXED OBJECT ATTACHMENT
95	TECHWALL STANDARD DETAILS (2 SHEETS)

TxDOT Dwg. No.	Description of Standard
CPCR(1)-94	CONCRETE PAVEMENT DETAILS CONTINUOUSLY REINFORCED.
CH-11	CONCRETE HEADWALLS FOR PIPE CULVERTS 12"-72" DIA.
CH-11-B-30 DEG.	CONCRETE HEADWALLS FOR PIPE CULVERTS 12"-72" DIA.
CH-11-B-45 DEG.	CONCRETE HEADWALLS FOR PIPE CULVERTS 12"-72" DIA.
MC5-1	MULTIPLE BOX CULVERTS SIZES 5'x2', 5'x3', 5'x4', 5'x5' DIRECT TRAFFIC TO 4'-0" FILL

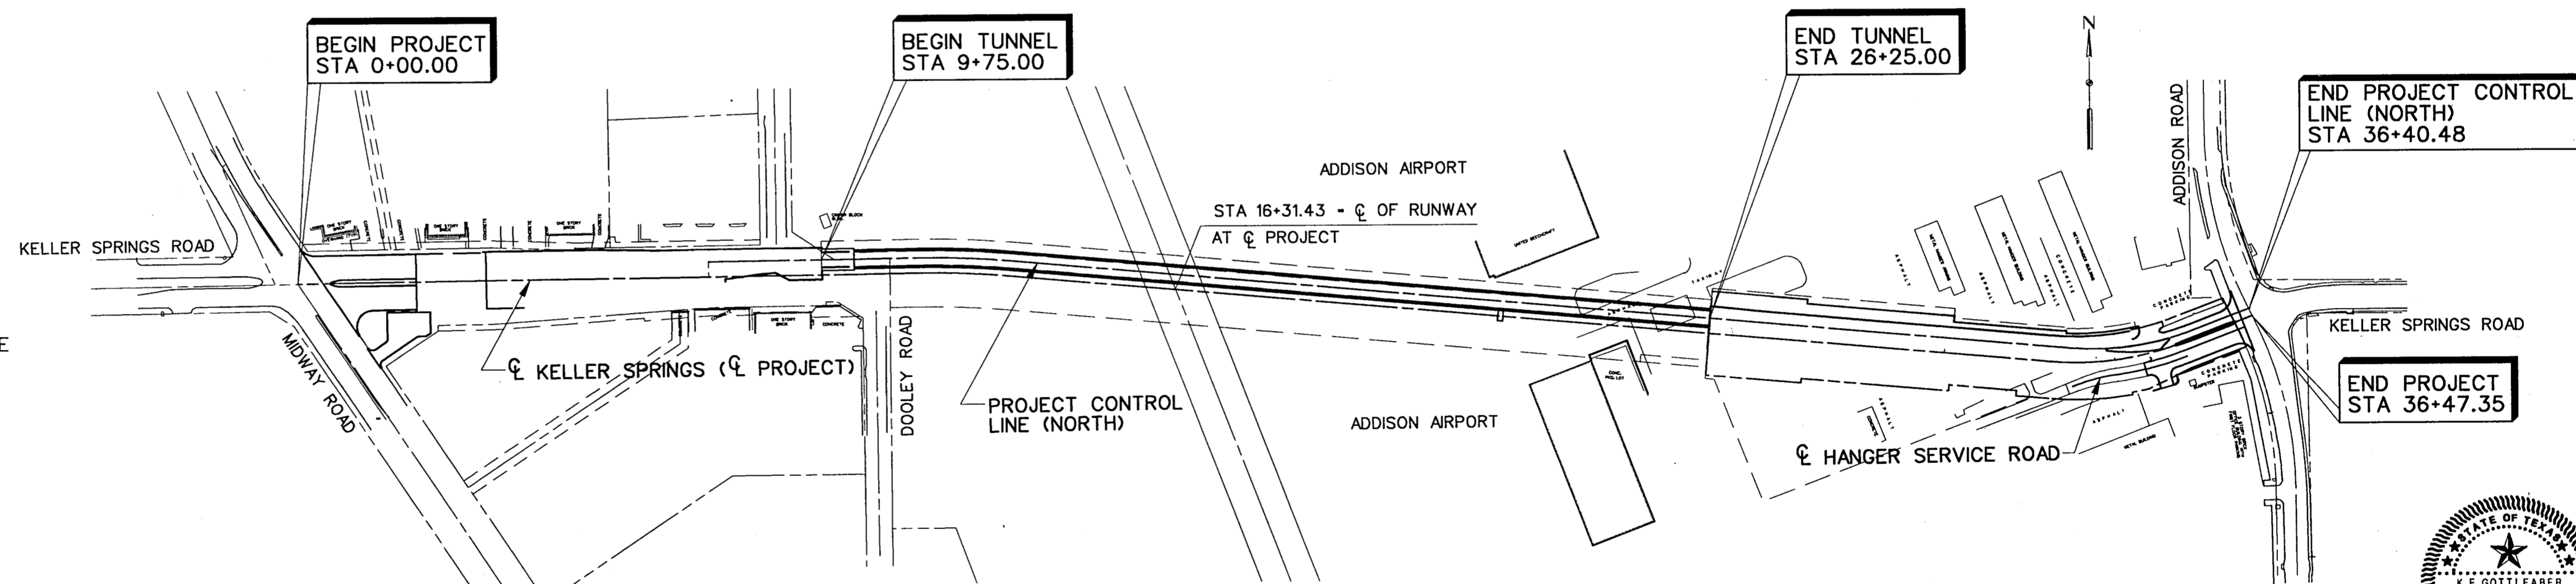

PROJECT LAYOUT
SCALE: 1" = 200'

FINAL RECORD DRAWING
Date: 12/25/99

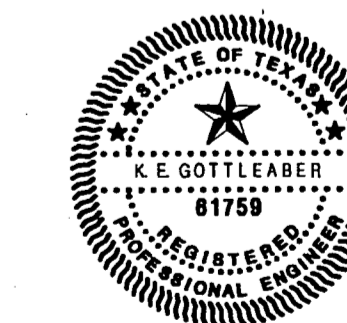

THE SEAL APPEARING ON THIS DOCUMENT WAS AUTHORIZED BY K. E. GOTTLER, P.E. 61759 ON SEPTEMBER 9, 1996.

Prepared by:
HDR ENGINEERING, INC.

William R. Maguire, P.E.
Design Engineer

Date: January 19, 1997

Recommended by:
HNTB CORPORATION

[Signature]
Consulting Engineer

Date: 01/10/97

Recommended by:
THE GINN CORPORATION

[Signature]
Project Engineer

Date: 1/10/97

Approved by:
TOWN OF ADDISON

City Manager

Date: _____

Approved by:
COUNTY OF DALLAS, TEXAS

Director of Public Works

Date: _____

Recommended by:
TEXAS TURNPIKE AUTHORITY

Director of Engineering

Date: _____

Approved by:
TEXAS TURNPIKE AUTHORITY

Executive Director

Date: Jan. 16, 1997